


LIGHT FIXTURE LEGEND

LIGHT FIXTURE A

KIM LIGHTING - WD18D3-250HPS OR EQUAL
 250 WATT, HIGH PRESSURE SODIUM
 WALL MOUNTED - MOUNTING HEIGHT = 12FT


NOTES:

- * PHOTOMETRIC DATA GENERATED UTILIZING DESIGN MASTER SOFTWARE
- * GRID SPACING = 10' X 10'
- * LIGHT LOSS FACTOR = 0.81 (HIGH PRESSURE SODIUM)
- * LIGHT LEVELS ARE NOT ADJUSTED FOR ELEVATION DIFFERENCES OR BUFFER VEGETATION
- * PHOTOMETRIC IES FILES OBTAINED FROM FIXTURE MANUFACTURERS
- * EXISTING ONSITE LIGHTING NOT MODELLED.

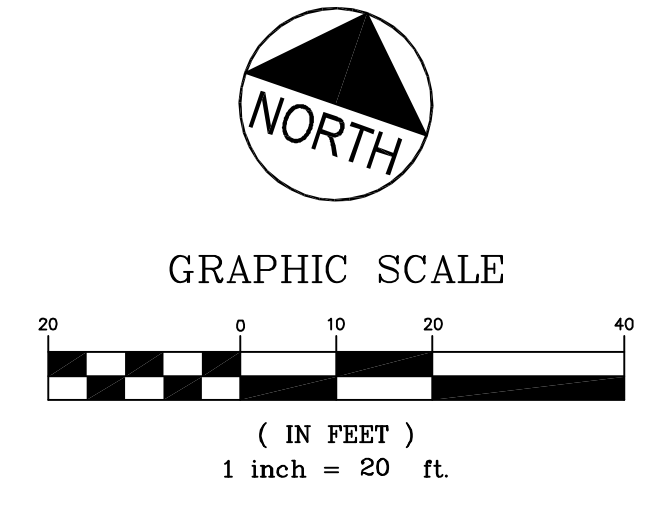

REV	DATE	DESCRIPTION
3	06.13.13	RELEASED FOR BID
2	06.03.13	LEVEL II SITE PLAN SUBMISSION
1	05.22.13	DESIGN DEVELOPMENT

REVISIONS

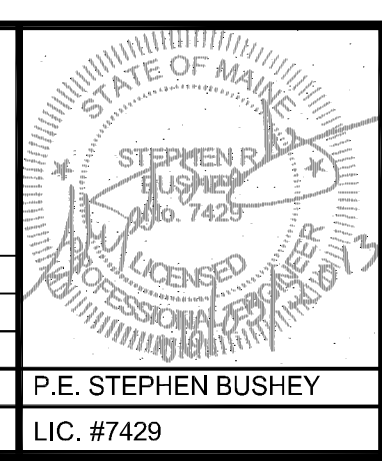

PROJECT
EYECARE MEDICAL GROUP PHASE 2 - ADDITION & RENOVATION

SHEET TITLE
LIGHTING PLAN

CLIENT
PDT ARCHITECTS

DRAWN: CMW DATE: MAY 2013
 DESIGNED: RJW SCALE: 1" = 20'
 CHECKED: SRB JOB NO. 3165
 FILE NAME: 3165-SP
 SHEET **C-5.0**

DeLUCA-HOFFMAN ASSOCIATES, INC.
 778 MAIN STREET, SUITE 8
 SOUTH PORTLAND, ME 04106
 207.775.1121
 WWW.DELUCAHOFFMAN.COM