

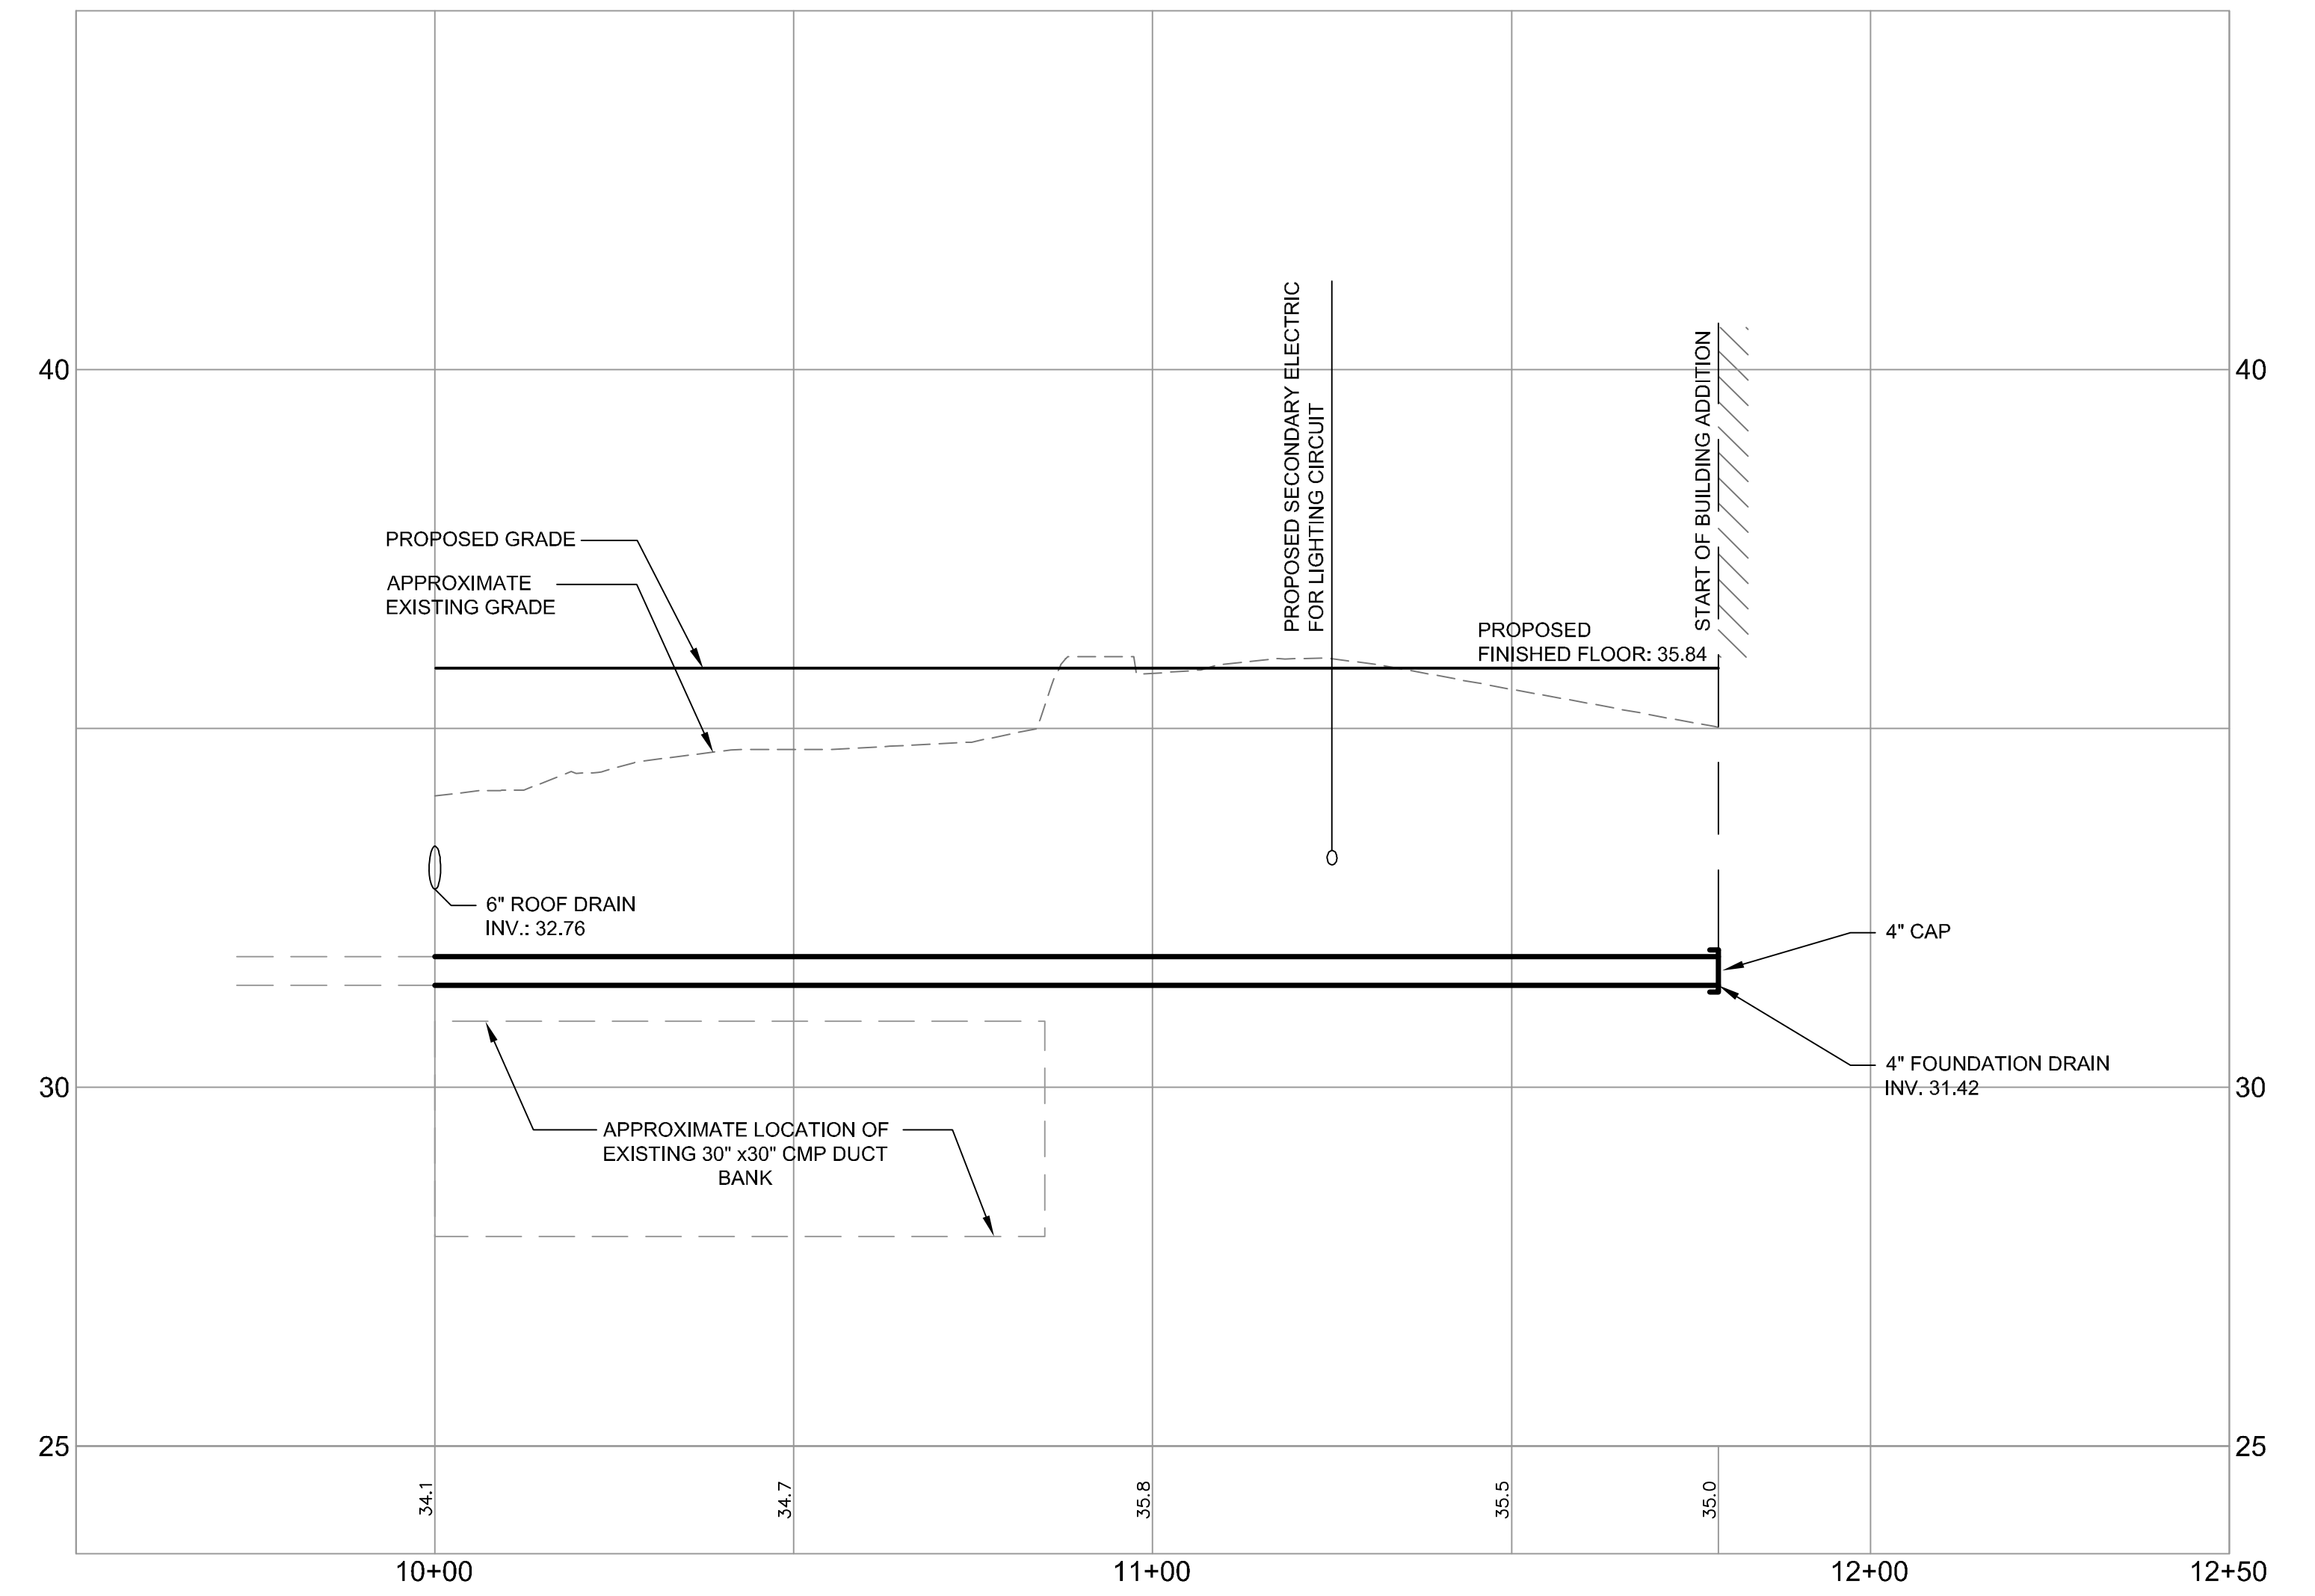



8" AND 6" STORM DRAIN PROFILE
 1" = 20' HORIZ.
 1" = 2' VERT.

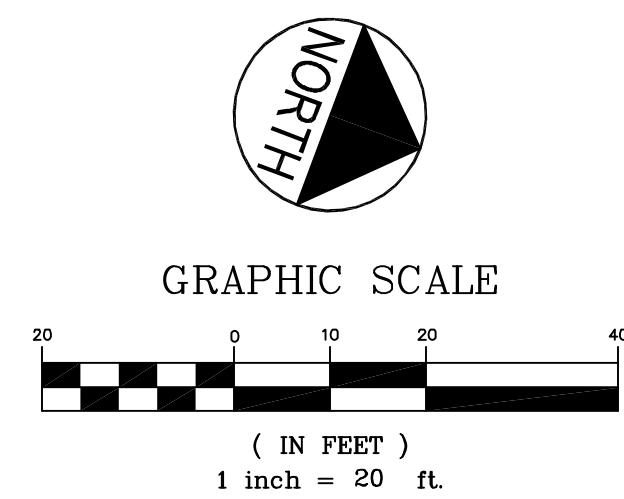

4" FOUNDATION DRAIN PROFILE
 1" = 20' HORIZ.
 1" = 2' VERT.

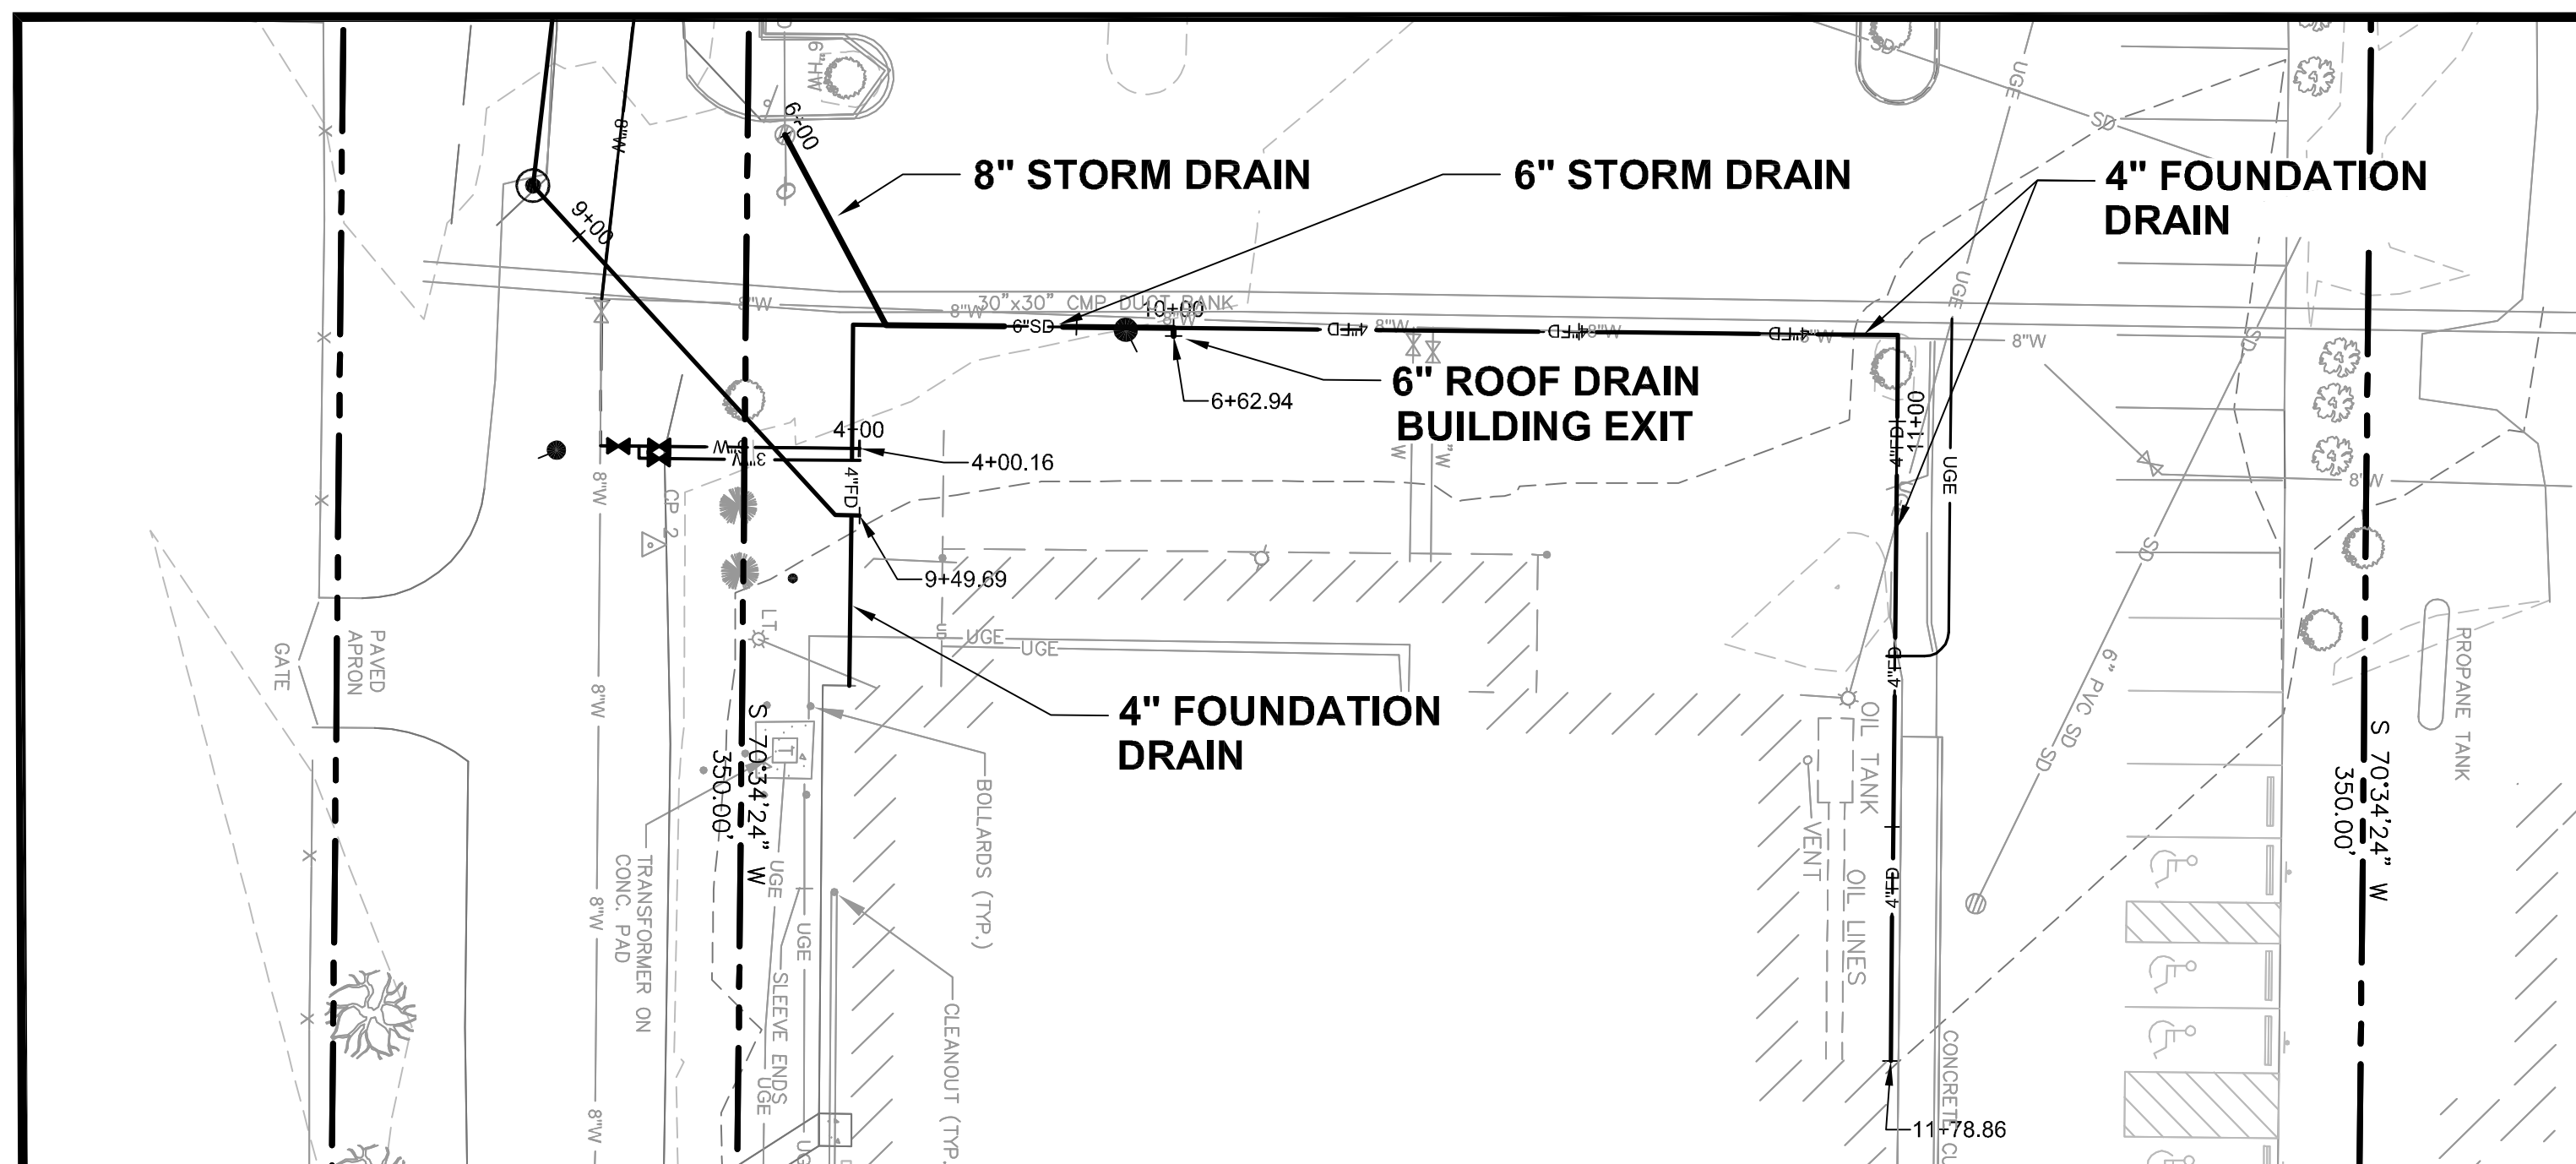

REV	DATE	DESCRIPTION	DESIGNED	CHECKED	DATE
3	06.13.13	RELEASED FOR BID			
2	06.03.13	LEVEL II SITE PLAN SUBMISSION			
1	05.22.13	DESIGN DEVELOPMENT			

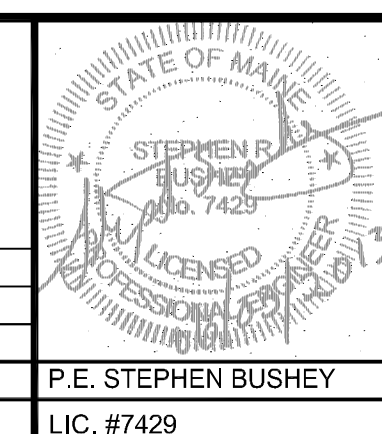

PROJECT
EYECARE MEDICAL GROUP PHASE 2 - ADDITION & RENOVATION

SHEET TITLE
DRAINAGE PROFILES

CLIENT
PDT ARCHITECTS

DeLUCA-HOFFMAN ASSOCIATES, INC.
 778 MAIN STREET, SUITE 8
 SOUTH PORTLAND, ME 04106
 207.775.1121
 WWW.DELUCAHOFFMAN.COM

DRAWN: PBF DATE: JUNE 2013
 DESIGNED: RJW SCALE: 1" = 20'
 CHECKED: SRB JOB NO. 3165
 FILE NAME: 3165-UTIL PROFILES
 SHEET **C-7.0**