


N:\Projects\2012\12064 - Eyecare Medical Group-Addition and Renovation\00 Drawing Files\12064\_M.rvt  
8/8/2013 6:44:44 PM

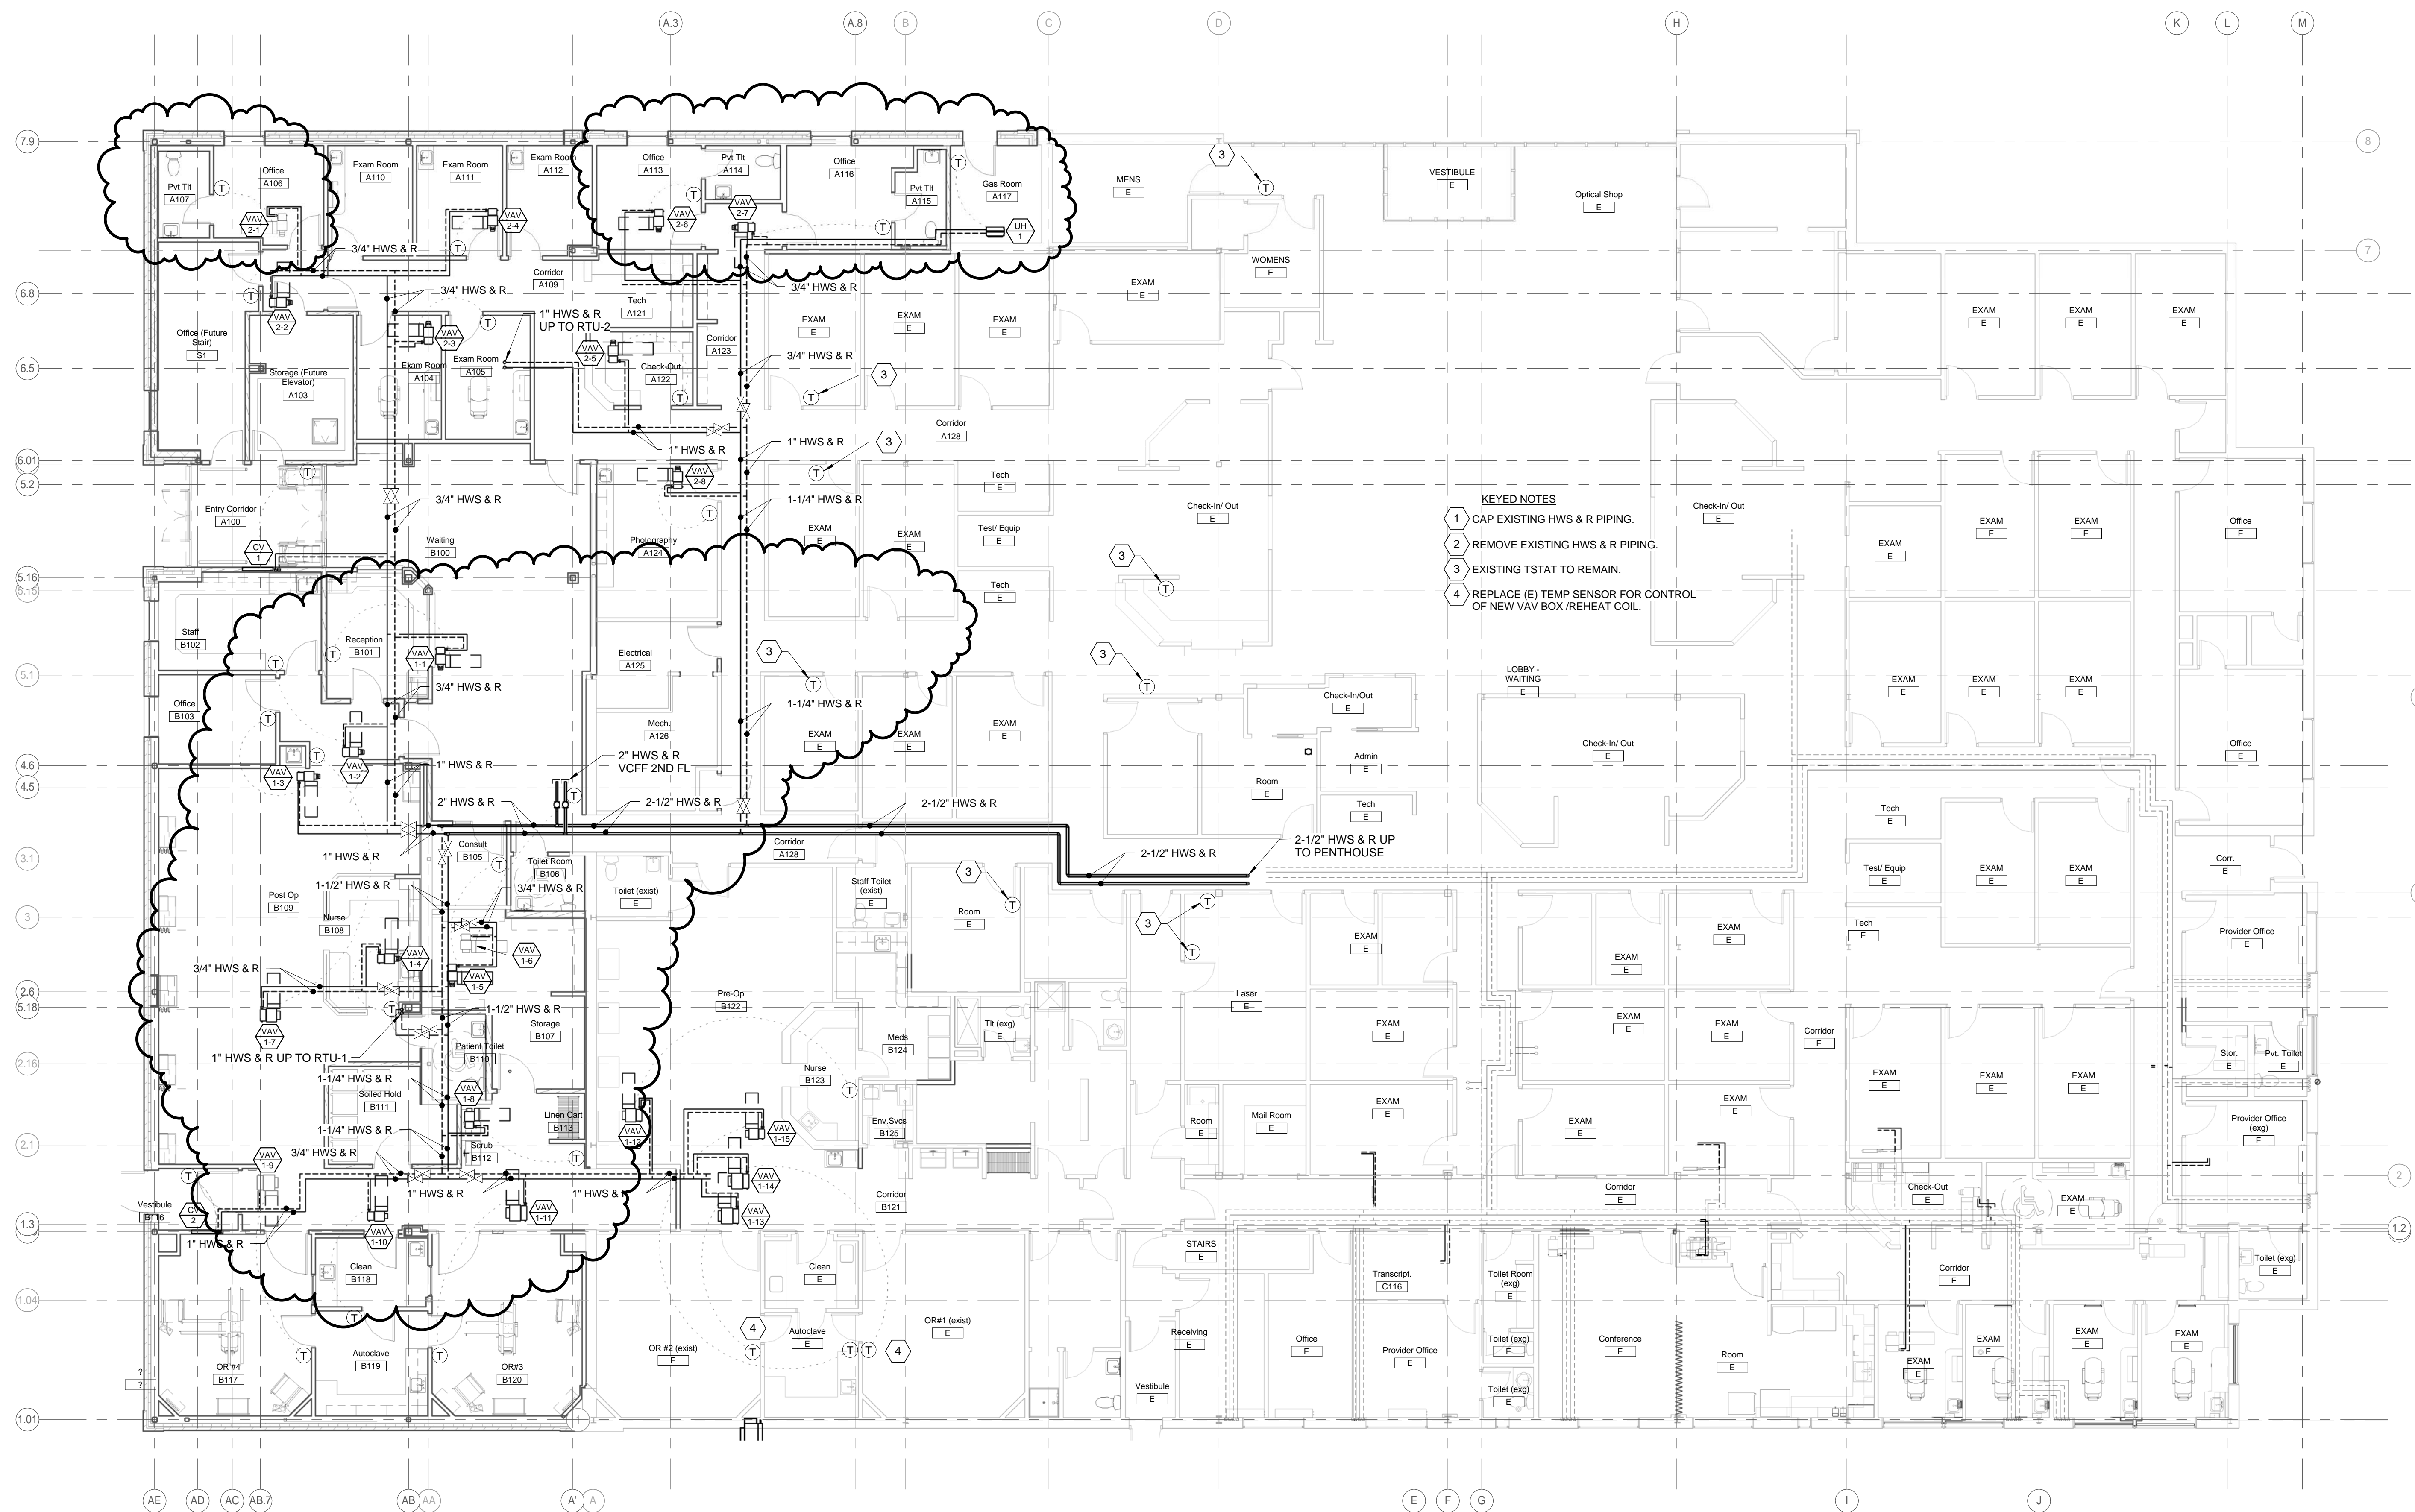

**KEYED NOTES**


- 1 CAP EXISTING HWS & R PIPING.
- 2 REMOVE EXISTING HWS & R PIPING.
- 3 EXISTING TSTAT TO REMAIN.
- 4 REPLACE (E) TEMP SENSOR FOR CONTROL OF NEW VAV BOX /REHEAT COIL.



ALLIED PROJECT No.:  
12064  
CAD FILE:

COPYRIGHT 2012  
PDT Architects  
Reuse or reproduction of the  
contents of this document is not  
permitted without written  
permission of PDT Architects.

**E.M.G. - PHASE 2 ADDITION & RENOVATION**  
53 Sewall Street, Portland, ME 04102

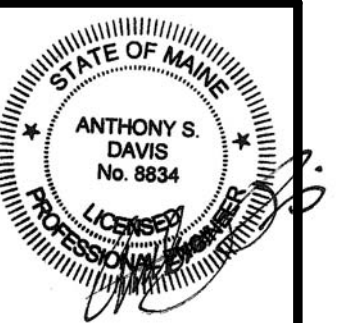

PDT JOB NO.  
12084

DRWN. CHK  
Checker

SCALE:  
1/8" = 1'-0"

ISSUE:  
JULY 11, 2013

TITLE  
MECHANICAL PIPING PLAN -  
PHASE 2

SHEET  
**MP100**

A1 MECHANICAL PIPING PLAN - PHASE 2  
1/8" = 1'-0"

No.	DATE	DESCRIPTION
5	08-08-2013	ADDENDUM-5

REVISION SCHEDULE