


N:\Projects\2012\12064 - Eyecare Medical Group-Addition and Renovation\00 Drawing Files\12064_M.rvt
8/8/2013 6:45:04 PM

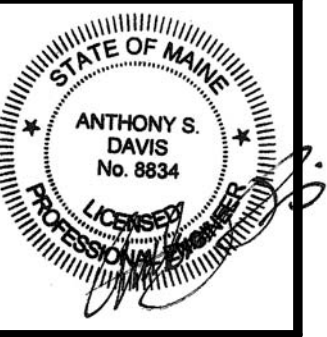

PDT JOB NO.
12084



DRWN. CHK
Checker

SCALE:
1/8" = 1'-0"

ISSUE:
JULY 11, 2013

TITLE
PLUMBING
DOMESTIC
PIPING PLAN -
PHASE 2

SHEET
PL102

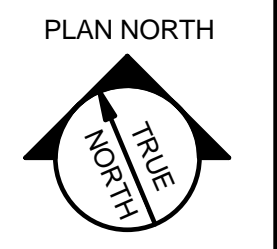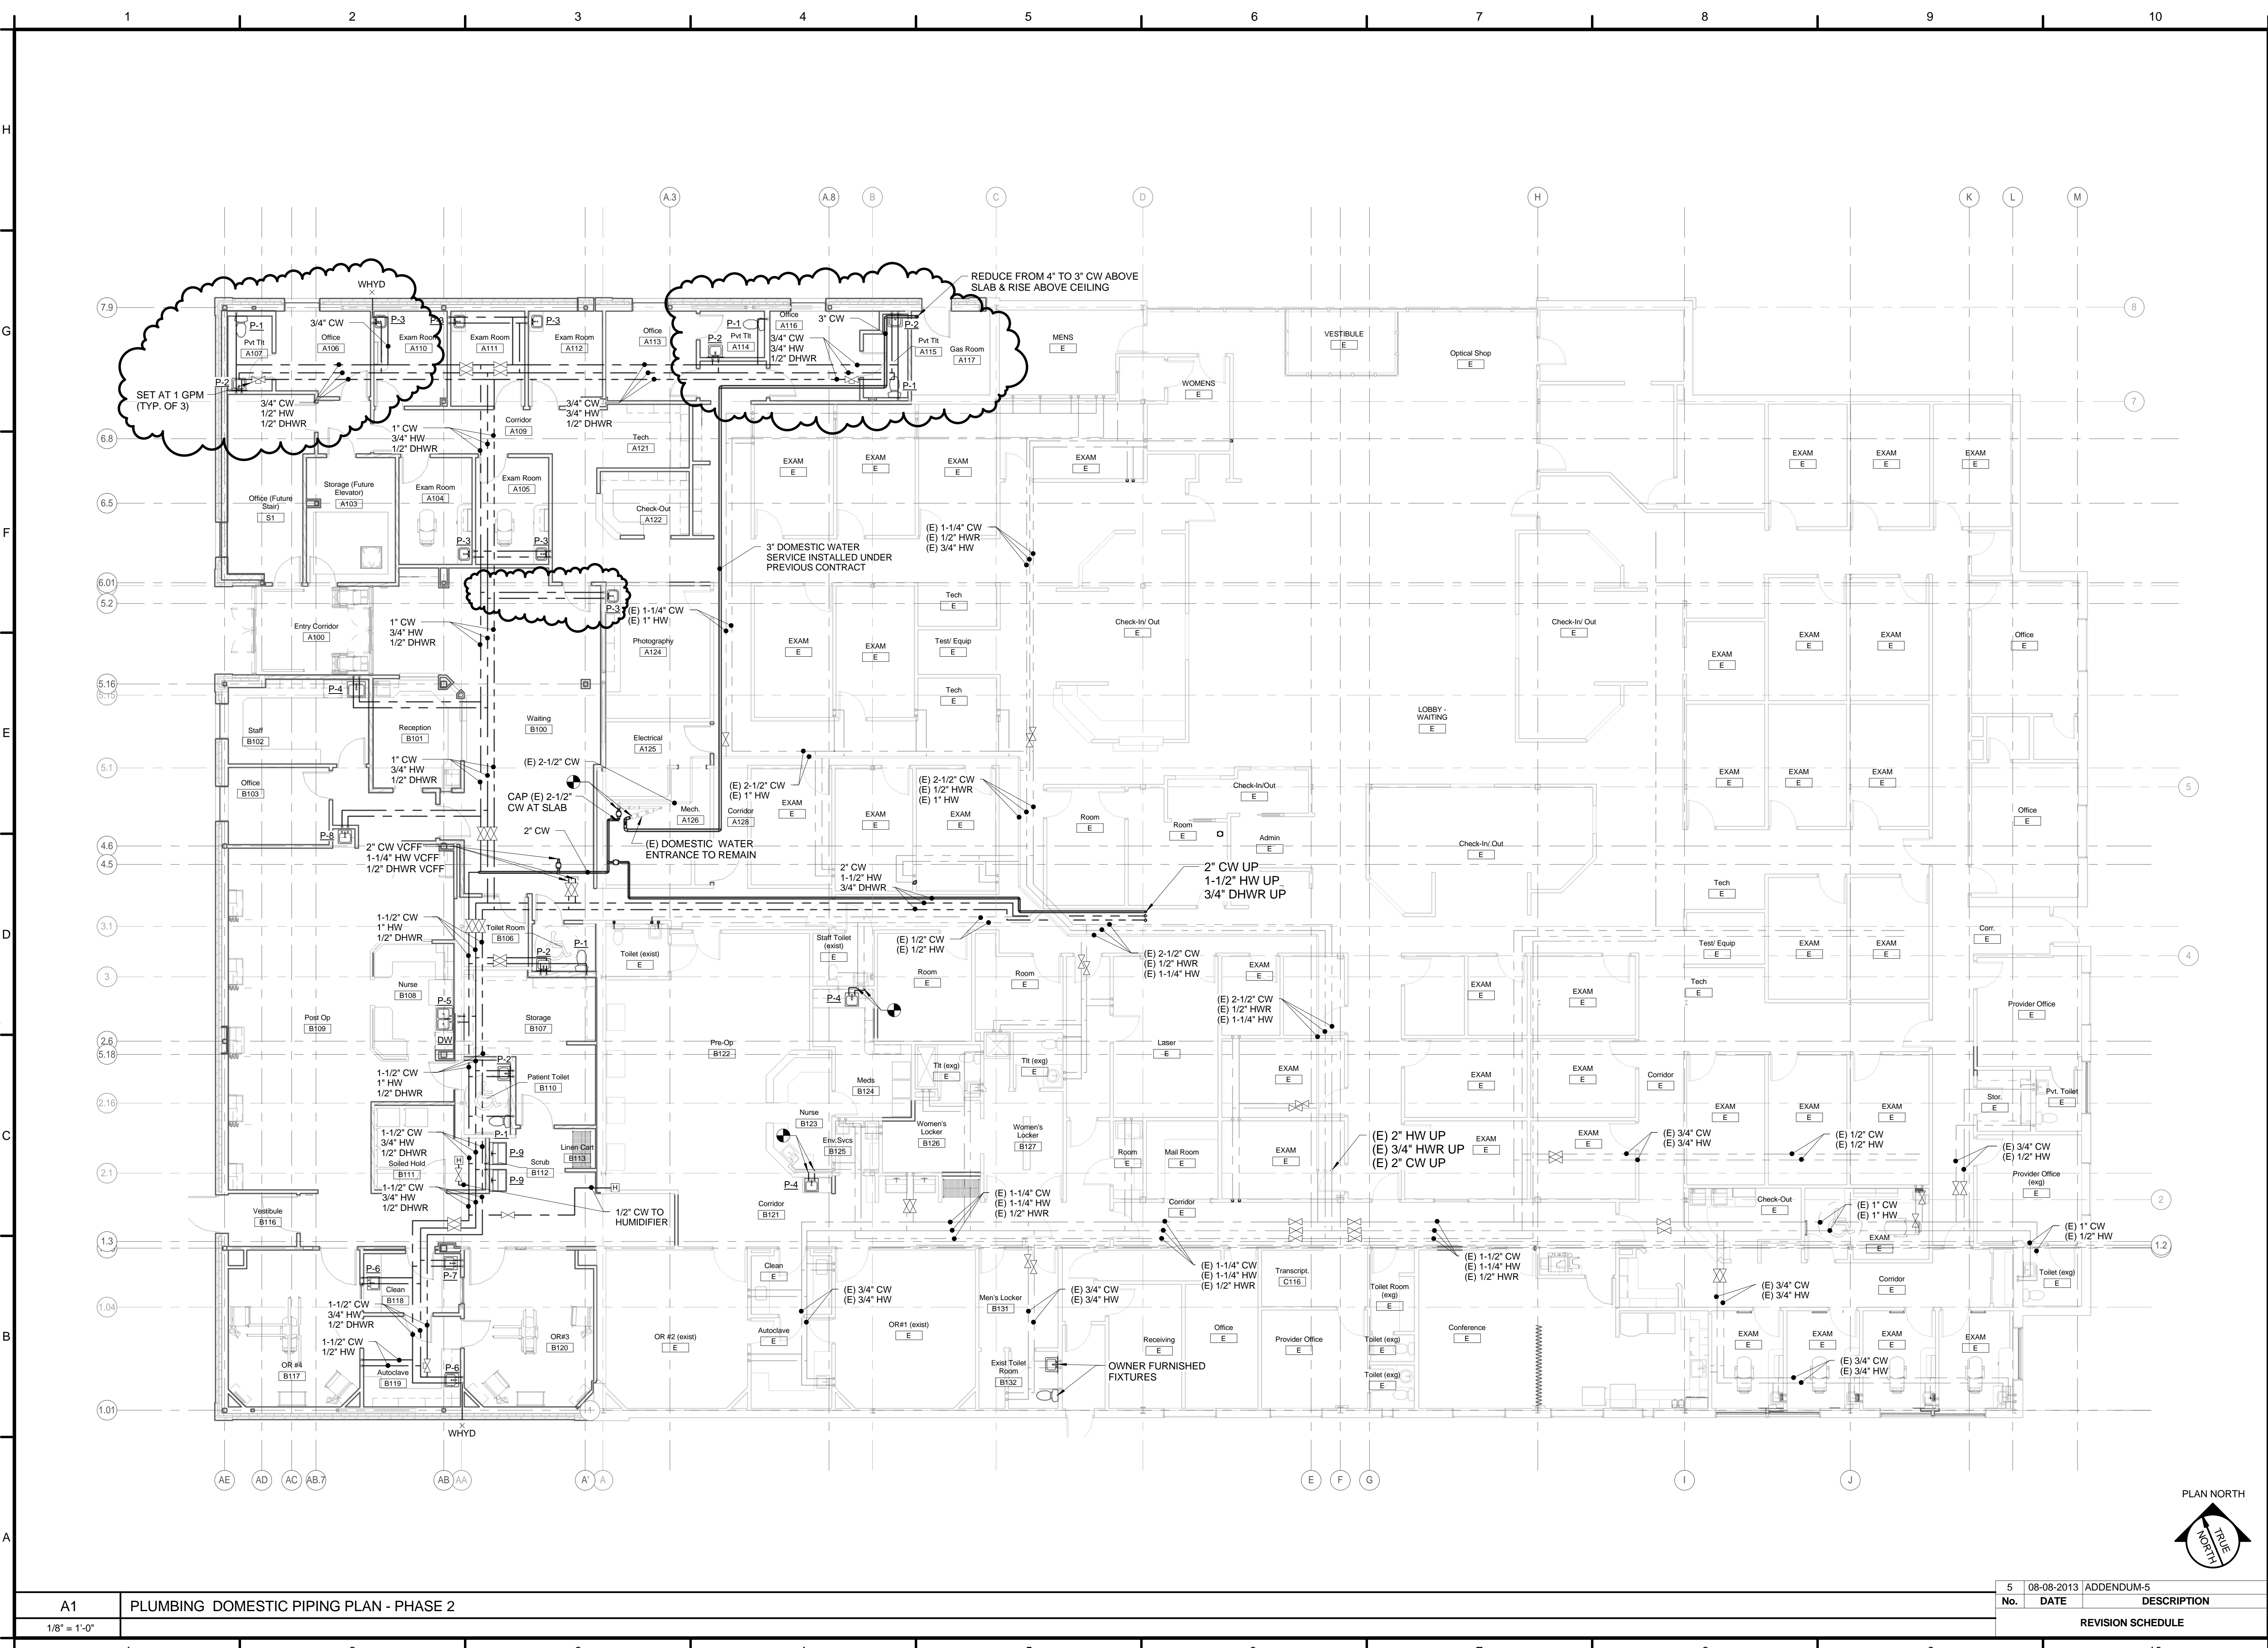

No.	DATE	DESCRIPTION
5	08-08-2013	ADDENDUM-5

REVISION SCHEDULE

A1 PLUMBING DOMESTIC PIPING PLAN - PHASE 2

1/8" = 1'-0"