


7/11/2013 5:54:25 PM N:\Projects\2012\12064 - Eyecare Medical Group-Addition and Renovation\00 Drawing Files\12064\_M.rvt



ALLIED PROJECT No.: 12064  
CAD FILE:

COPYRIGHT 2012  
PDT Architects  
Reuse or reproduction of the  
contents of this document is not  
permitted without written  
permission of PDT Architects.

E.M.G. - PHASE 2 ADDITION & RENOVATION  
53 Sewall Street, Portland, ME 04102

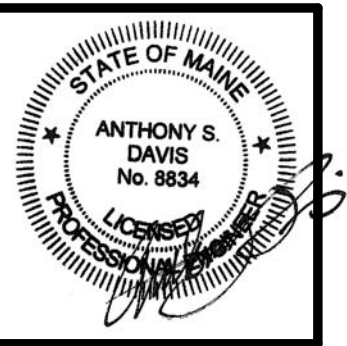

PDT JOB NO. 12084

DRWN. CHK  
Checker



SCALE:  
1/8" = 1'-0"

ISSUE:  
JULY 11, 2013

TITLE  
PLUMBING MED  
GAS PIPING PLAN  
- PHASE 2

SHEET

PL103

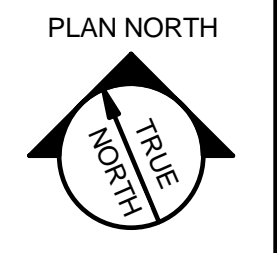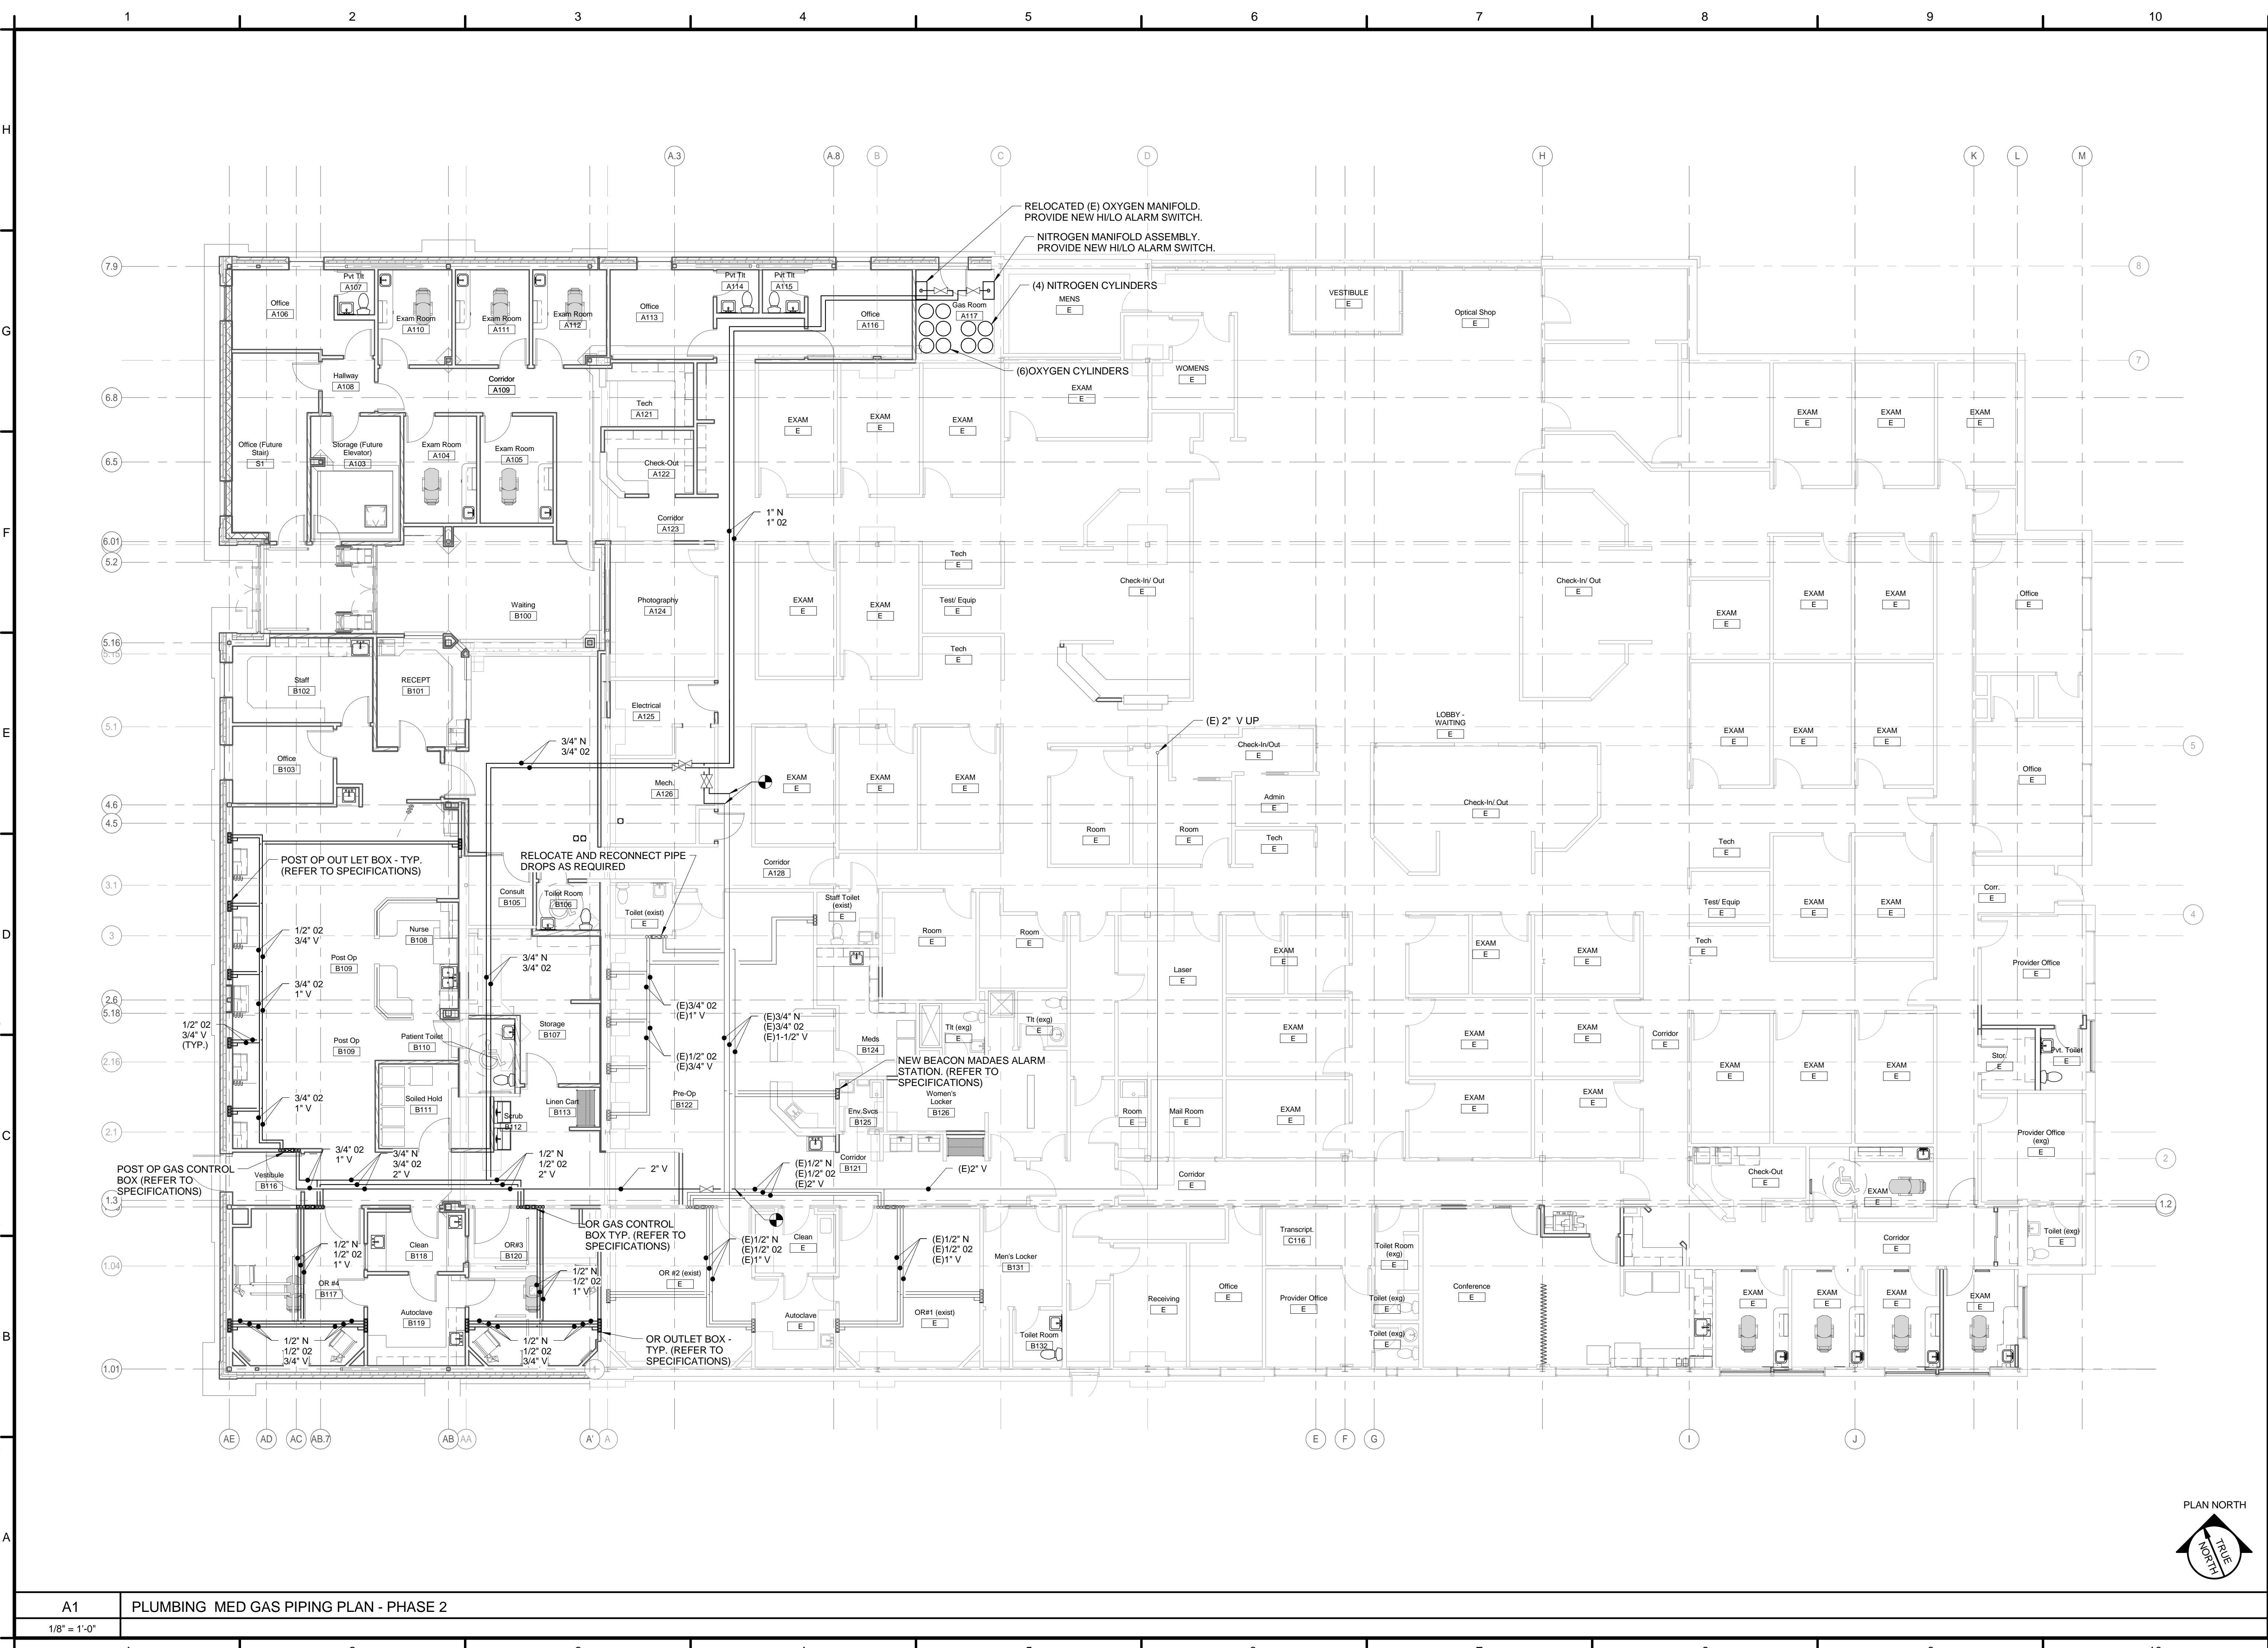

A1 PLUMBING MED GAS PIPING PLAN - PHASE 2  
1/8" = 1'-0"