


PRE-DEVELOPMENT DRAINAGE PLAN
SCALE = 1"=20'

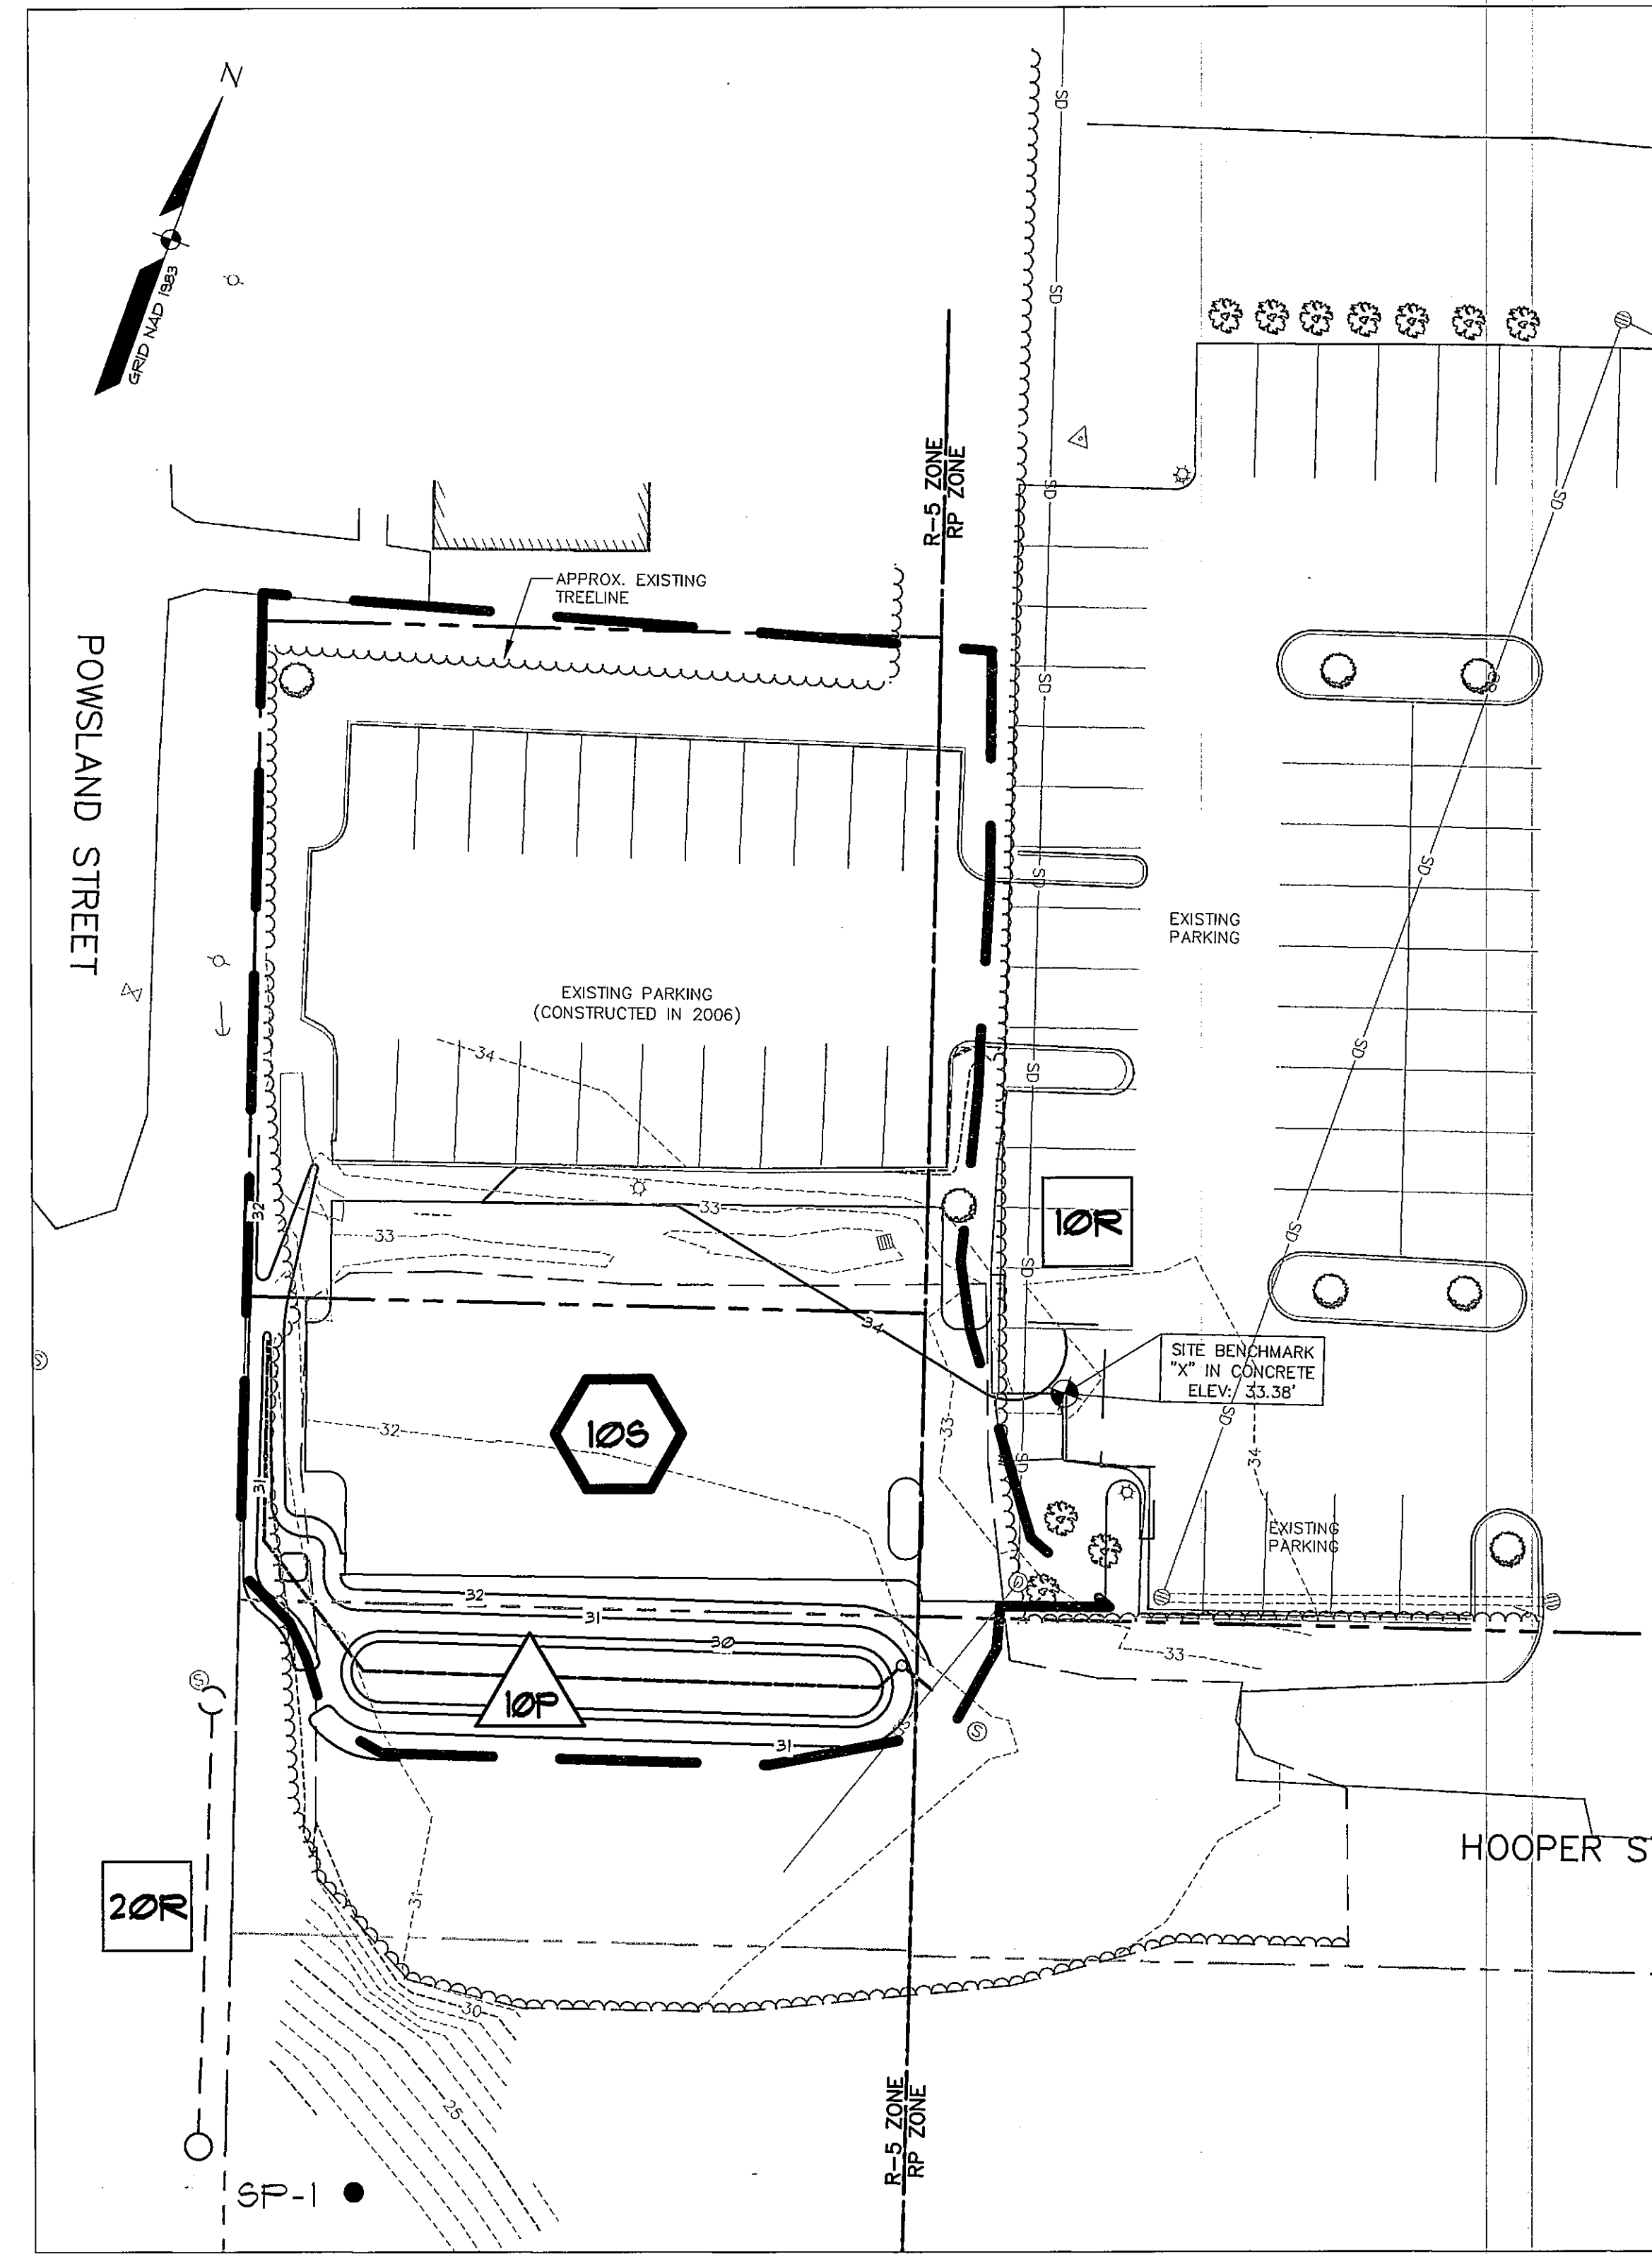



POST-DEVELOPMENT DRAINAGE PLAN
SCALE = 1"=20'

LEGEND

EXISTING	DESCRIPTION	PROPOSED	EXISTING	DESCRIPTION	PROPOSED
---	BOUNDARY LINE/ROIL	---	⊠	GATE VALVE	---
---	ABUTTER LINE/ROIL	---	⊙	SEWER MH	---
---	SETBACK	---	SD	STORM DRAIN	---
---	EASEMENT CENTERLINE	---	UD	UNDERDRAIN	---
---	MONUMENT	---	⊕	CATCH BASIN	---
---	IRON PIPE/ROD CURVILINE NO.	---	⊕	DRAINAGE MH	---
---	BENCHMARK	---	⊕	OVERHEAD ELEC. 4 TEL.	---
---	BUILDING	---	⊕	UNDERGROUND ELEC. 4 TEL.	---
---	EDGE PAVEMENT	---	⊕	LIGHT POLE/WALL	---
---	PAVEMENT PAINT	---	⊕	UTILITY POLE	---
---	CURBLINE	---	⊕	GUY	---
---	TREELINE	---	⊕		---
---	CONTOURS	---	⊕		---
---	SPOT GRADE	---	⊕		---
⊙	DECIDUOUS TREE	---	⊕		---
⊙	CONIFEROUS TREE	---	⊕		---

DRAINAGE LEGEND

---	WATERSHED BOUNDARY
---	TIME OF CONCENTRATION
⊕	REACH
⊕	REACH
⊕	WATERSHED LABEL
⊕	REACH
⊕	DETENTION POND
---	SOILS BOUNDARY
⊕	STUDY POINT

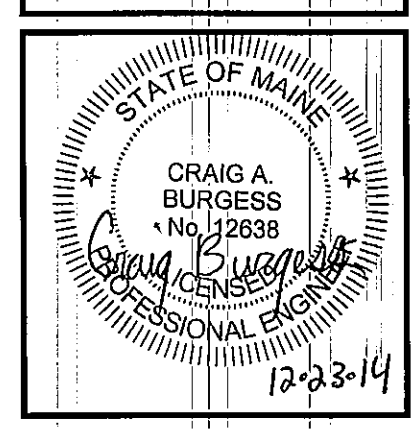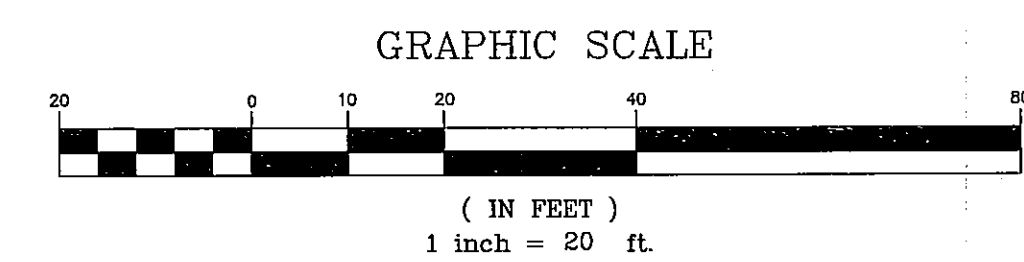

REV.	BY	DATE	REISSUED FOR CITY REVIEW & APPROVAL STATUS
A	CAB	12-23-14	

THIS PLAN SHALL NOT BE MODIFIED WITHOUT WRITTEN PERMISSION FROM SEBAGO TECHNICS, INC. ANY ALTERATIONS, AUTHORIZED OR OTHERWISE, SHALL BE AT THE USER'S SOLE RISK AND WITHOUT LIABILITY TO SEBAGO TECHNICS, INC.

SEBAGO TECHNICS
 WWW.SEBOGOTECHNICS.COM
 75 John Roberts Rd., Suite 1A
 Portland, ME 04106
 Phone: 207-200-2100
 Fax: 207-783-5655

PROJECT NO. FIELD BOOK DESIGN CHD DRAWN
 06267 ELECTRONIC CAB ACH CAB

DRAINAGE PLAN
 OF: **PARKING LOT EXPANSION**
 53 SEWALL STREET
 PORTLAND, MAINE 04102
 FOR: **EYE VENTURE ASSOCIATES, LLC**
 62 SEWALL STREET
 PORTLAND, MAINE 04102

DATE: 12-19-14 SCALE: 1"=20'

SHEET 5 OF 5

06267SWP.dwg TAB: SWP