



HARRIMAN



AUBURN PORTLAND MANCHESTER

JEWISH COMMUNITY ALLIANCE OF SOUTHERN MAINE

PORTLAND, ME


Harriman Project No. 15309

Key Plan

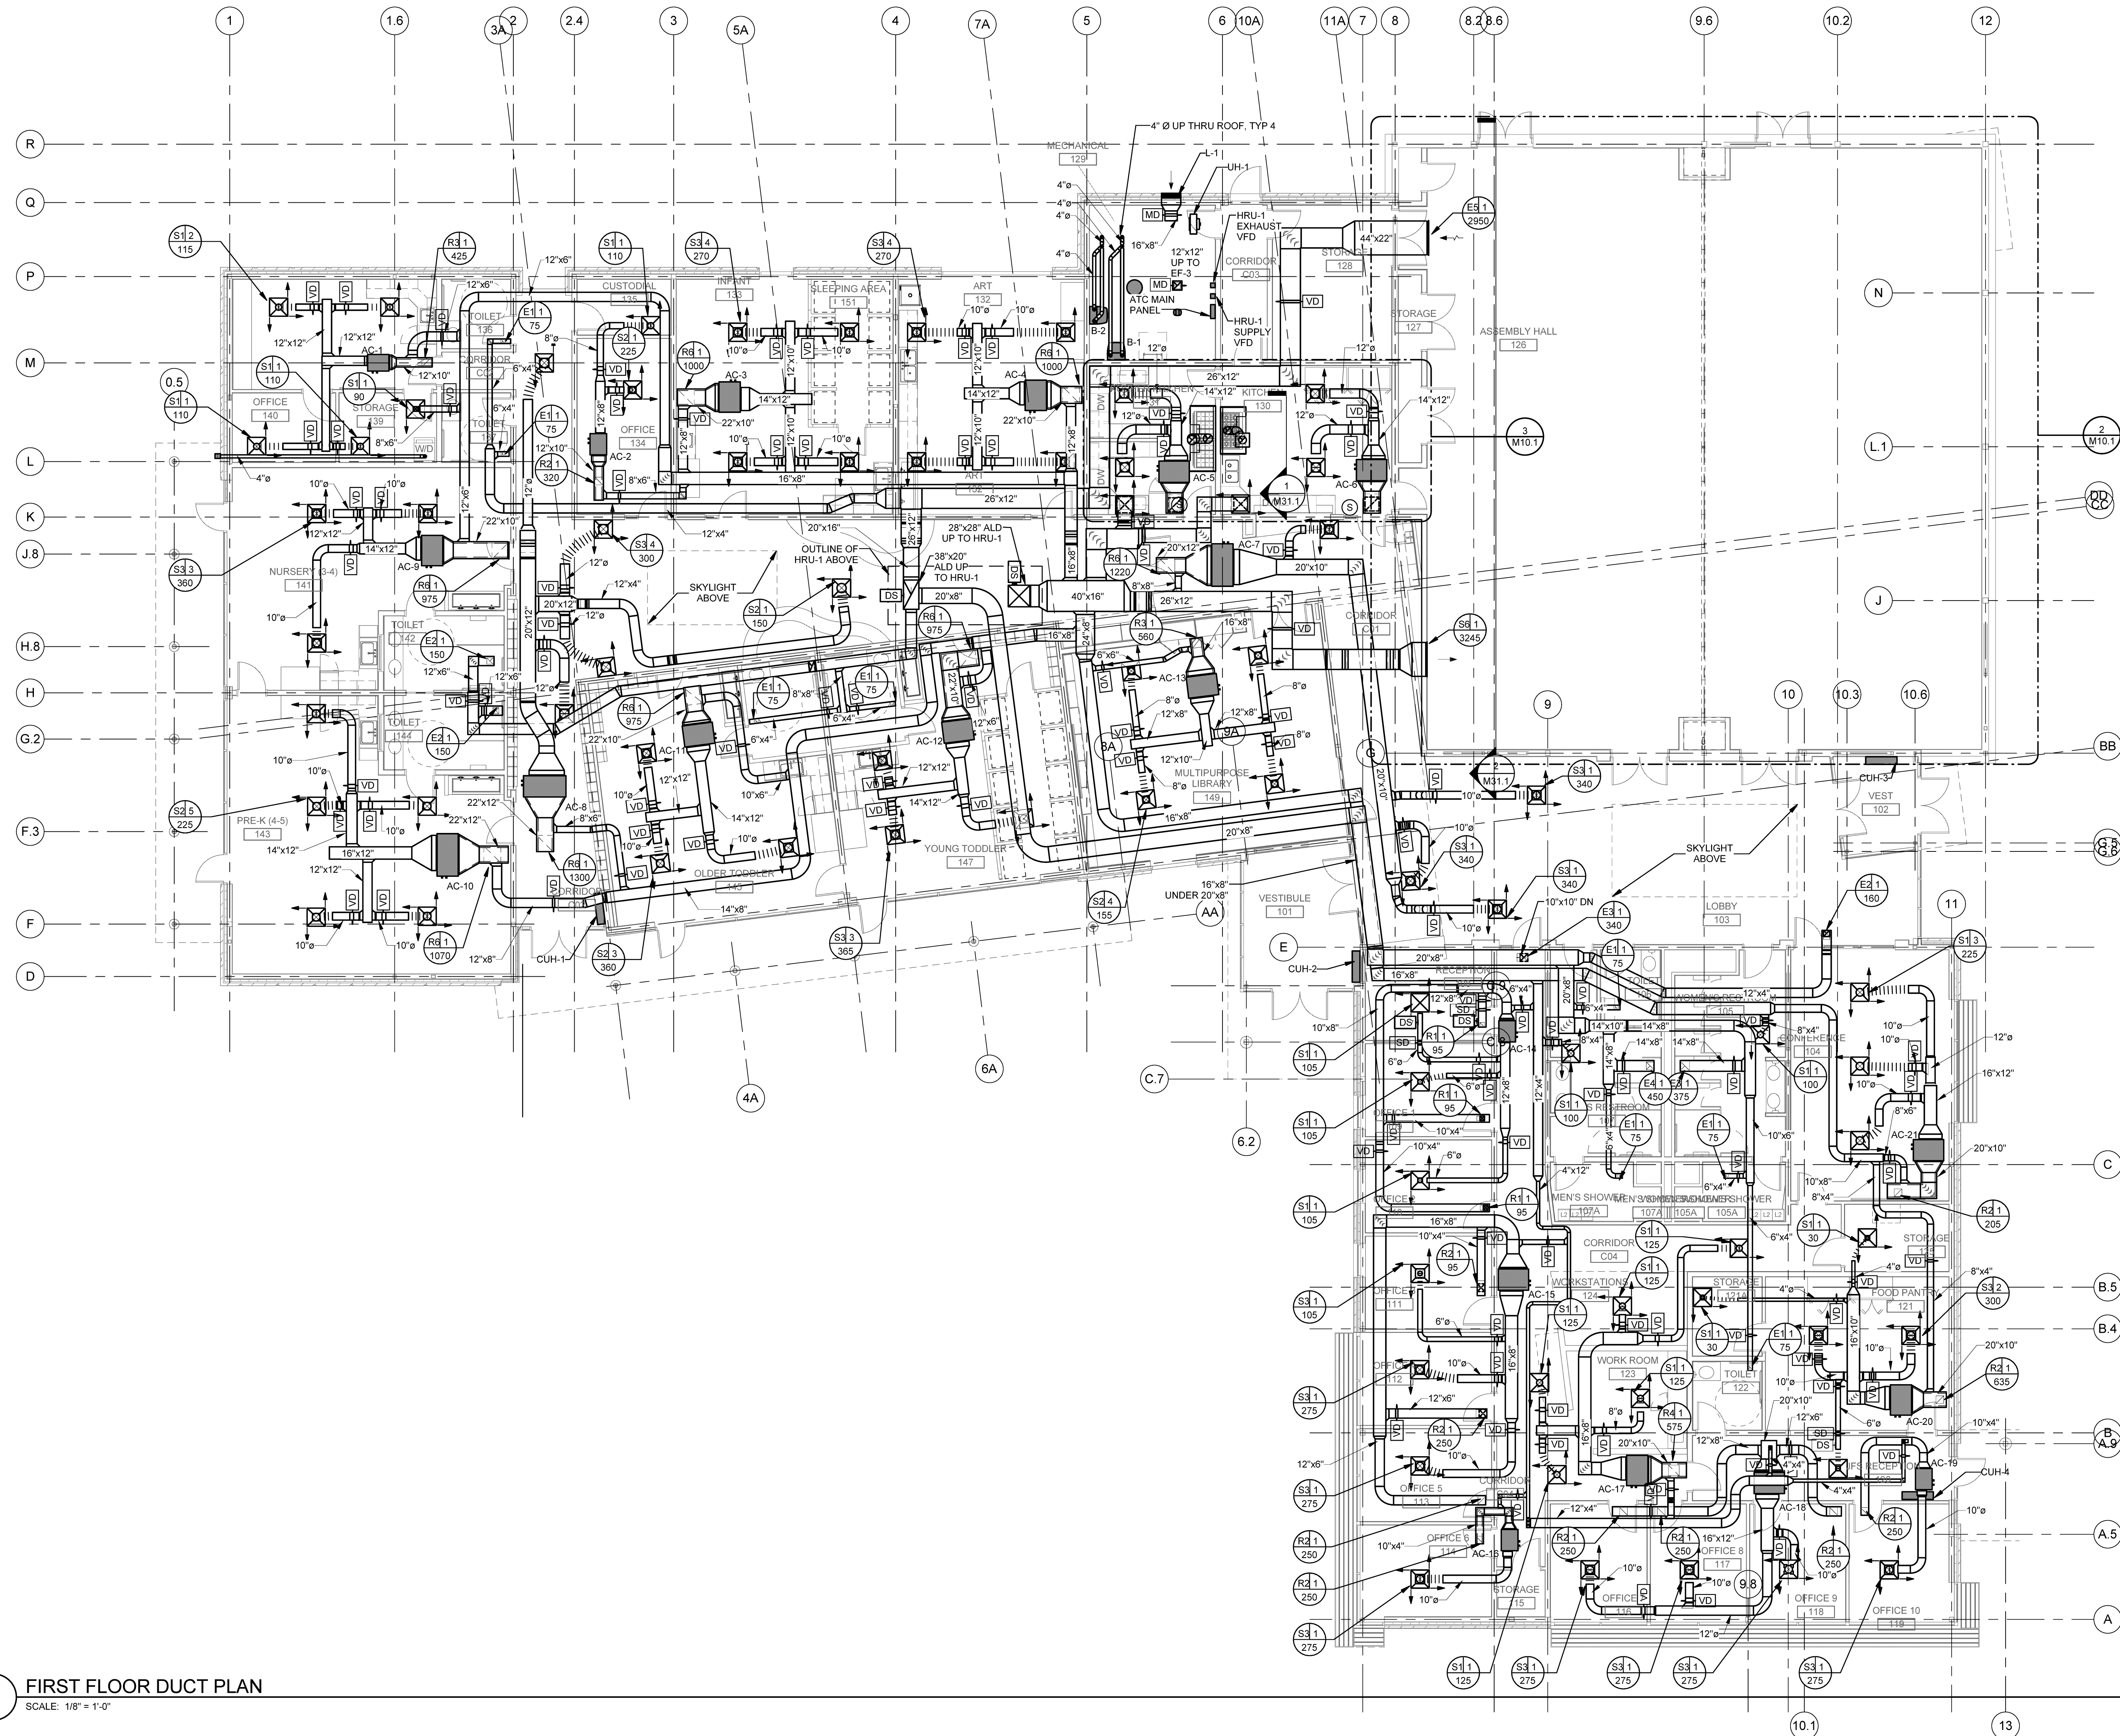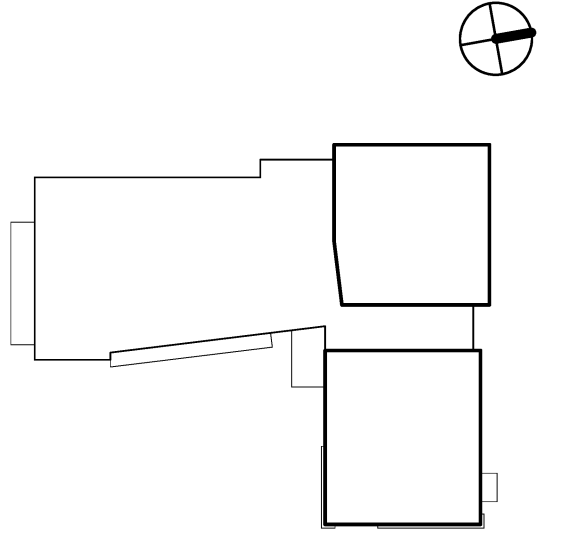

1 FIRST FLOOR DUCT PLAN  
SCALE: 1/8" = 1'-0"

| Issues and Revisions |          |                           |
|----------------------|----------|---------------------------|
| Mark                 | Date     | Description               |
| 09-04-15             | 09-04-15 | DESIGN DEVELOPMENT REVIEW |
| 03-25-16             | 03-25-16 | CONSTRUCTION DOCUMENTS    |

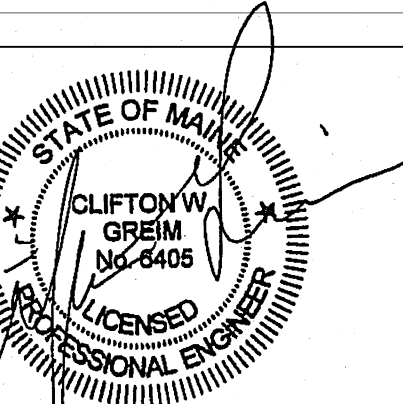

Drawing Scales  
1/8" = 1'-0"  
1/8" = 1'-0"

PA / PE: CG  
Drawn By: JSL  
© 2016  
Harriman Associates

FIRST FLOOR DUCTWORK PLAN

M10.0