



HARRIMAN

AUBURN PORTLAND MANCHESTER



JEWISH COMMUNITY ALLIANCE OF SOUTHERN MAINE

PORTLAND, ME

Harriman Project No. 15309


Key Plan

Proj North

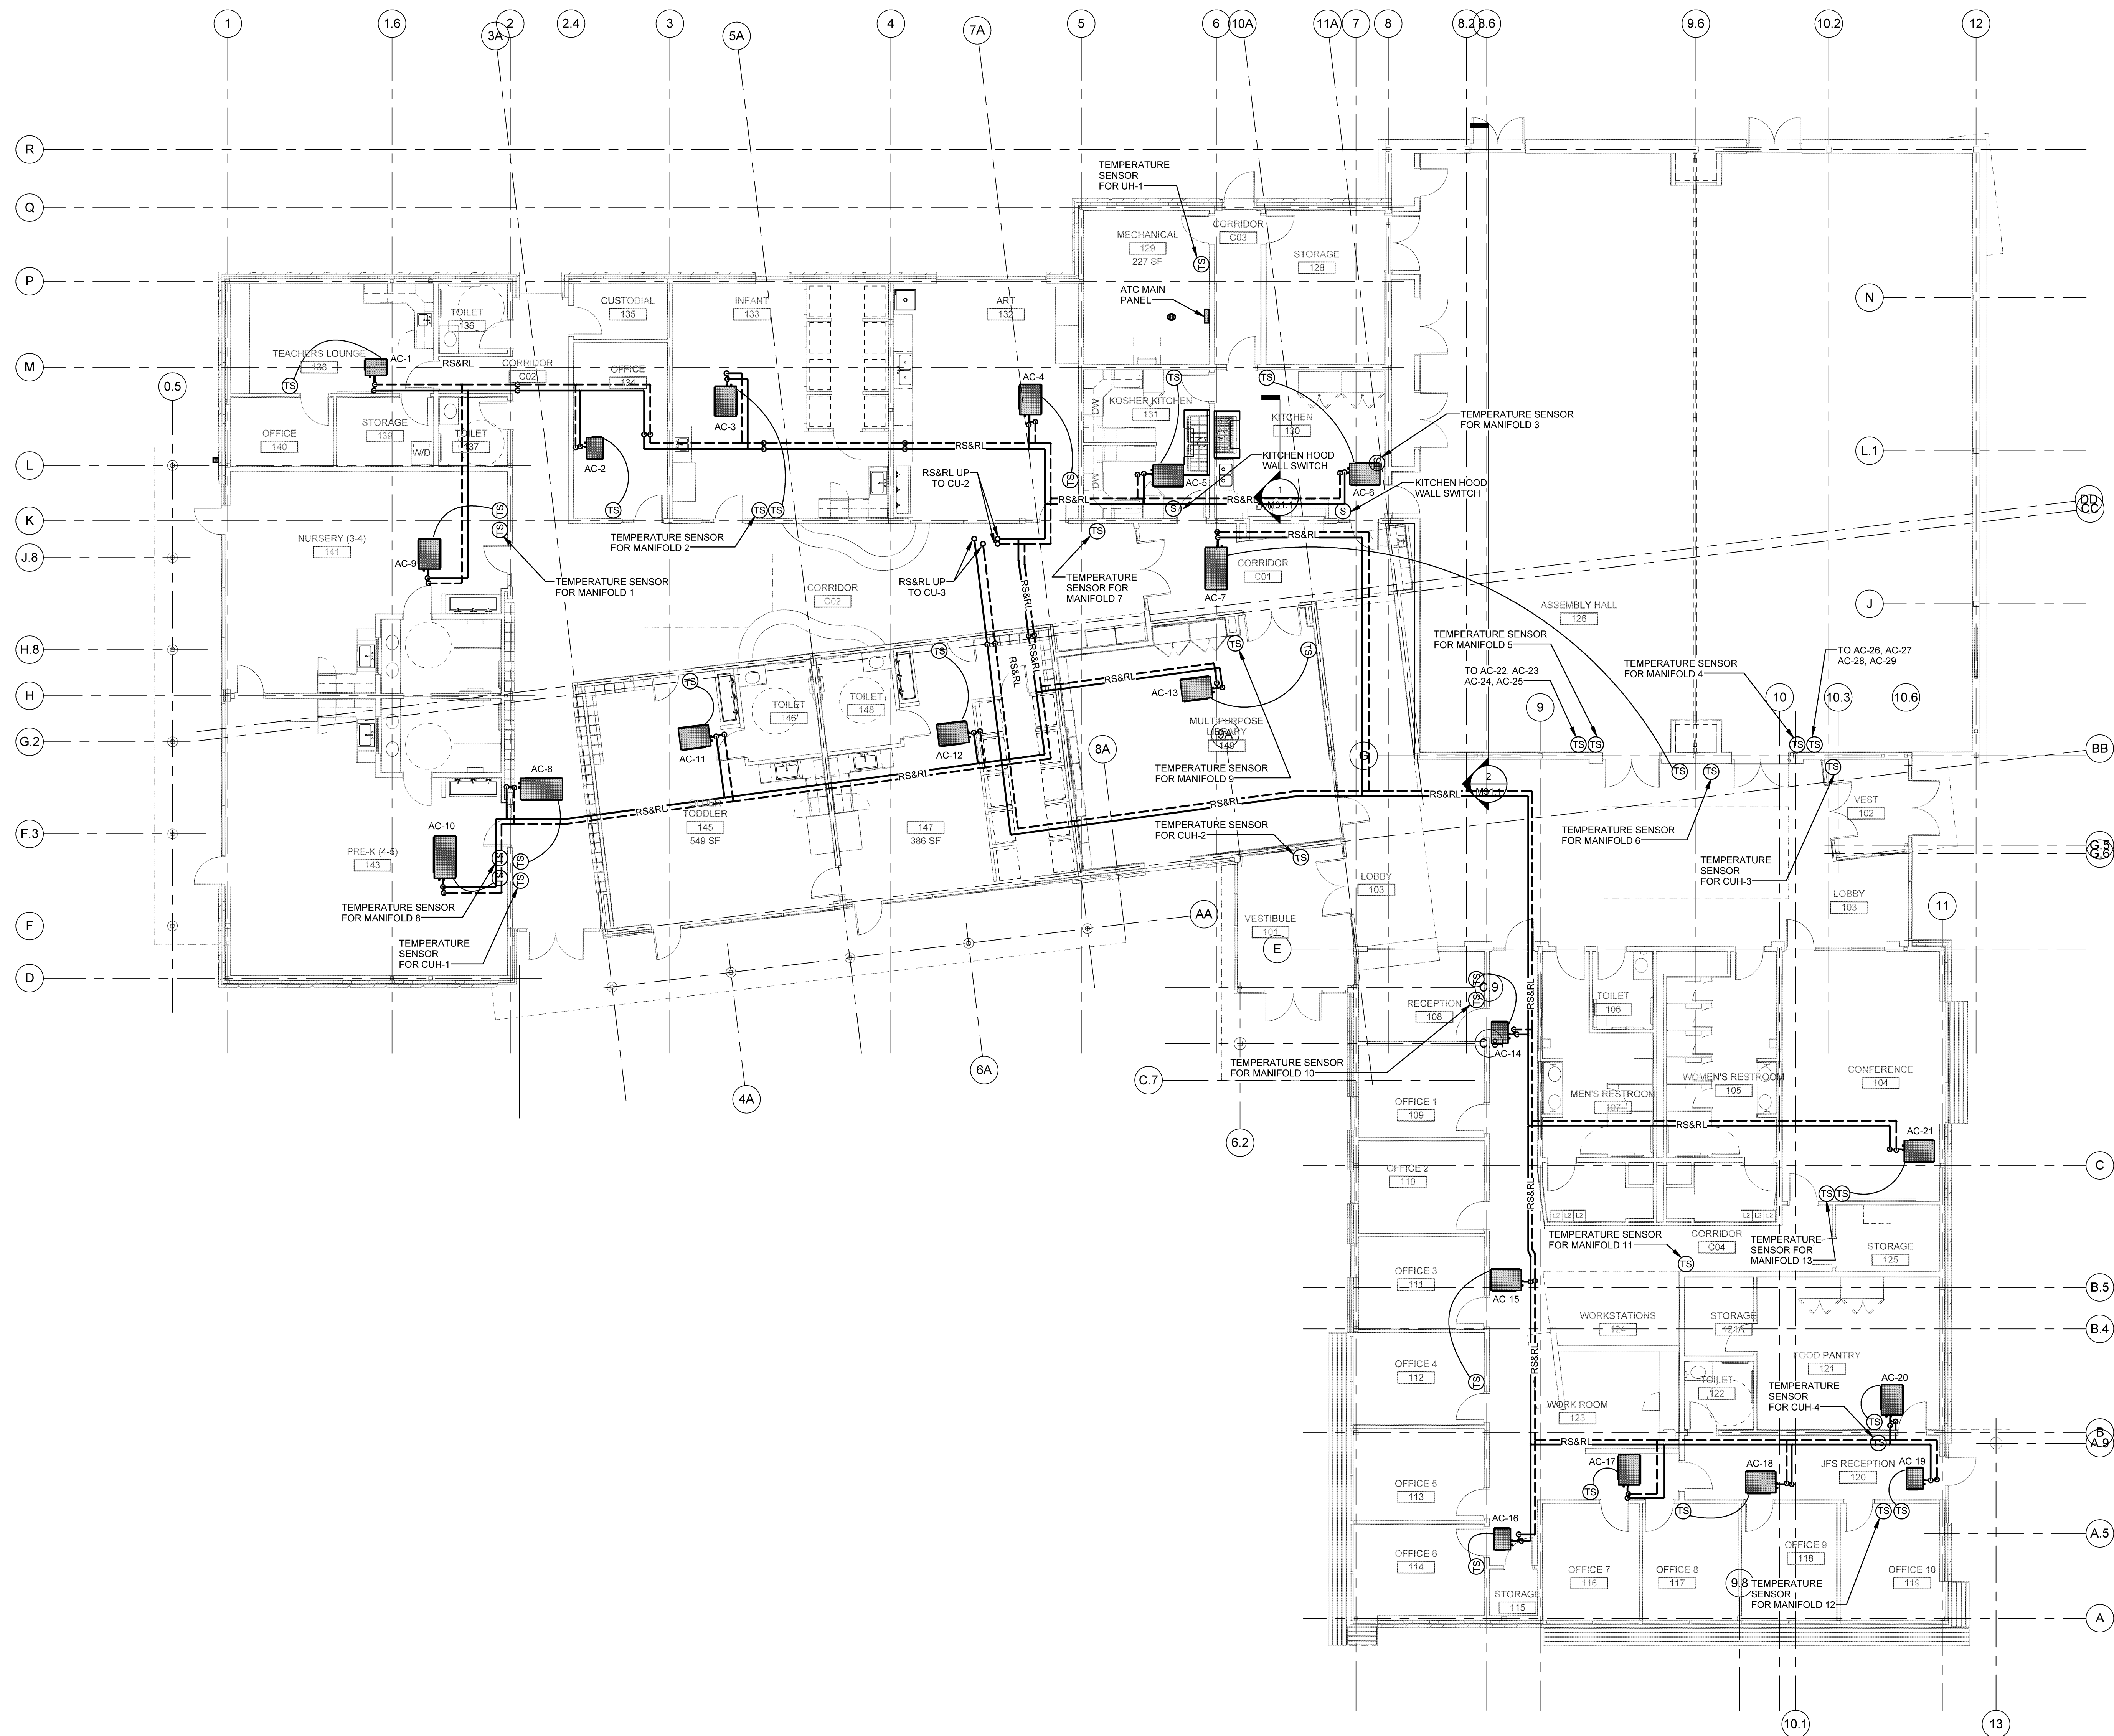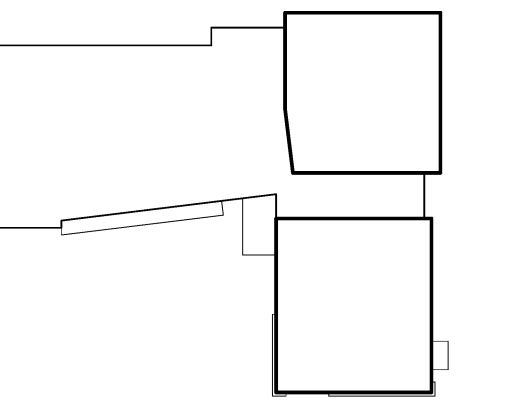

1 FIRST FLOOR PIPING PLAN
SCALE: 1/8" = 1'-0"

Mark	Date	Description
03-25-16		CONSTRUCTION DOCUMENTS

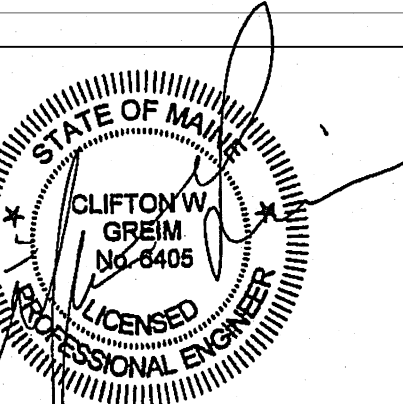

Drawing Scales
1/8" = 1'-0"

PA/PE: CG © 2016 Harriman Associates
Drawn By: JSL

FIRST FLOOR PIPING PLAN

M20.0

Plot Date: 3/23/2016 2:16:55 PM