



HARRIMAN

AUBURN PORTLAND MANCHESTER



JEWISH COMMUNITY ALLIANCE OF SOUTHERN MAINE

PORTLAND, ME

Harriman Project No. 15309

Key Plan


Proj North

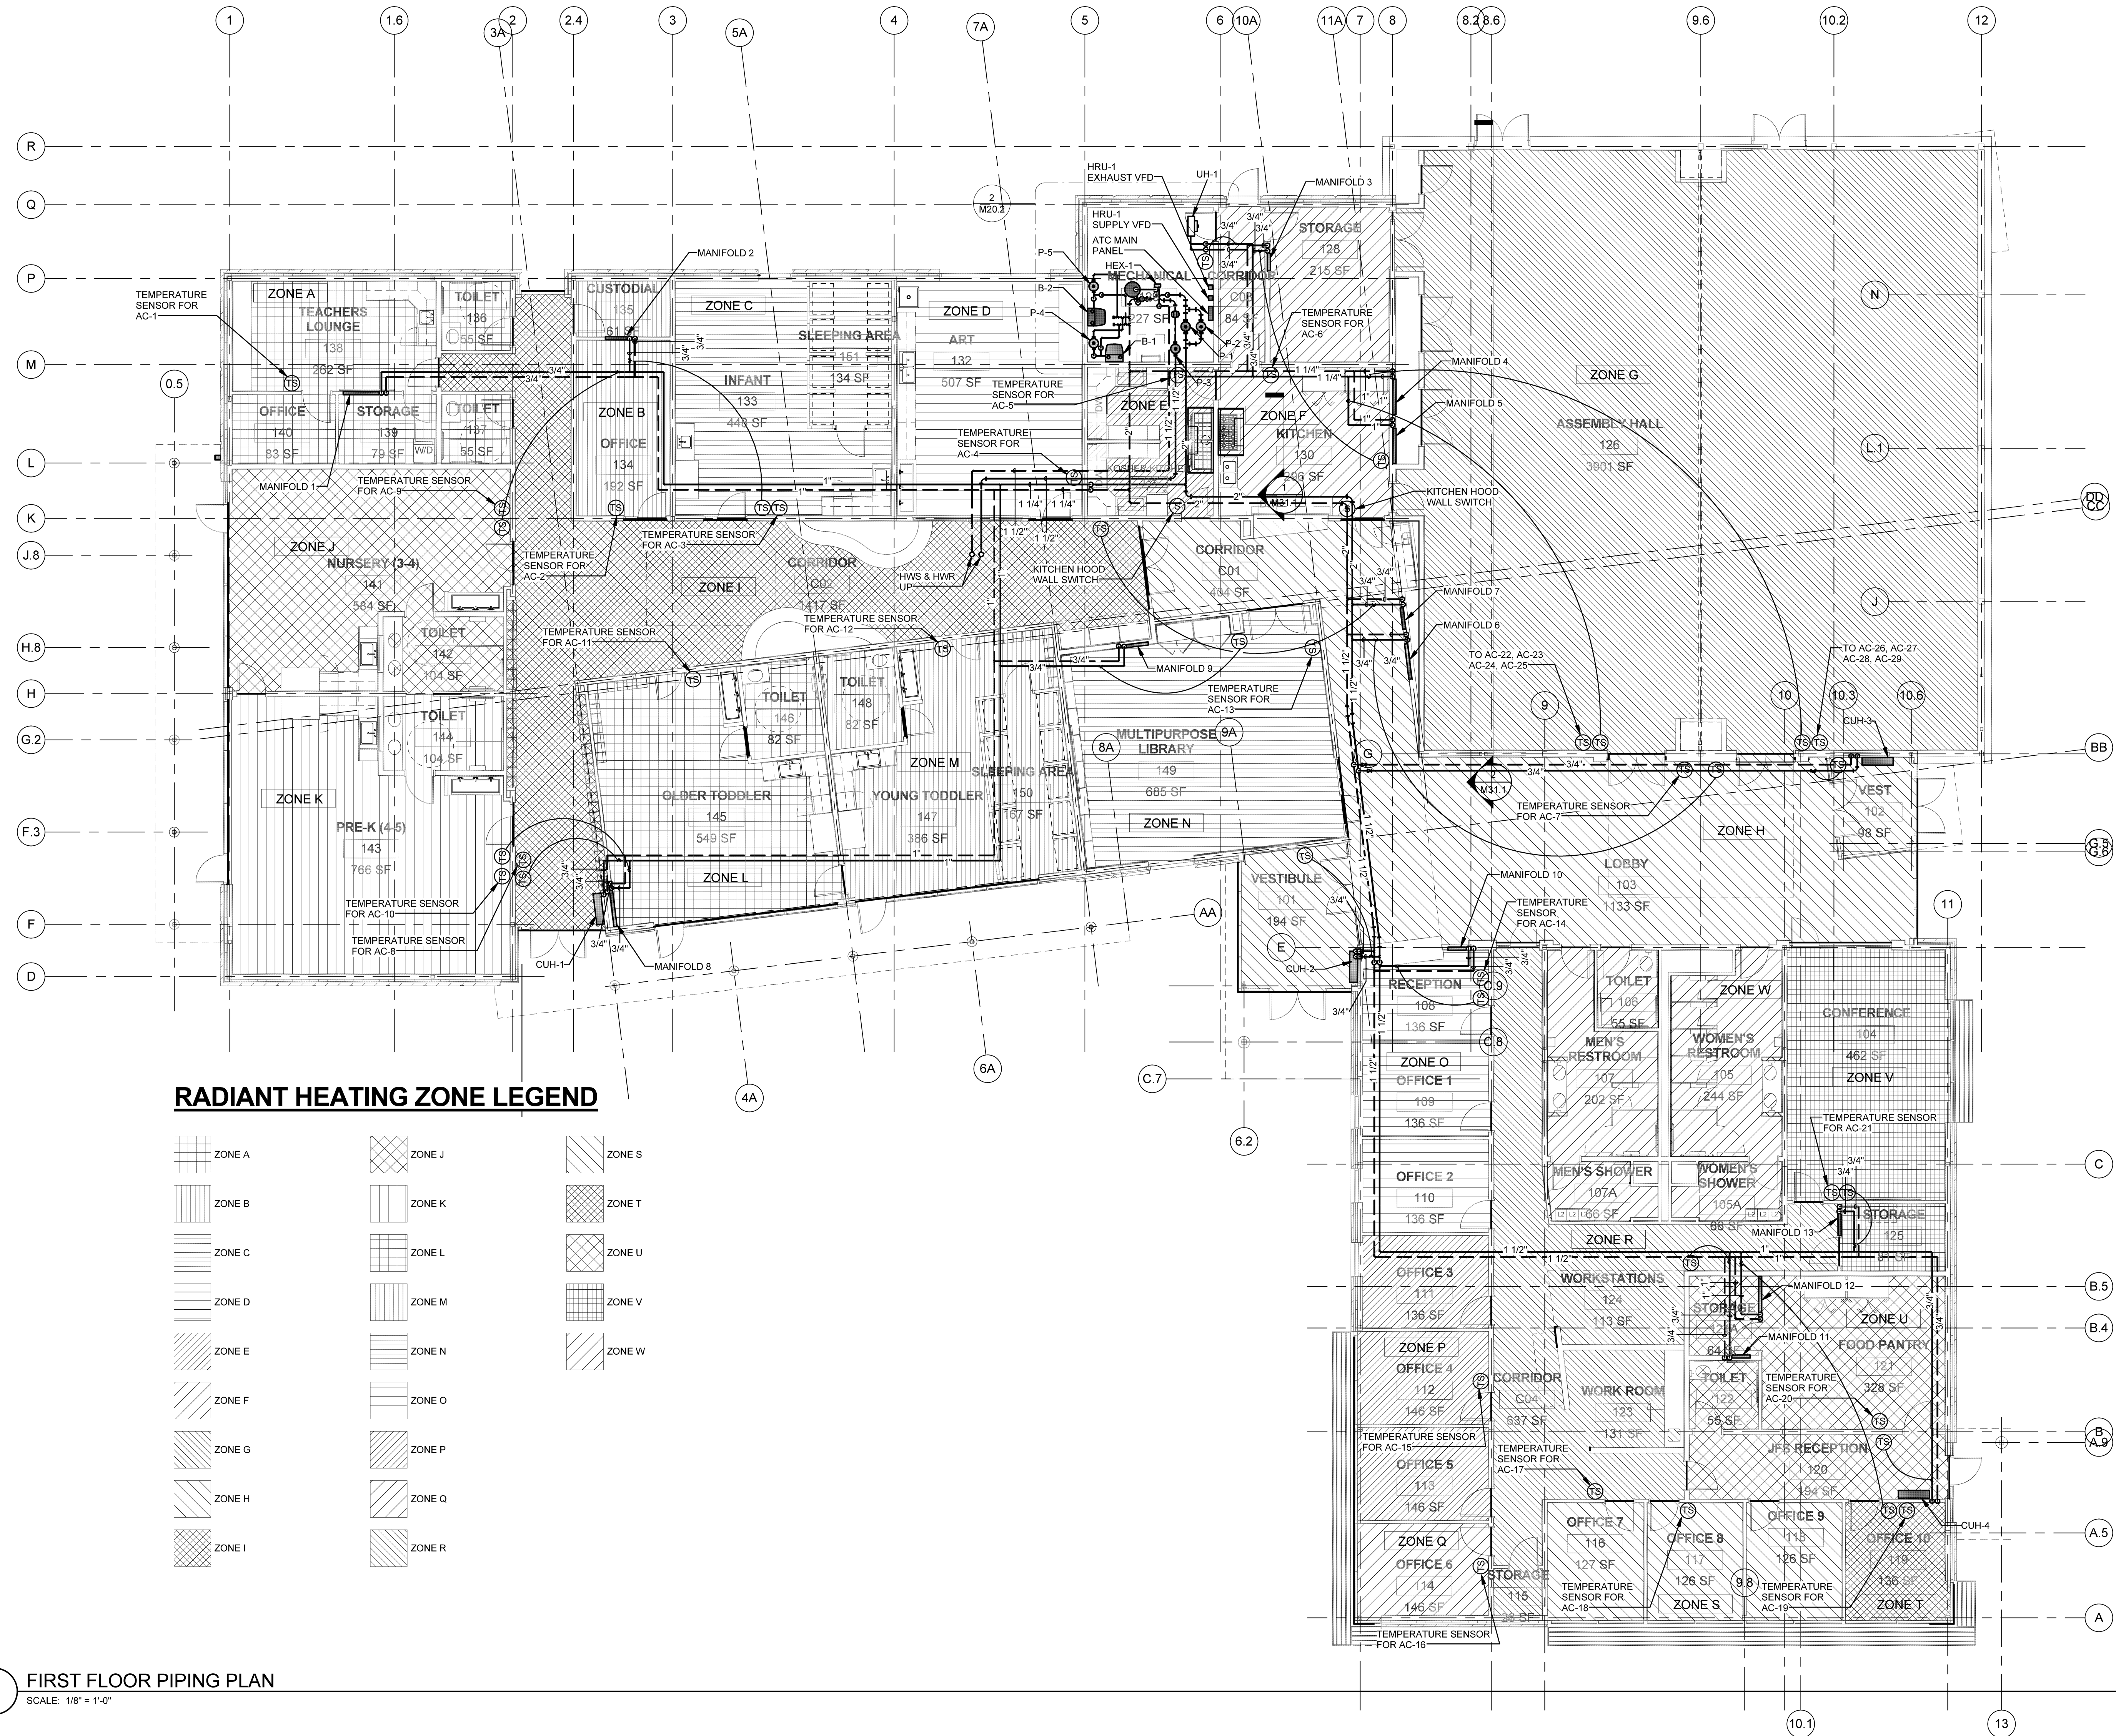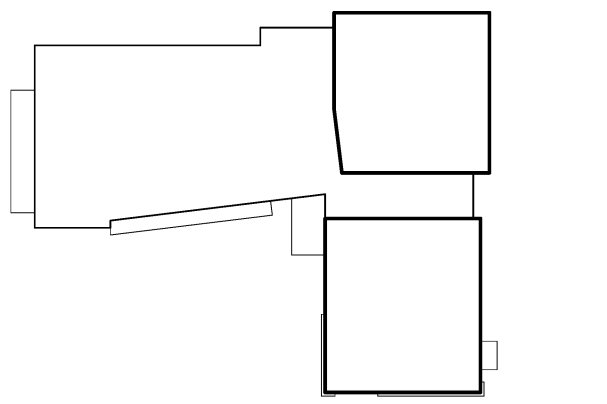

RADIANT HEATING ZONE LEGEND

1 FIRST FLOOR PIPING PLAN
SCALE: 1/8" = 1'-0"

Mark	Date	Description
	09-04-15	DESIGN DEVELOPMENT REVIEW
	03-25-16	CONSTRUCTION DOCUMENTS

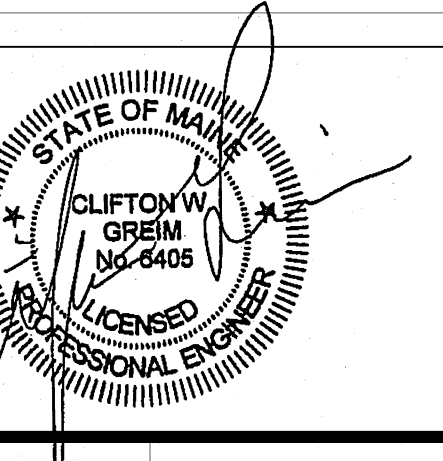

Drawing Scale: 1/8" = 1'-0"

PA/PE: CG © 2016 Harriman Associates
Drawn By: JSL

FIRST FLOOR RADIANT FLOOR PIPING PLAN

M20.1

Plot Date: 3/23/2016 2:17:26 PM