



HARRIMAN



AUBURN PORTLAND MANCHESTER

JEWISH COMMUNITY ALLIANCE OF SOUTHERN MAINE

PORTLAND, ME


Harriman Project No. 15309

Key Plan Proj North

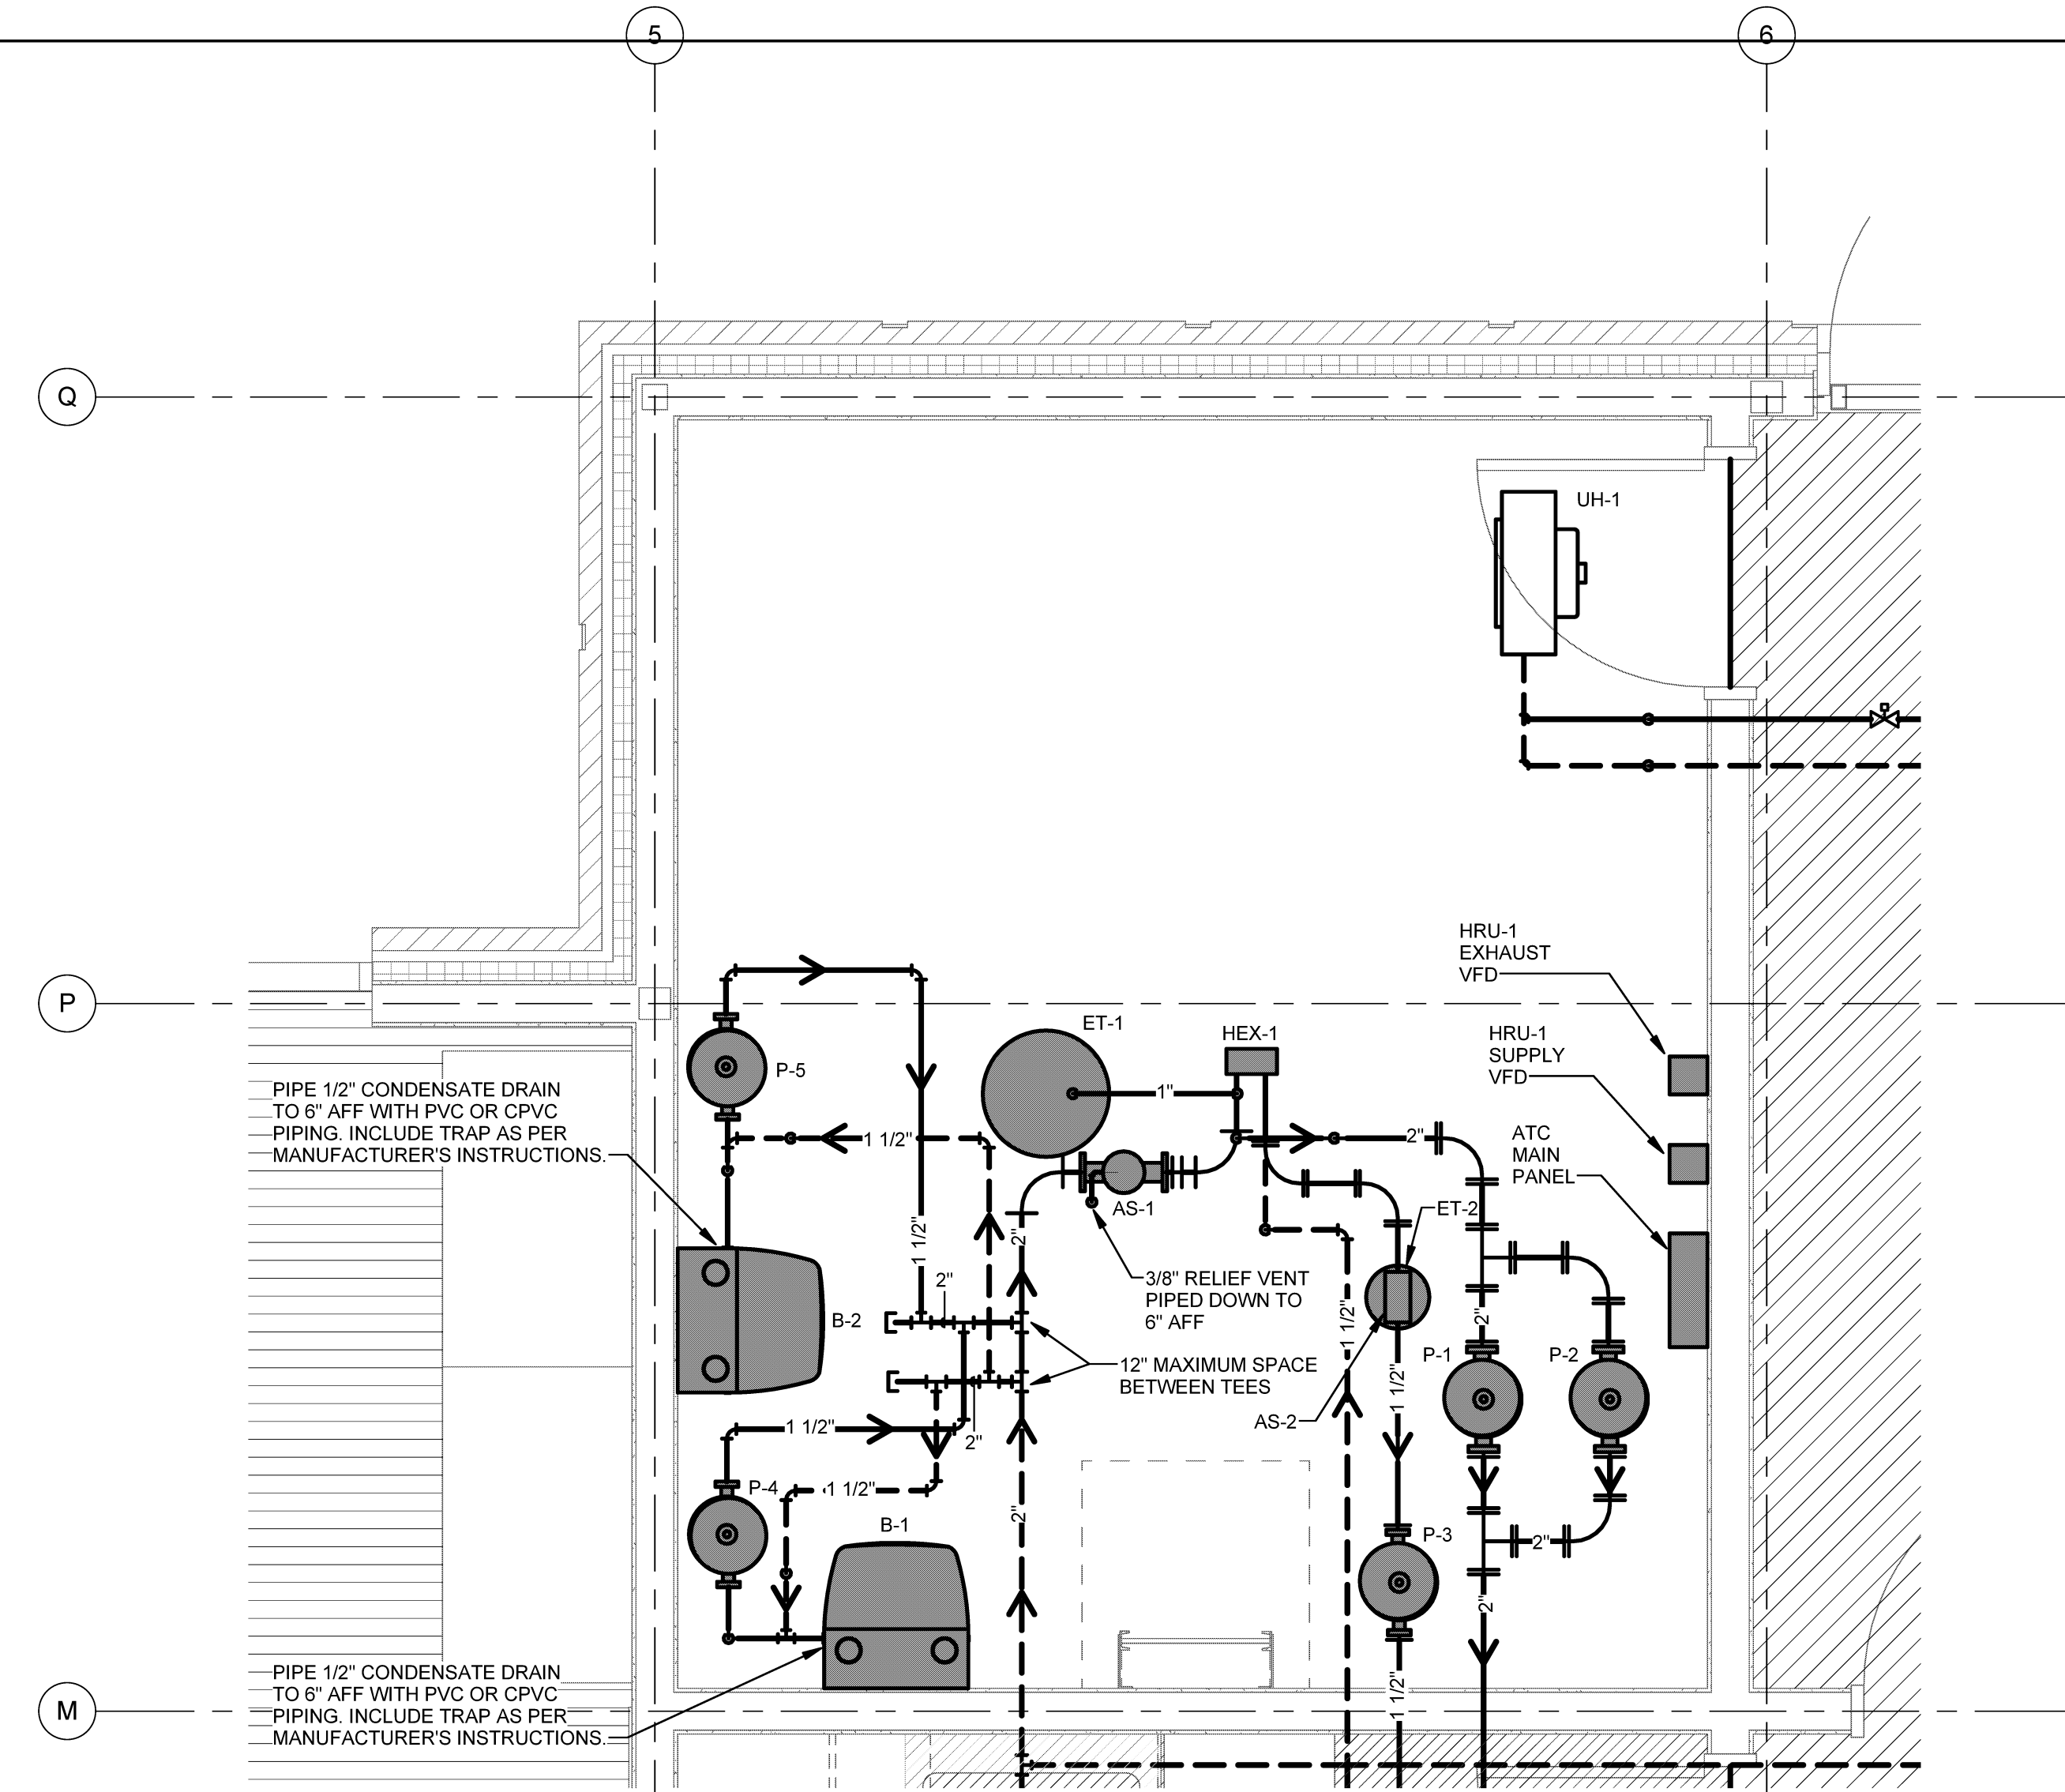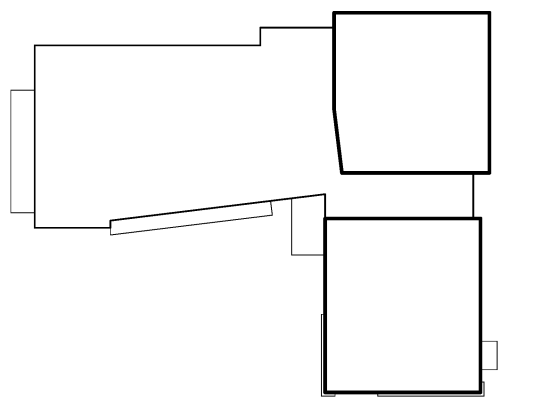

2 MECHANICAL ROOM PART PLAN


SCALE: 1/2" = 1'-0"

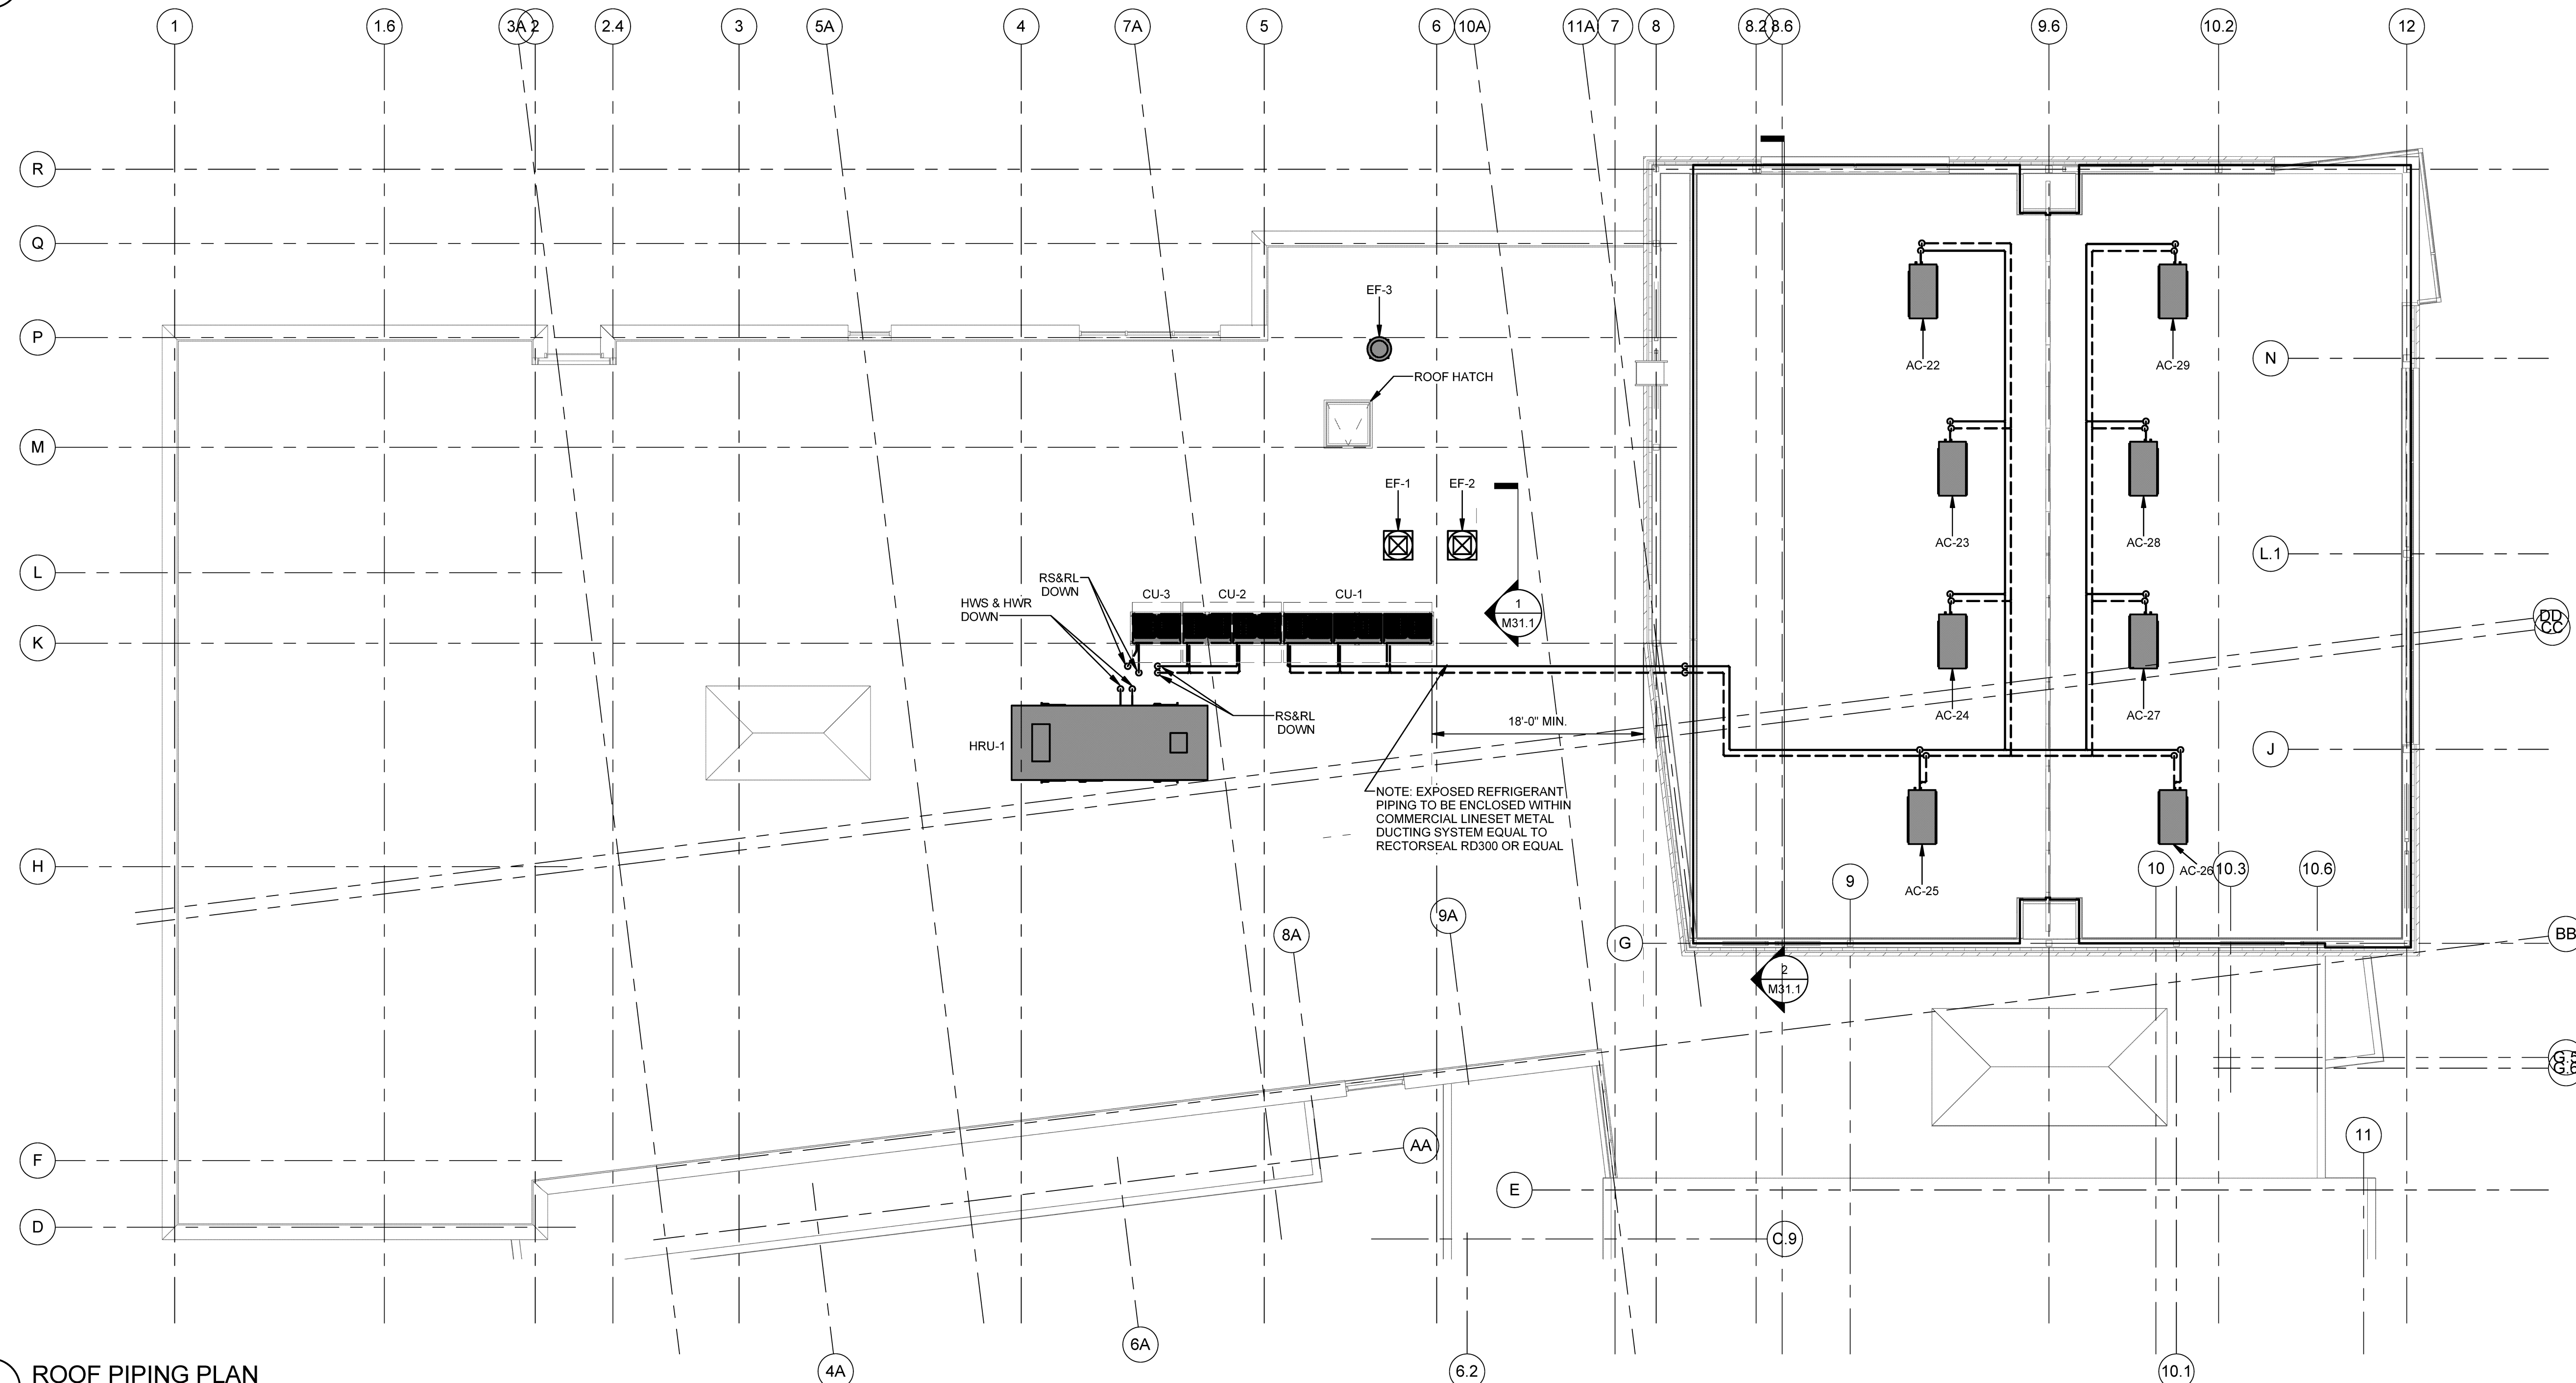

1 ROOF PIPING PLAN

SCALE: 1/8" = 1'-0"

Mark	Date	Description
	09-04-15	DESIGN DEVELOPMENT REVIEW
	03-25-16	CONSTRUCTION DOCUMENTS

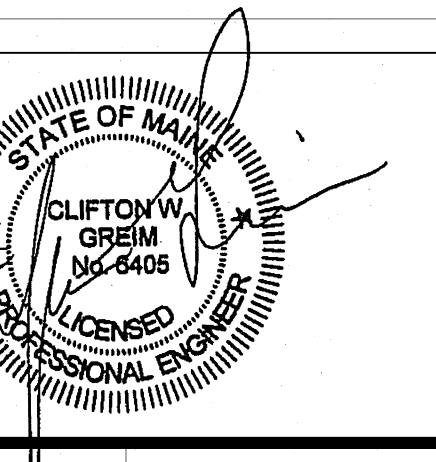

Drawing Scales As indicated

PA/PE: CG © 2016 Harriman Associates
Drawn By: JSL

PIPING PART PLANS

M20.2