



HARRIMAN



AUBURN PORTLAND MANCHESTER

JEWISH COMMUNITY ALLIANCE OF SOUTHERN MAINE



PORTLAND, ME

Harriman Project No. 15309

Key Plan Proj North

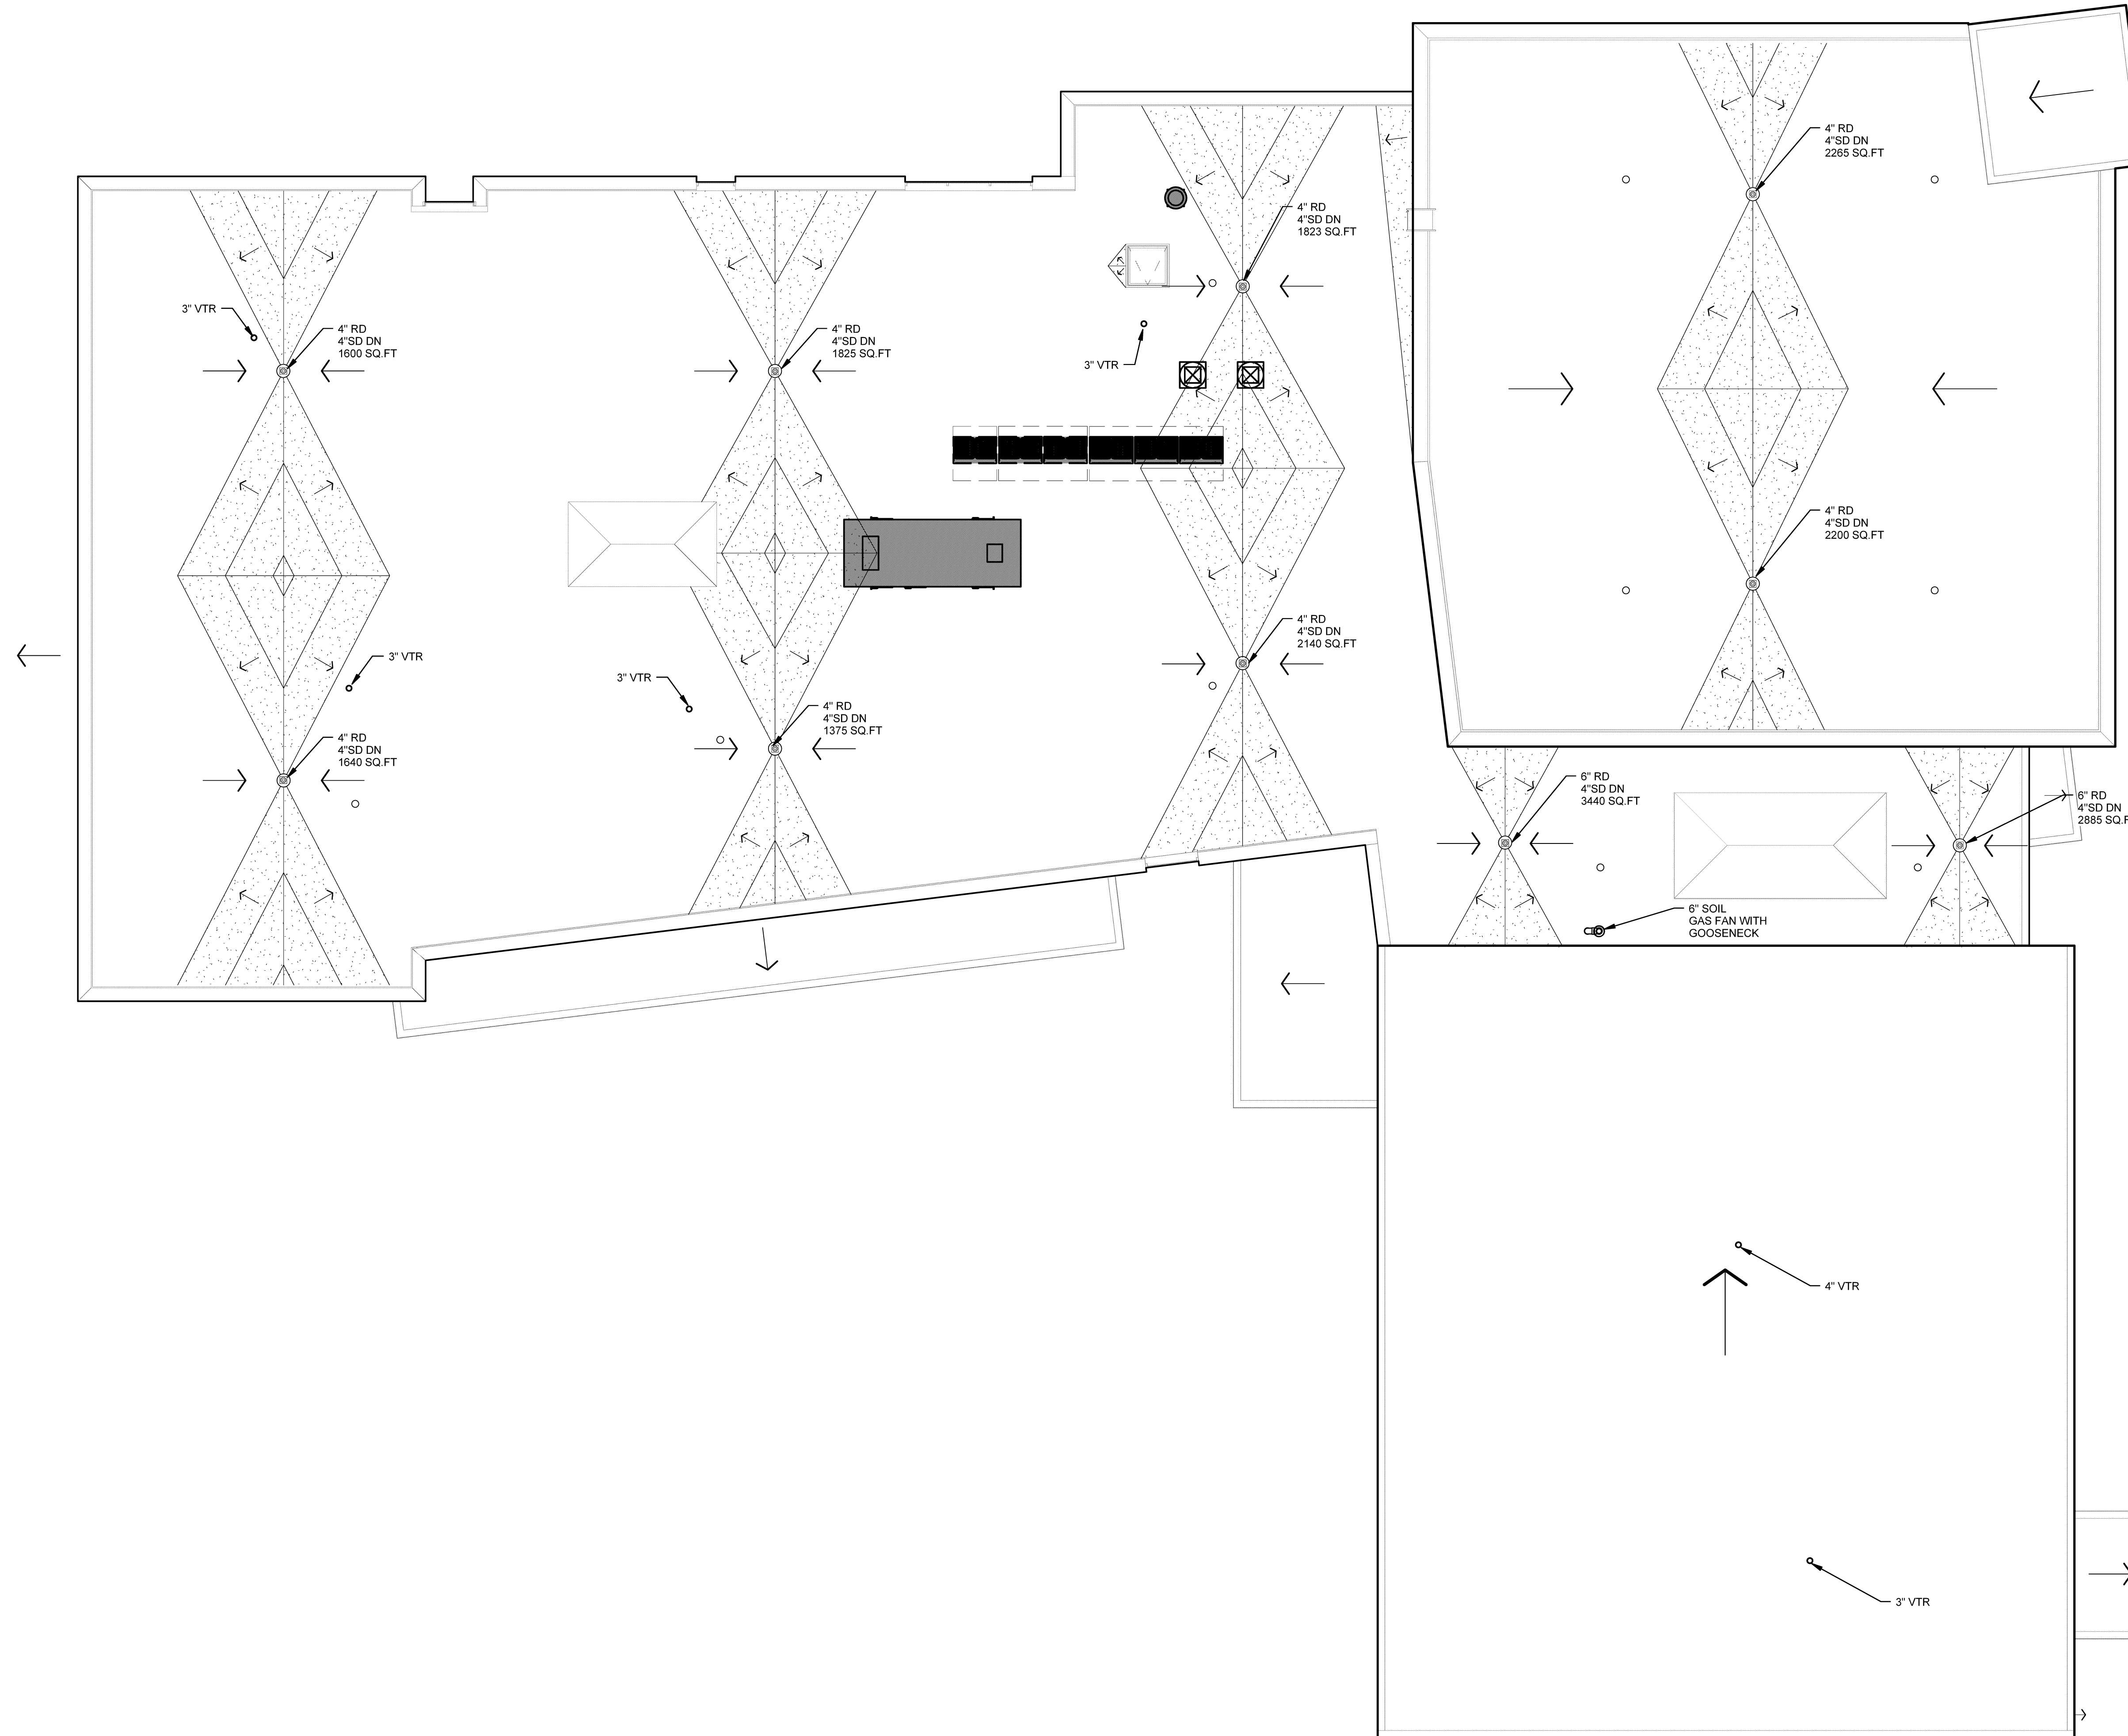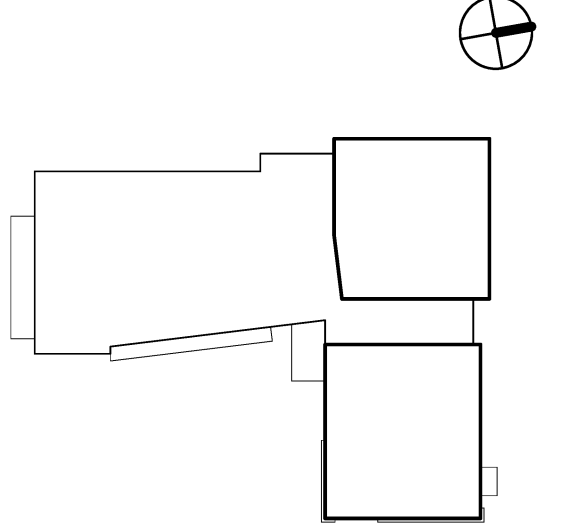

Issues and Revisions		
Mark	Date	Description
	09-04-15	DESIGN DEVELOPMENT REVIEW
	03-25-16	CONSTRUCTION DOCUMENTS

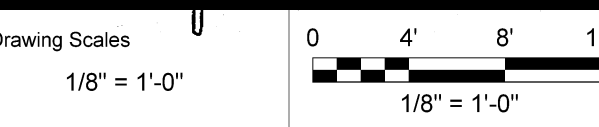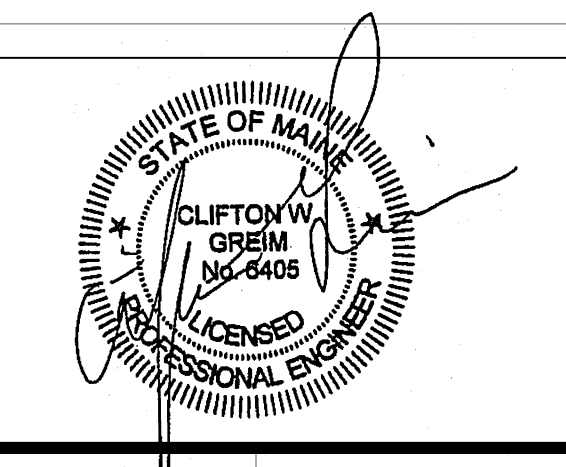

PA/PE: CG © 2016 Harriman Associates
Drawn By: MAM

PLUMBING ROOF PLAN

P10.3

1 PLUMBING ROOF PLAN
SCALE: 1/8" = 1'-0"