



HARRIMAN

AUBURN PORTLAND MANCHESTER


JEWISH COMMUNITY ALLIANCE OF SOUTHERN MAINE

PORTLAND, ME

Harriman Project No. 15309


Key Plan

Prof North

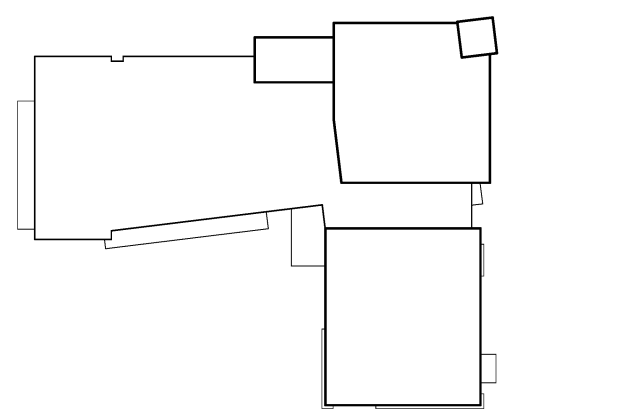


LIGHTING FIXTURE TYPE: GO RUN AROUND PERIMETER OF SPACE AS INDICATED. PROVIDE WITH ILLUMINATED SIDEG. CORNERS. LIGHTING CONTROL ZONE #4

6" ADJUSTABLE 3,000 LUMEN LED DOWNLIGHT GOTHAM (CO ADJ-3530-6AC-T0-FL-SS-25D-120-EZ10) ORIENTATE SO LIGHT CAN BE AIMED TOWARDS NORTH WALL (RODS TO WALL). AIM AS DIRECTED BY OWNER. COORDINATE INSTALLATION WITH CEILING SYSTEM.

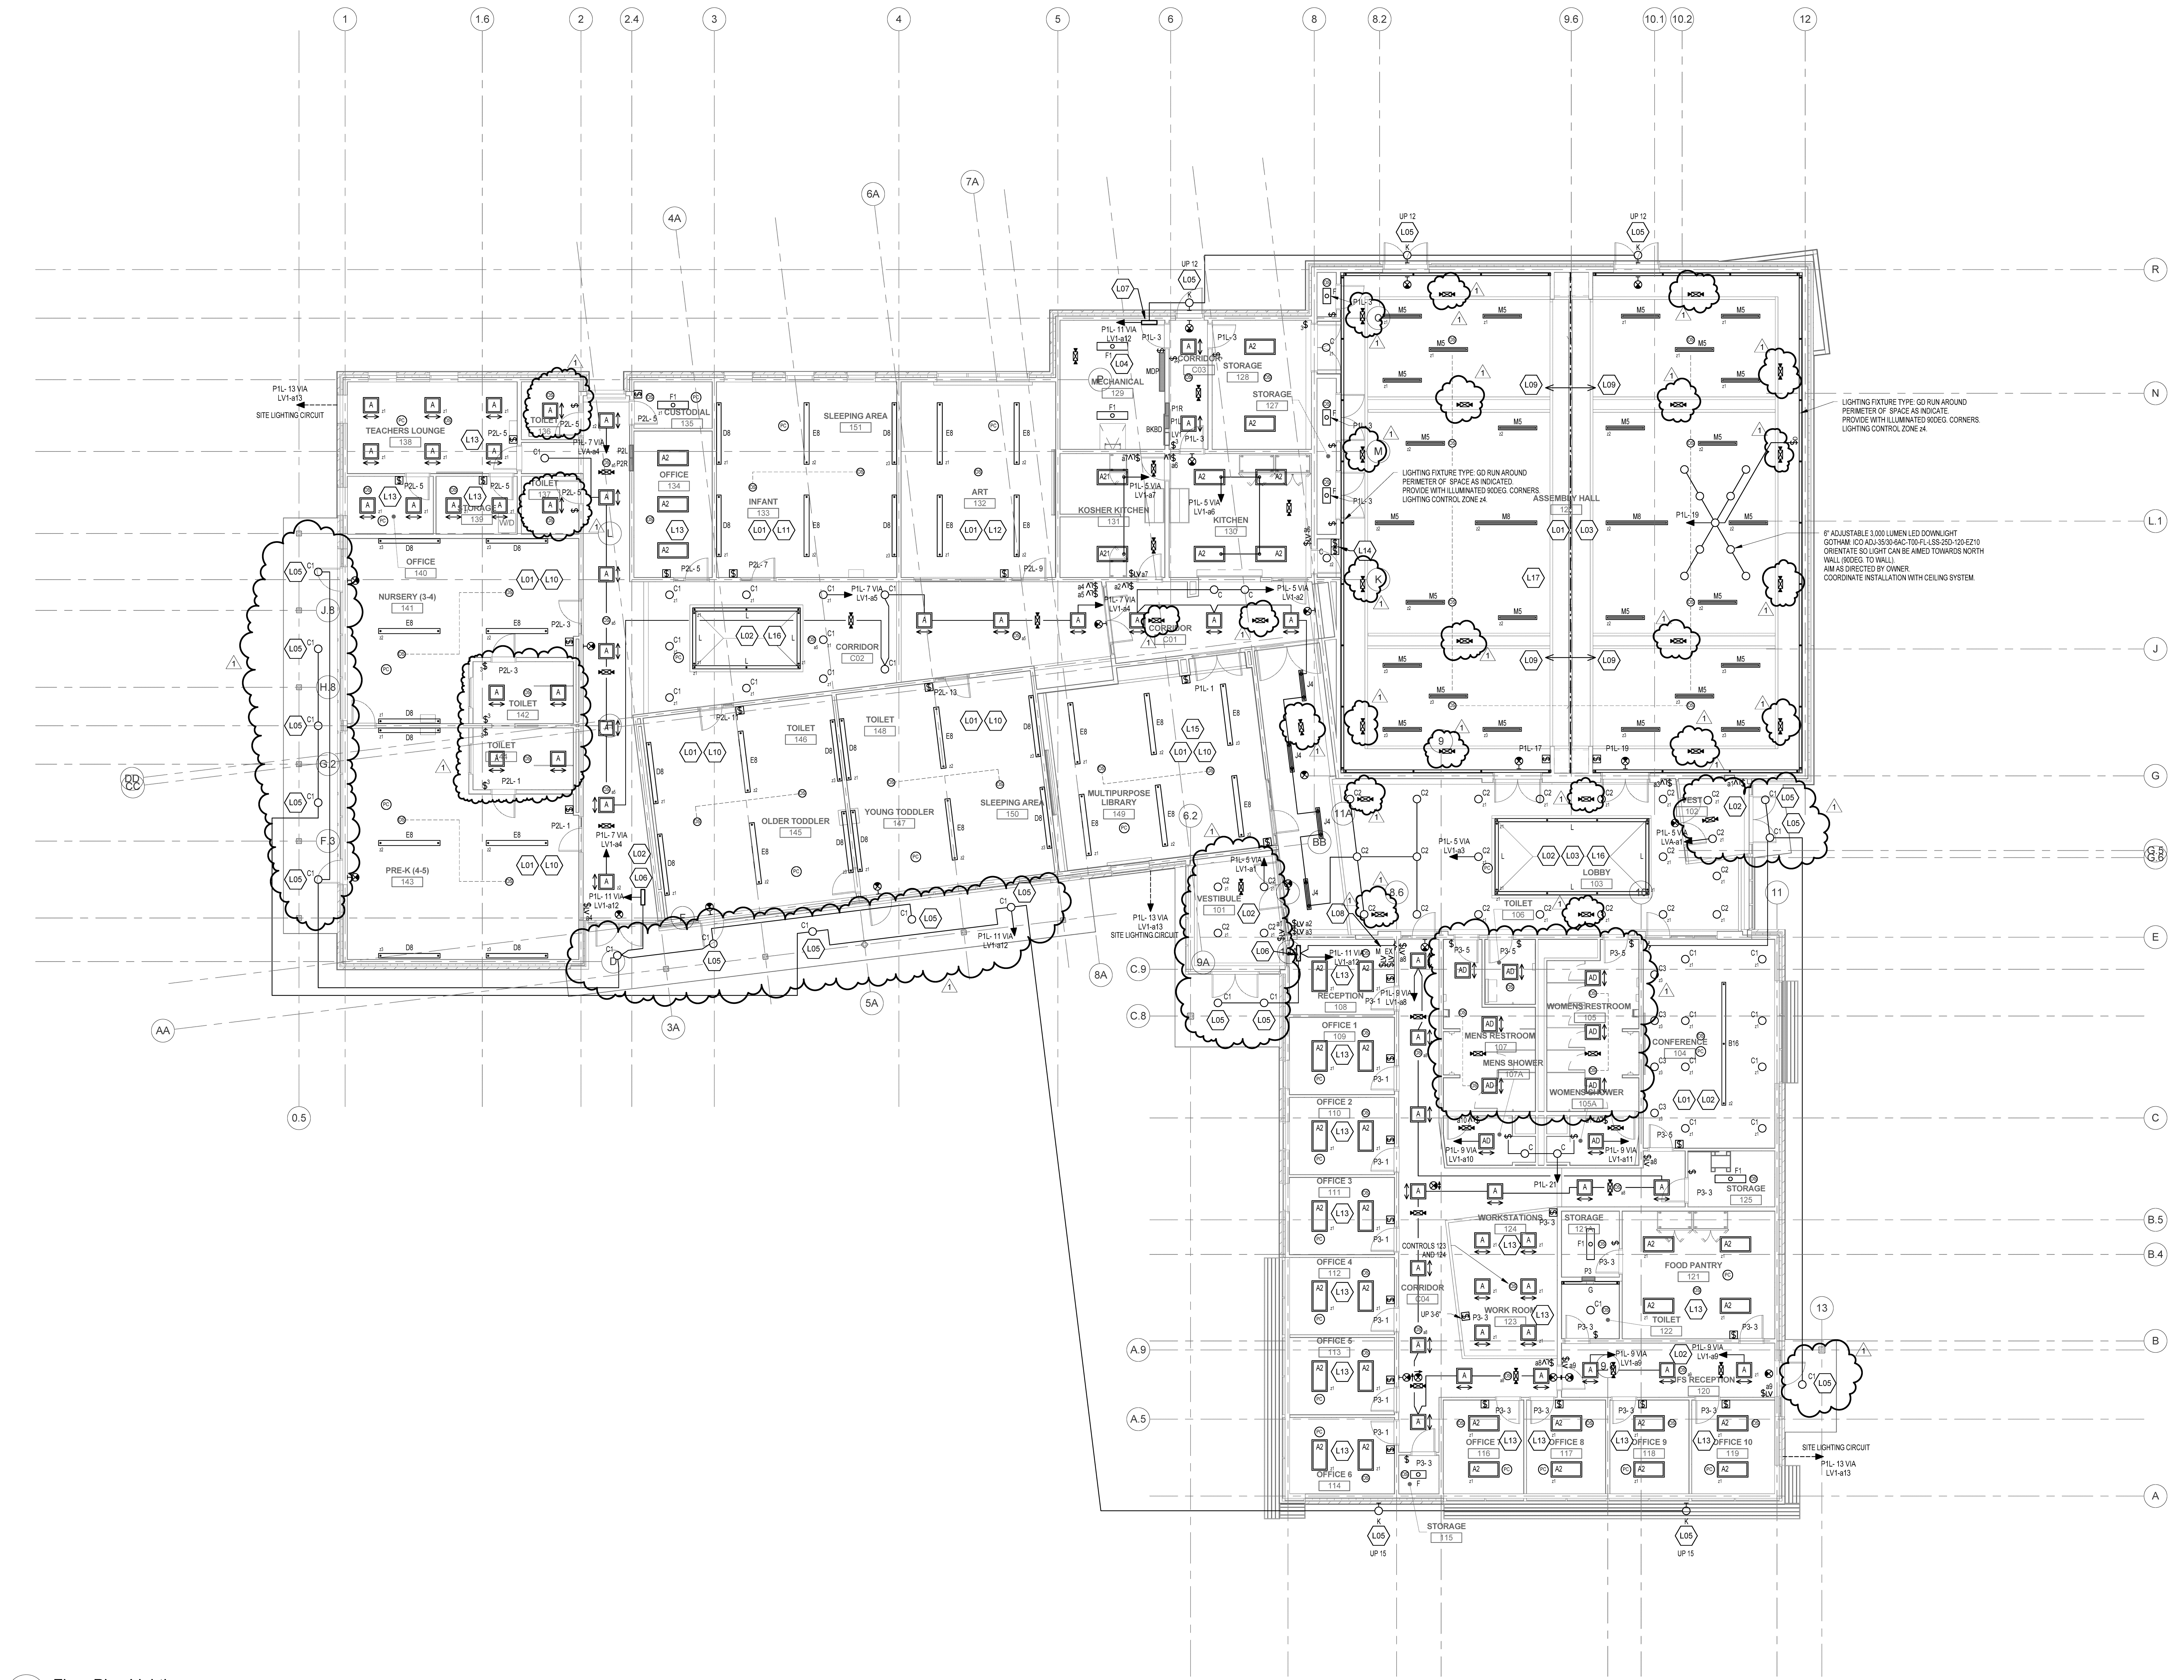

Issues and Revisions

Mark	Date	Description
03-25-16		CONSTRUCTION DOCUMENTS
1	07-22-16	CONFORMANCE SET

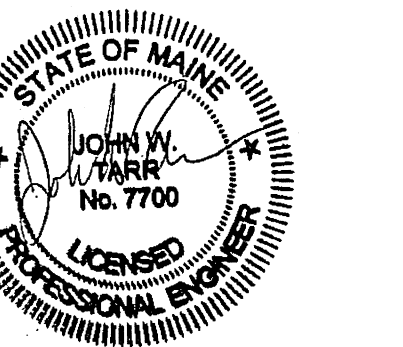

Drawing Scales 0 4 8 12
1/8" = 1'-0" 1/8" = 1'-0"

PA/PE: JWT © 2016
Drawn By: JMB Harriman Associates

FLOOR PLAN LIGHTING

E10.1

1 Floor Plan Lighting
SCALE: 1/8" = 1'-0"

Plot Date: 7/27/2016 1:52:33 PM