



HARRIMAN



AUBURN PORTLAND MANCHESTER

JEWISH COMMUNITY ALLIANCE OF SOUTHERN MAINE

PORTLAND, ME


Harriman Project No. 15309

Key Plan

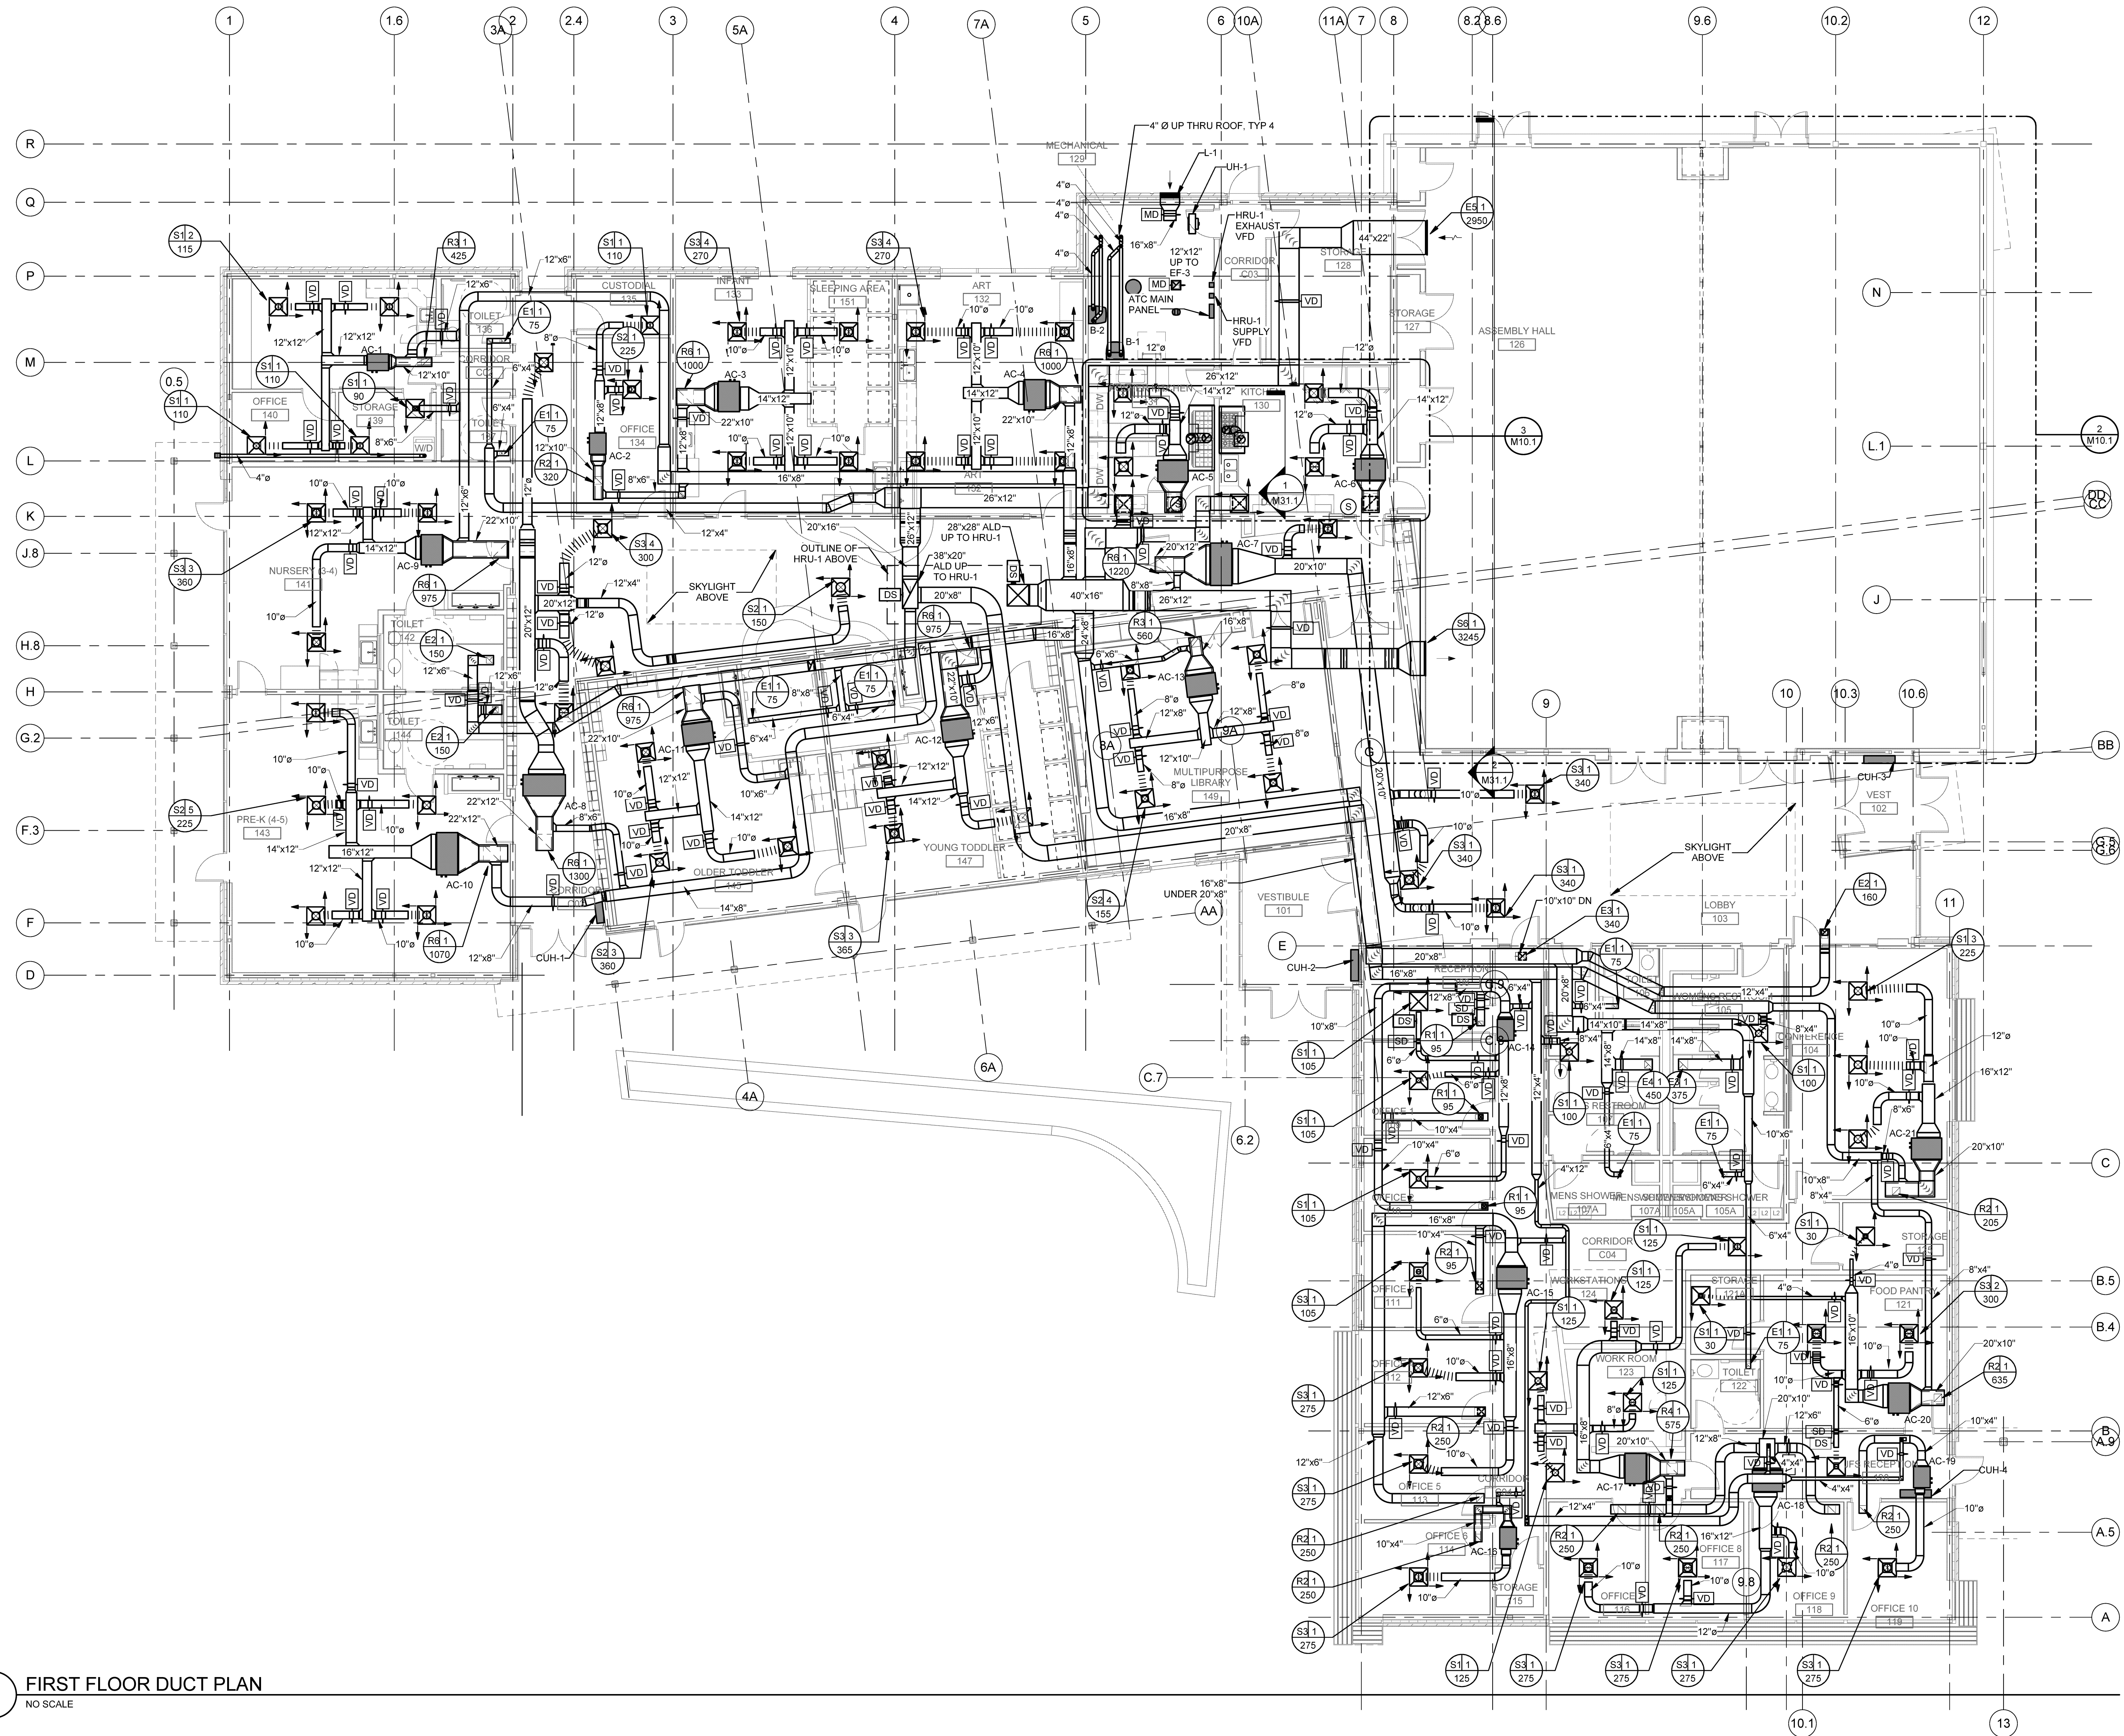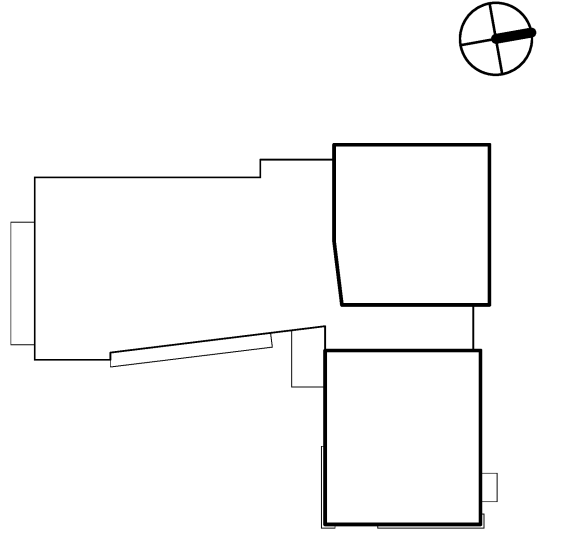

1 FIRST FLOOR DUCT PLAN
NO SCALE

Issues and Revisions		
Mark	Date	Description
09-04-15		DESIGN DEVELOPMENT REVIEW
03-25-16		CONSTRUCTION DOCUMENTS
3	07-22-16	CONFORMANCE SET

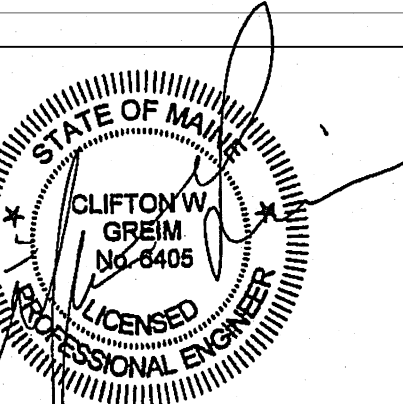

Drawing Scales
1/8" = 1'-0"
1/8" = 1'-0"

PA/PE: CG © 2016
Harriman Associates
Drawn By: JSL

FIRST FLOOR DUCTWORK PLAN

M10.0