



HARRIMAN

AUBURN PORTLAND MANCHESTER



JEWISH COMMUNITY ALLIANCE OF SOUTHERN MAINE

PORTLAND, ME

Harriman Project No. 15309


Key Plan

Proj North

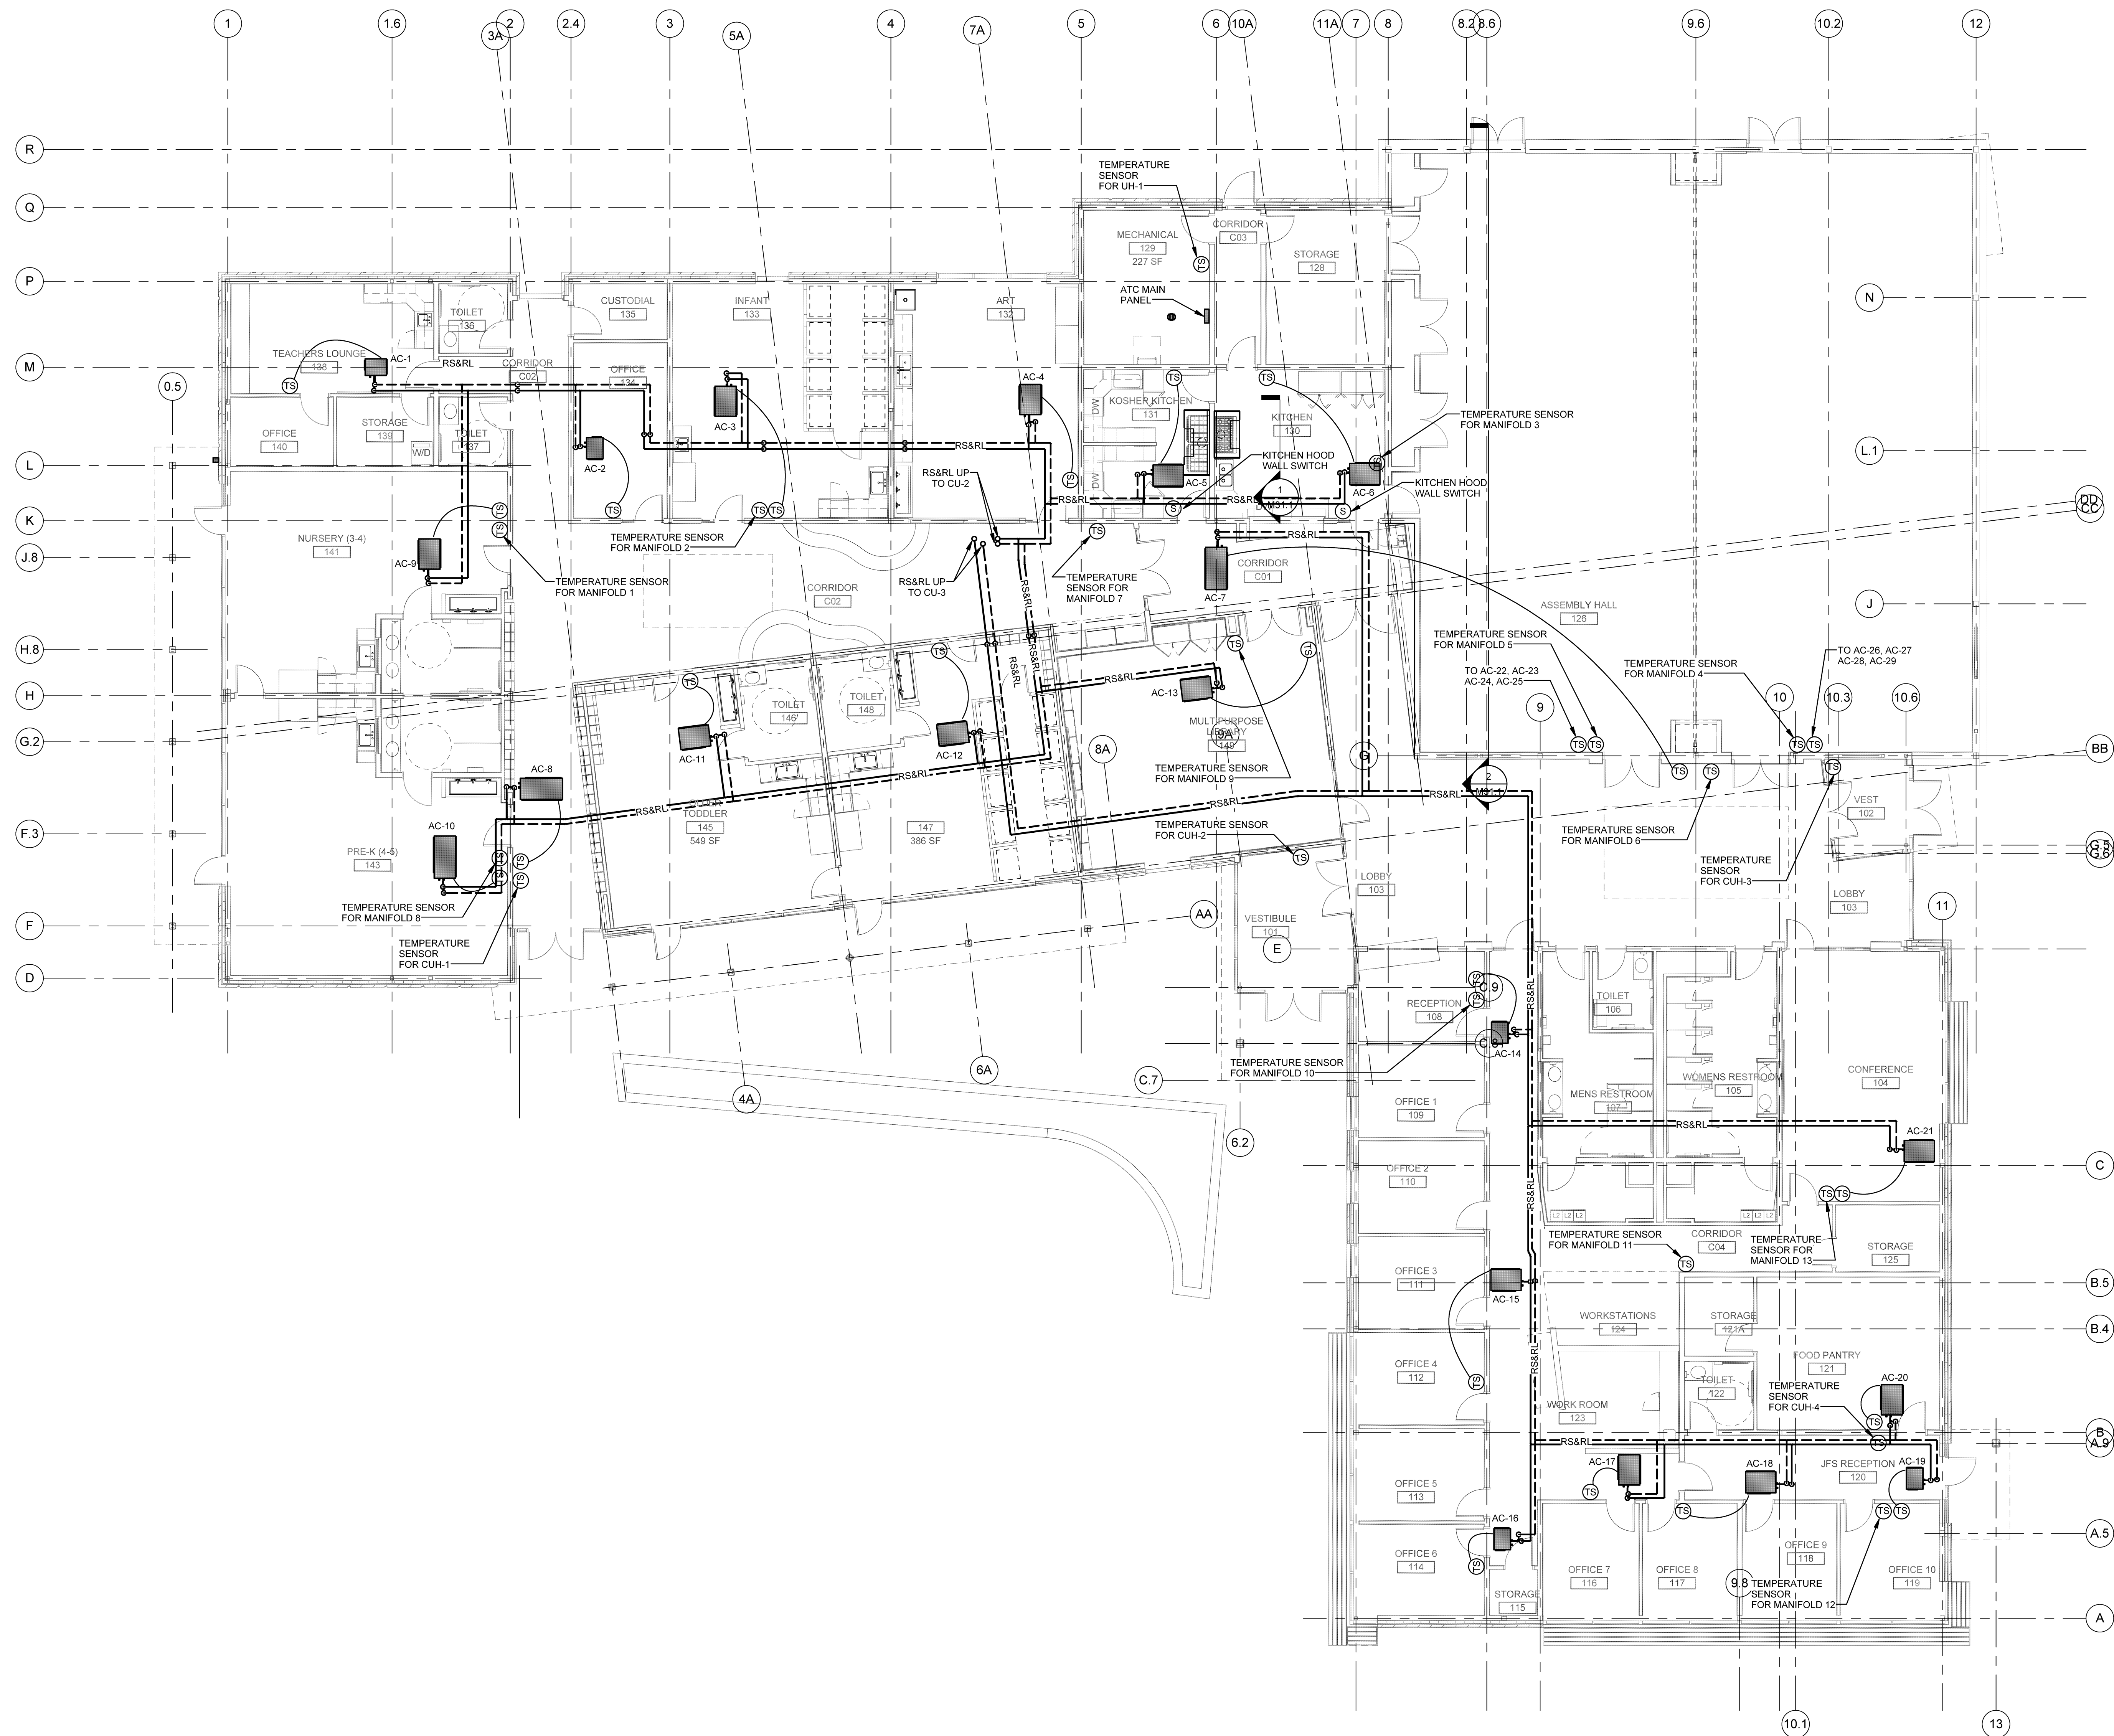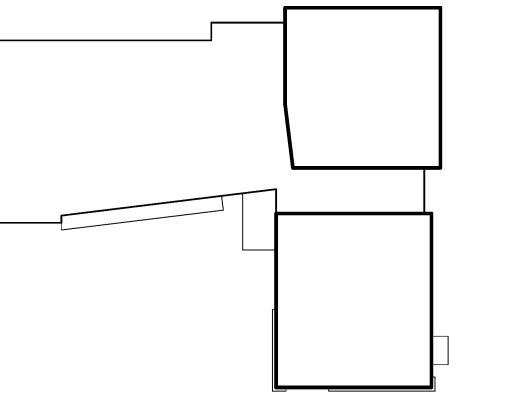

1 FIRST FLOOR PIPING PLAN
NO SCALE

Issues and Revisions		
Mark	Date	Description
03-25-16		CONSTRUCTION DOCUMENTS
3	07-22-16	CONFORMANCE SET

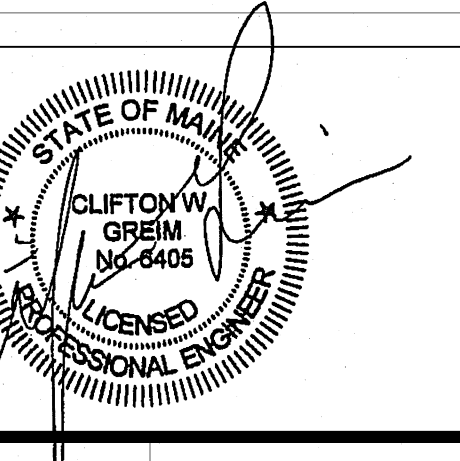

Drawing Scales
1/8" = 1'-0"

PA/PE: CG © 2016
Drawn By: JSL Harriman Associates

FIRST FLOOR PIPING PLAN

M20.0