



HARRIMAN

AUBURN PORTLAND MANCHESTER



JEWISH COMMUNITY ALLIANCE OF SOUTHERN MAINE

PORTLAND, ME

Harriman Project No. 15309

Key Plan

Proj North

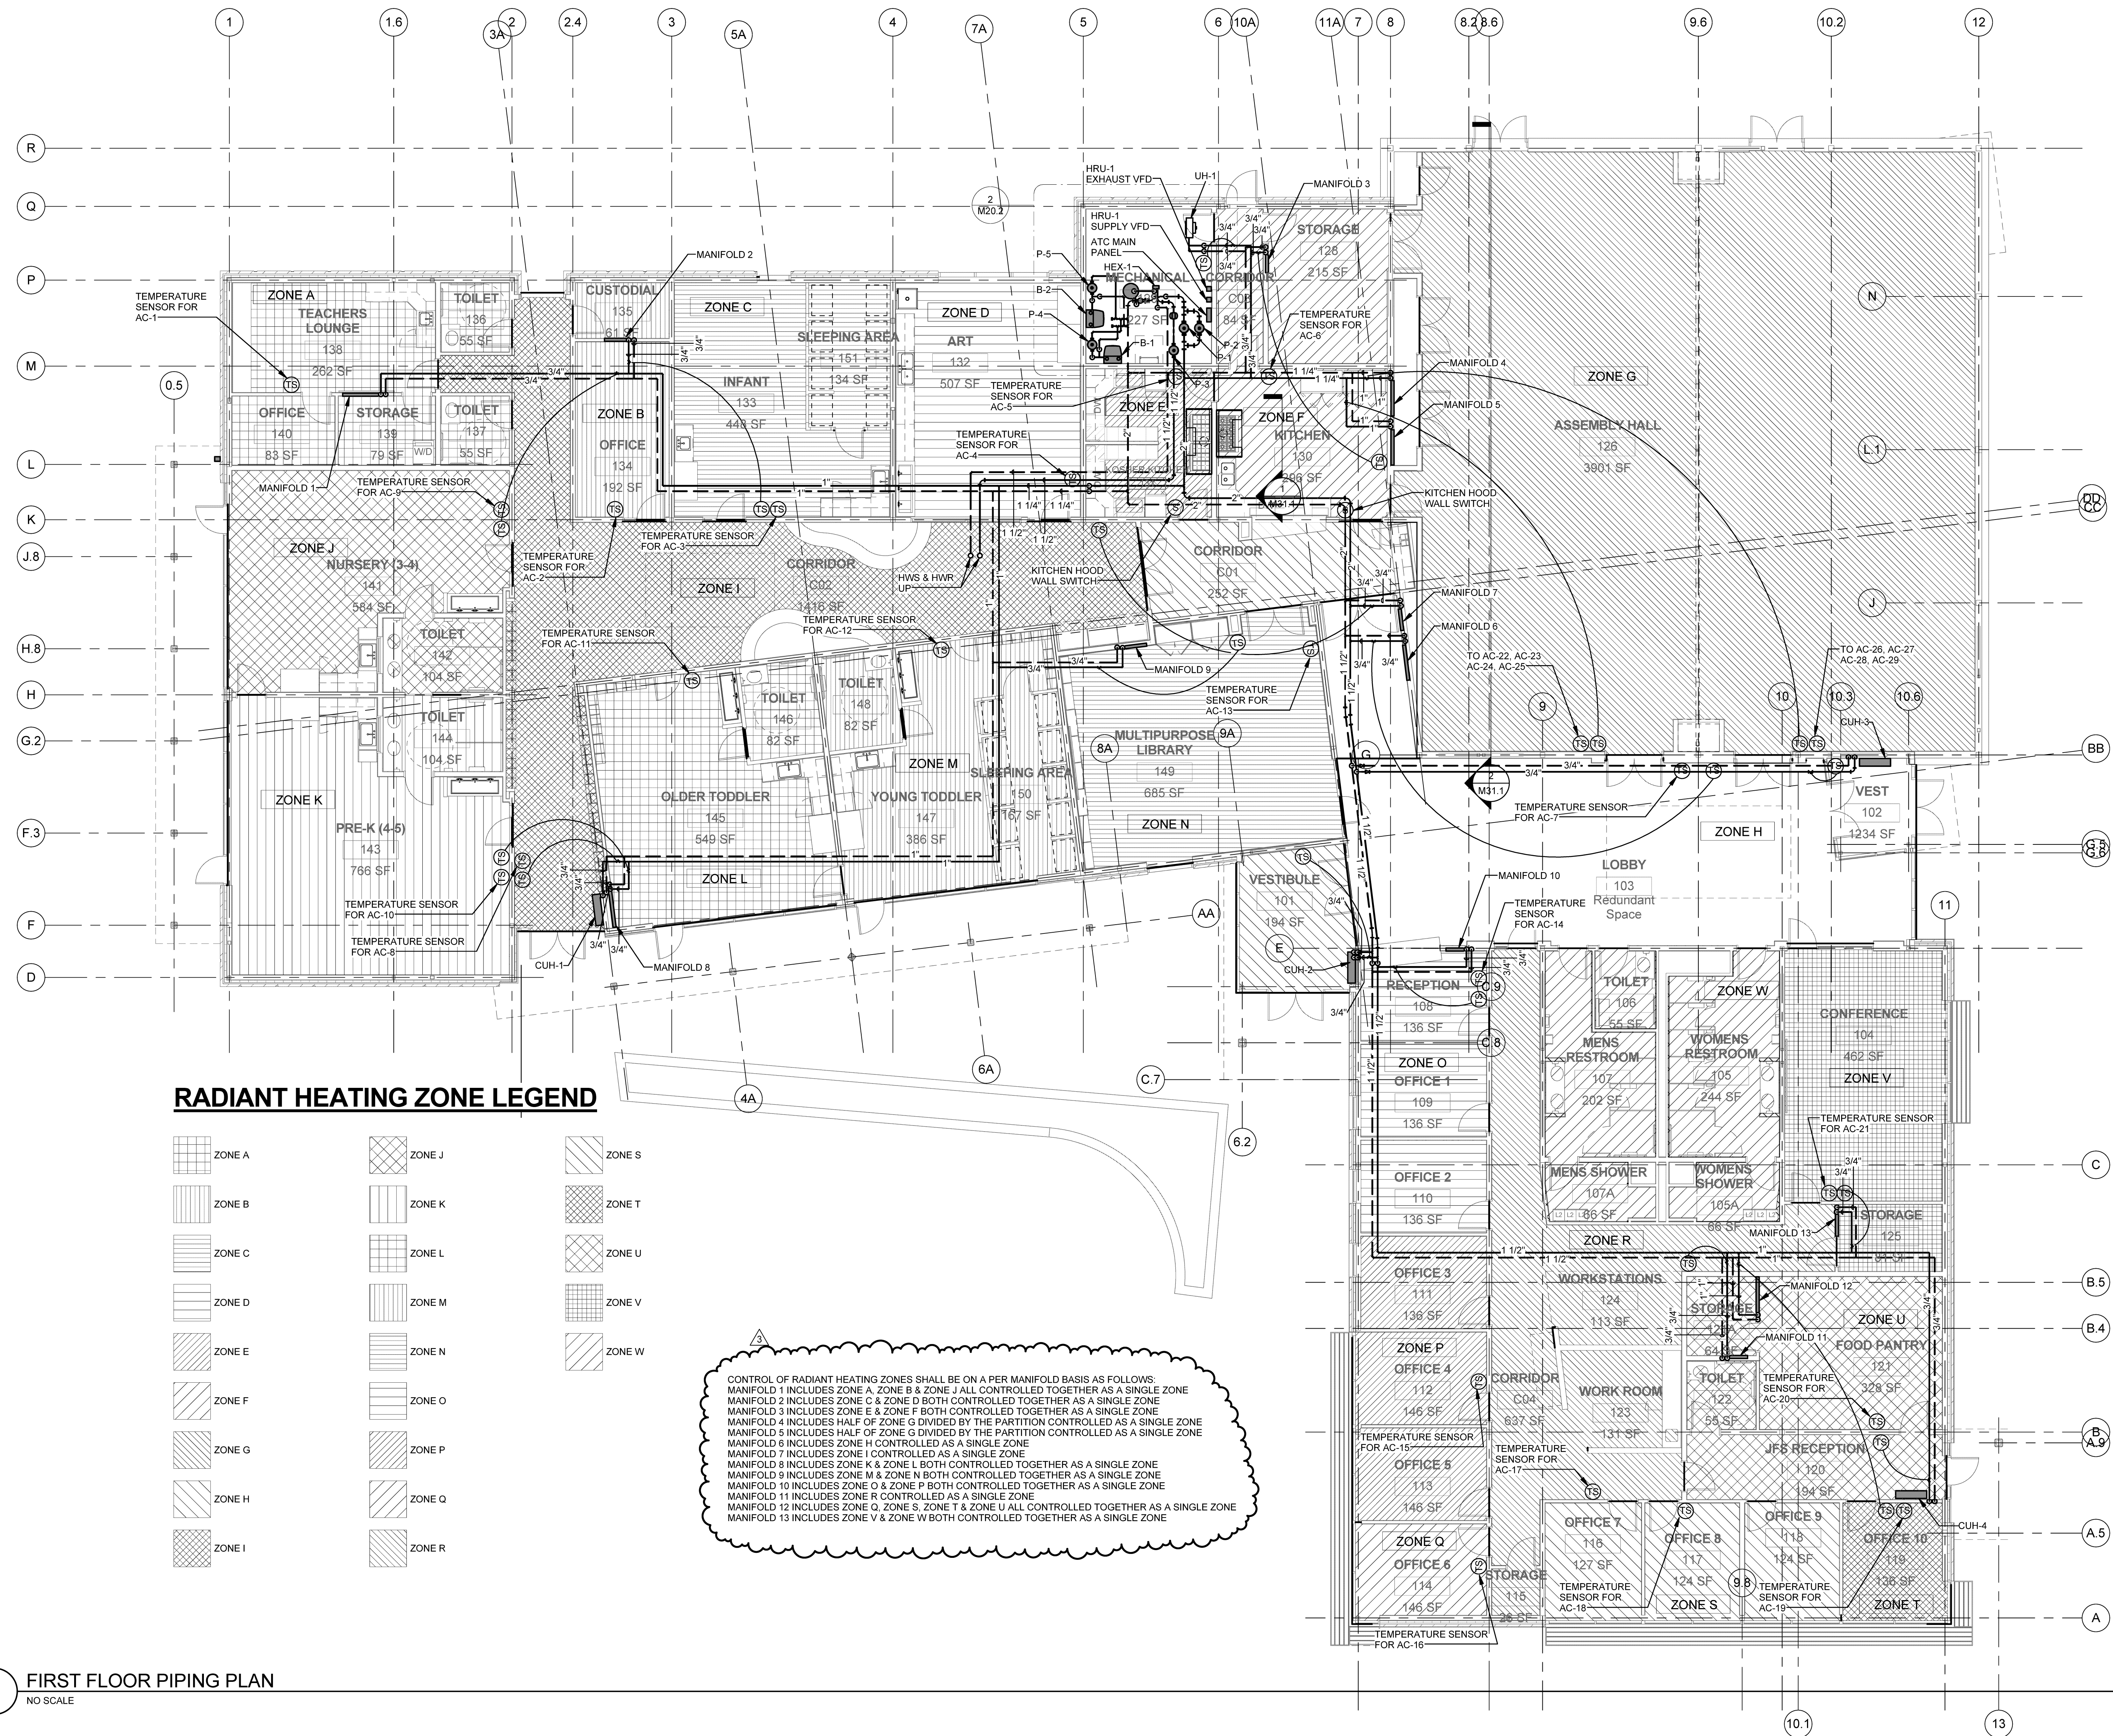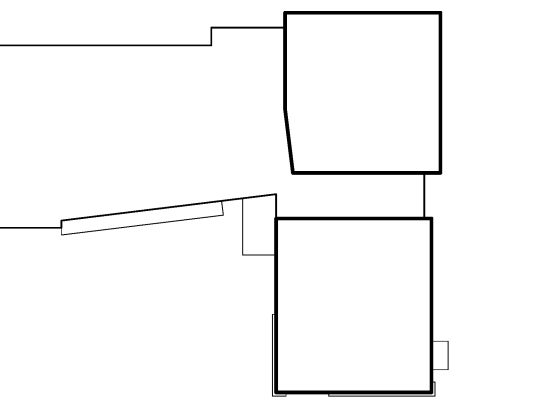


RADIANT HEATING ZONE LEGEND

CONTROL OF RADIANT HEATING ZONES SHALL BE ON A PER MANIFOLD BASIS AS FOLLOWS:
 MANIFOLD 1 INCLUDES ZONE A, ZONE B & ZONE J ALL CONTROLLED TOGETHER AS A SINGLE ZONE
 MANIFOLD 2 INCLUDES ZONE C & ZONE D BOTH CONTROLLED TOGETHER AS A SINGLE ZONE
 MANIFOLD 3 INCLUDES ZONE E & ZONE F BOTH CONTROLLED TOGETHER AS A SINGLE ZONE
 MANIFOLD 4 INCLUDES HALF OF ZONE G DIVIDED BY THE PARTITION CONTROLLED AS A SINGLE ZONE
 MANIFOLD 5 INCLUDES HALF OF ZONE G DIVIDED BY THE PARTITION CONTROLLED AS A SINGLE ZONE
 MANIFOLD 6 INCLUDES ZONE H CONTROLLED AS A SINGLE ZONE
 MANIFOLD 7 INCLUDES ZONE I CONTROLLED AS A SINGLE ZONE
 MANIFOLD 8 INCLUDES ZONE K & ZONE L BOTH CONTROLLED TOGETHER AS A SINGLE ZONE
 MANIFOLD 9 INCLUDES ZONE M & ZONE N BOTH CONTROLLED TOGETHER AS A SINGLE ZONE
 MANIFOLD 10 INCLUDES ZONE O & ZONE P BOTH CONTROLLED TOGETHER AS A SINGLE ZONE
 MANIFOLD 11 INCLUDES ZONE R CONTROLLED AS A SINGLE ZONE
 MANIFOLD 12 INCLUDES ZONE Q, ZONE S, ZONE T & ZONE U ALL CONTROLLED TOGETHER AS A SINGLE ZONE
 MANIFOLD 13 INCLUDES ZONE V & ZONE W BOTH CONTROLLED TOGETHER AS A SINGLE ZONE

1 FIRST FLOOR PIPING PLAN
NO SCALE

Mark	Date	Description
	09-04-15	DESIGN DEVELOPMENT REVIEW
	03-25-16	CONSTRUCTION DOCUMENTS
3	07-22-16	CONFORMANCE SET

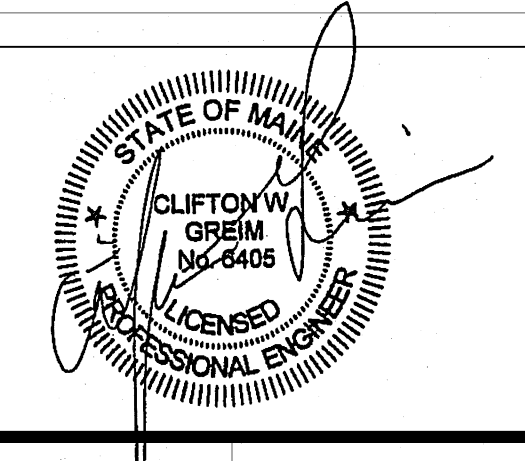

Drawing Scale: 1/8" = 1'-0"

PA/PE: CG © 2016 Harriman Associates
Drawn By: JSL

FIRST FLOOR RADIANT FLOOR PIPING PLAN

M20.1