



HARRIMAN



AUBURN PORTLAND MANCHESTER

JEWISH COMMUNITY ALLIANCE OF SOUTHERN MAINE


PORTLAND, ME

Harriman Project No. 15309

Key Plan Proj North

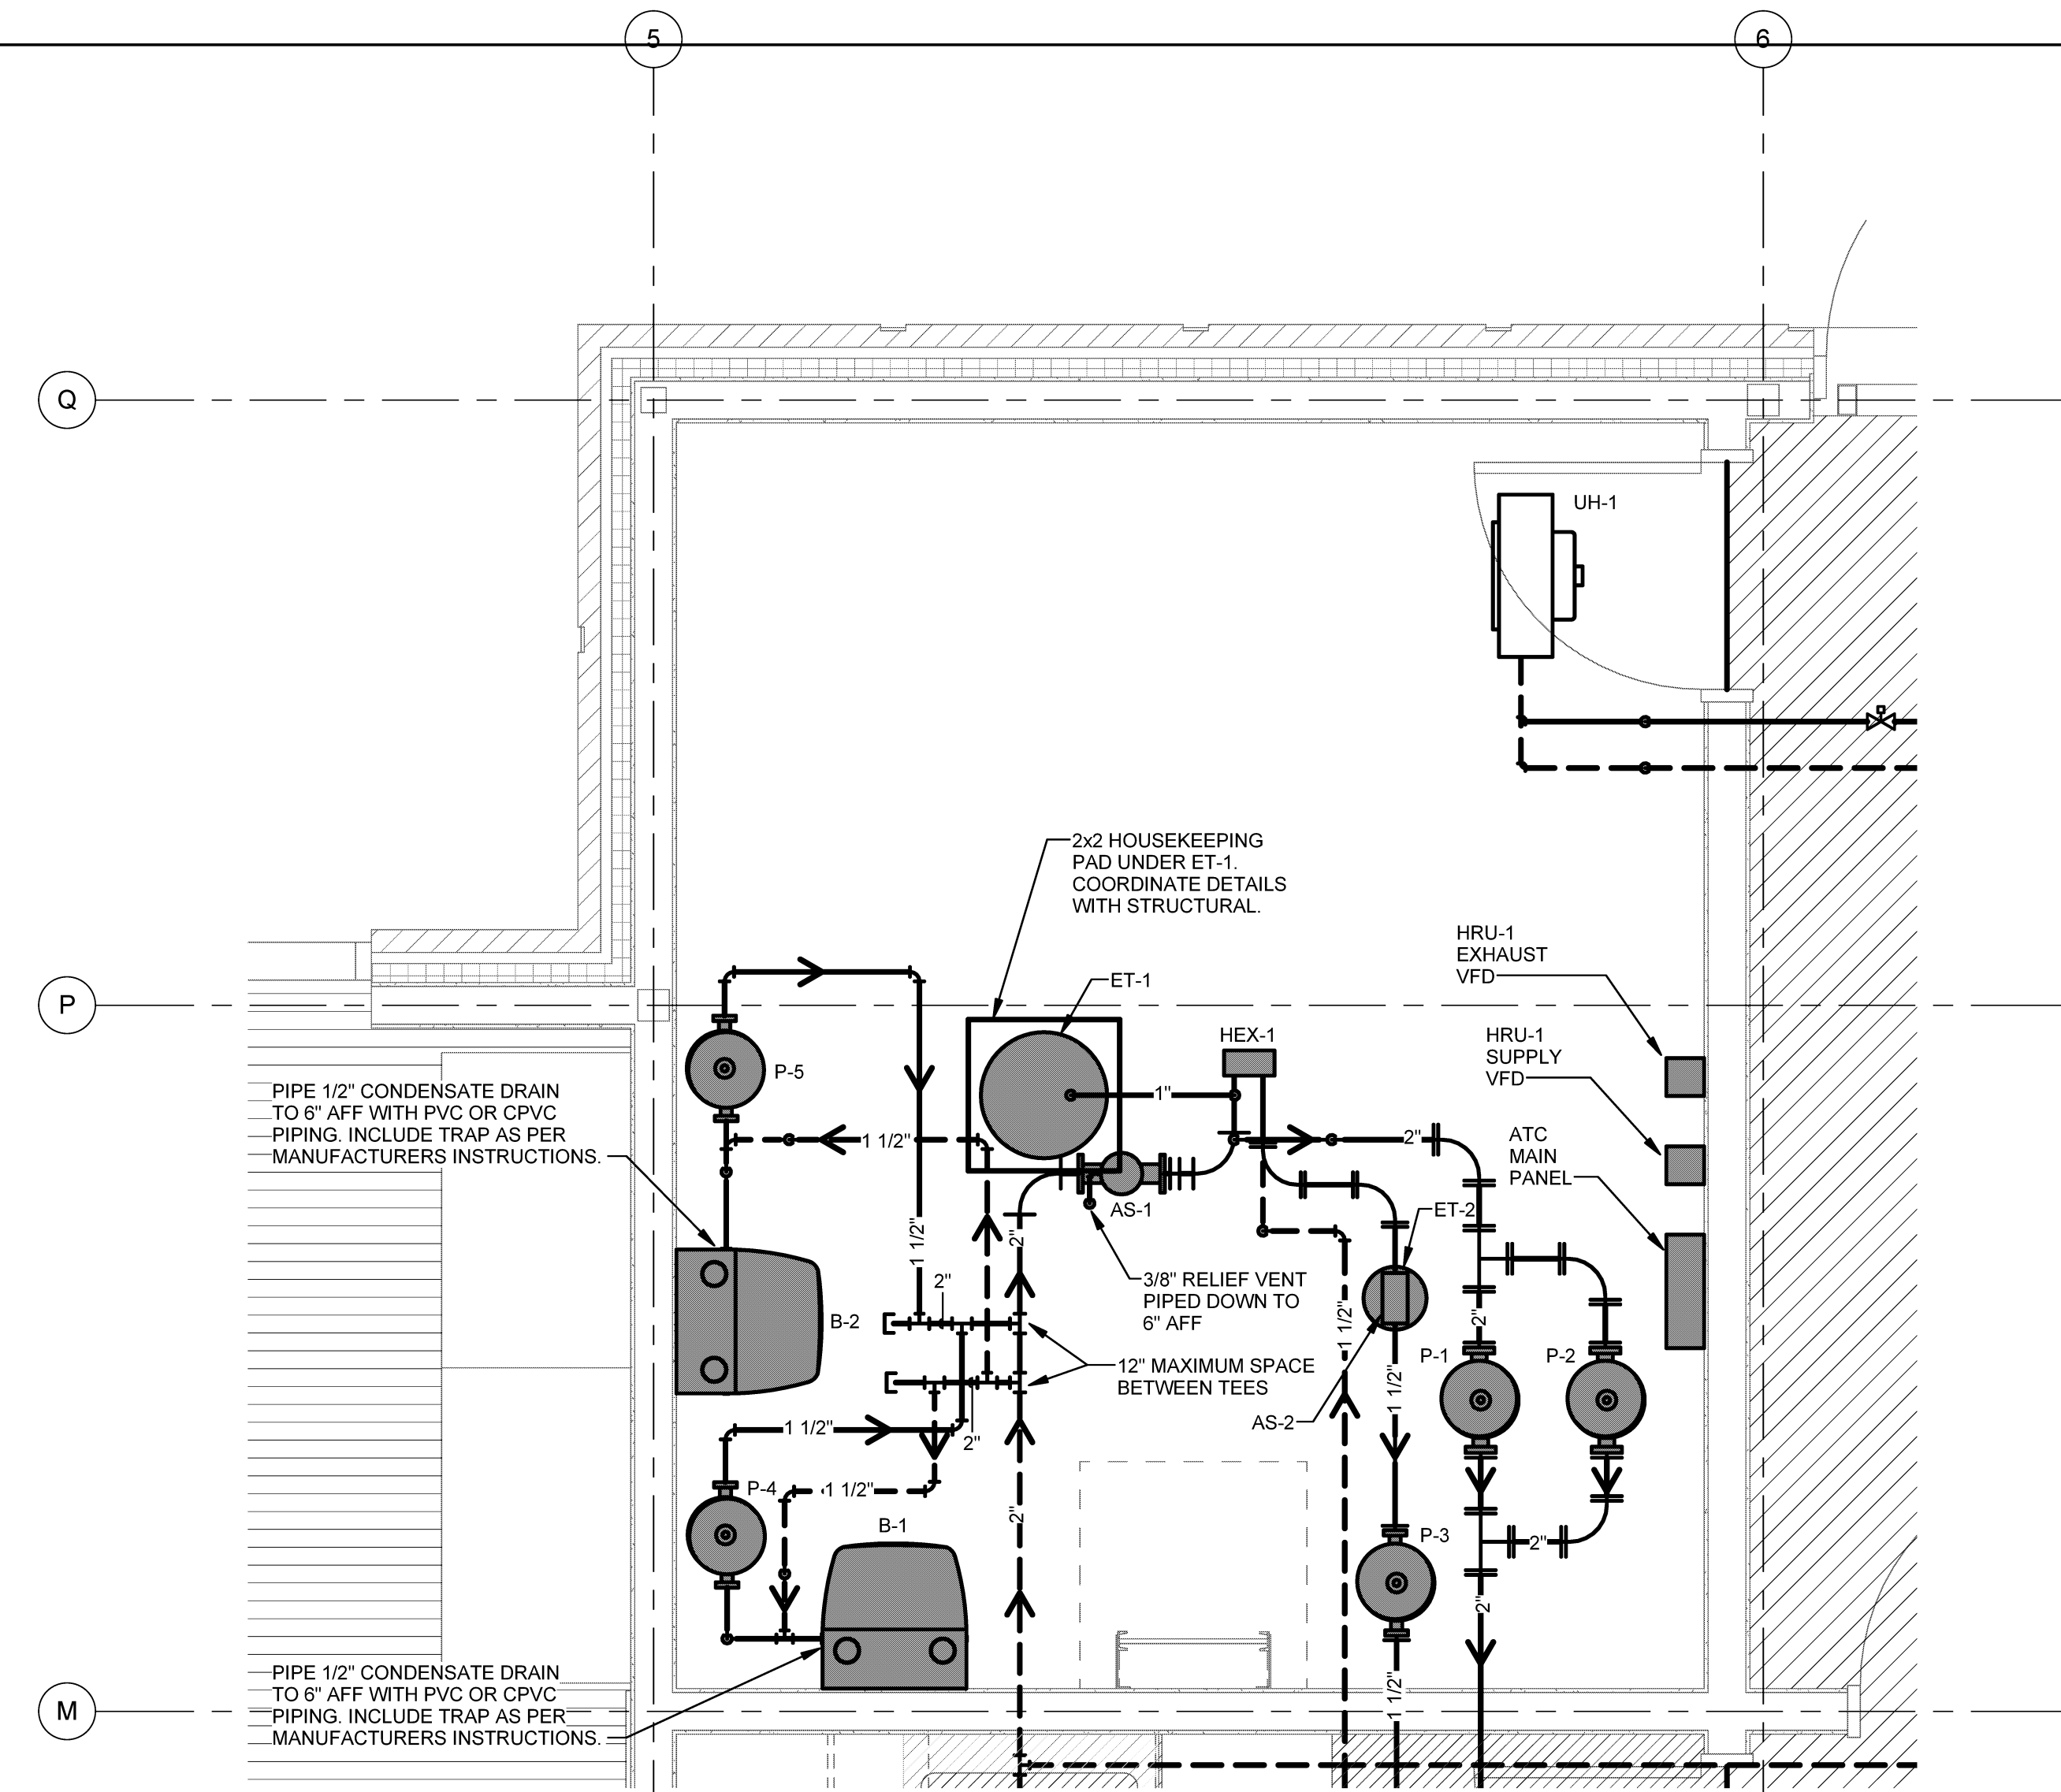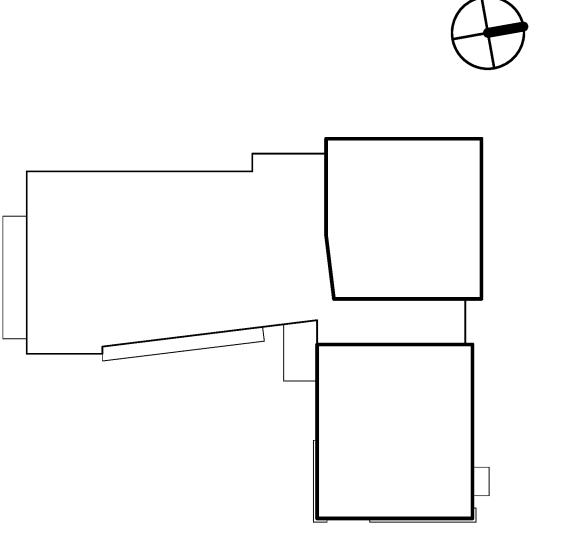


2 MECHANICAL ROOM PART PLAN NO SCALE

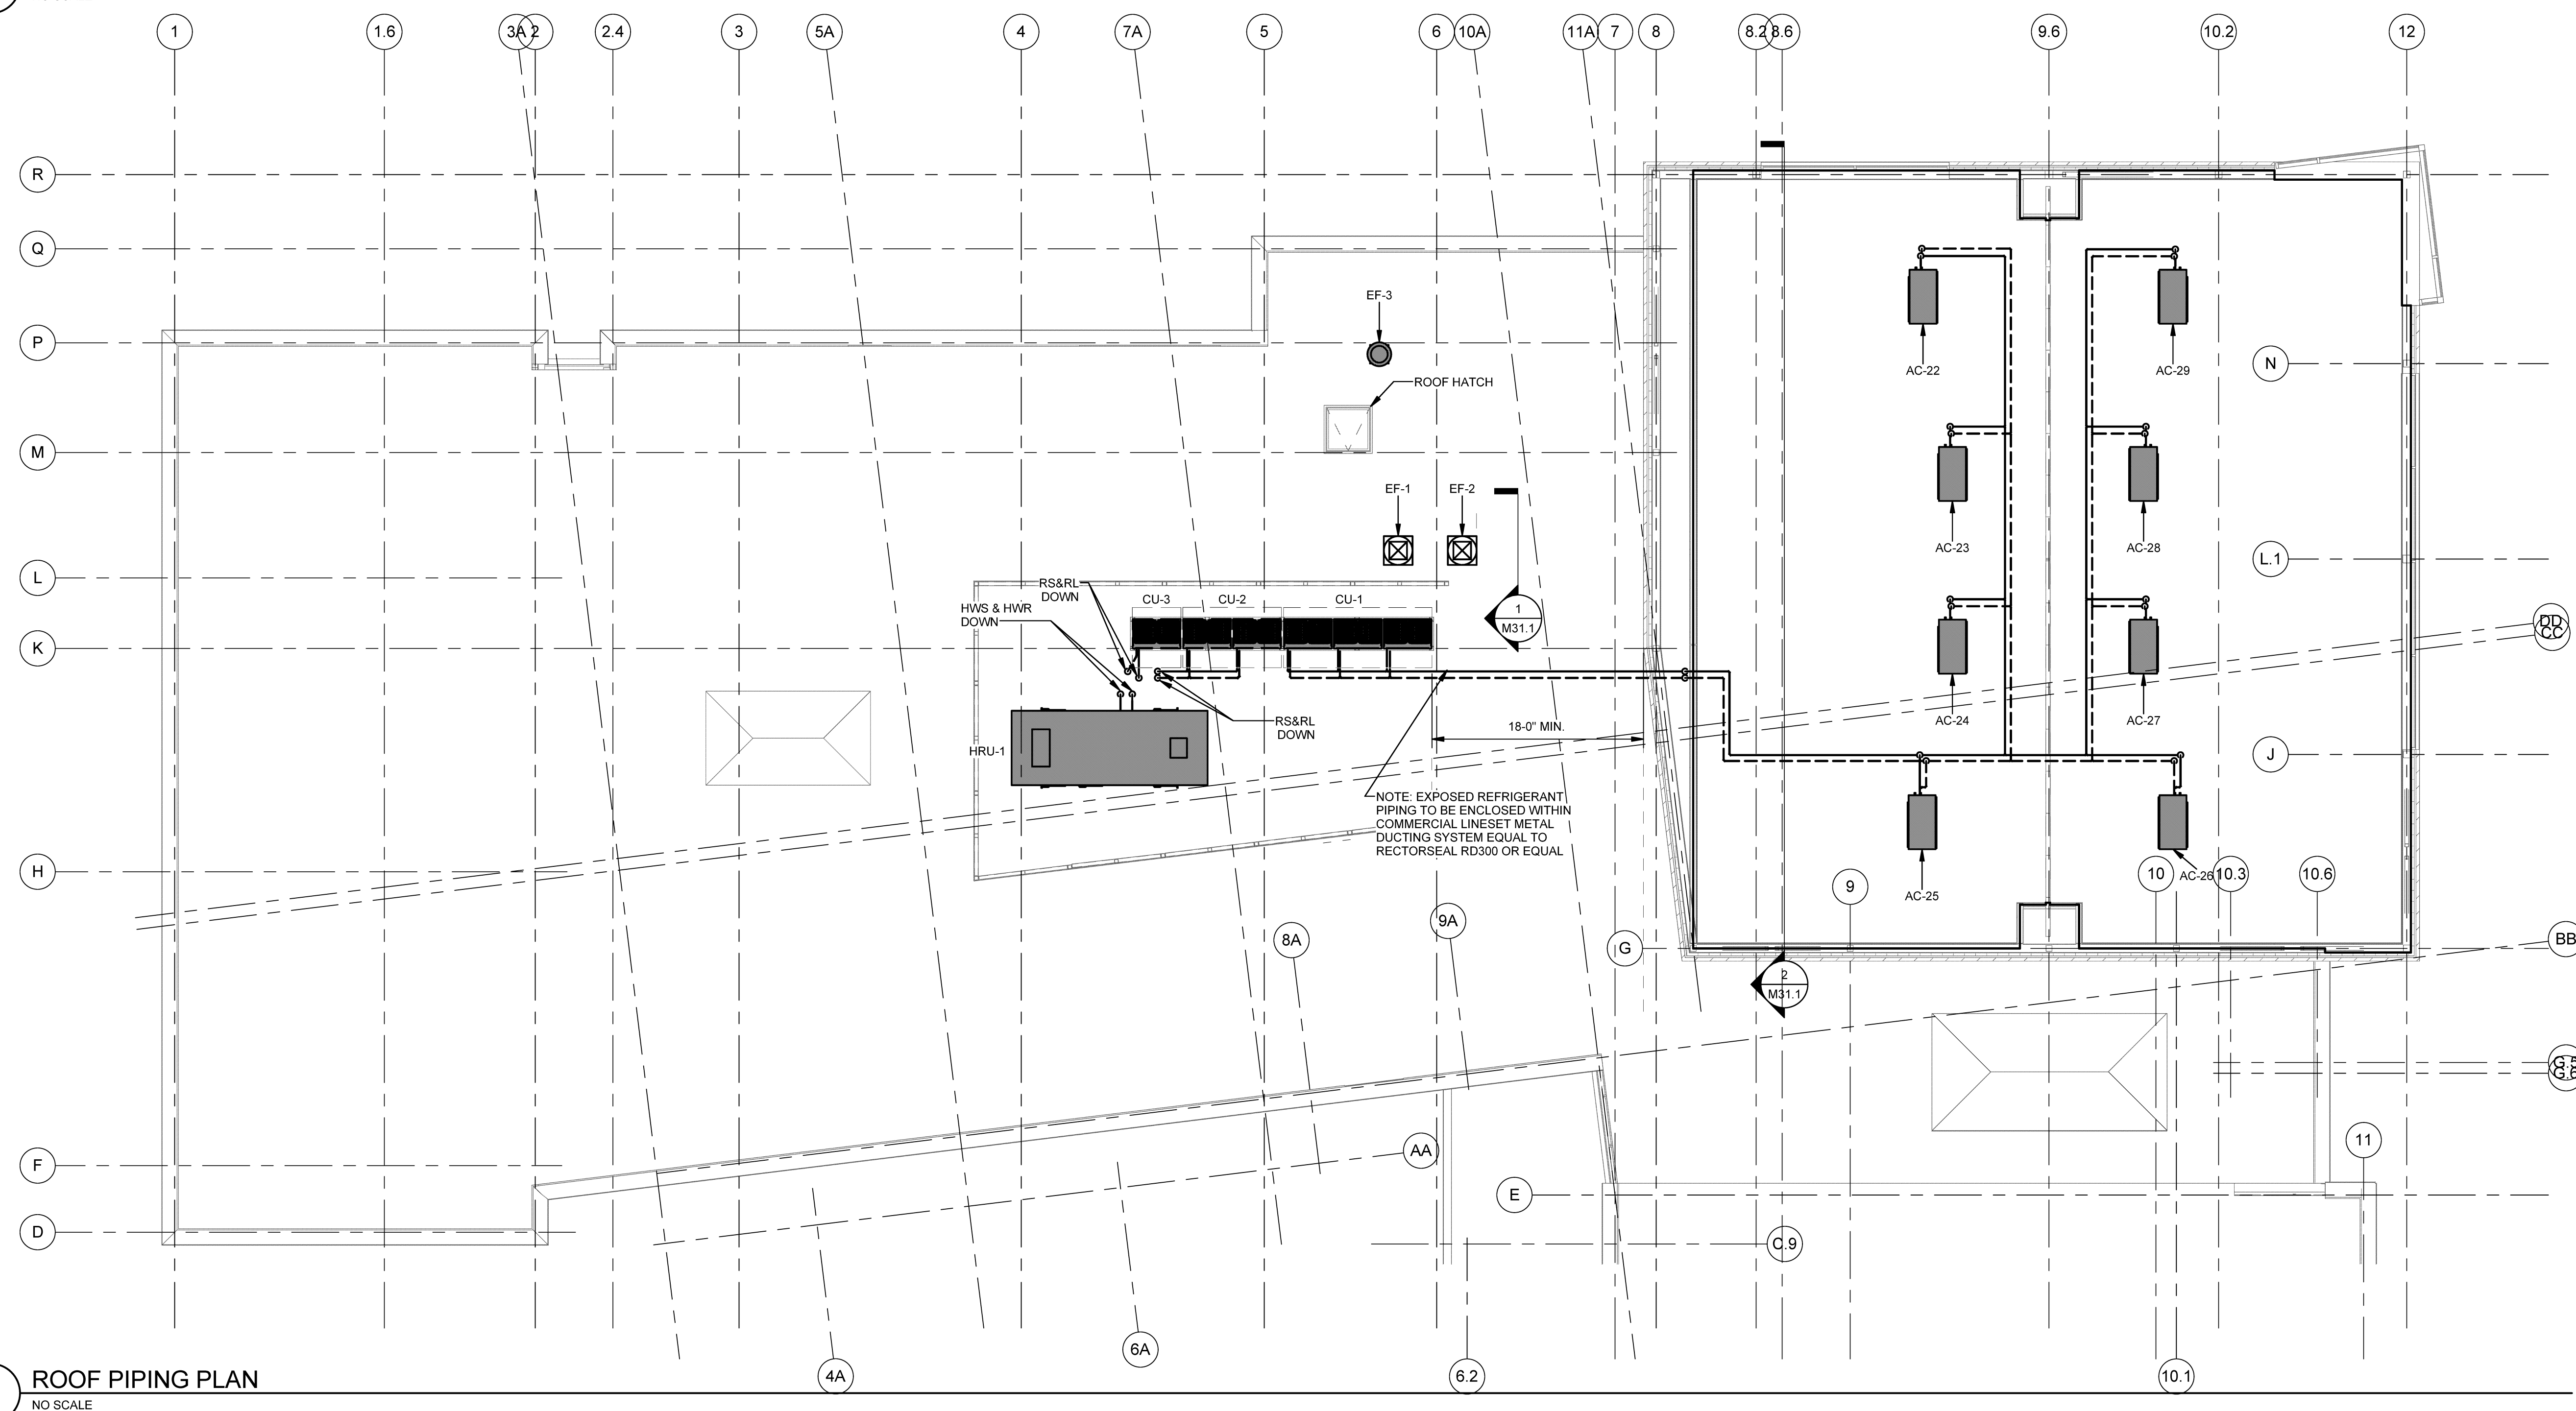

1 ROOF PIPING PLAN NO SCALE

Mark	Date	Description
09-04-15	DESIGN DEVELOPMENT REVIEW	
03-25-16	CONSTRUCTION DOCUMENTS	
2	04-27-16	ADDENDUM #3
3	07-22-16	CONFORMANCE SET

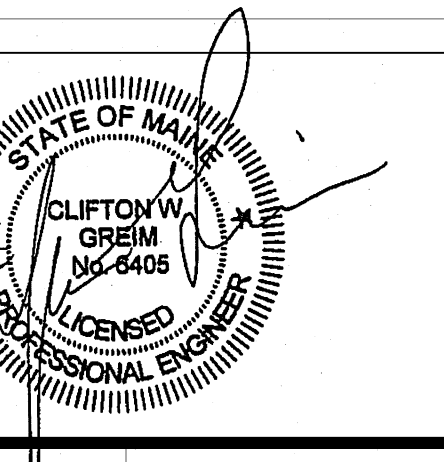

Drawing Scales As indicated

PA/PE: CG © 2016 Harriman Associates  
Drawn By: JSL

PIPING PART PLANS

M20.2