


# 4X-LCD

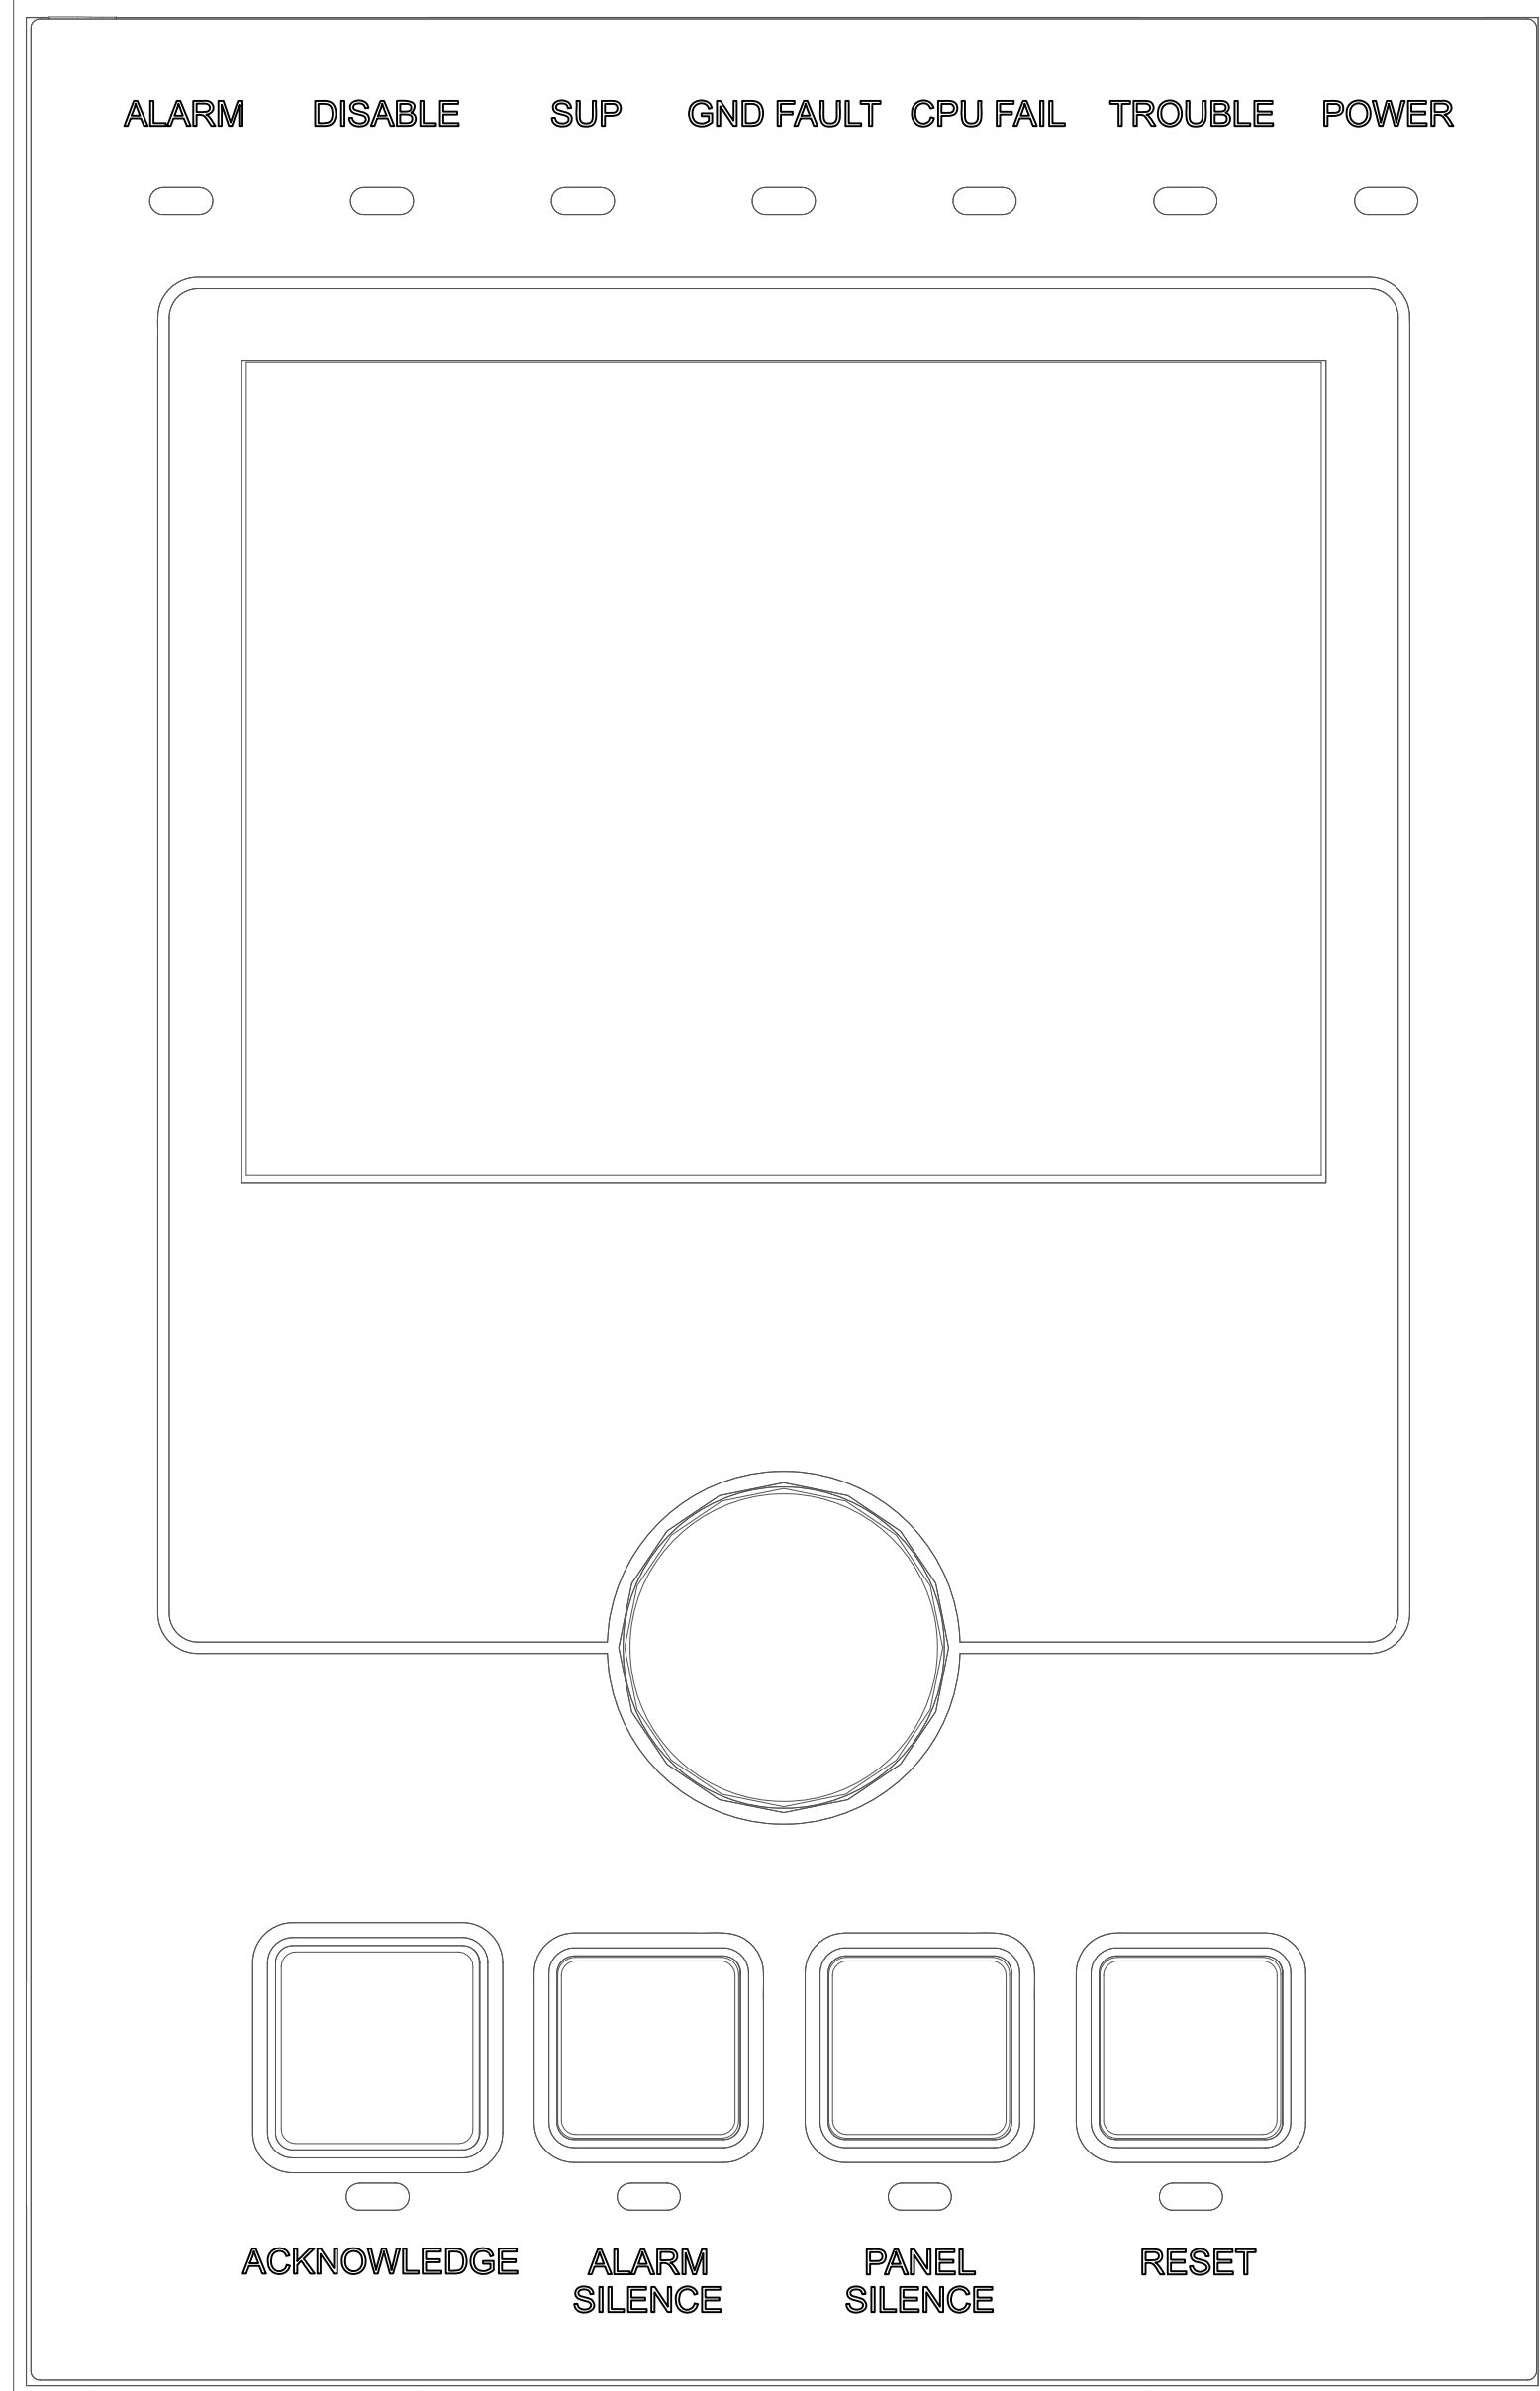

## Panel Wiring Diagram

SCALE: NTS

REV.	DESCRIPTION	DATE	DRWN:	RYW'D:
0	Original Issue	1/17	KMB	TRD

PO No. \_\_\_\_\_  
 Jewish Community Alliance  
 of Southern Maine  
 Portland, Maine  
 FIRE ALARM RISER  
 DWG No. FA-002

JOB NAME: **Jewish Community Alliance of Southern Maine**  
 57 Ashmount ST  
 Portland, Maine  
**Fire Alarm Panel Layout**

**R.B. Allen Co., Inc.**  
 P.O. BOX 170  
 131 LAKE AVENUE  
 NO. HAMPTON, NH 03862  
 1-800-258-7284

DWG NAME: **Jewish Community Center**  
 57 Ashmont St  
 Portland, ME  
**Fire Alarm Panel Layout**  
 DWG No. FA-002