




Rev Date: 05/24/2016 4:26:51 PM

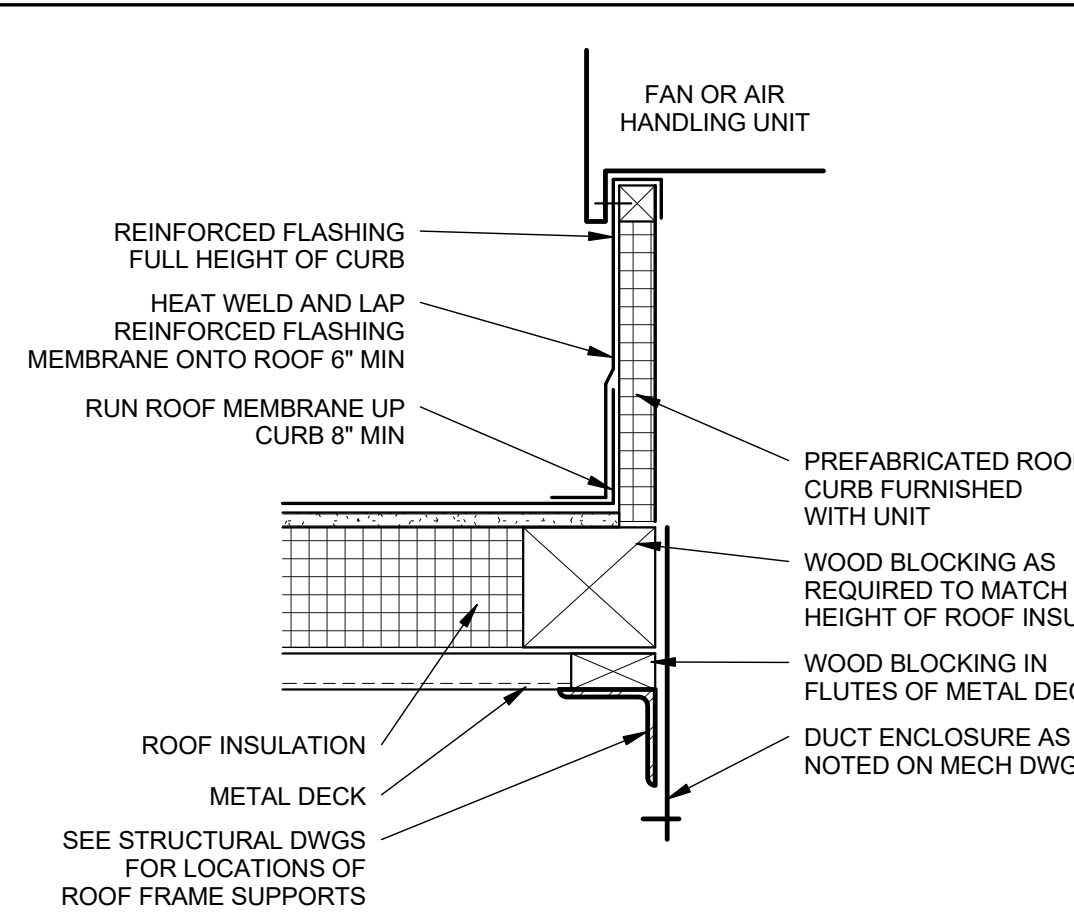


E1 MECH HOOD/EXHAUST CURB, TYP
SCALE: 1 1/2" = 1'-0"

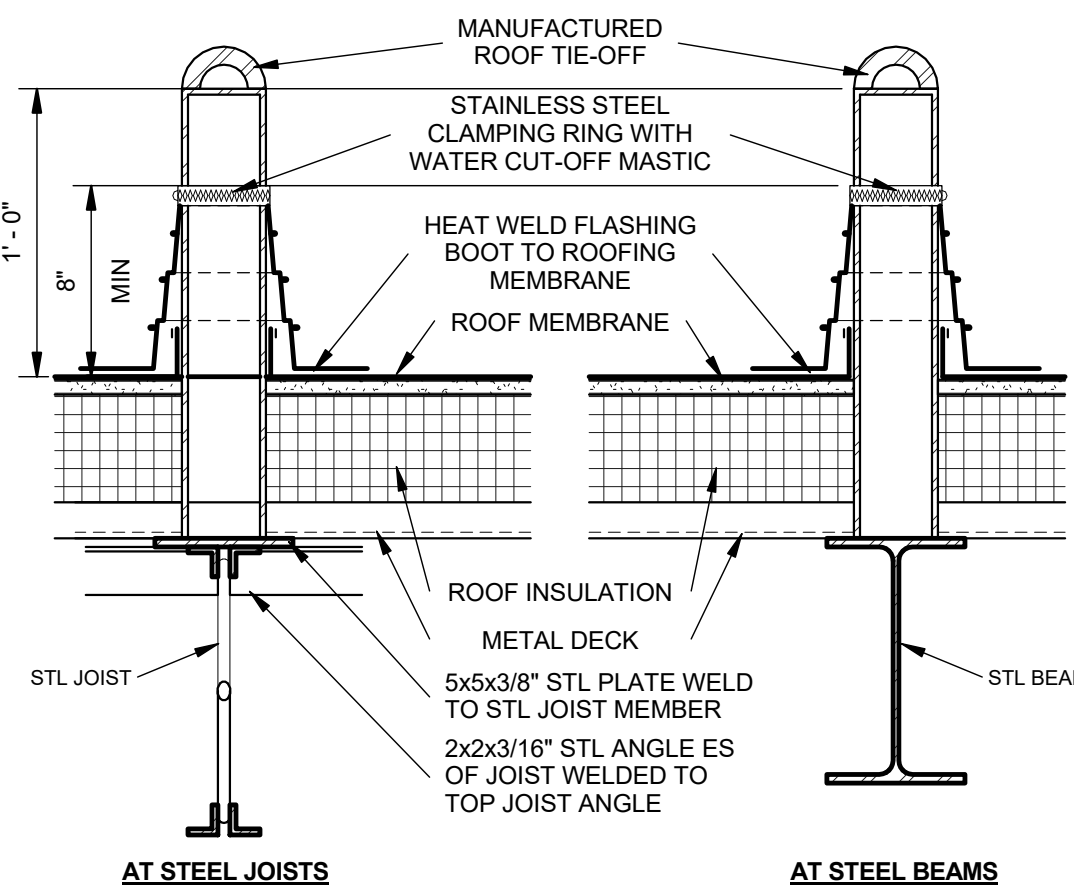


D1 ROOF TIE-OFF DETAIL, TYP
SCALE: 1 1/2" = 1'-0"

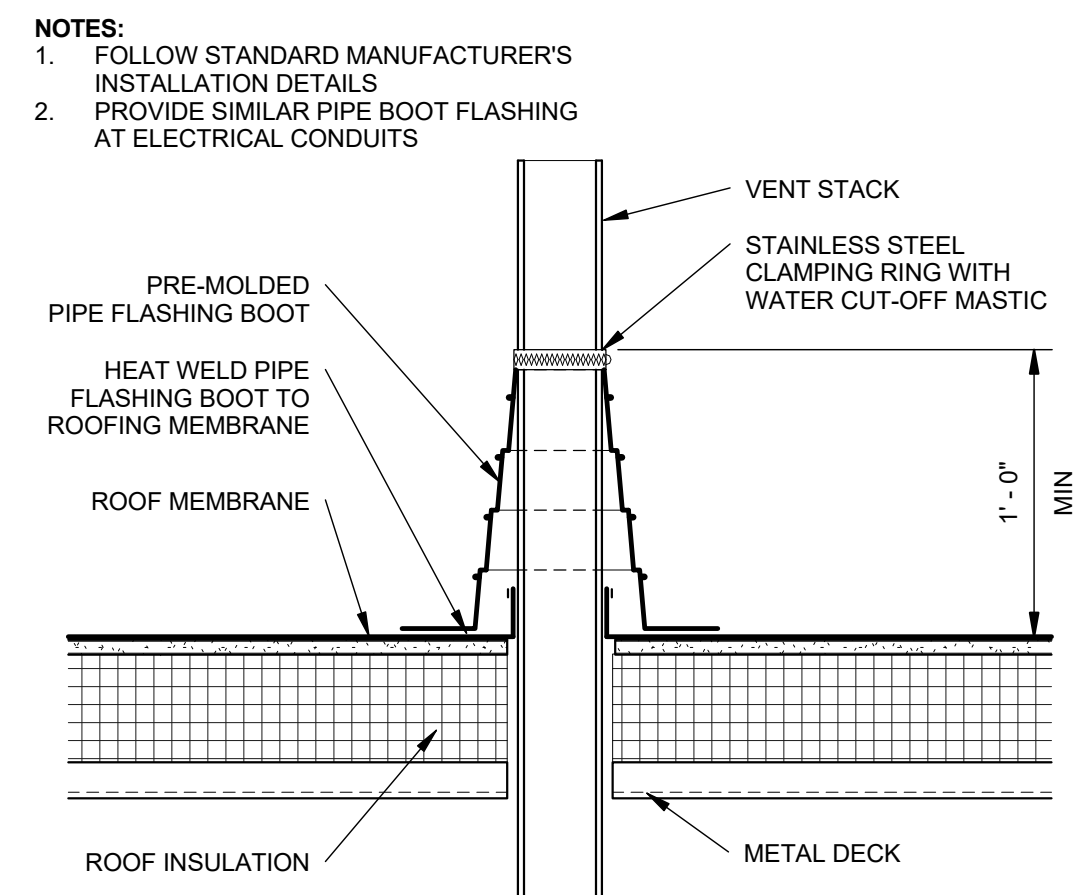


C1 VENT STACK DETAIL, TYP
SCALE: 1 1/2" = 1'-0"

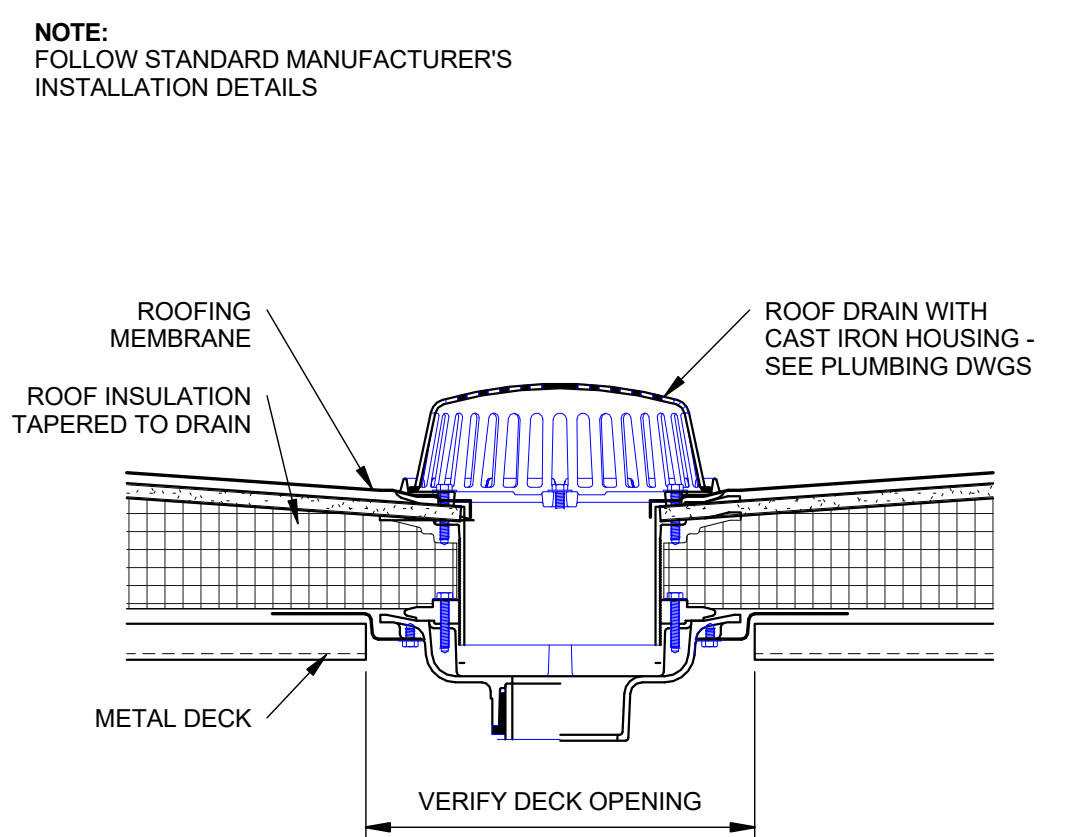


B1 ROOF DRAIN DETAIL, TYP
SCALE: 1 1/2" = 1'-0"

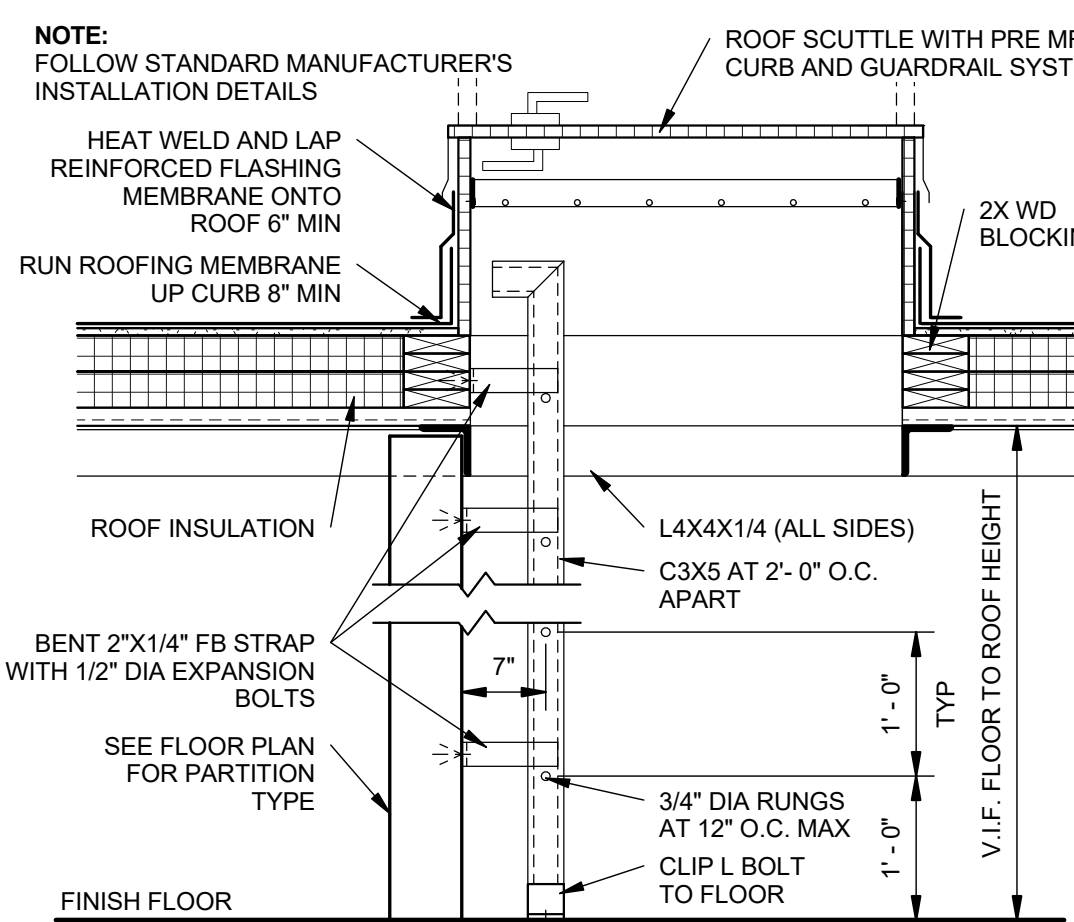


A1 ROOF SCUTTLE DETAIL
SCALE: 3/4" = 1'-0"

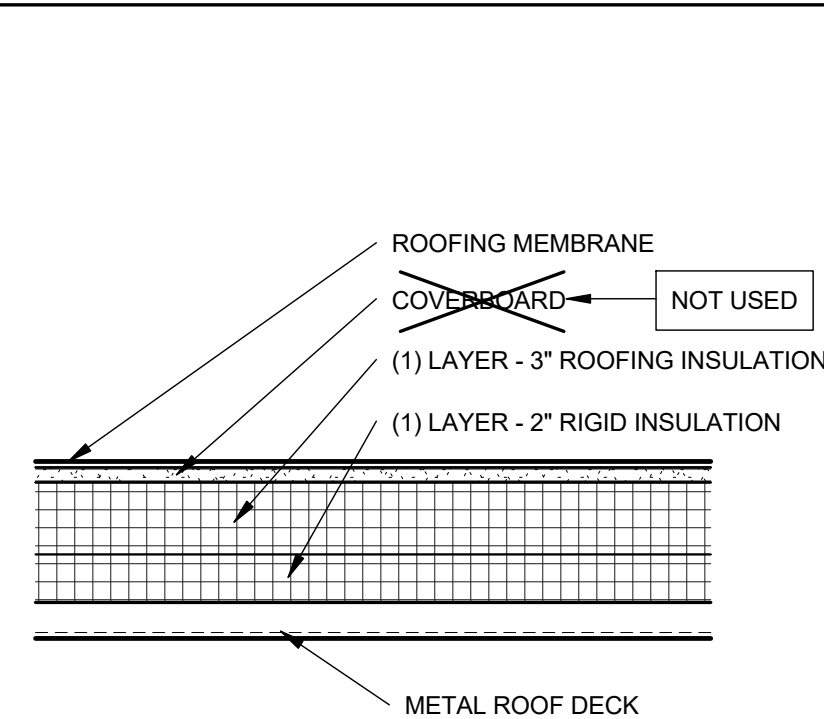


ROOF SYSTEM - R1 (SLOPED STEEL)

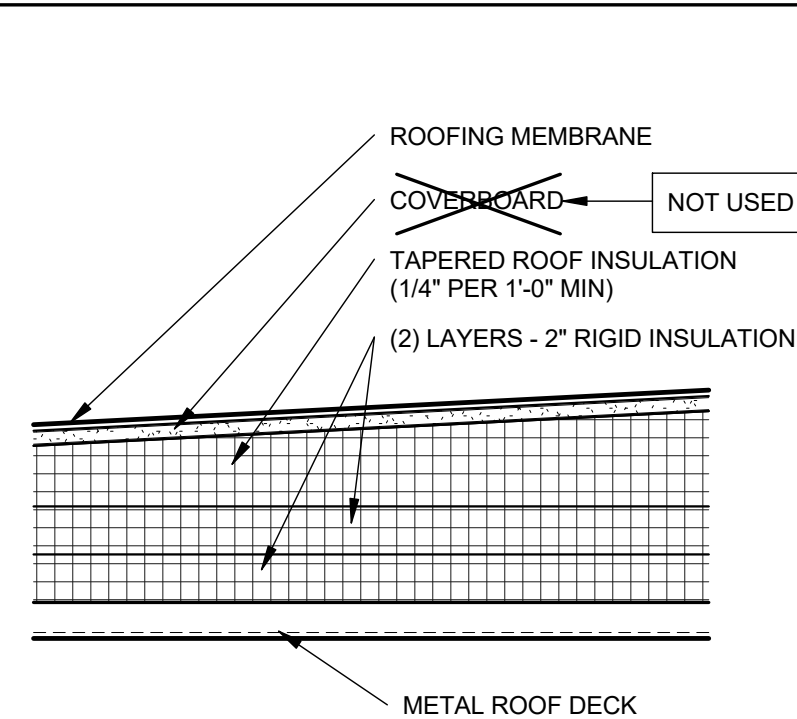


ROOF SYSTEM - R2 (TAPERED INSULATION)

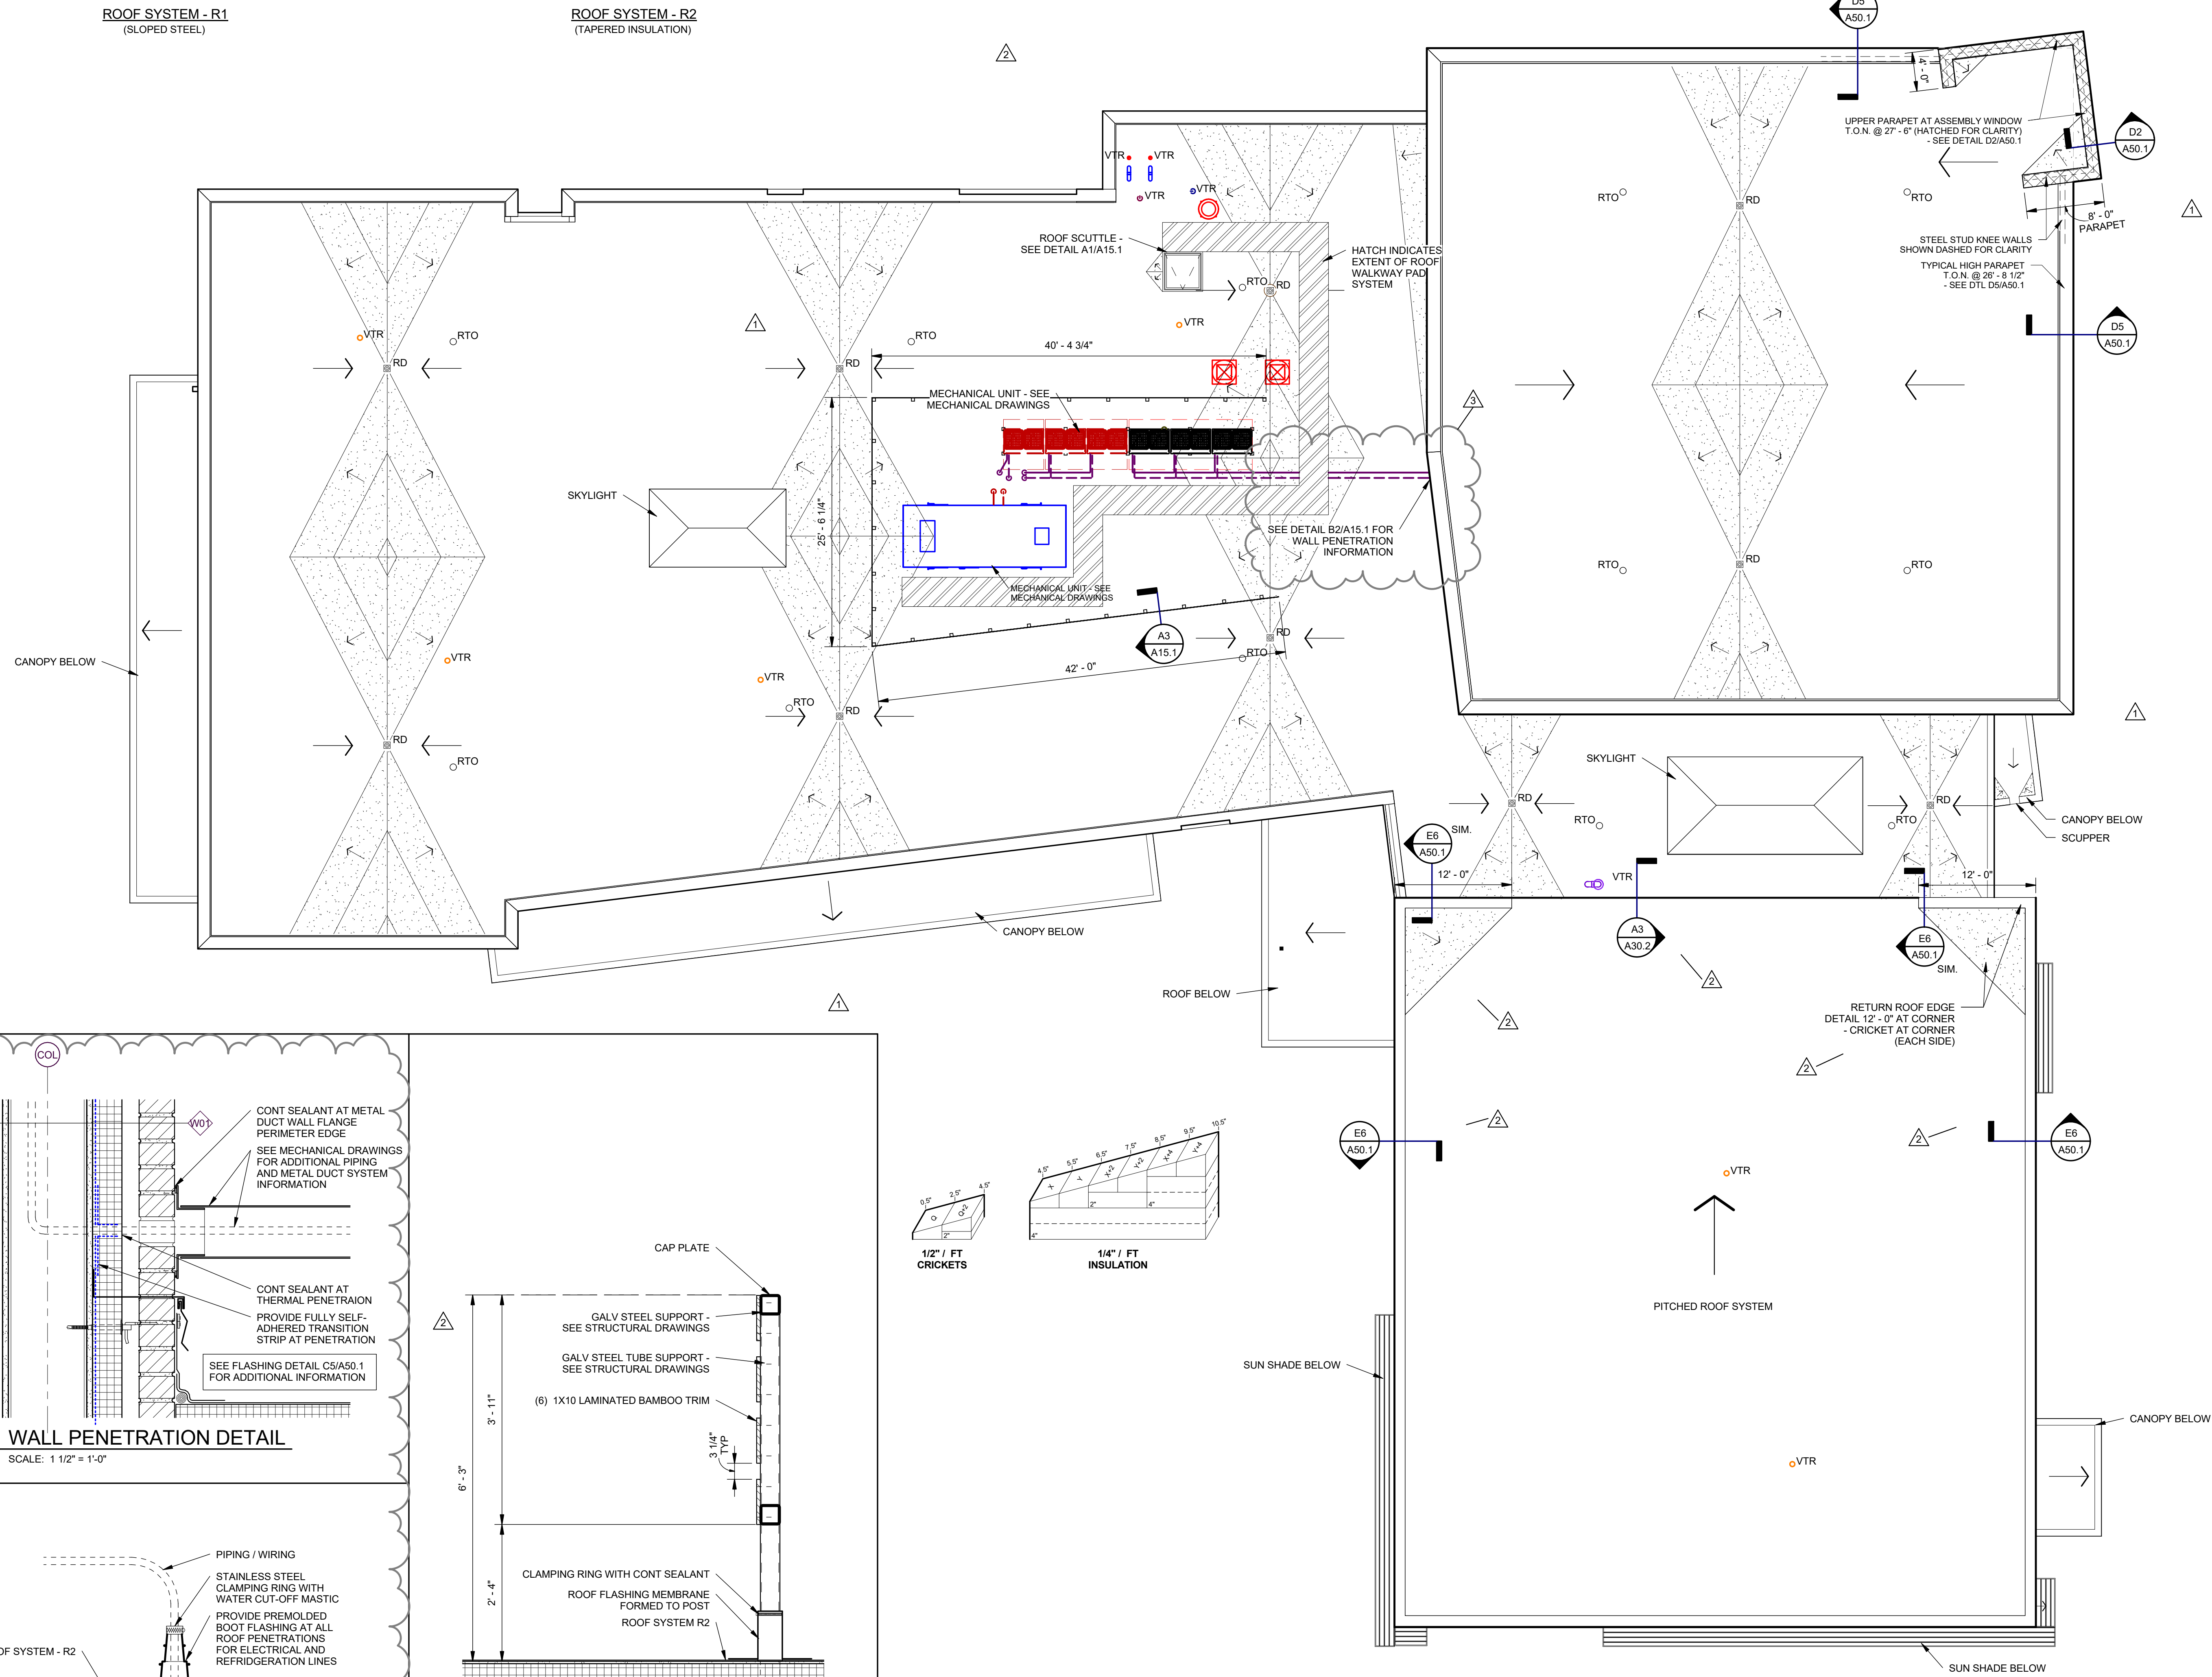


B2 WALL PENETRATION DETAIL
SCALE: 1 1/2" = 1'-0"

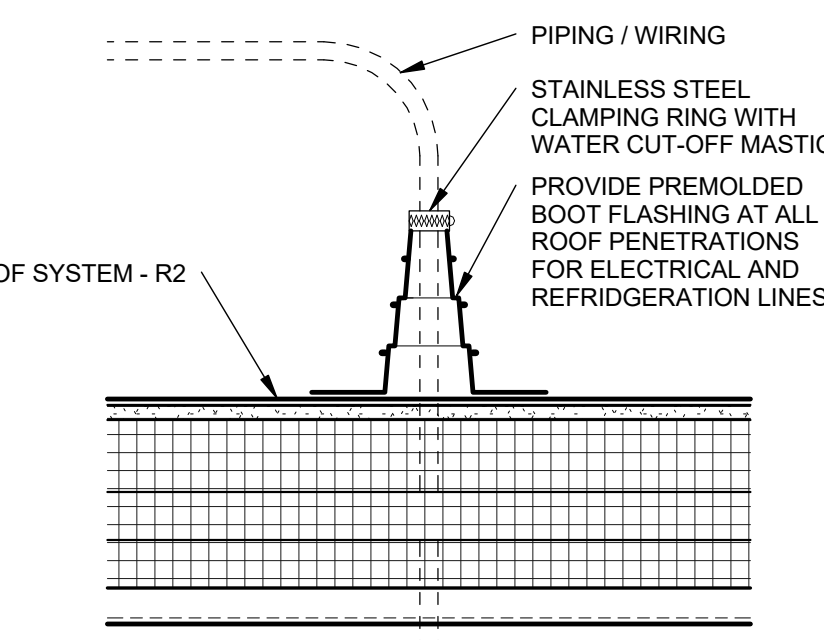

A2 ROOF PENETRATION DETAIL, TYP
SCALE: 1 1/2" = 1'-0"

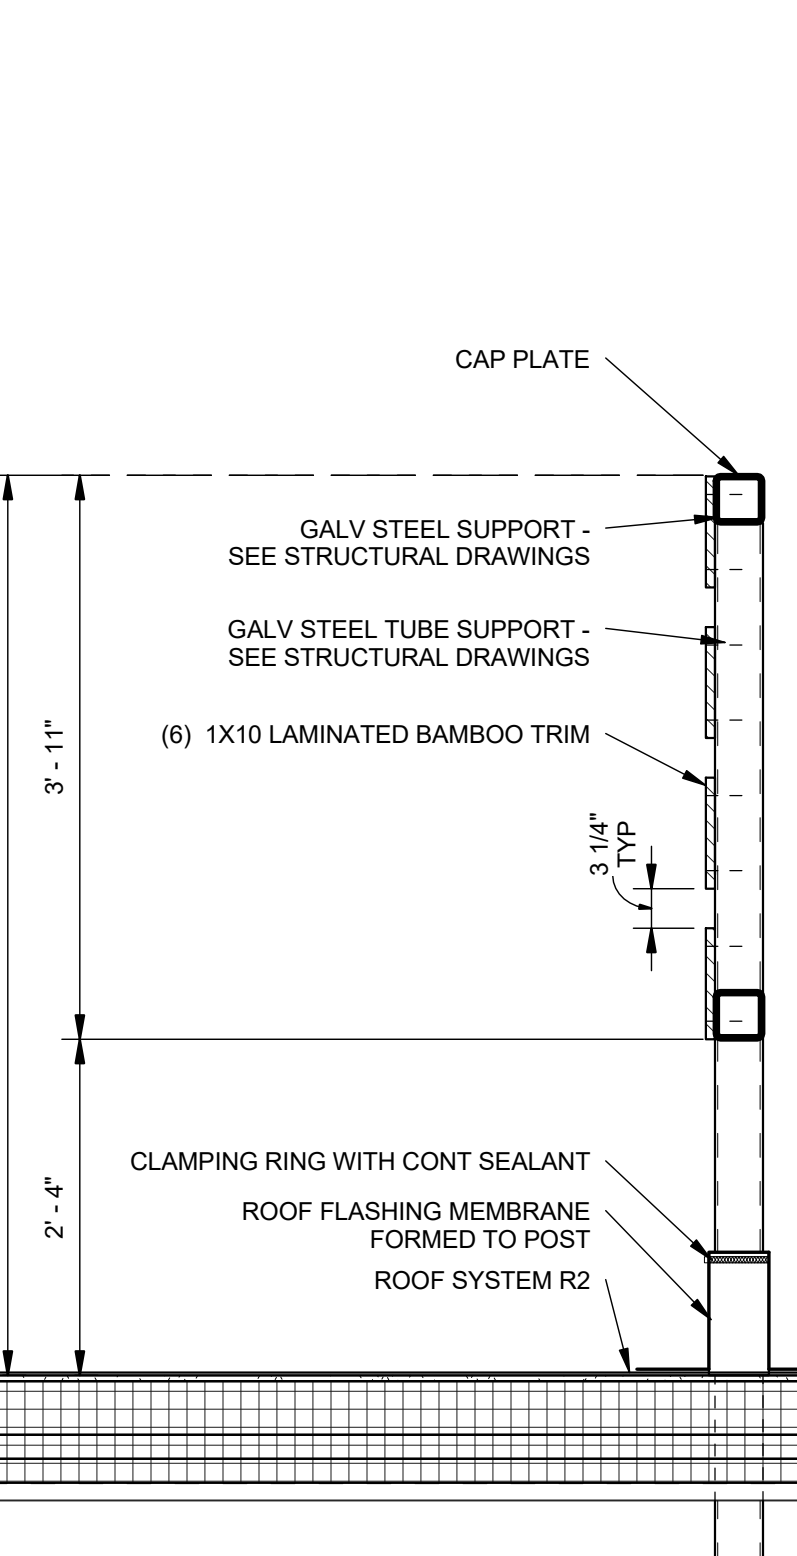

A3 ROOF SCREEN DETAIL
SCALE: 3/4" = 1'-0"

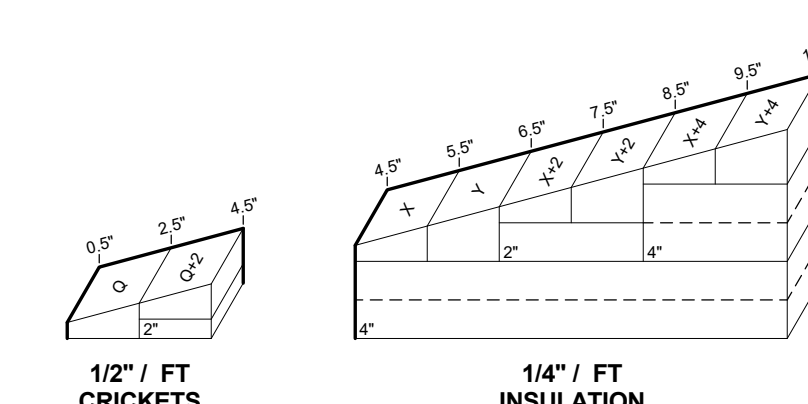

A4 ROOF PLAN
SCALE: 1/8" = 1'-0"

JEWISH COMMUNITY ALLIANCE OF SOUTHERN MAINE

PORTLAND, ME	
Harriman Project No.	15309
Key Plan	Proj North

GENERAL NOTES

1. PROVIDE CRICKET INSULATION AT MECHANICAL CURB LOCATIONS WHERE UNIT IS BETWEEN HIGH POINT OF ROOF AND ROOF DRAINS.
2. COORDINATE ALL ROOF PENETRATIONS WITH MECHANICAL, PLUMBING, AND ELECTRICAL DRAWINGS.

LEGEND

	DIRECTION OF SLOPE
	MECHANICAL UNIT
	ROOF TYPE MARKER
	VENT THROUGH ROOF
	ROOF DRAIN
	ROOF TIE-OFF
	TAPERED INSULATION CRICKET

Issues and Revisions		
Mark	Date	Description
-	07-22-15	SCHEMATIC REVIEW
-	07-24-15	REVISED SCHEMATIC REVIEW
-	08-04-15	DESIGN DEVELOPMENT REVIEW
-	03-25-16	CONSTRUCTION DOCUMENTS
1	04-15-16	ADDENDUM #1
2	04-21-16	ADDENDUM #2
3	05-04-16	ADDENDUM #4
4	06-24-16	REVISED FOR PB SUBMISSION

PRELIMINARY NOT FOR CONSTRUCTION

Drawing Scales	
As indicated	
PA / PE: MDL	© 2016 Harriman Associates
Drawn By: JAE	

ROOF PLAN

A15.1