


KEY NOTES:


P01...J-BOX LOCATED ABOVE CEILING FOR HEAT TRACE CABLES ON ROOF LEADERS, MAKE CONNECTIONS AS REQUIRED. WIRE TO CONTRACTOR SUPPLIED 30MA GFCI CIRCUIT BREAKER - CONTROL ALL CIRCUITS FROM RELAYS IN COMMON ELECTRICAL SPACE. COORDINATE EXACT LOCATION WITH OWNER'S REP. PROVIDE TOGGLE SERVICE SWITCH ON JUNCTION BOX. STUB CABLE TO MINIMUM 6" ABOVE FINISHED ROOF SURFACE IN CONCEALED LOCATION. SEAL ALL PENETRATIONS. RUN ON ROOF TO DRAIN AS INDICATED.

P02...PROVIDE JUNCTION BOX(ES) ABOVE ACCESSIBLE CEILING. LOCATE TO SERVE FUTURE SIGNAGE. CONNECT TO ASSOCIATED RETAIL SPACE PANELBOARD VIA ASSOCIATED TIME CLOCK. SEE SPECS AND DETAILS FOR ADDITIONAL TIME CLOCK REQUIREMENTS.

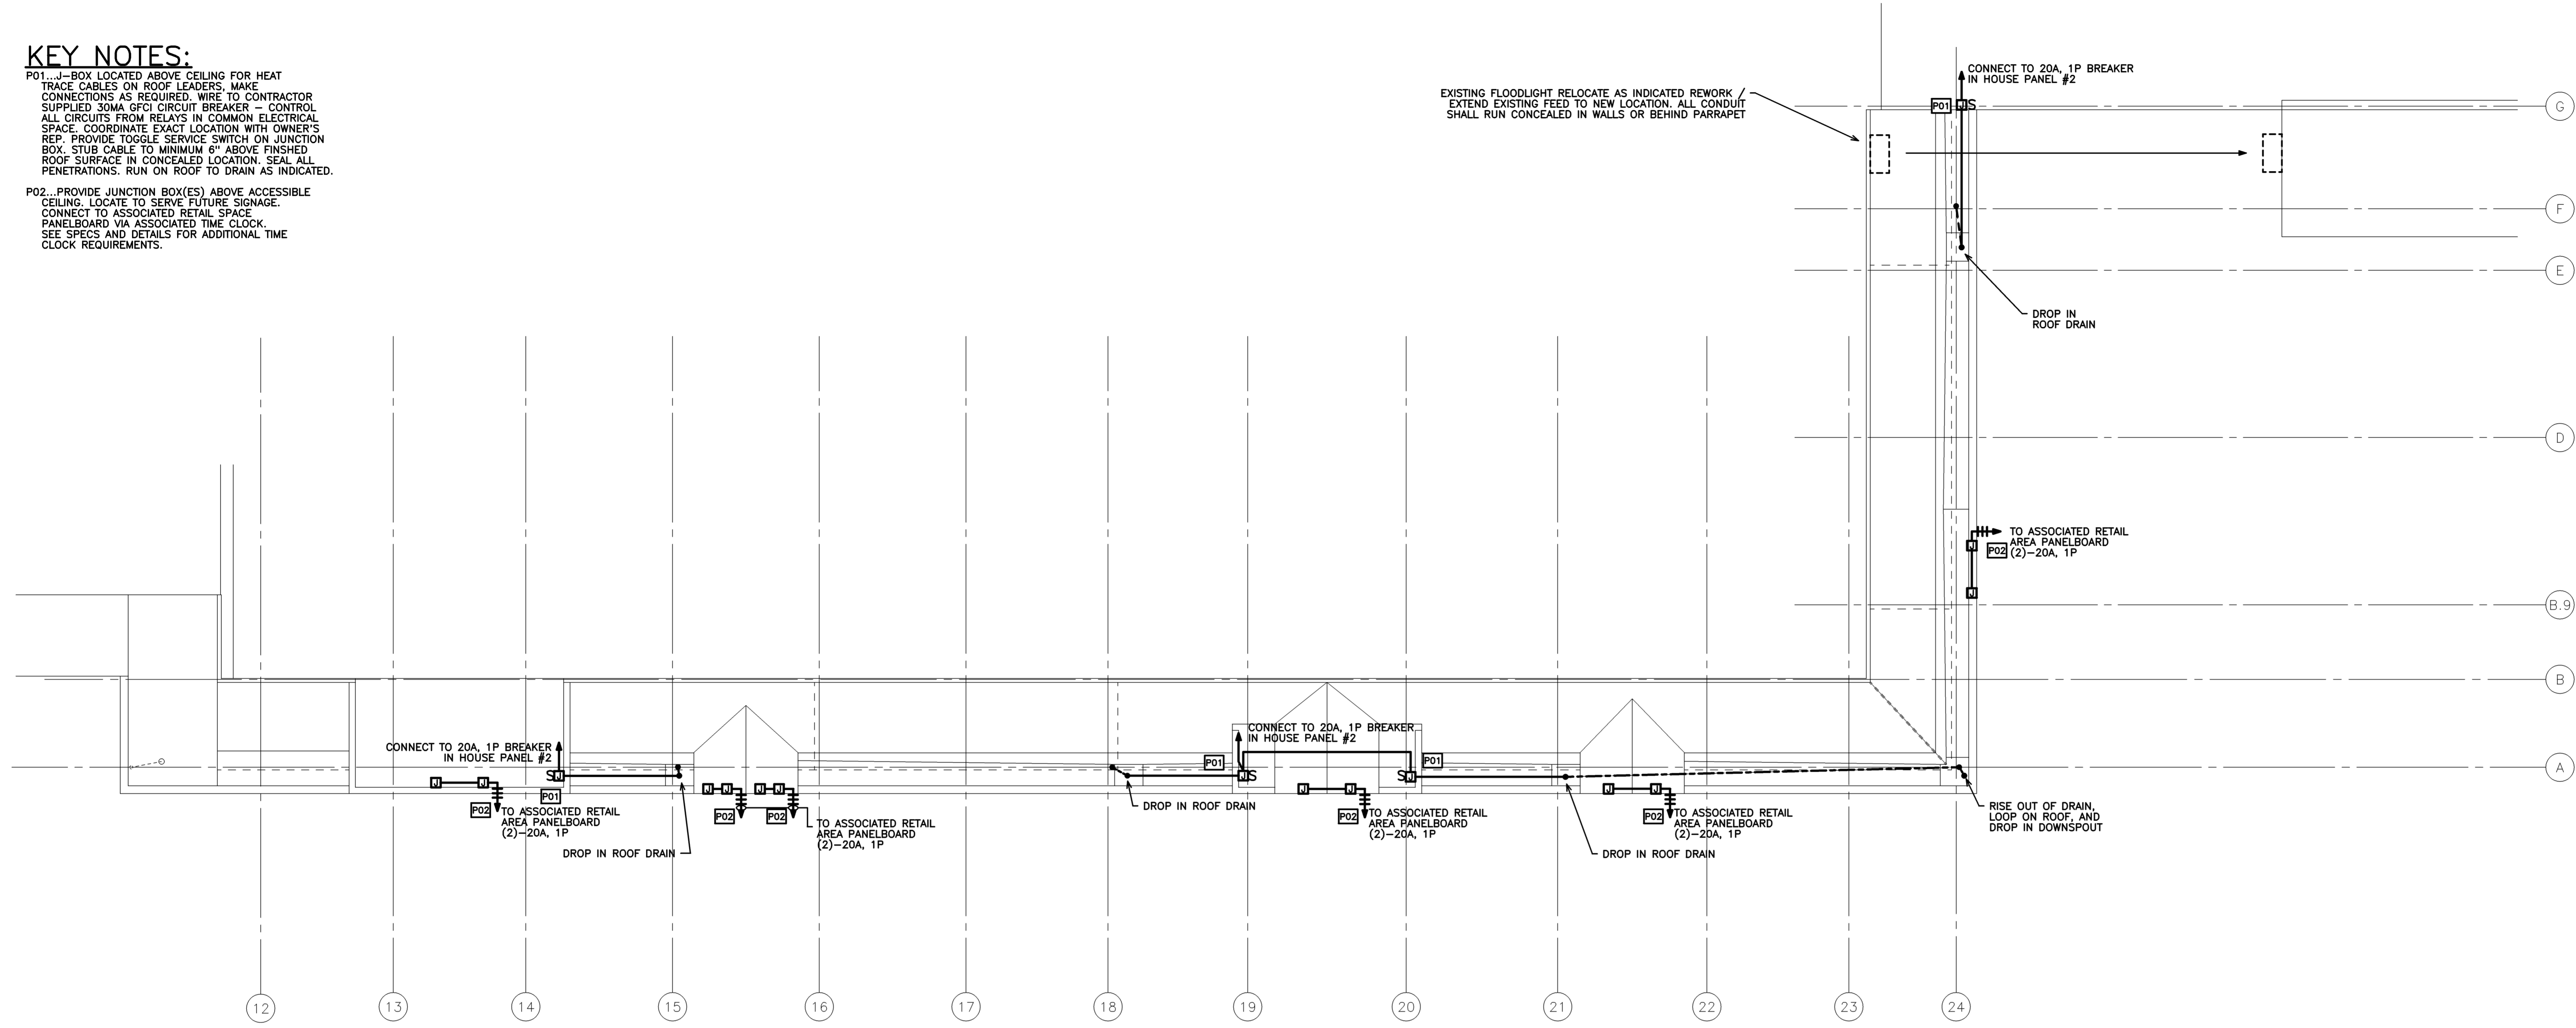

ROOF ELECTRICAL PLAN B
1/8" = 1'-0" REF: NA

B1

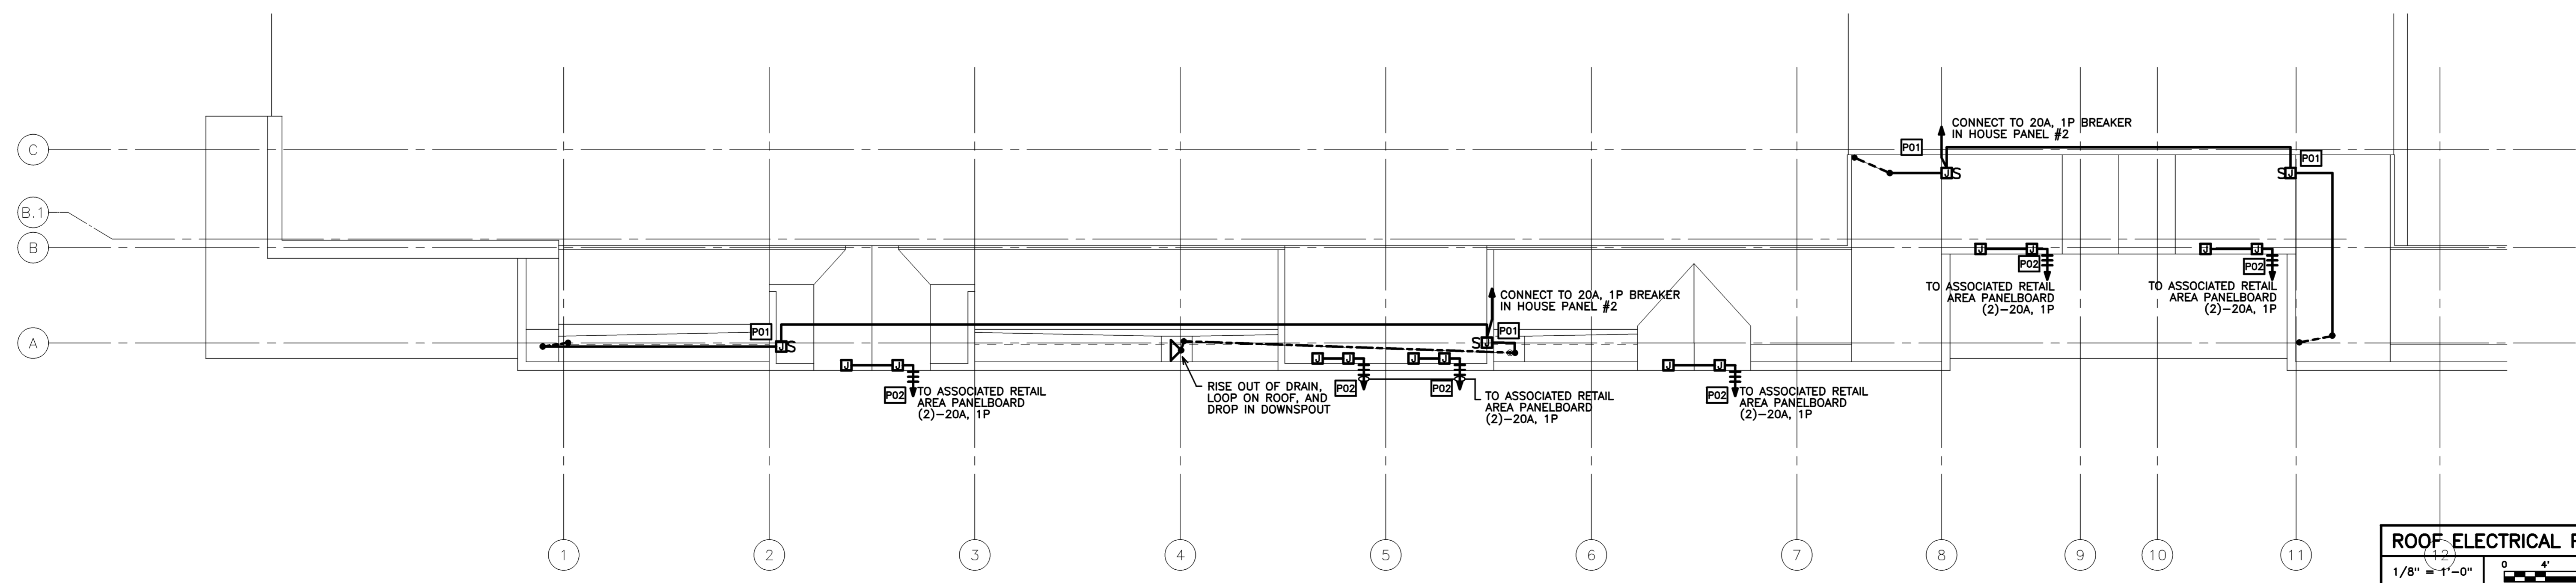

ROOF ELECTRICAL PLAN A
1/8" = 1'-0" REF: NA

A1

03-10-08	ISSUED FOR BID
Mark	Date
Issue Dates	Description

Drawing Status

Drawing Title	ROOF PLAN POWER
PA / PE:	PRM
Drawn By:	DSH
Drawing Number	E10.1