

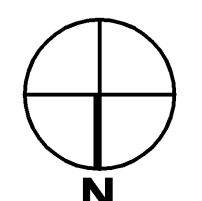
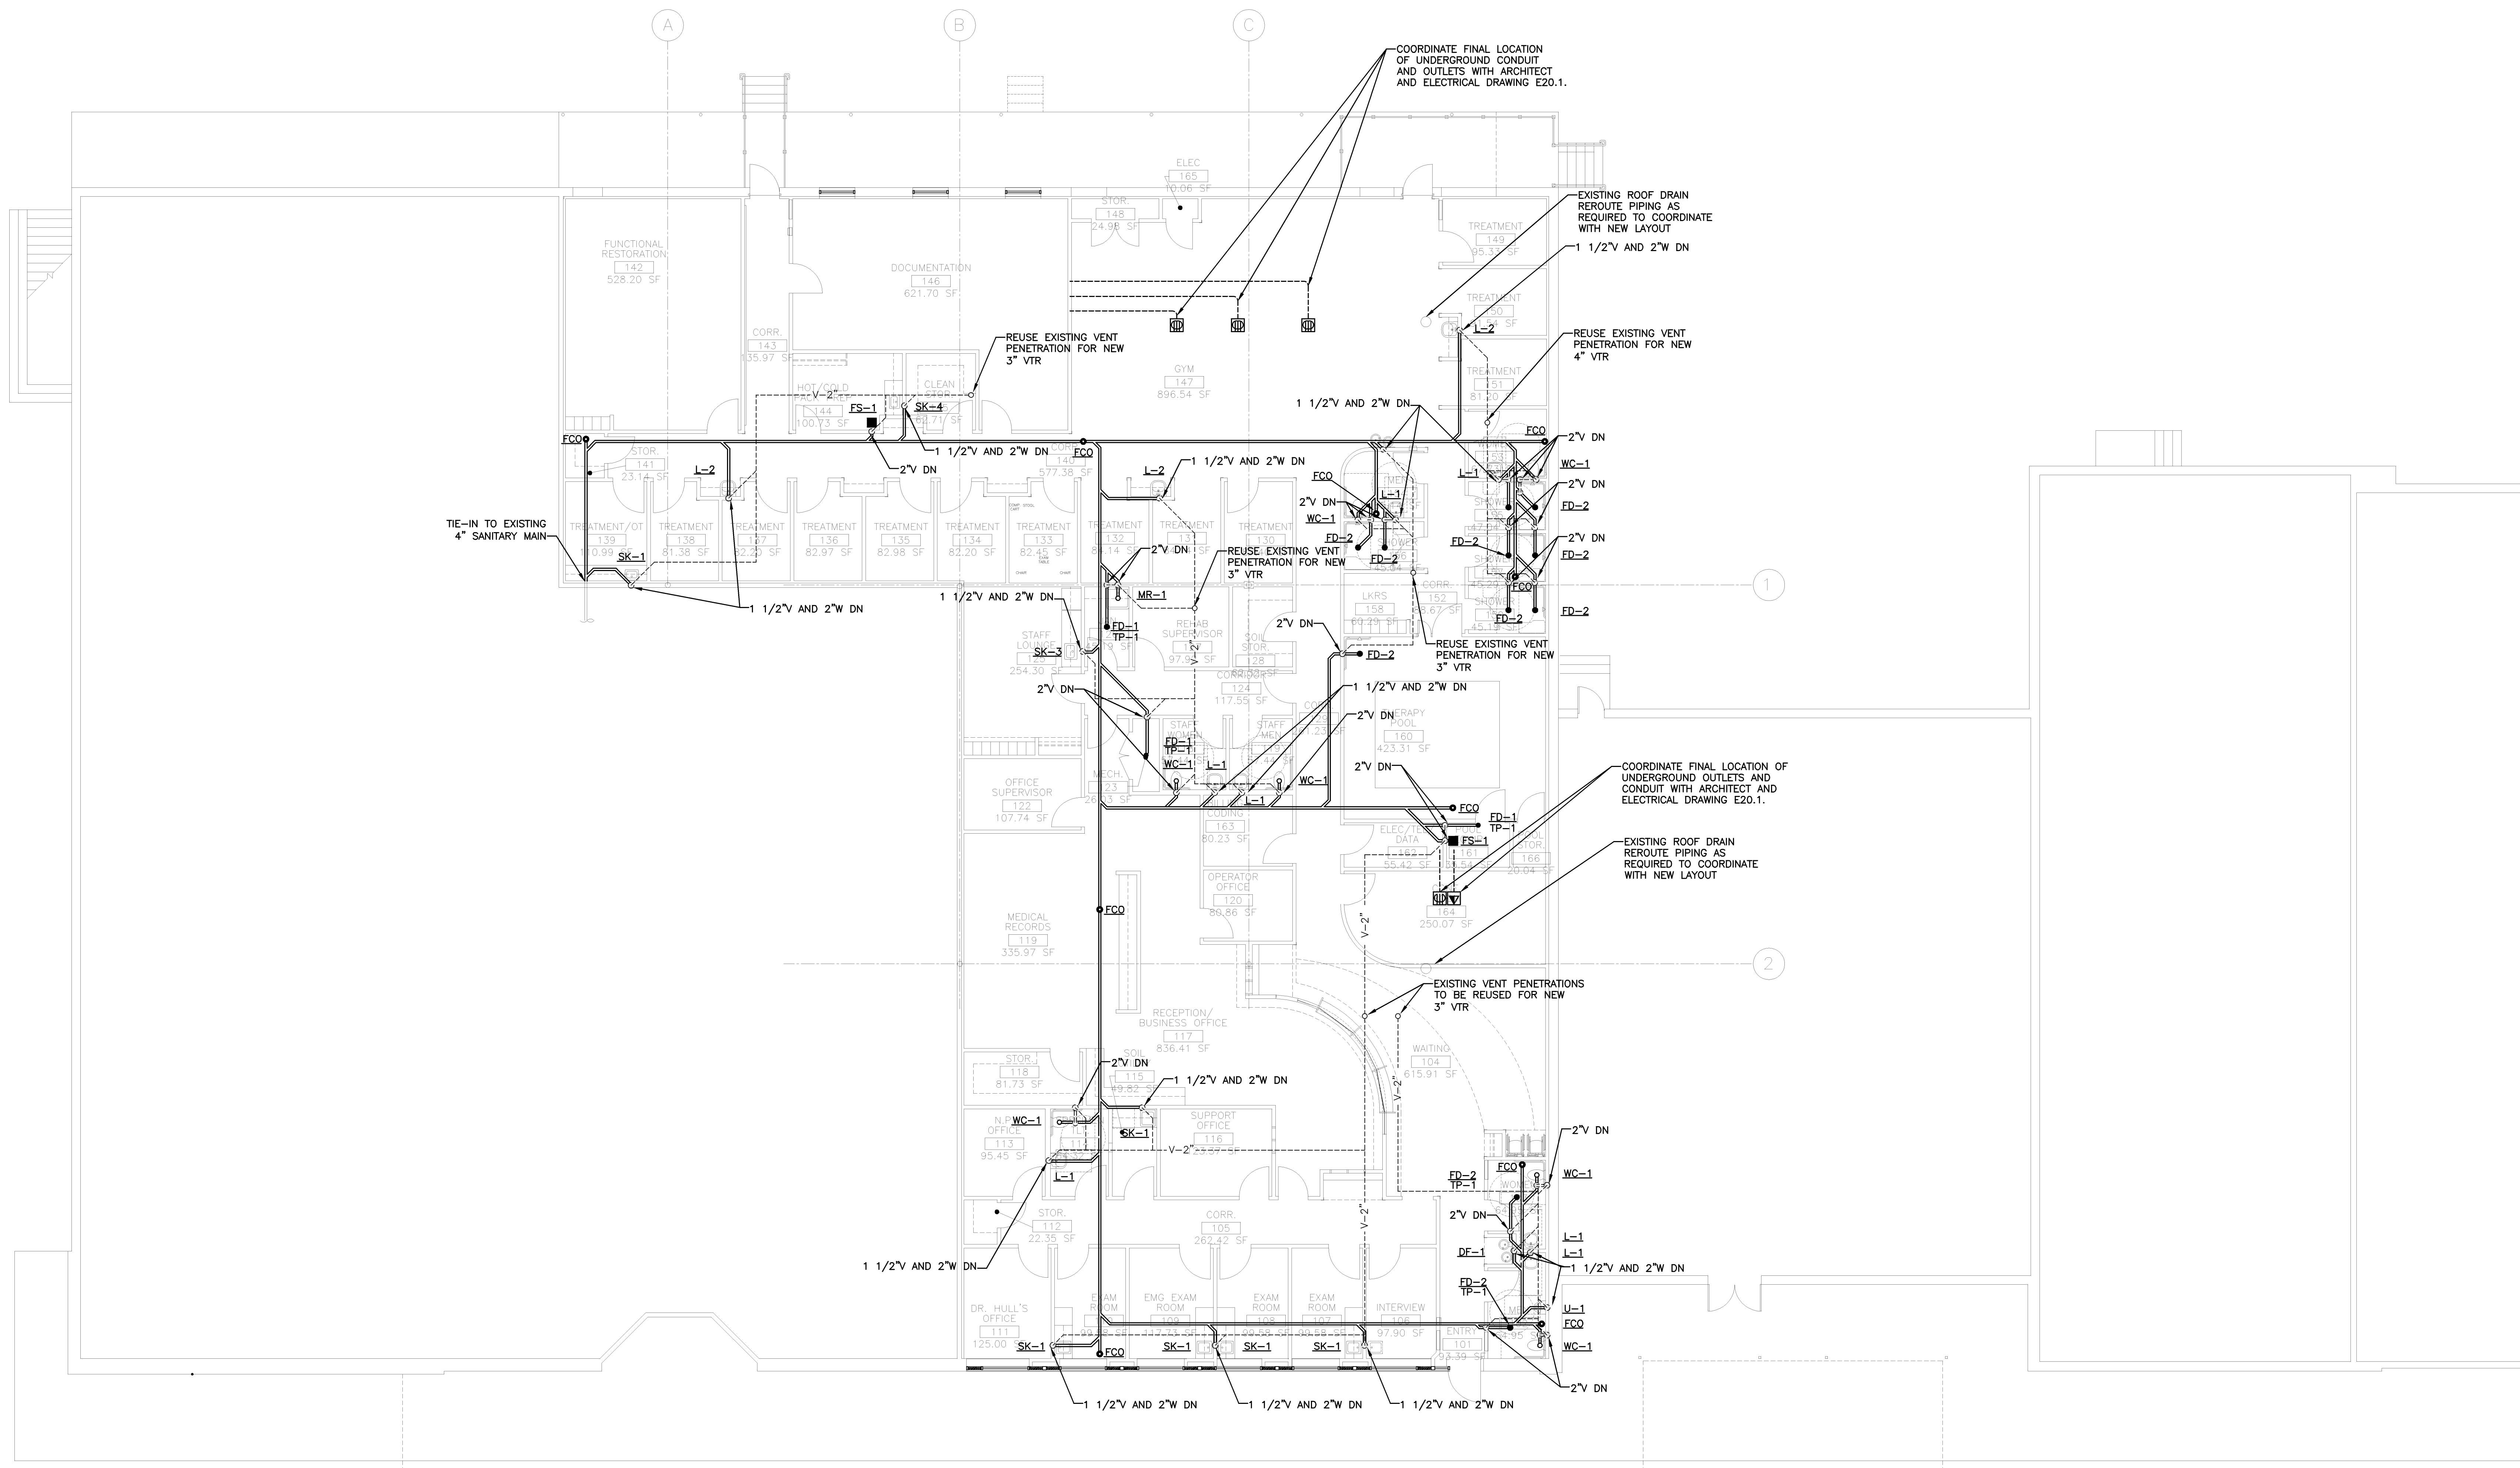
Project Title

**MERCY HEALTH CENTER  
WESTGATE PLAZA**

PORTLAND, MAINE

HA Project No. **07182**

Key Plan

07/01/08	ISSUED FOR PERMIT	
06/26/08	100% REVIEW SET	
06/17/08	50% REVIEW SET	
Mark	Date	Description
Issue Dates		

Drawing Status

Drawing Title

**FLOOR PLAN  
DRAINAGE**

PA / PE: CG Drawn By: SGH

Drawing Number

**P10.1**