


THIRD FLOOR LIGHTING AND FIRE ALARM PLAN
SCALE: 1/4" = 1'-0"

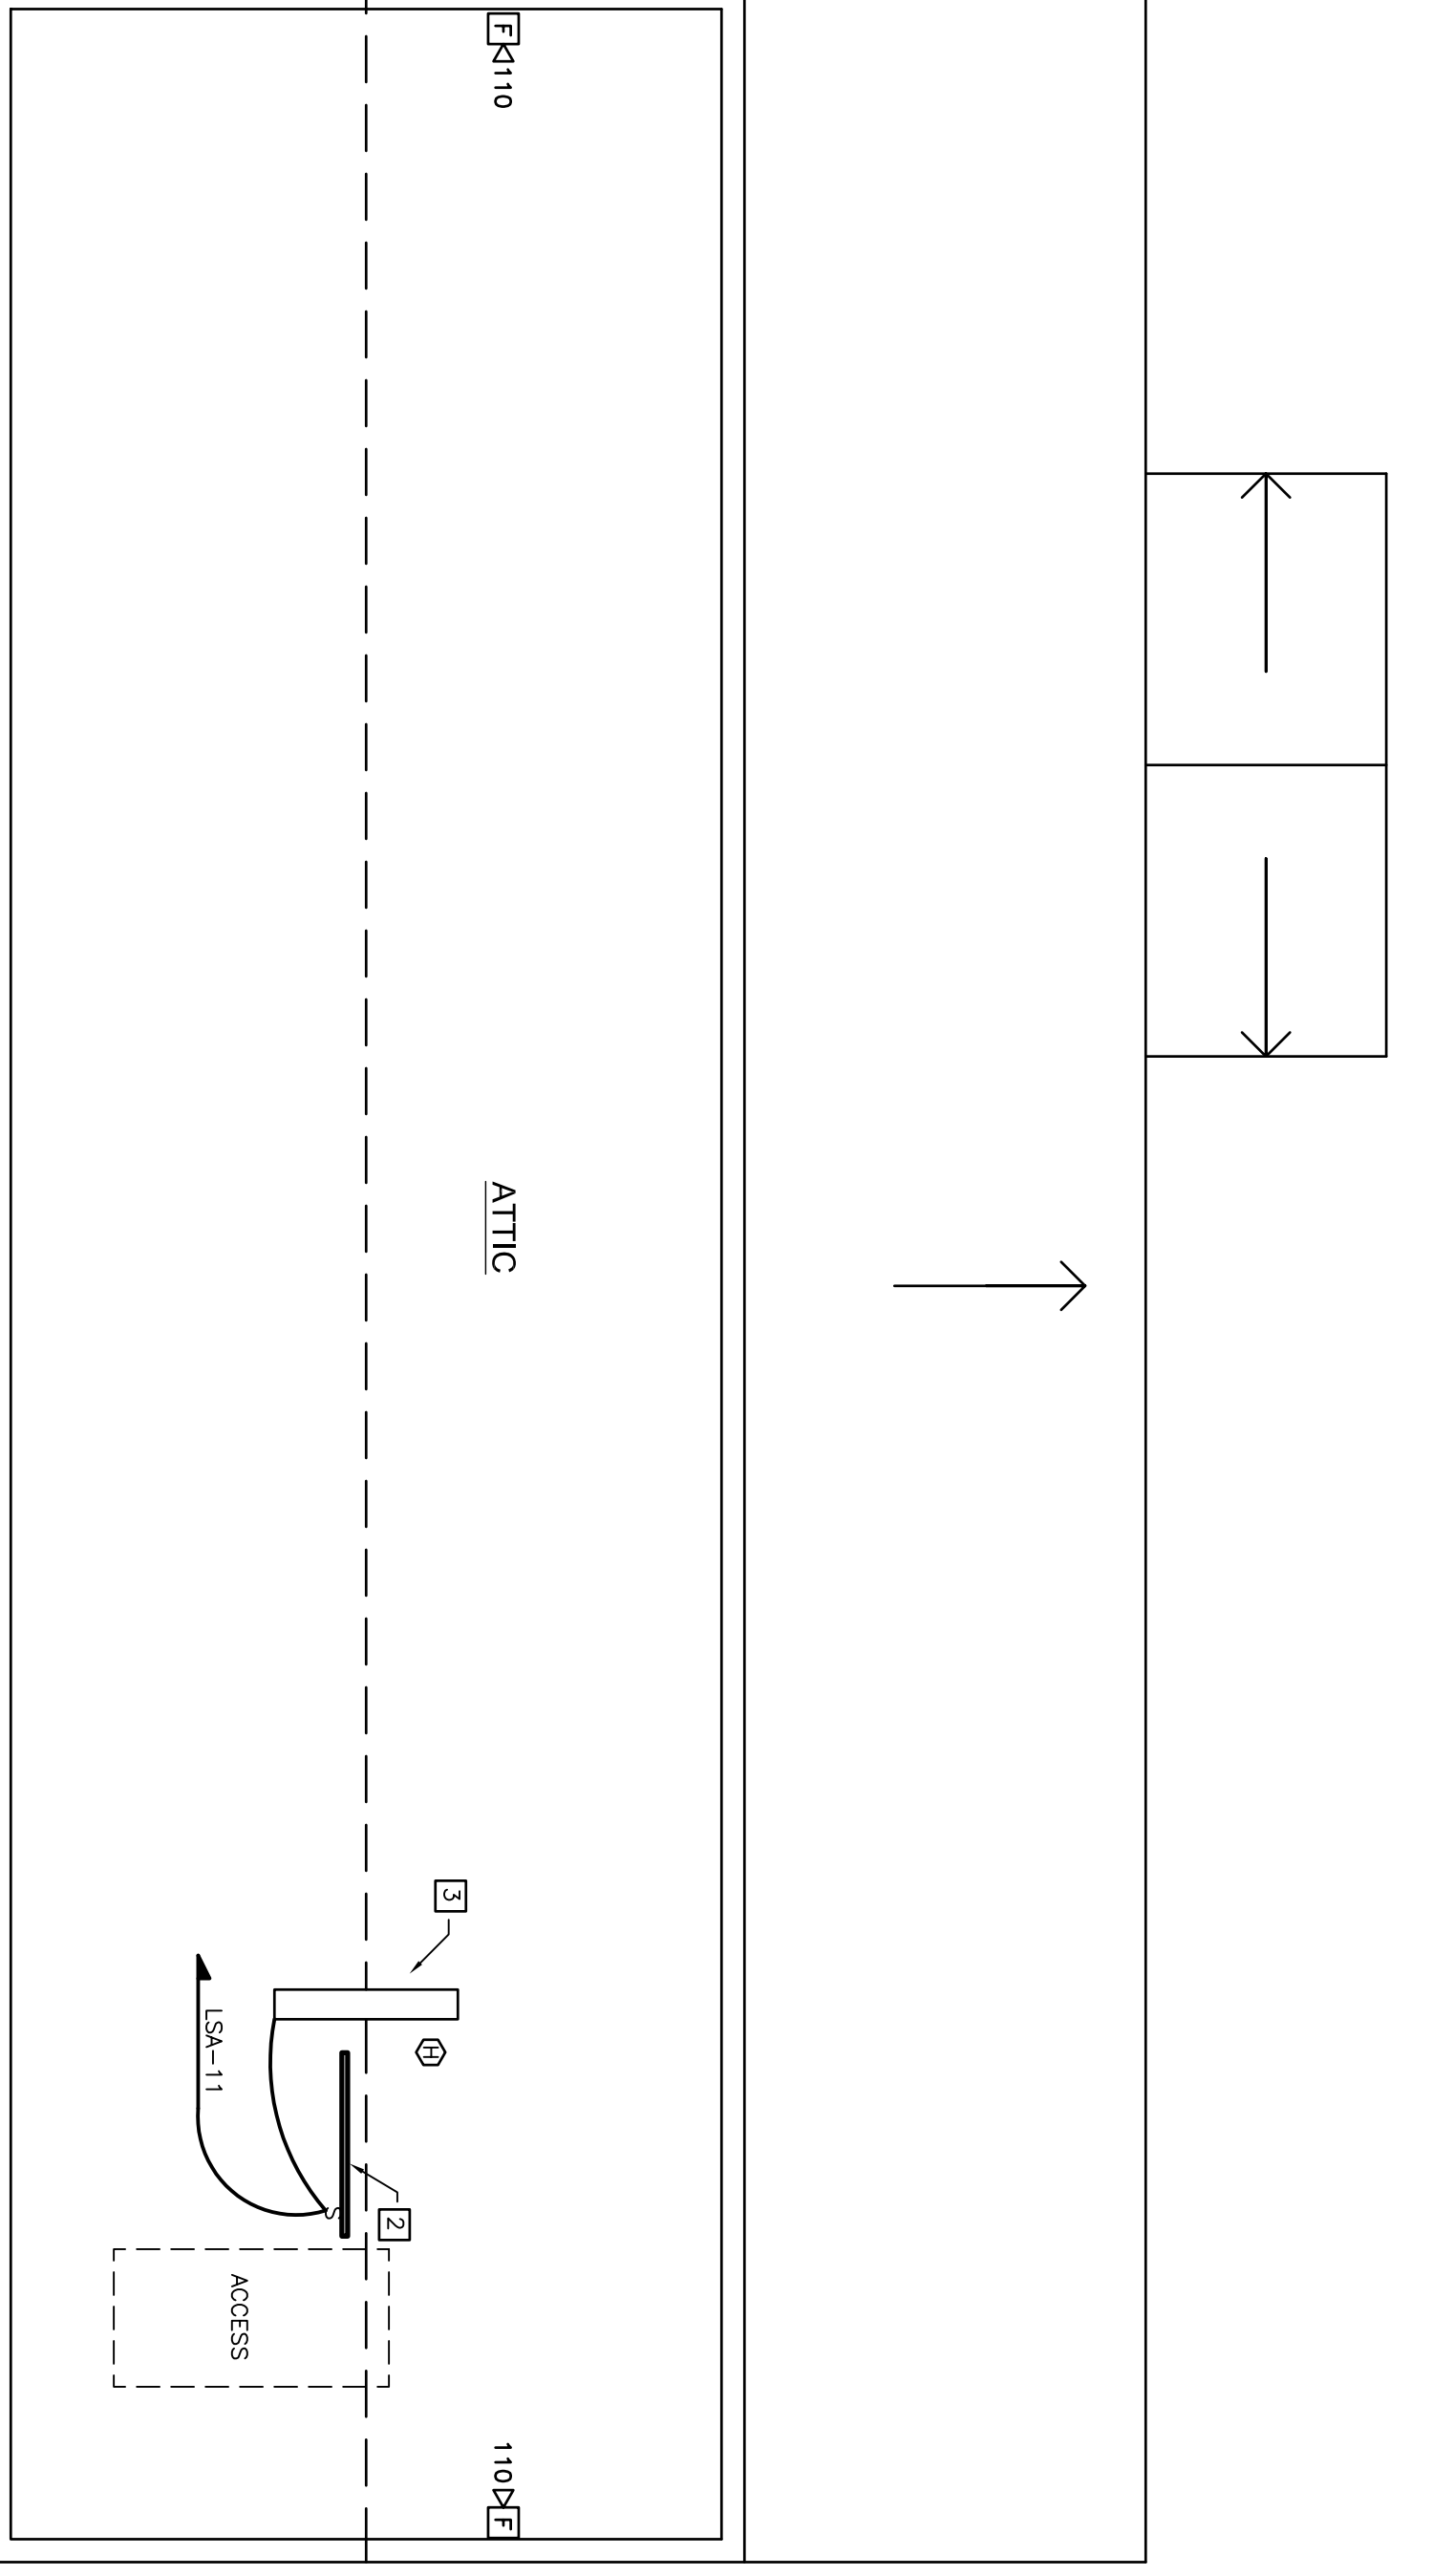

- CONSTRUCTION NOTES:**
- 1 MOUNT CLOSET LIGHT ON CEILING AT WALL CENTERED ABOVE DOOR.
 - 2 PROVIDE BACKBOARD FROM FLOOR TO ROOF TO MOUNT ELECTRICAL COMPONENTS.
 - 3 PENDANT MOUNT LUMINAIRE WITH HOOK/CHAIN AT 8' ABOVE FLOOR.
 - 4 SEE MECHANICAL ENGINEER'S DRAWING FOR EXACT LOCATION.
 - 5 CONTINUE TO S4 BELOW.

PROGRESS, SET ONLY
FOR REVIEW BY AUTHORITIES
HAVING JURISDICTION

CHABAD LUBAVITCH OF
MAINE, INC.
101 CRAIGIE STREET
PORTLAND, ME 04102

THIRD FLOOR LIGHTING AND FIRE ALARM PLAN

CHABAD LUBAVITCH OF MAINE, INC. REGISTERED PROFESSIONAL ENGINEER STATE OF MAINE No. 2800

ELECTRICAL DESIGN CONSULTANTS

DESIGNED BY: RFS	FILENAME: CHA-LIGHTING
DRAWN BY: BMC	REVISION: NONE
DATE: 6-28-07	SCALE: 1/4" = 1'-0"

110110

E-5