


**RICHARD
ABRAHAM
ASSOCIATES
ARCHITECTS**

5 BIRCH DRIVE
SCARBOROUGH, ME 04074
PHONE FAX: (207) 888-6514
EMAIL: rhabraham@rhabraham.com

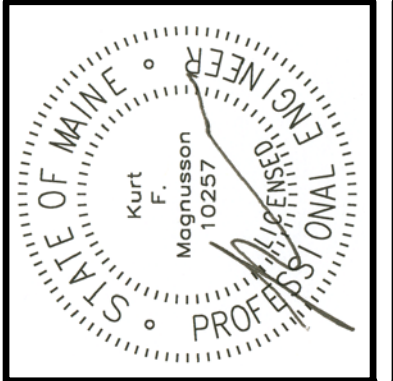

THIS DRAWING, DESIGN AND ELECTRONIC FILE ARE THE PROPERTY OF RICHARD ABRAHAM ASSOCIATES ARCHITECTS. THE REPRODUCTION OR TRANSMISSION OF THIS DOCUMENT WITHOUT WRITTEN CONSENT OF RICHARD ABRAHAM ASSOCIATES ARCHITECTS IS STRICTLY FORBIDDEN BY FEDERAL COPYRIGHT LAW.

NO.	DESCRIPTION	DATE


**PROPOSED NEW SYNAGOGUE
AND RESIDENCE**

POMEROY STREET
PORTLAND, MAINE

OWNER
CHABAD LUBAVITCH OF
MAINE, INC.
101 CRANIE STREET
PORTLAND, ME 04102

DATE	06.28.2007
SCALE	1/4" = 1'-0"
DRAWN BY	E.J.P.
JOB NO.	0702
DESIGN STAGE	REVIEW
SHEET TITLE	SECOND FLOOR PLUMBING PLAN

P-3

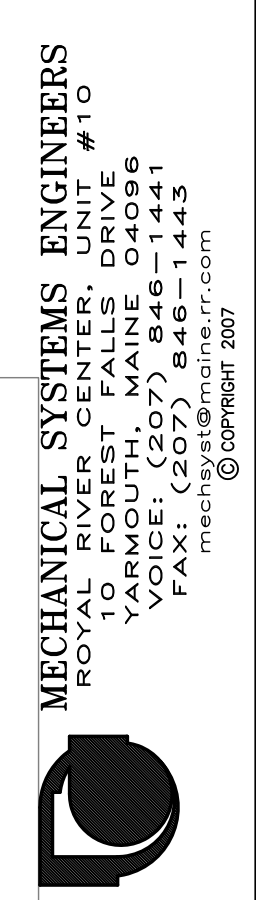

MECHANICAL SYSTEMS ENGINEERS
ROYAL RIVER CENTER, UNIT #10
FOREST FALLS DRIVE
YONKERS, NY 10710
VOICE: (207) 846-1441
FAX: (207) 846-1443
mech@mseng.com
© copyright 2007

FOR REVIEW BY AUTHORITIES
HAVING JURISDICTION 1/4" = 1'-0"

