


THIRD FLOOR LIGHTING AND FIRE ALARM PLAN  
SCALE: 1/4" = 1'-0"

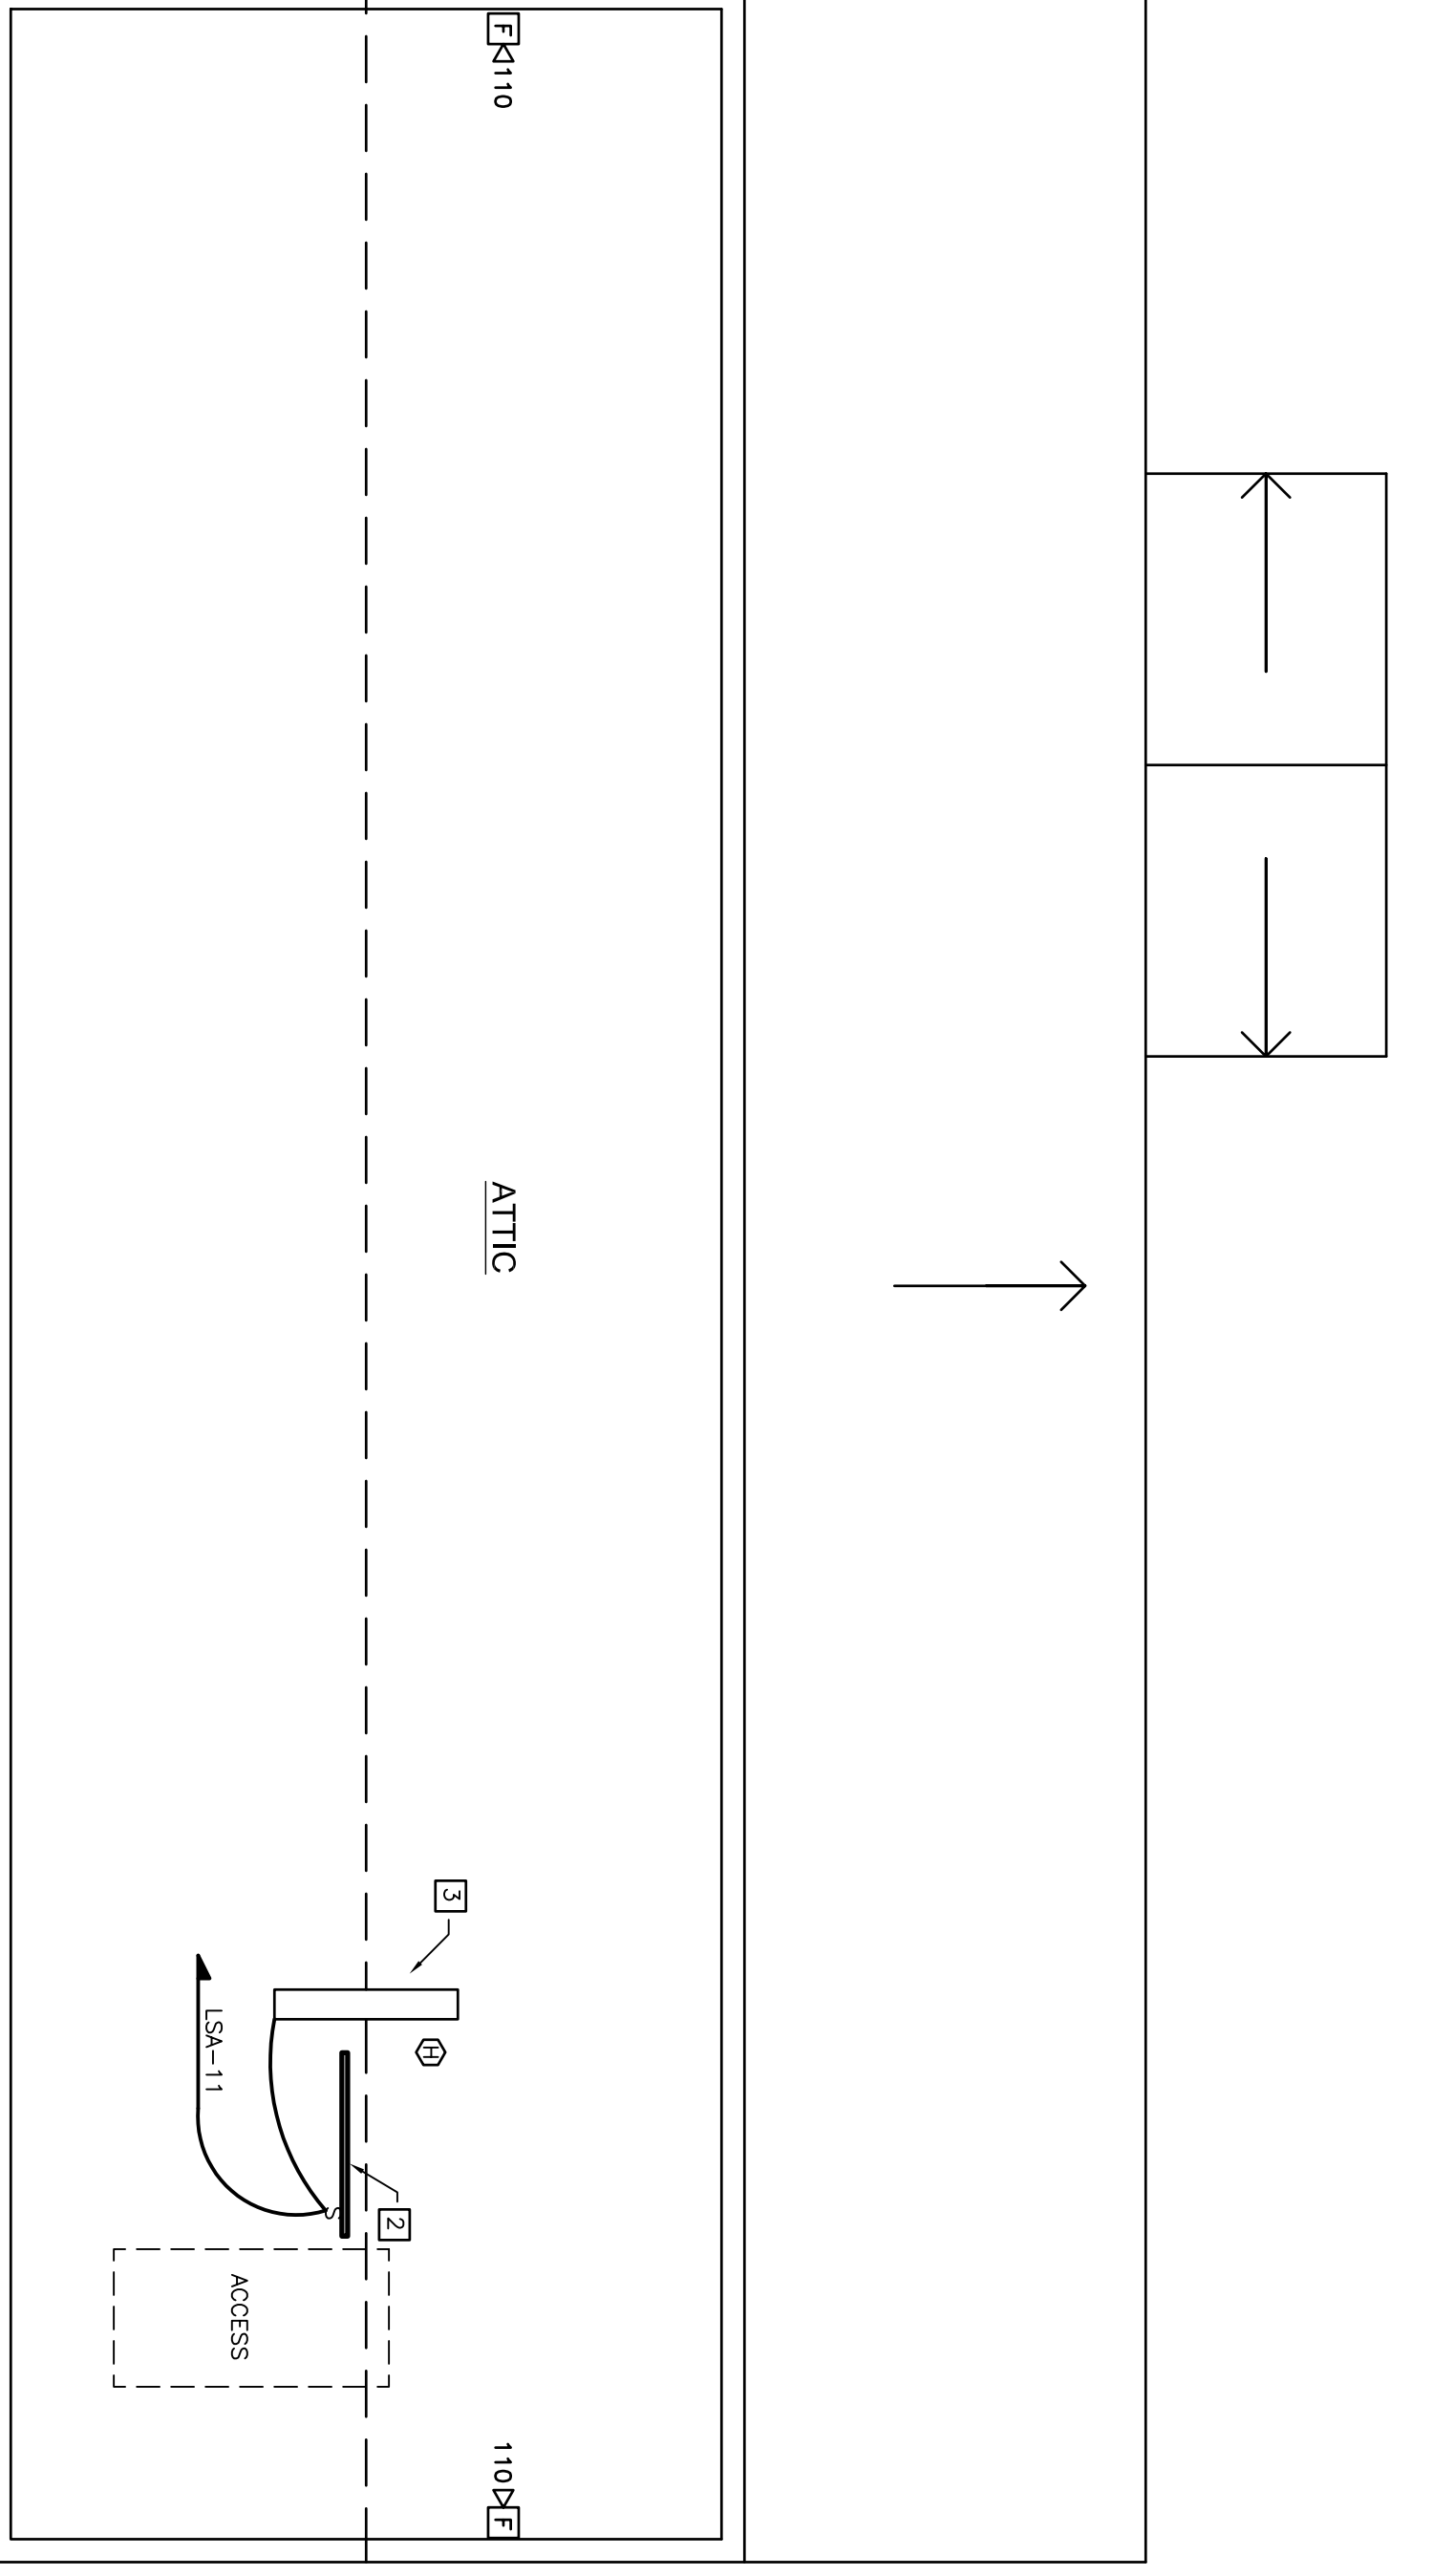

- CONSTRUCTION NOTES:**
- 1 MOUNT CLOSET LIGHT ON CEILING AT WALL CENTERED ABOVE DOOR.
  - 2 PROVIDE BACKBOARD FROM FLOOR TO ROOF TO MOUNT ELECTRICAL COMPONENTS.
  - 3 PENDANT MOUNT LUMINAIRE WITH HOOK/CHAIN AT 8' ABOVE FLOOR.
  - 4 SEE MECHANICAL ENGINEER'S DRAWING FOR EXACT LOCATION.
  - 5 CONTINUE TO S4 BELOW.

PROGRESS, SET ONLY  
FOR REVIEW BY AUTHORITIES  
HAVING JURISDICTION

CHABAD LUBAVITCH OF  
MAINE, INC.  
101 CRAIGIE STREET  
PORTLAND, ME 04102

THIRD FLOOR LIGHTING AND FIRE ALARM PLAN

CHABAD LUBAVITCH OF MAINE, INC. REGISTERED PROFESSIONAL ENGINEER STATE OF MAINE No. 2800

**ELECTRICAL DESIGN CONSULTANTS**

DESIGNED BY: RFS	FILENAME: CHA-LIGHTING
DRAWN BY: BMC	REVISION: NONE
DATE: 6-28-07	SCALE: 1/4" = 1'-0"

PROJECT NO. 28-07  
ELECTRICAL CONSTRUCTION DOCUMENTS

**E-5**