
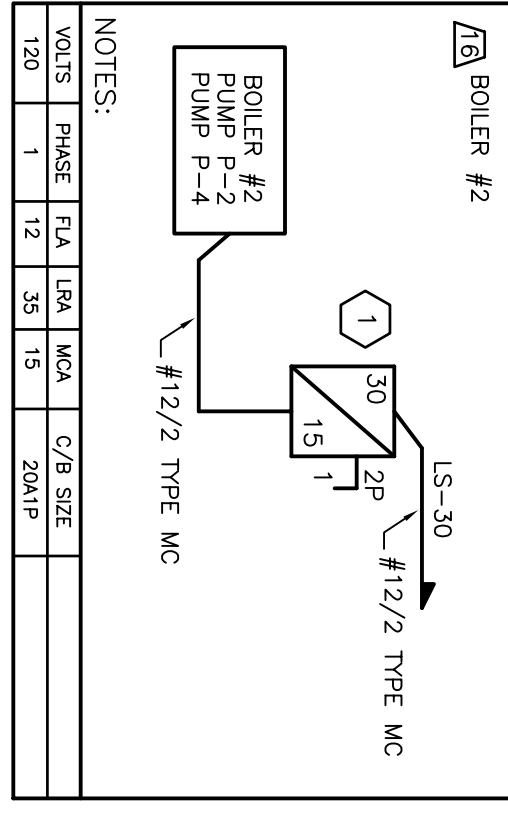
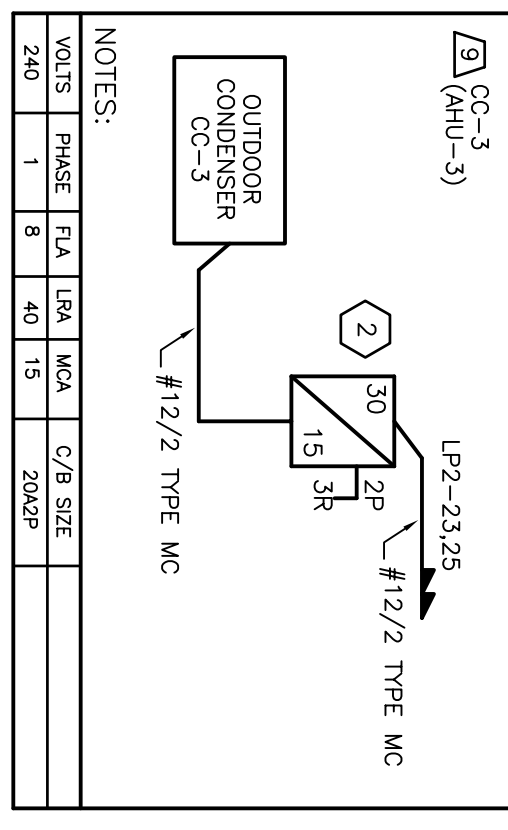


PANEL "1P1" (NORMAL POWER)

VOLTS	PHASE	F/A	U/A	W/A	C/B SIZE	CONNECTION	W/A
240	1	1	12	35	15	20AMP	
CONNECTED TOTAL							
DEMAND TOTAL							




NOTES:  
 \* AFCI BREAKER

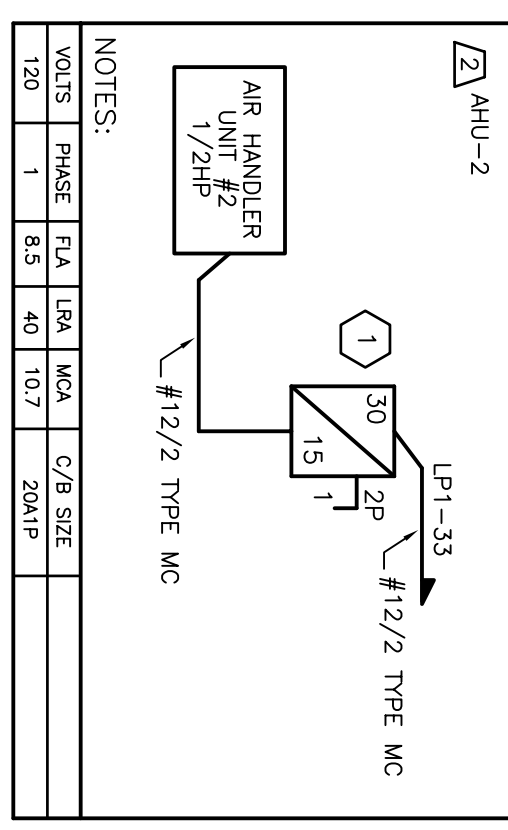

PANEL "1P2" (NORMAL POWER)

VOLTS	PHASE	F/A	U/A	W/A	C/B SIZE	CONNECTION	W/A
240	1	1	12	35	15	20AMP	
CONNECTED TOTAL							
DEMAND TOTAL							




NOTES:  
 \* AFCI BREAKER

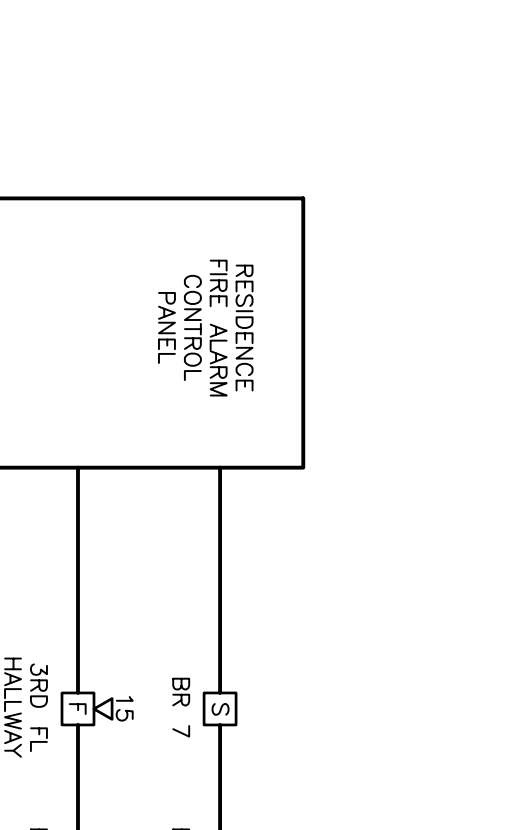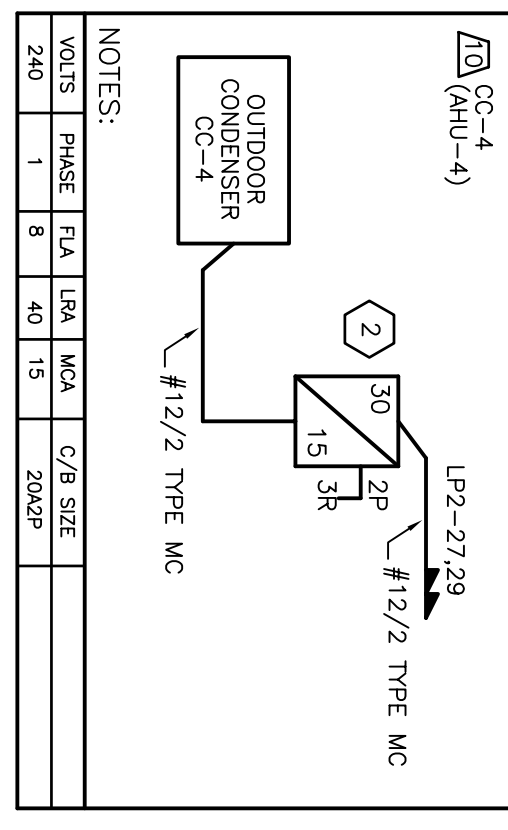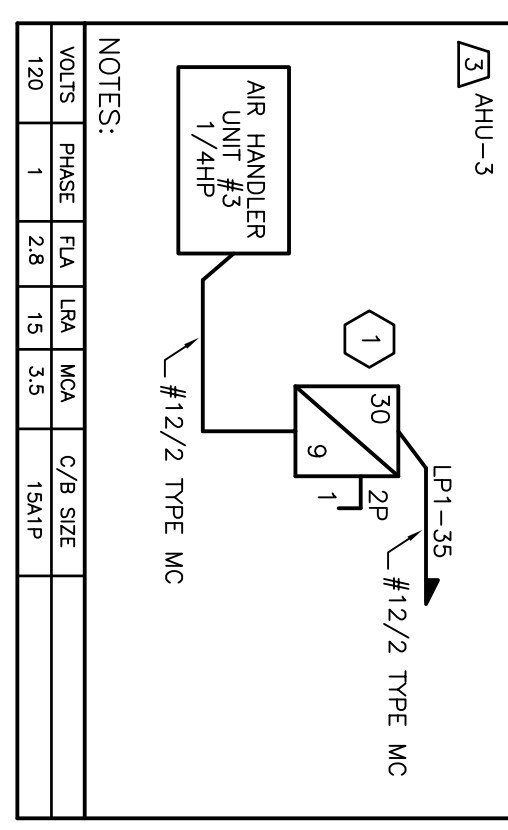

PANEL "1P3" (NORMAL POWER)

VOLTS	PHASE	F/A	U/A	W/A	C/B SIZE	CONNECTION	W/A
240	1	1	12	35	15	20AMP	
CONNECTED TOTAL							
DEMAND TOTAL							




NOTES:  
 \* AFCI BREAKER

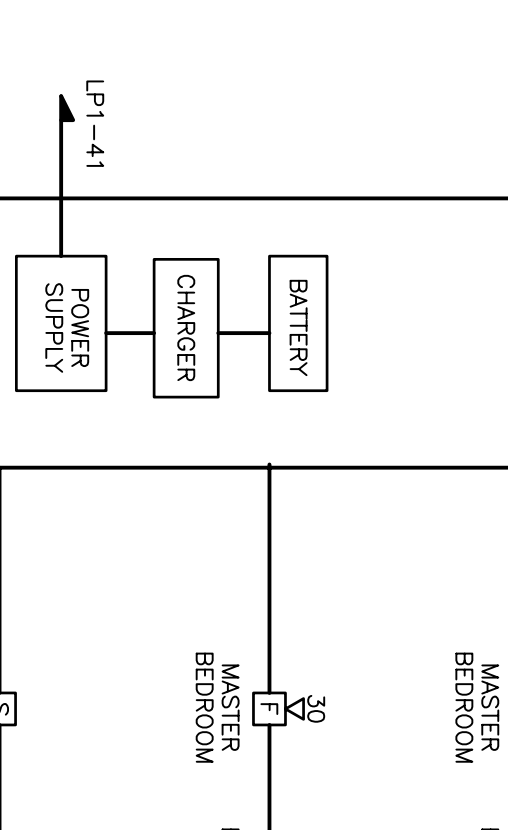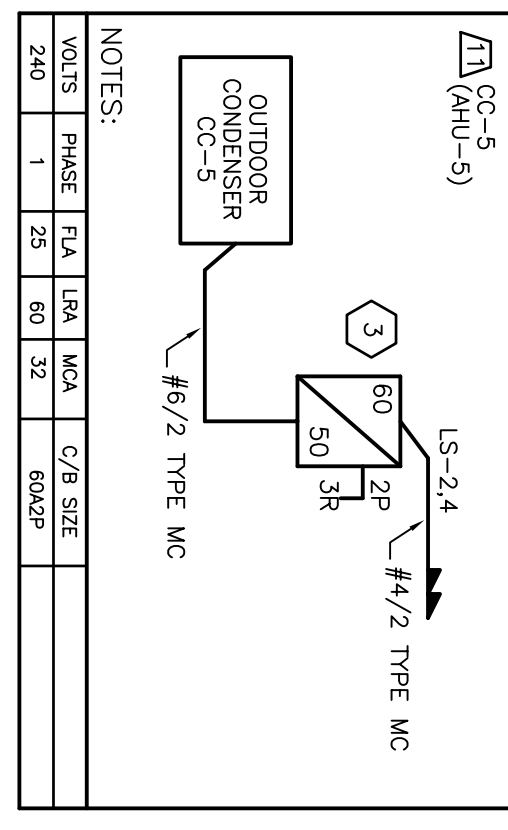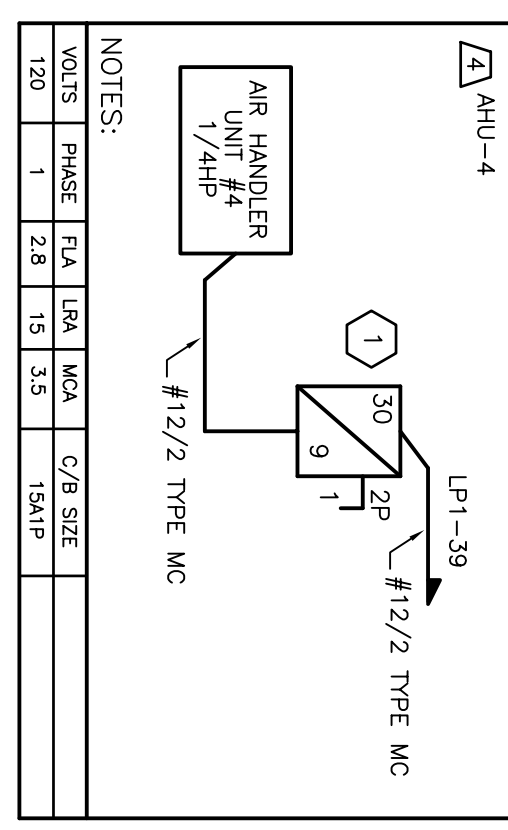

PANEL "1P4" (NORMAL POWER)

VOLTS	PHASE	F/A	U/A	W/A	C/B SIZE	CONNECTION	W/A
240	1	1	12	35	15	20AMP	
CONNECTED TOTAL							
DEMAND TOTAL							



NOTES:  
 \* AFCI BREAKER

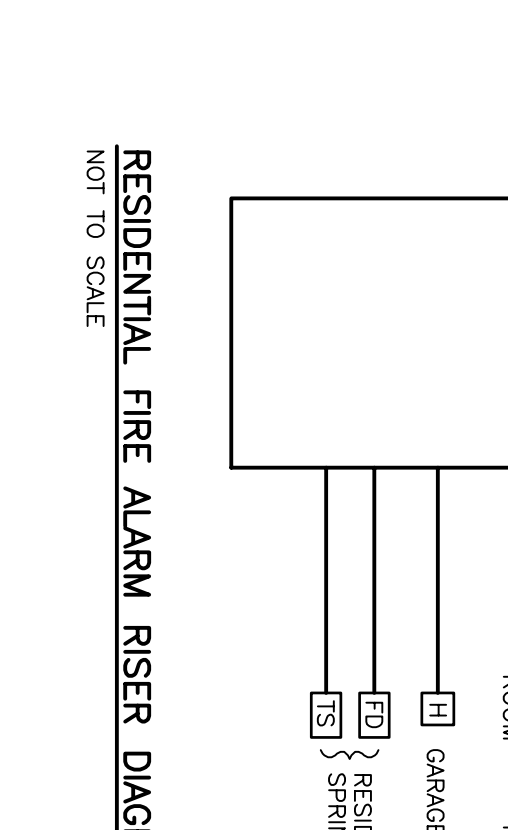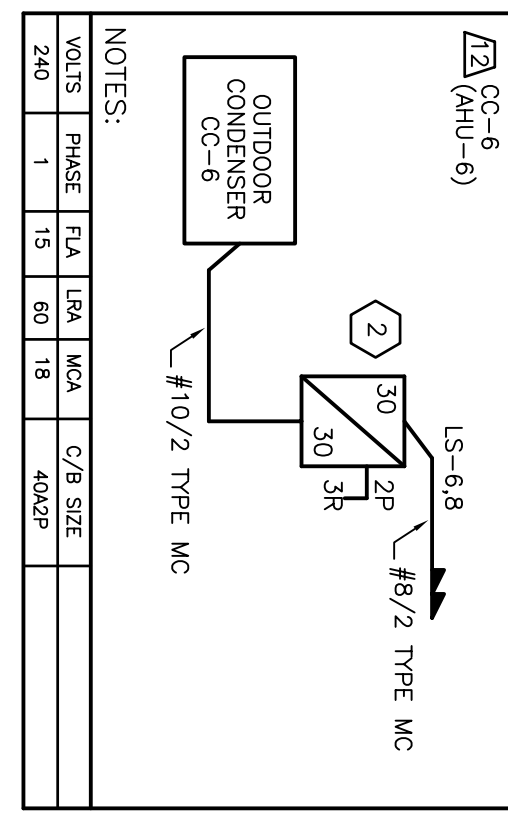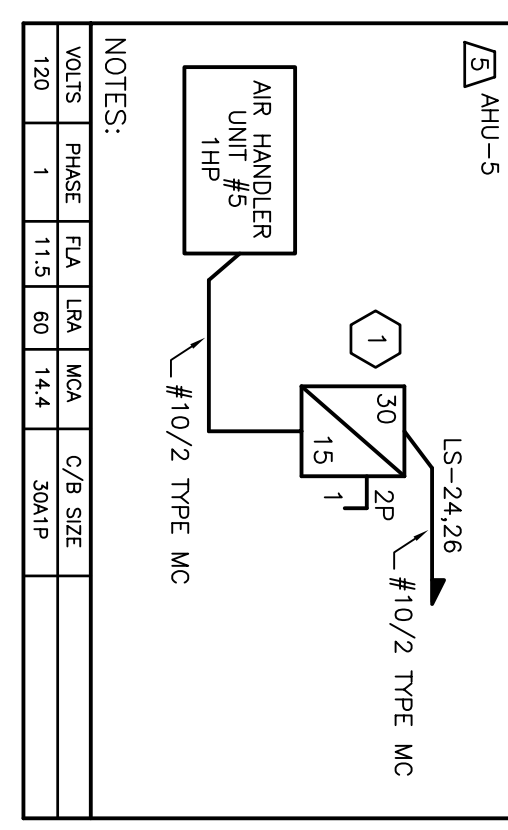

PANEL "1P5" (NORMAL POWER)

VOLTS	PHASE	F/A	U/A	W/A	C/B SIZE	CONNECTION	W/A
240	1	1	12	35	15	20AMP	
CONNECTED TOTAL							
DEMAND TOTAL							



NOTES:  
 \* AFCI BREAKER

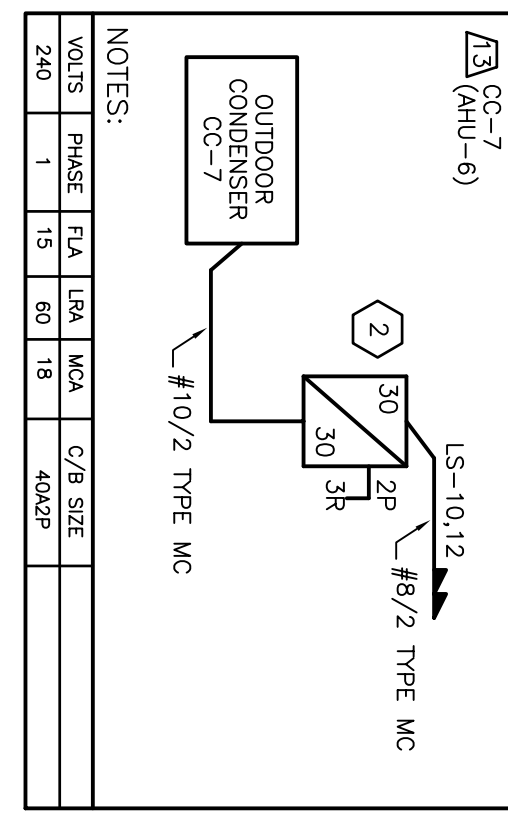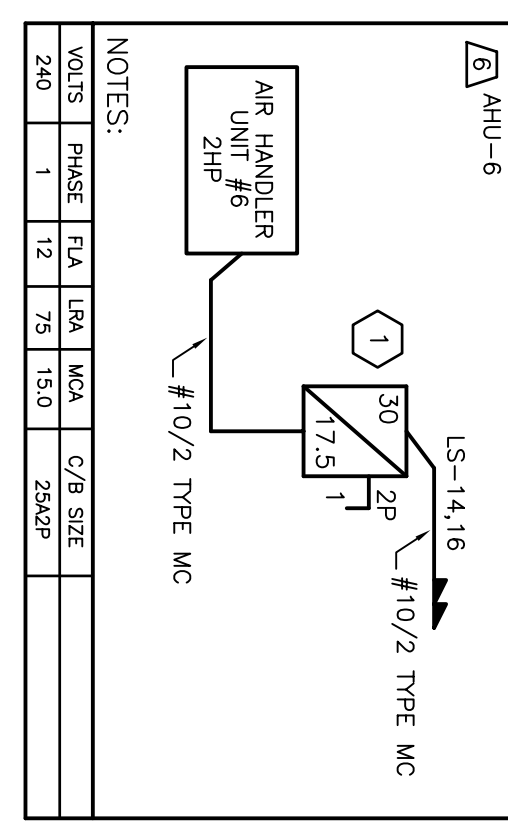

PANEL "1P6" (NORMAL POWER)

VOLTS	PHASE	F/A	U/A	W/A	C/B SIZE	CONNECTION	W/A
240	1	1	12	35	15	20AMP	
CONNECTED TOTAL							
DEMAND TOTAL							

NOTES:  
 \* AFCI BREAKER

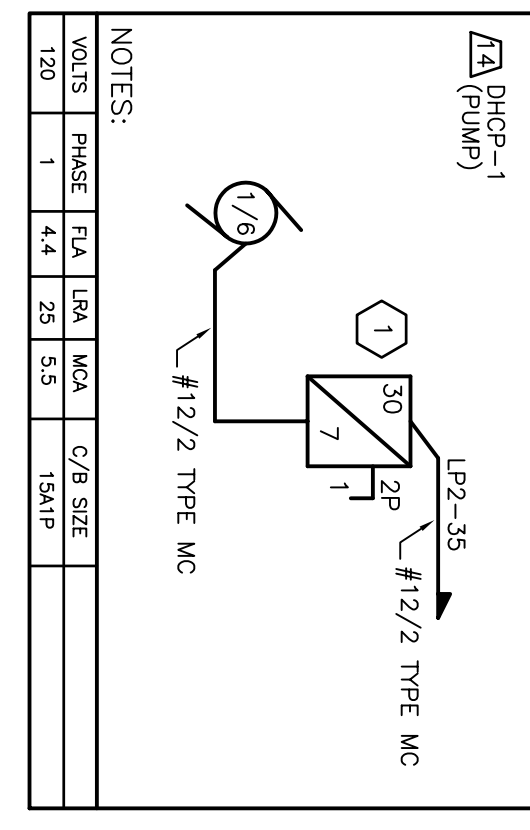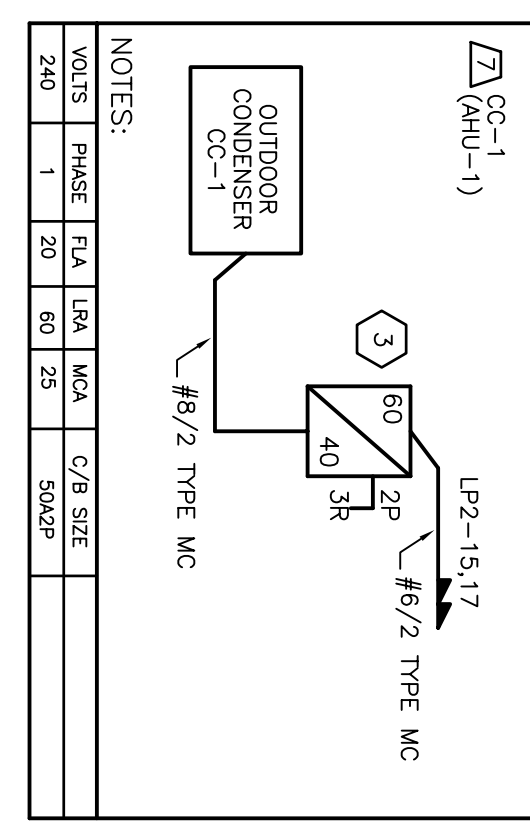

PANEL "1P7" (NORMAL POWER)


VOLTS	PHASE	F/A	U/A	W/A	C/B SIZE	CONNECTION	W/A
240	1	1	12	35	15	20AMP	
CONNECTED TOTAL							
DEMAND TOTAL							

NOTES:  
 \* AFCI BREAKER

PANEL SCHEDULE (NORMAL POWER)

SPRINKLER	Lighting	Receptacles	Power/Panel	WSP	WSP	WSP	WSP
1	1	1	1	1	1	1	1
CONNECTED TOTAL							
DEMAND TOTAL							

NOTES:  
 \* AFCI BREAKER

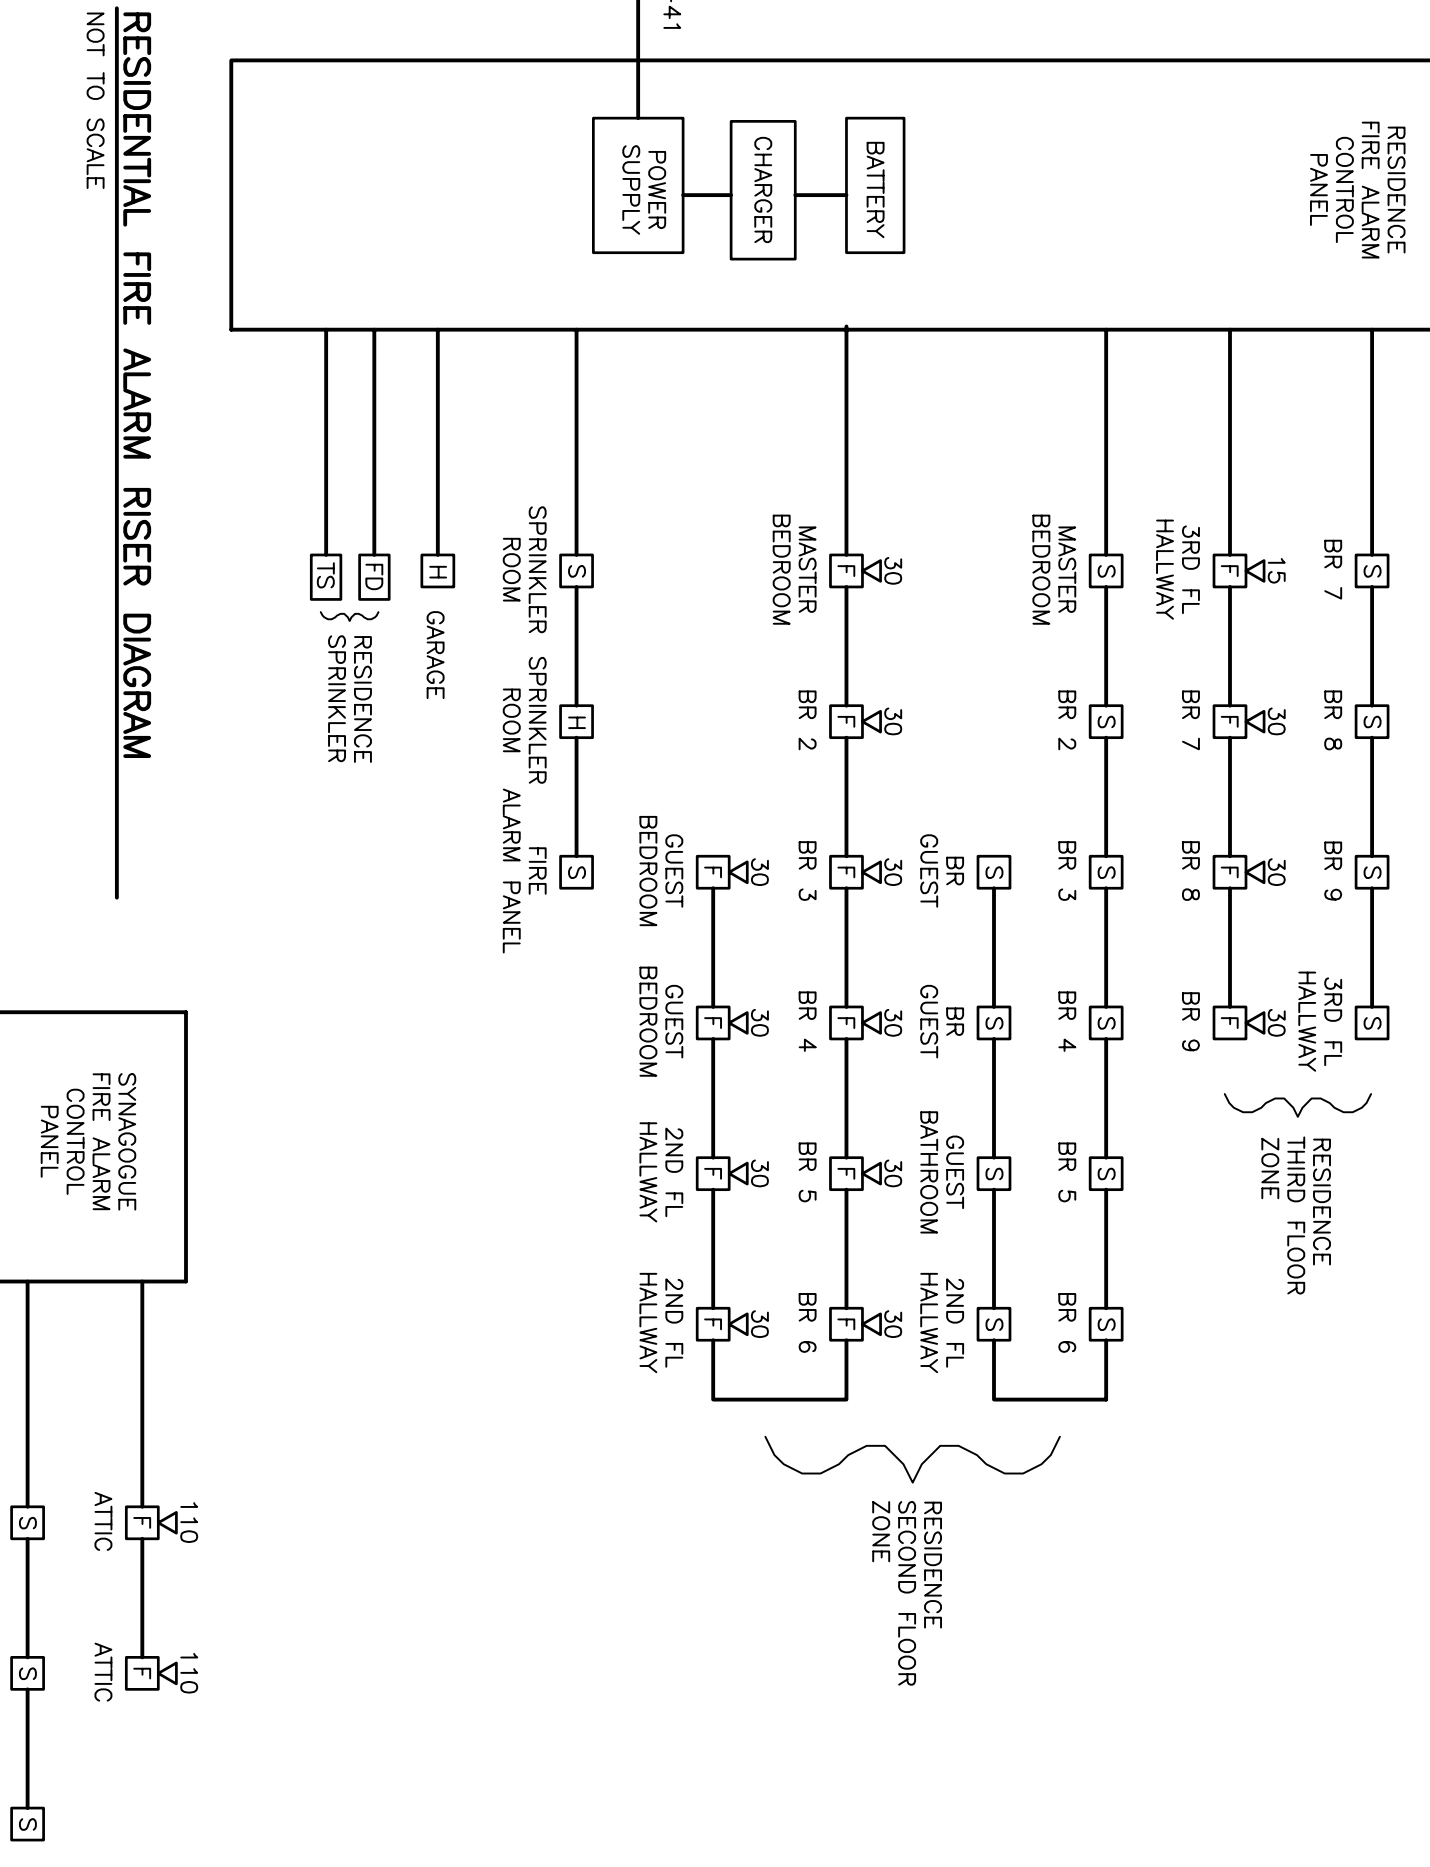

PANEL SCHEDULE (NORMAL POWER)

SPRINKLER	Lighting	Receptacles	Power/Panel	WSP	WSP	WSP	WSP
1	1	1	1	1	1	1	1
CONNECTED TOTAL							
DEMAND TOTAL							

NOTES:  
 \* AFCI BREAKER

PANEL SCHEDULE (NORMAL POWER)

SPRINKLER	Lighting	Receptacles	Power/Panel	WSP	WSP	WSP	WSP
1	1	1	1	1	1	1	1
CONNECTED TOTAL							
DEMAND TOTAL							

NOTES:  
 \* AFCI BREAKER

PANEL SCHEDULE (NORMAL POWER)


SPRINKLER	Lighting	Receptacles	Power/Panel	WSP	WSP	WSP	WSP
1	1	1	1	1	1	1	1
CONNECTED TOTAL							
DEMAND TOTAL							

NOTES:  
 \* AFCI BREAKER

PANEL SCHEDULE (NORMAL POWER)

SPRINKLER	Lighting	Receptacles	Power/Panel	WSP	WSP	WSP	WSP
1	1	1	1	1	1	1	1
CONNECTED TOTAL							
DEMAND TOTAL							

NOTES:  
 \* AFCI BREAKER

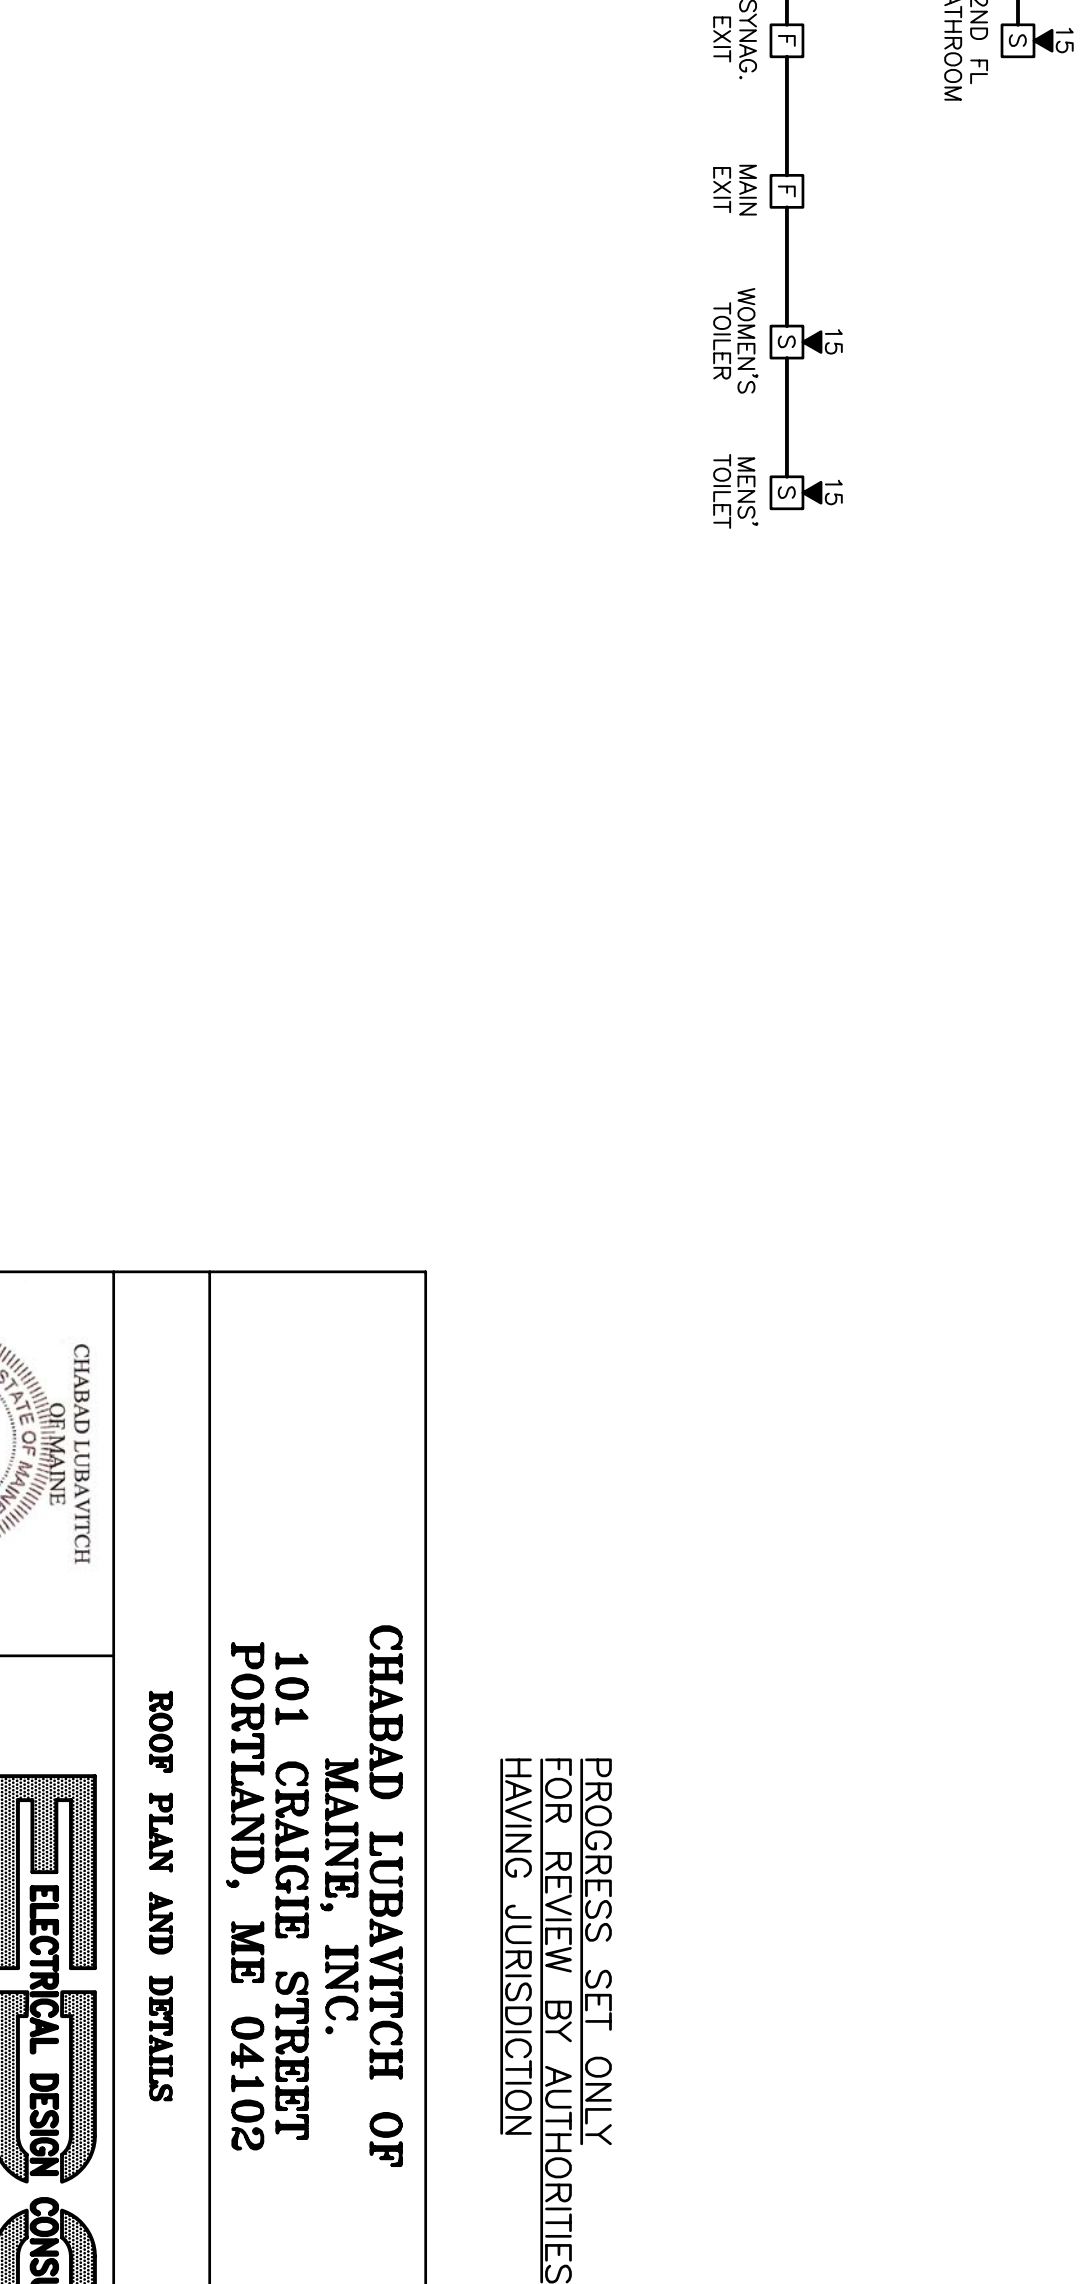

CHABAD LUBAVITCH OF MAINE, INC.  
 101 CRAIGIE STREET  
 PORTLAND, ME 04102

PROGRESS SET ONLY  
 FOR REVIEW BY AUTHORITIES  
 HAVING JURISDICTION

DESIGNED BY: RFS  
 DRAWN BY: BMC  
 DATE: 6-28-07

SCALE: 1/4" = 1'-0"

ELECTRICAL DESIGN CONSULTANTS

CHABAD LUBAVITCH OF MAINE  
 STATE OF MAINE  
 LICENSE NO. 2003

