


1 FIRST FLOOR PLAN - POWER
SCALE: 1/4" = 1'-0"

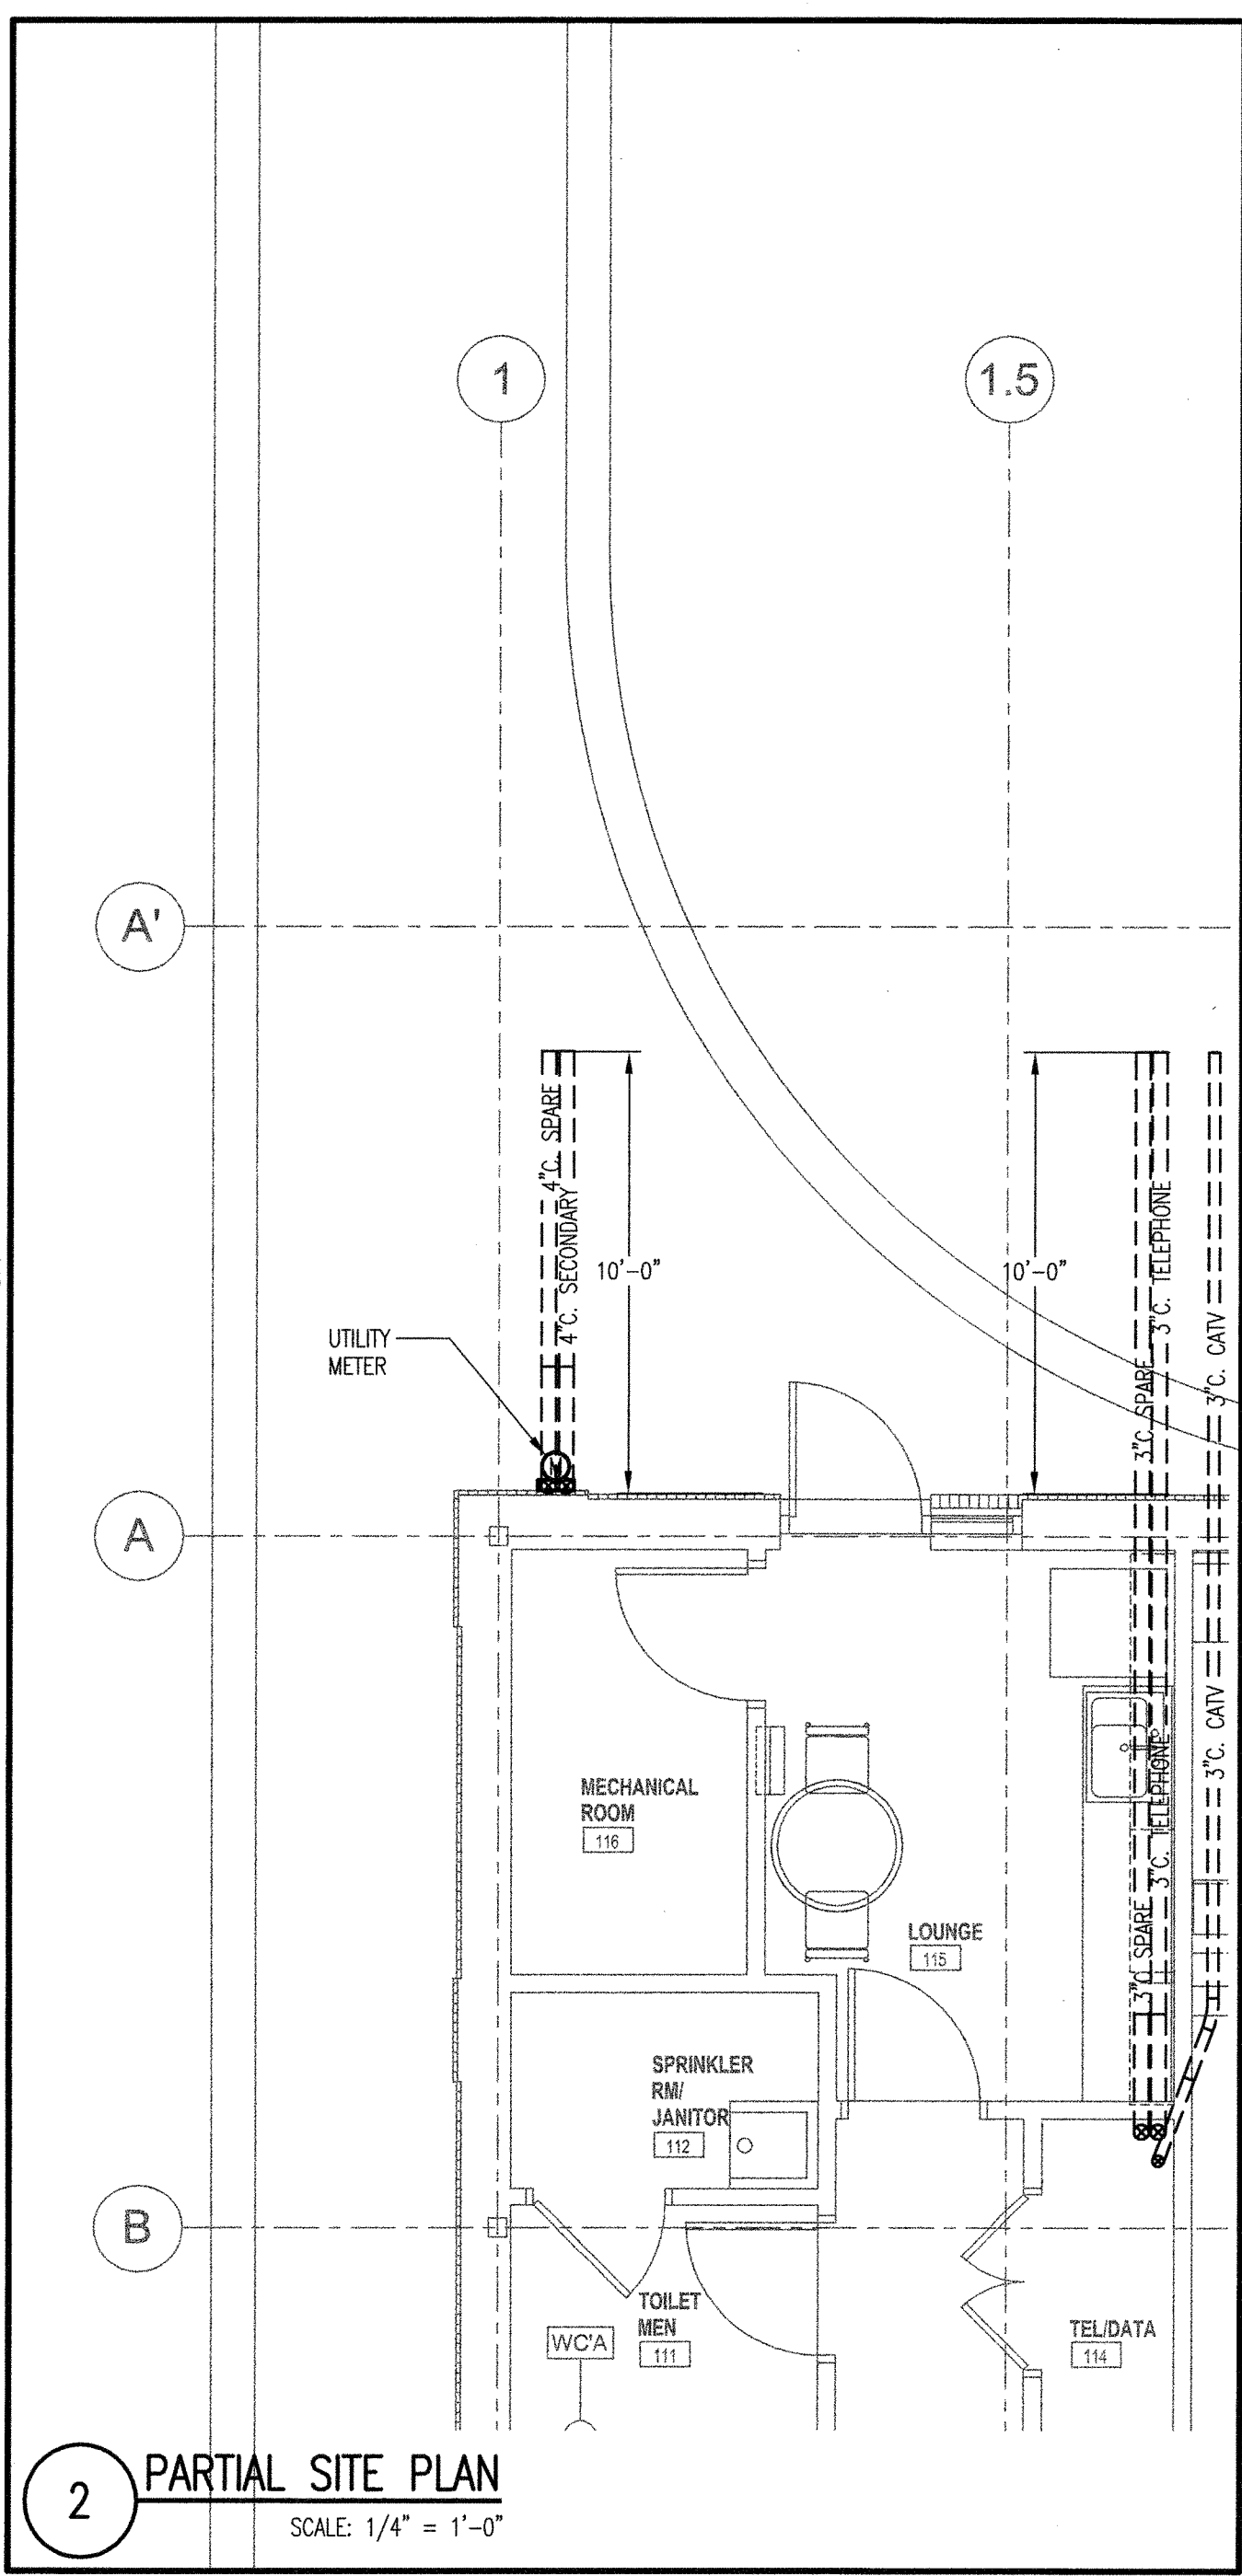

2 PARTIAL SITE PLAN
SCALE: 1/4" = 1'-0"

NOTES:

1. PROVIDE FLUSH MOUNT QUAD RECEPTACLES IN TELLER MILLWORK AT EACH TELLER STATION W/ DEDICATED CIRCUITS AS SHOWN ON PLANS. CONCEAL HOMERUN CIRCUITING IN WALL FOR INSTALLATION REQUIREMENTS, REFER TO TELLER STATION ELEVATION DETAIL E1.01/1.
2. PROVIDE OUTLET BOXES REQUIRED FOR INSTALLATION OF TEL/DATA SYSTEMS' DEVICES, J-BOXES AND CONDUIT SYSTEM WITH PULL WIRES AS REQUIRED FOR TEL/DATA SYSTEMS' INSTALLATION. OUTLET BOXES SHALL BE INSTALLED FLUSH IN TELLER MILLWORK AT EACH TELLER STATION, FOR INSTALLATION REQUIREMENTS REFER TO TELLER STATION ELEVATION DETAIL ON THIS DRAWING. TEL/DATA SYSTEMS' JACKS AND WIRING WILL BE INSTALLED BY OTHERS.
3. EXTEND 1" CONDUIT WITH PULL WIRE (FROM TEL/DATA J-BOX AT THE TELLER COUNTER OR FROM COMMUNICATION COMPARTMENT OF THE RACEWAY) INSIDE THE WALL DOWN TO THE CEILING ABOVE. STUB STUB CONDUIT 6" ABOVE ACCESSIBLE CEILING AT 90° ANGLE AND TERMINATE WITH PLASTIC BUSHING.
4. PROVIDE DEDICATED NEUTRALS FOR EACH OF IDENTIFIED CIRCUITS.
5. PROVIDE DEDICATED 20A DUPLEX RECEPTACLE AND DEDICATED CIRCUIT FOR TCR/TCD (TELLER CASH RECYCLER/TELLER CASH DISPENSER). COORDINATE EXACT LOCATION WITH OWNER PRIOR TO ROUGH-IN.
6. ALL CABLE TYPES SHALL BE VERIFIED WITH VAT SYSTEM INSTALLER. REFER TO DETAILS E7.02/1, E7.02/2 & E7.02/3 FOR ADDITIONAL REQUIREMENTS.
7. REFER TO DETAILS E7.02/1, E7.02/2 & E7.02/3 FOR ADDITIONAL REQUIREMENTS.
8. GROUNDING BAR KIT WITH SOLID COPPER GROUND BAR, INSULATORS AND SUPPORT BRACKETS, EQUAL TO CFI #10622-010. INSTALL 12" A.F.F. PROVIDE #6 AWG BACK TO WATER SERVICE PIPE.

OWNER REVIEW
NAME _____ DATE _____

05.30.08 ISSUED FOR BD
NO. DATE DESCRIPTION
ISSUE LOG
△ = CLOUDED CHANGE
Banknorth
1410 Congress Street
Portland, ME 04102

FIRST FLOOR PLAN
POWER

SCALE 1/4" = 1'-0"
DRAWN BY SFM
CHECKED BY [Signature]
PROJ. ARCH. / ENGR. SFM
PROJ. MGR. PJB
JOB NO. 07133.01
© SYMMES, MAINI & MCKEE ASSOCIATES, INC. 2008

E1.01