

OWNER REVIEW
 NAME _____ Date _____


5/30/08 ISSUE FOR BID
 NO. DATE DESCRIPTION
 ISSUE LOG
 = CLOUDED CHANGE

TD Banknorth
 1410 Congress Street
 Portland, ME 04102

FLOOR PLAN

SCALE 1/4" = 1'-0"
 DRAWN BY MVR
 CHECK BY T&W
 PROJ ARCH/ENGR JR/MVR
 PROJ MRG PJB
 JOB NO 07133.01
 © SYMMES, MAINI & MCKEE ASSOCIATES, INC. 2008

FP1.01

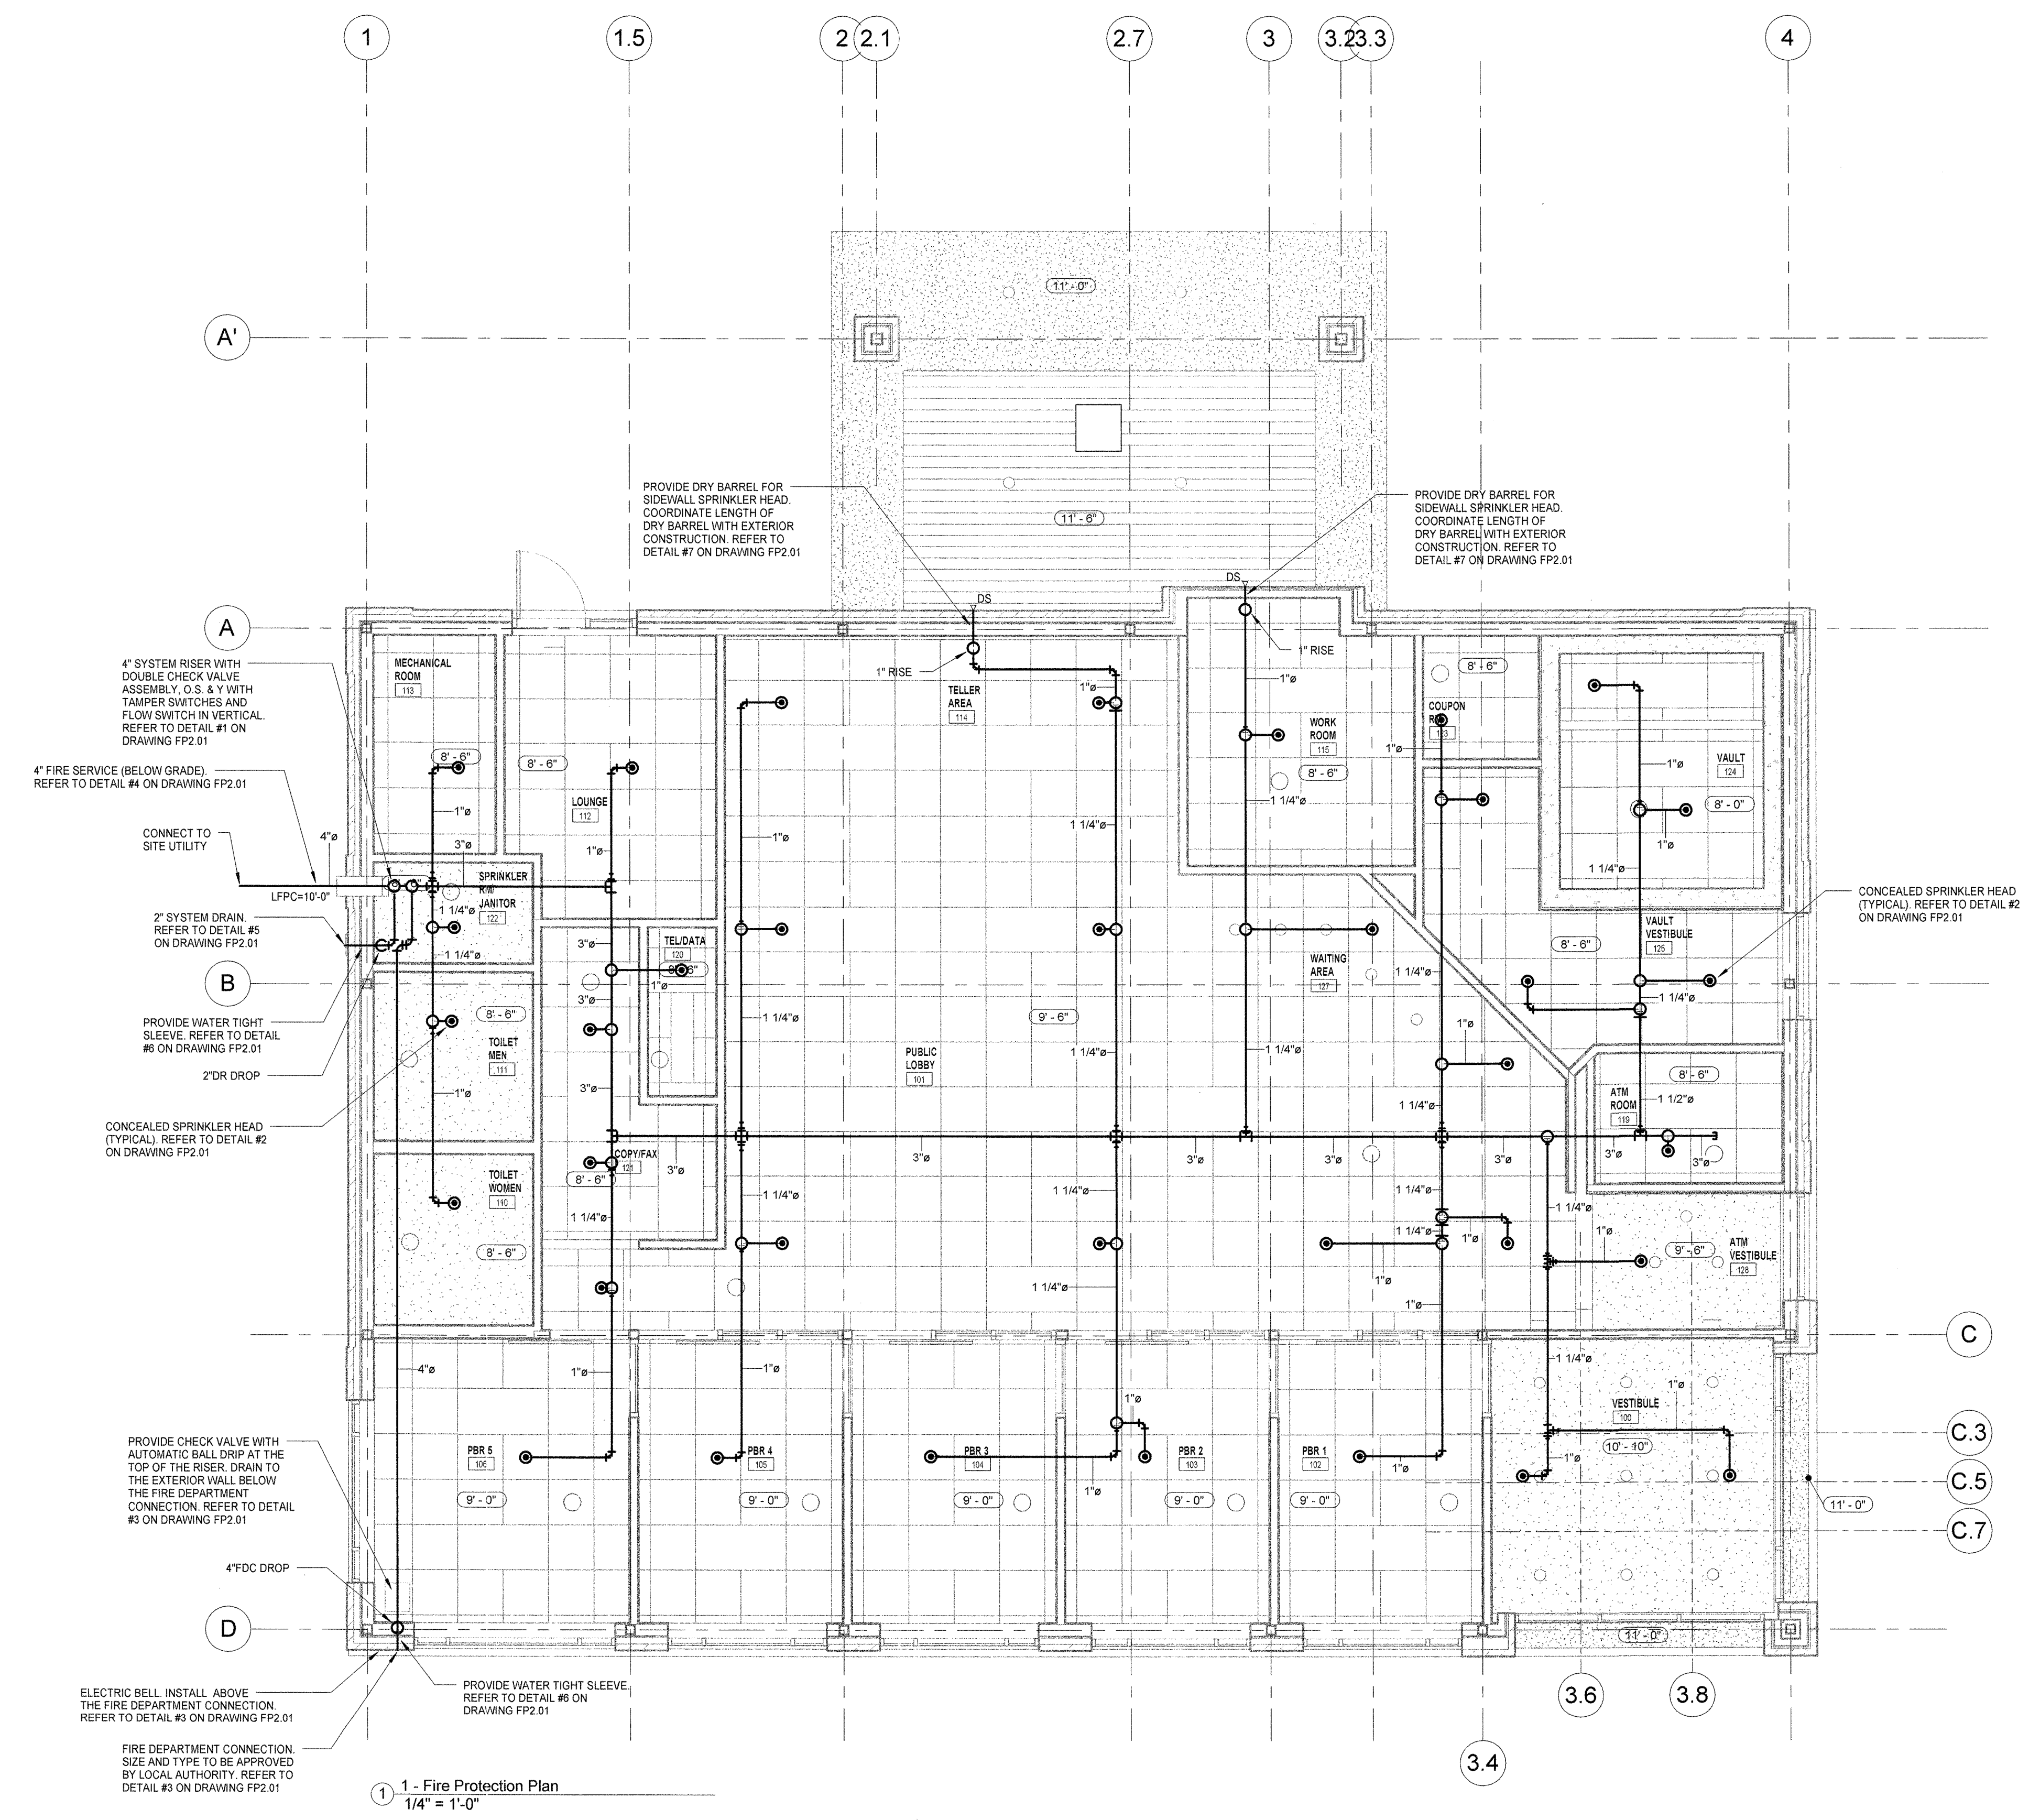

1 - Fire Protection Plan
 1/4" = 1'-0"