
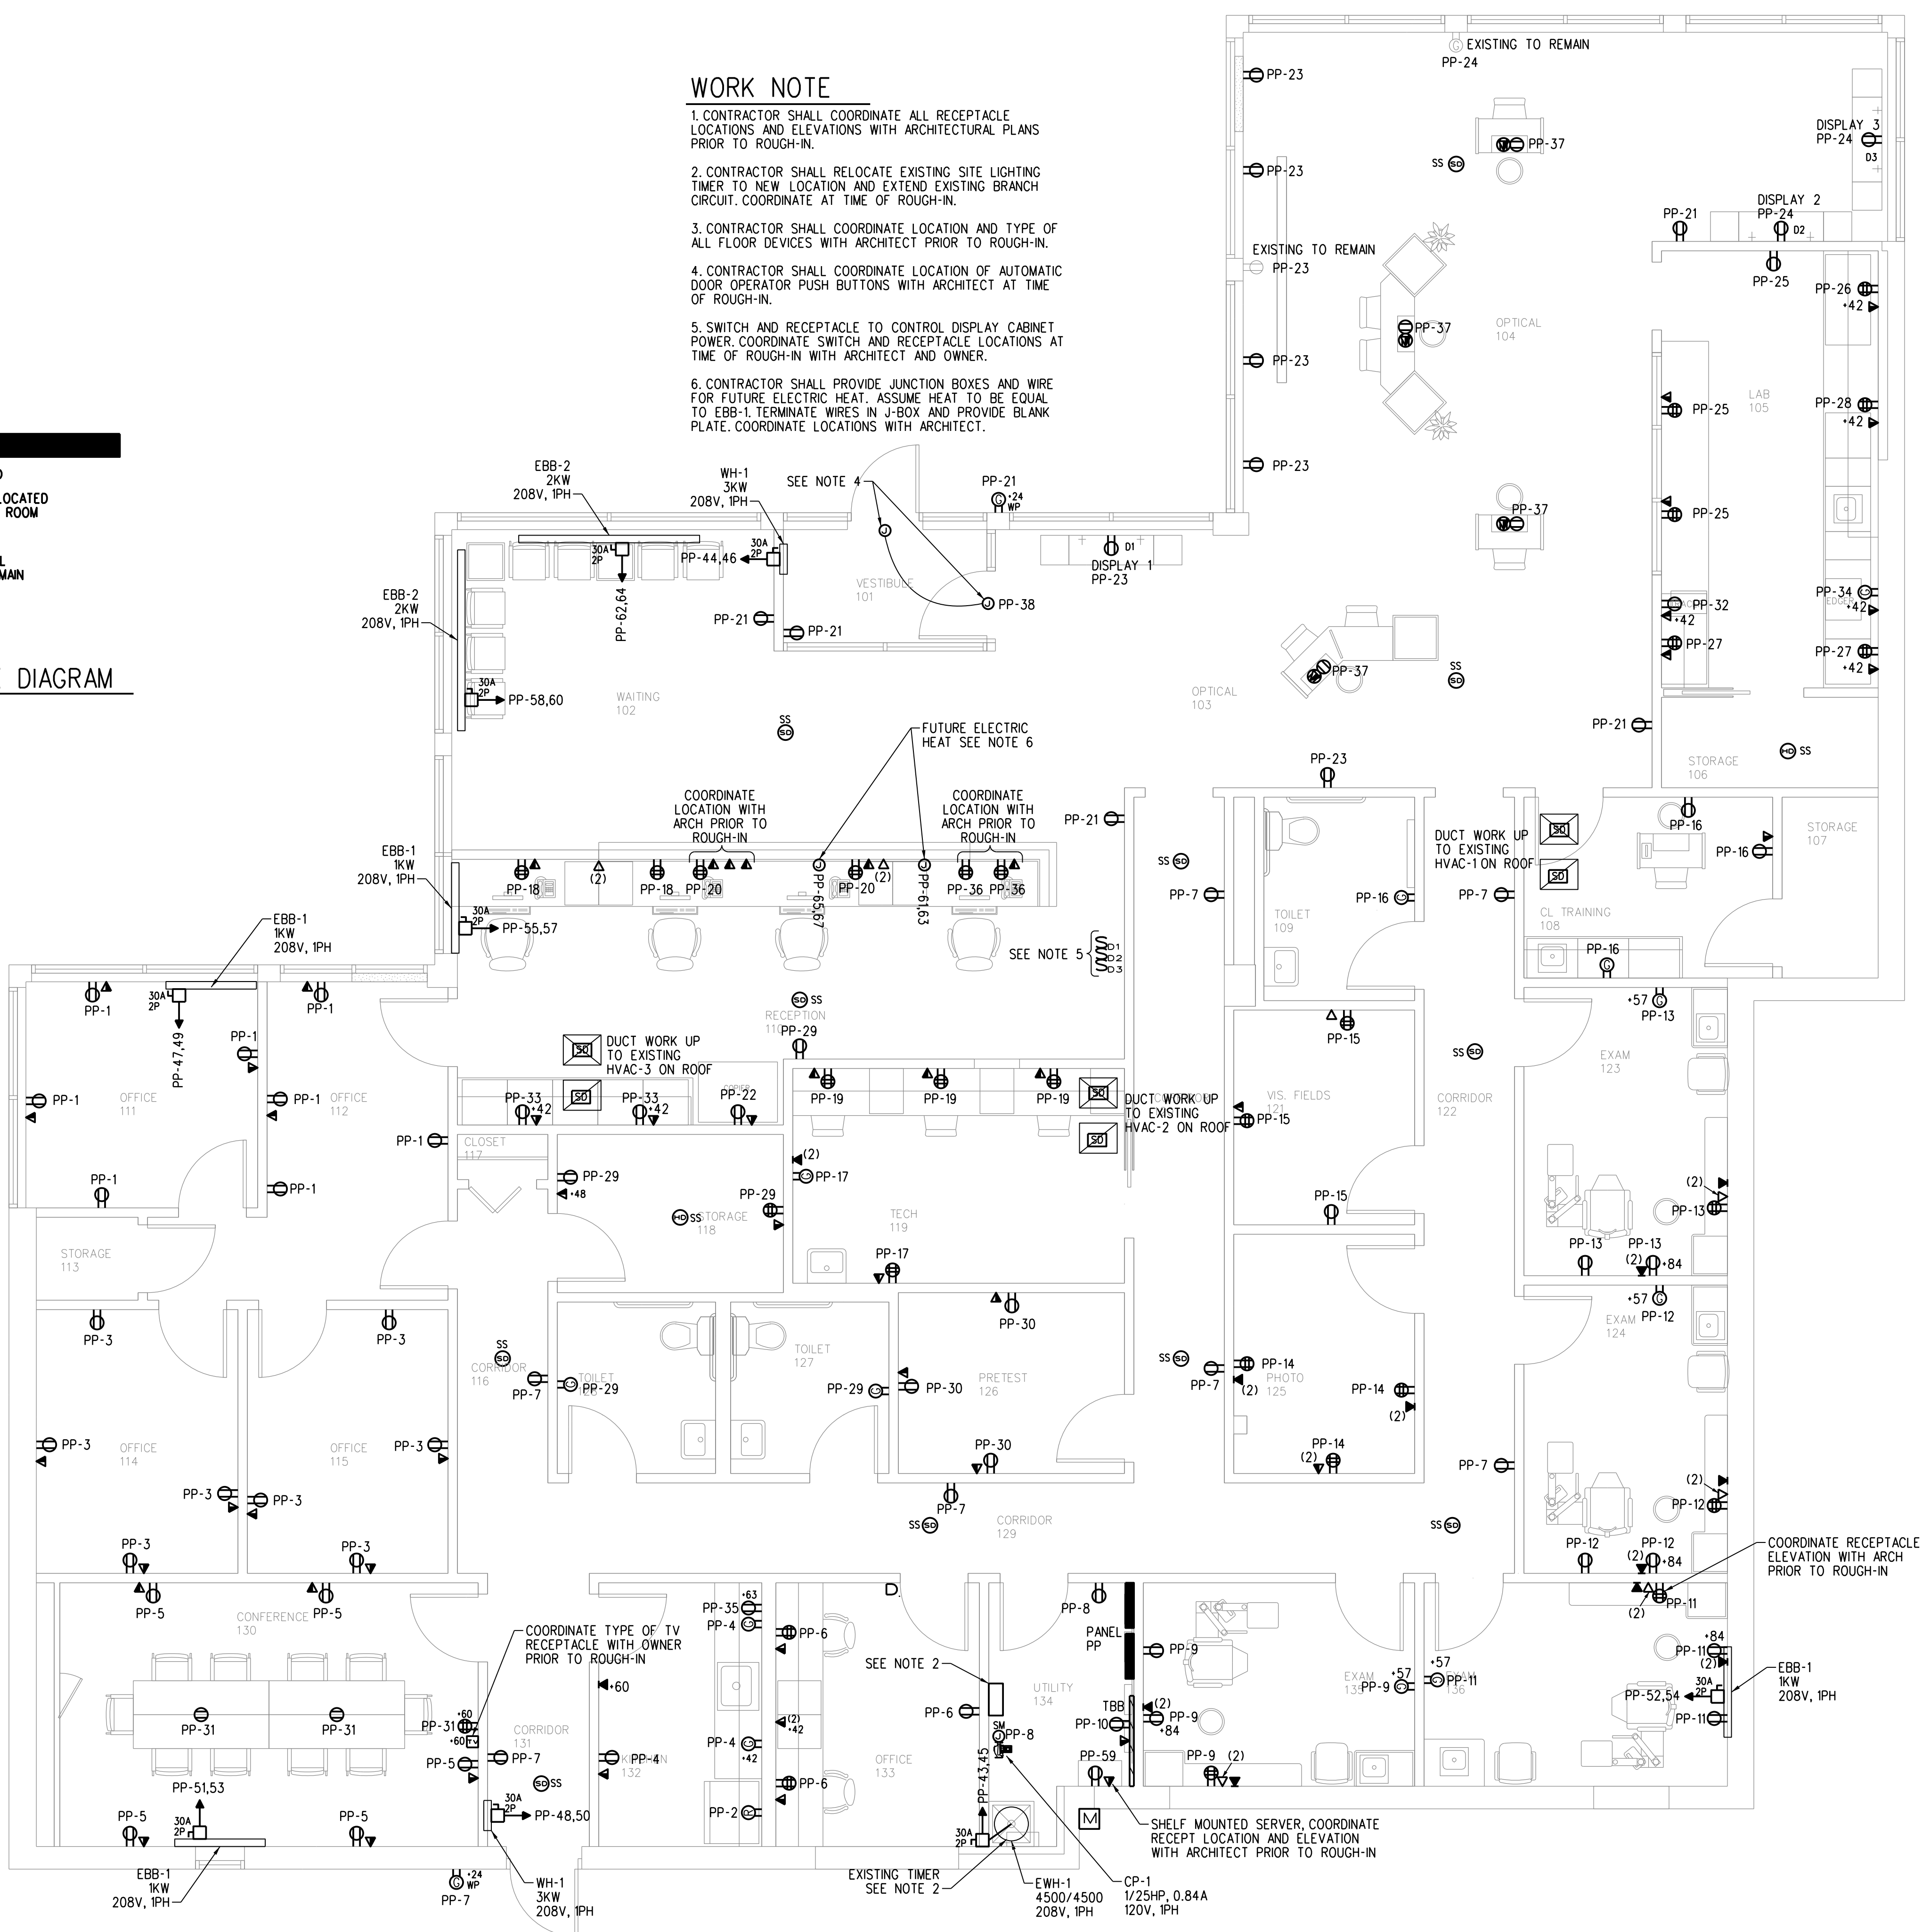


WORK NOTE

1. CONTRACTOR SHALL COORDINATE ALL RECEPTACLE LOCATIONS AND ELEVATIONS WITH ARCHITECTURAL PLANS PRIOR TO ROUGH-IN.
2. CONTRACTOR SHALL RELOCATE EXISTING SITE LIGHTING TIMER TO NEW LOCATION AND EXTEND EXISTING BRANCH CIRCUIT. COORDINATE AT TIME OF ROUGH-IN.
3. CONTRACTOR SHALL COORDINATE LOCATION AND TYPE OF ALL FLOOR DEVICES WITH ARCHITECT PRIOR TO ROUGH-IN.
4. CONTRACTOR SHALL COORDINATE LOCATION OF AUTOMATIC DOOR OPERATOR PUSH BUTTONS WITH ARCHITECT AT TIME OF ROUGH-IN.
5. SWITCH AND RECEPTACLE TO CONTROL DISPLAY CABINET POWER. COORDINATE SWITCH AND RECEPTACLE LOCATIONS AT TIME OF ROUGH-IN WITH ARCHITECT AND OWNER.
6. CONTRACTOR SHALL PROVIDE JUNCTION BOXES AND WIRE FOR FUTURE ELECTRIC HEAT. ASSUME HEAT TO BE EQUAL TO EBB-1. TERMINATE WIRES IN J-BOX AND PROVIDE BLANK PLATE. COORDINATE LOCATIONS WITH ARCHITECT.

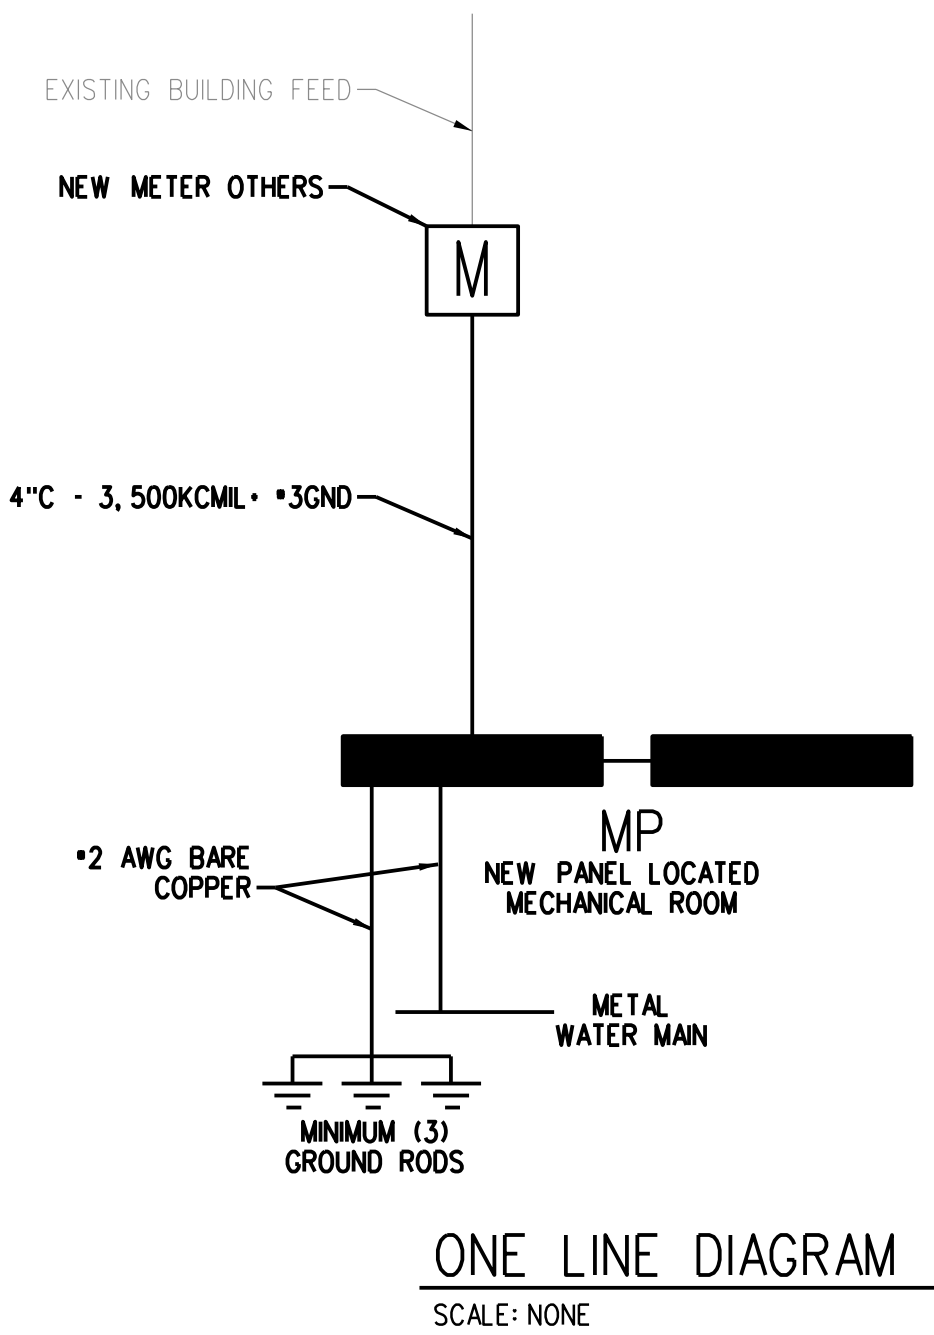

POWER PLAN

SCALE: 1/4"=1'-0"