


KITCHEN EQUIPMENT SCHEDULE

NO.	SUPPL'D	INSL'D	DESCRIPTION	QTY.	MANUFACTURER	MODEL	NOTES
1.1	G.C.	G.C.	MIRROR	2	BOBRICK		24" horiz. x 42" vert.
2	T.D.	G.C.	TOILET PAPER HOLDER	2			Surface Mounted (Consult with Tim Hortons field engineer)
3.2	G.C.	G.C.	ELECTRIC HAND DRYER	2	NOVA	NOVA 1	Surface mounted ADA/ANSI compliant. Color: White
4A	G.C.	G.C.	42" GRAB BAR	2	BOBRICK	B-680x42	
4B	G.C.	G.C.	36" GRAB BAR	2	BOBRICK	B-680x36	Supplied by finished carpentry section
5	T.D.	G.C.	SOAP DISPENSER - HAND SINK AREA	2			
5.1	T.D.	G.C.	SOAP DISPENSER - WALL MOUNTED	3	BOBRICK	B-2111	Liquid Soap Surface mounted
6	T.D.	G.C.	RECEIVER (MUZAK)	1	PANASONIC	SA160K	On shelf - electrician to supply & connect speakers
8.2	T.D.	T.D.	BAG-N-BOX W/ CARBONATOR	1	COKE		43"
16.3	T.D.	T.D.	IN-STORE CAMERA	6	PANASONIC	KV-BP140	Location to suit. Tim Hortons's field engineer
20.12	T.D.	G.C.	3 COMPARTMENT SINK	1	S 4 G		(72" Long)
22.1	T.D.	G.C.	FIRE EXTINGUISHER WITH RECESSED CABINET	2			
22.2	T.D.	G.C.	FIRE EXTINGUISHER WALL SURFACE MTD.	1			
24.2	T.D.	T.D.	POWER WHISK MIXER	1	DYNAMIC	FT197	
25	T.D.	T.D.	REGULAR KEEPER	1	ASTRON	RA-70 AR15 M15	
26.5	S.F.C.	G.C.	ALWAYS FRESH FINISHING TABLE (6'-0")	1	S 4 G		
27.1	T.D.	T.D.	DRIVE-THRU MONITOR (WALL MOUNTED)	1	PANASONIC		C/W Monitor Bracket #VMB-9 by CBM Metal
27.3	T.D.	T.D.	SANDWICH MONITOR (WALL MOUNTED)	5	PANASONIC		
28	T.D.	G.C.	HOT WATER MACHINE	1,1F	BUNN- O-MATIC	HK2	
29.1	T.D.	G.C.	PAPER TOWEL DISPENSER ROLL	2	FROST	126	
29.2	T.D.	G.C.	PAPER TOWEL DISPENSER	1	FROST	101	
31	T.D.	T.D.	WIRELESS BASE STATION	1	HME/S/M/PANASONIC		
32	T.D.	T.D.	BATTERY CHARGER	1	HME/S/M/PANASONIC		
33	T.D.	T.D.	HARDWARE RECEIVER	1	HME/S/M/PANASONIC		
35.3	T.D.	G.C.	DISHWASHER	1	TEMPSTAR	208/230/3 PHASE	
37.10	T.D.	T.D.	CASH REGISTERS	4	PANASONIC	7500	Insulated, isolation outlet
38.8	S.F.C.	S.F.C.	SANDWICH UNIT (5'-0")	1	S 4 G		SC-60
40.1	S.F.C.	S.F.C.	LID DISPENSER - HOT	3	S 4 G		HOT
40.3	S.F.C.	S.F.C.	ICED CAPPUCCINO LID DISPENSER	1	S 4 G		COLD
42.4	T.D.	T.D.	MICROWAVE OVEN (STANDARD)	2	PANASONIC	NE 1054	On shelf (D17)
43	T.D.	G.C.	WALL SHELVING 12" DEEP	--	155		VARIES Consult Tim Hortons's field engineer - See plan
44.1	T.D.	T.D.	BEVERAGE FOUNTAIN W/ ICE BIN	1	WILSHIRE	DRINKMASTER II	15' X 22"
46.3	T.D.	T.D.	BAGEL TOASTER - TURBO	1	STAR MFG.	OC53-1600B	
47.7	S.F.C.	G.C.	SEATING PACKAGE WATERFALL (FREE)	--	PETER ANTHONY		Waterfall Free-standing
49	T.D.	G.C.	WALK-IN SHELVING	6	155		See plan
50.2	T.D.	T.D.	FAX MACHINE - STANDARD	1	PANASONIC		Connect to incoming line before any phone
51	T.D.	G.C.	PRECAST STONE GARBAGE UNIT	--	HASSAU	TF1025	
51.1	T.D.	G.C.	PRECAST STONE ASHTRAY UNIT	--	HASSAU	TF2045	
52.6	T.D.	T.D.	FASCIA SIGN - 42"	3	CUSTOM SIGNS		Verify w/ Tim Hortons's field engineer
53.1	G.C.	G.C.	VANITY SINGLE BOWL	2	KARADON/SINGLE		
55.4	T.D.	G.C.	MOISTURE PLUS - 1/2 SIZE ELECT. OVEN	1	GARLAND	MP05L	Oven with drain and vent kit
57.1	T.D.	T.D.	MINI FONDANT WARMER	1	GARLAND	EPN-400	
58.9	S.F.C.	S.F.C.	30" CAKE DISPLAY	1	S 4 G		
62.4	T.D.	G.C.	ICE MACHINE	1	HOSHIZAKI	F-450MAH	
63	T.D.	G.C.	SUSPENDED STORAGE SHELVING (METAL)	8	155		Height above floor varies - See I.S.S. drawings
64	T.D.	G.C.	DRY STORAGE SHELVING (METAL)	2	155		VARIES See plan
66.3	T.D.	G.C.	ICER CREAMER-DUAL VOLUME (STANDARD)	3	SURE SHOT	AC10	
67.4	T.D.	G.C.	HOT POWERED DRINK MACHINE (STANDARD)	1	BUNN	FMD DBC-3	
68.1	T.D.	G.C.	COFFEE BREWER	5	BUNN-O-MATIC	S7S 35	

S.F.C. STORE FIXTURE COMPANY
T.D. TIM DONUT LIMITED
G.C. GENERAL CONTRACTOR
F. FUTURE
PO POSSIBLE OPTION

STORE FIXTURE SCHEDULE

NO.	SUPPL'D	INSL'D	DESCRIPTION	QTY.	MANUFACTURER	MODEL	NOTES
144	T.D.	G.C.	ICED COFFEE CHILLER	--	FRANKE		
147	T.D.	T.D.	BIOHAZARD KIT	1	NEATH	I27670	COORDINATE LOCATION/MOUNTING WITH T.D.L. REPRESENTATIVE
148	T.D.	T.D.	FIRST AID KIT	1	VARIES	VARIES	COORDINATE LOCATION/MOUNTING WITH T.D.L. REPRESENTATIVE
D1	S.F.C.	S.F.C.	MAIN COFFEE STATION	1	S 4 G		
D2	S.F.C.	S.F.C.	SECOND COFFEE STATION	1	S 4 G		
D4	S.F.C.	S.F.C.	GLASS GUARD	7	S 4 G		
D8	S.F.C.	S.F.C.	DRIVE-THRU DONUT WALLCASE	1	S 4 G		
D9	S.F.C.	S.F.C.	DRIVE-THRU CASH COUNTER	1	S 4 G		
D10	S.F.C.	S.F.C.	DRIVE-THRU BACK BAR	1	S 4 G		
D11	S.F.C.	S.F.C.	BACK BAR	1			
D14	S.F.C.	S.F.C.	CAFE DOOR AND FRAME	1	S 4 G		
D17	S.F.C.	S.F.C.	MICROWAVE SHELF	--	S 4 G		
D17J	S.F.C.	S.F.C.	MICROWAVE SHELF - WHITE MELAMINE	2	S 4 G		
D21b	S.F.C.	S.F.C.	3' DISPLAY MERCHANDISER	1	S 4 G		
D22	S.F.C.	S.F.C.	LOW PARTITION	3	S 4 G		
D23	S.F.C.	S.F.C.	WAINSCOTING	--	S 4 G		
D24	S.F.C.	S.F.C.	WINDOW SILL	7	S 4 G		
D27	S.F.C.	S.F.C.	TRAINING CABINET	1	S 4 G		
D34a	S.F.C.	S.F.C.	GARBAGE UNIT W/TRAY STORAGE	3	S 4 G		
D45.2	S.F.C.	G.C.	PORTAL CABINET	1	S 4 G		
D53	S.F.C.	S.F.C.	MERCHANDISER	2	S 4 G		

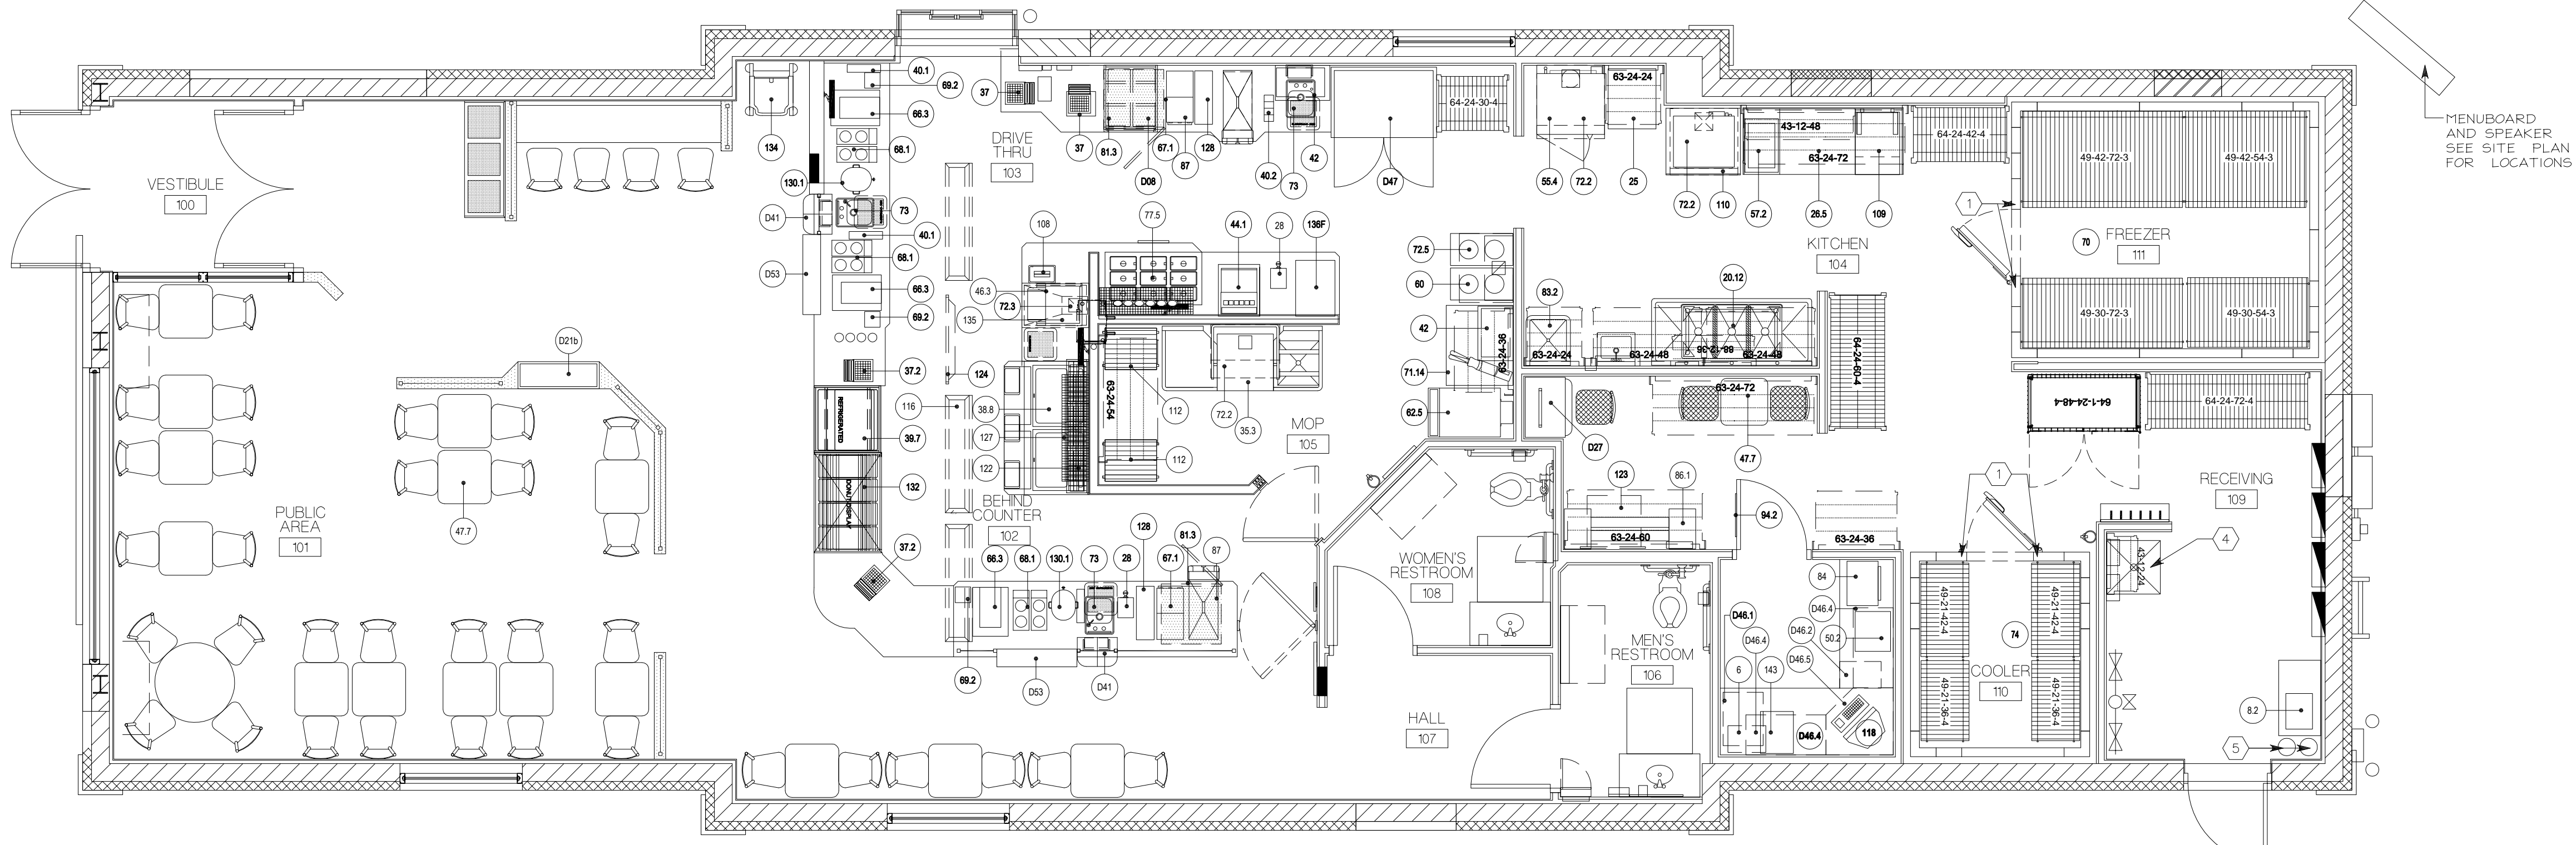

EQUIPMENT PLAN
SCALE 1/4" = 1'-0"

- GENERAL NOTES
- COORDINATE EQUIPMENT PACKAGE W/ TDL REPRESENTATIVE
 - G.C. RESPONSIBLE FOR UNLOADING AND PLACING EQUIPMENT IN STORE.
 - G.C. TO PROVIDE SOLID WOOD BLOCKING IN WALLS FOR ALL WALL MOUNTED EQUIPMENT AND ACCESSORIES.
 - G.C. TO PROVIDE BLOCKING BETWEEN TRUSSES AS REQUIRED FOR OVERHEAD SUSPENDED SHELVING
 - QUANTITY AND LOCATION OF SECURITY CAMERAS TO BE DETERMINED BY TIM HORTONS.

- FLOOR PLAN NOTE LEGEND
- FREEZER / COOLER MFG. TO PROVIDE STAINLESS STEEL CLOSURE ANGLE.
 - ROUGH-IN FOR FUTURE HOT BUTTON. SEE ELECTRICAL SHEETS FOR ADDITIONAL INFORMATION.
 - WATER HEATER, SUPPLIED BY T.D. AND INSTALLED BY G.C. SEE PLUMBING PLAN FOR MANUFACTURER AND MODEL NUMBER.
 - MOP SINK, PROVIDED AND INSTALLED BY CONTRACTOR. SEE PLUMBING SHEETS.
 - CO2 TANK, PROVIDE SAFETY CHAIN. ATTACHED TO WALL.
 - WALL TRACKING

STORAGE SHELVING LEGEND

SHELVING TYPE	ITEM-DEPTH-LENGTH-TIERS	QUANTITY
OVERHEAD SHELVING #43	43-12-48	1
OVERHEAD SHELVING #58	88-12-36	1
OVERHEAD SHELVING #63	63-24-24 63-24-36 63-24-42 63-24-48 63-24-54 63-24-60 63-24-72	2 2 -- 1 1 1 2
FLOOR SHELVING #64	64-24-42-4 64-24-72-4	-- --
WALK-IN SHELVING #49	49-24-54-4 49-42-54-5	-- --

- NOTES:
- PROVIDE METAL SHELVING AS INDICATED ON DRAWINGS.
 - REFER TO INTERIOR ELEV. SHEET A9 FOR SHELVING HEIGHTS.
 - PROVIDE BLOCK/BACKING IN WALLS & CEILING AS REQUIRED FOR SHELF SUPPORT.

REVISONS:
DATE ISSUED: 07-02-2008
*INCLUDES REVISION TO THIS SHEET

Atlanta
Boston
Chicago
Dallas
Los Angeles
Miami
Sacramento

wd partners

7007 Discovery Blvd
Dublin, OH 43017
614.834.7777 F
wdpartners.com

Tim Hortons
1408 CONGRESS STREET
PORTLAND, ME 04102

EQUIPMENT PLAN
DRAWN BY: DDS
CHECKED BY: JPY

SAI # 0818
DRAWING NUMBER: A3