
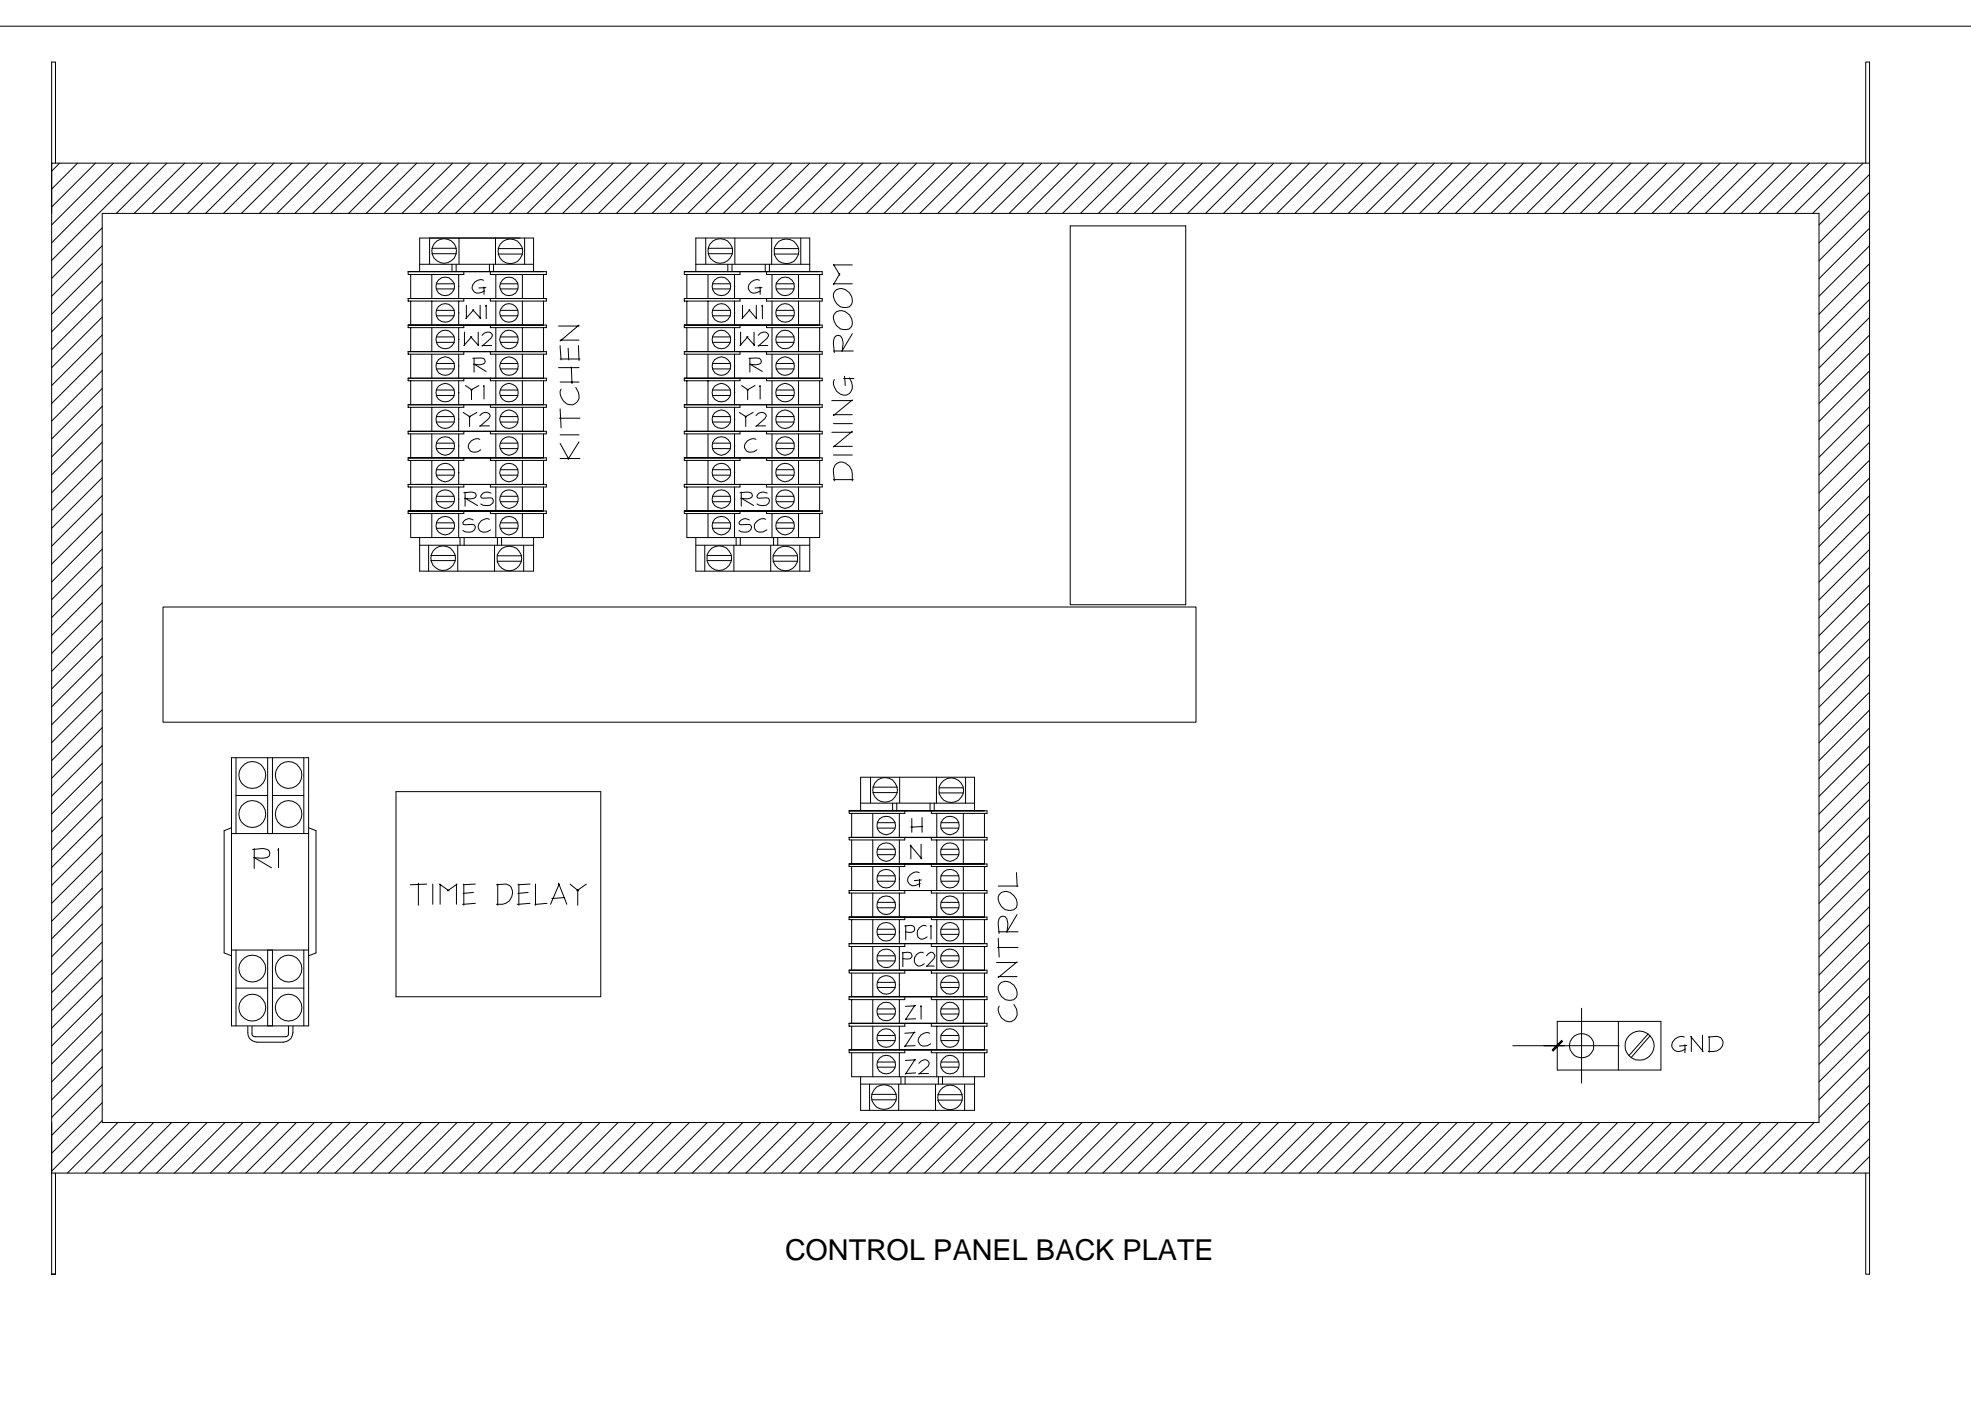


**LEGEND**

- P-#-# = CONNECTOR TAB NUMBER
- ◁ = MOLEX CONNECTOR
- = ENCLOSURE TERMINALS HVAC
- ⊕ = ENCLOSURE TERMINALS - CONTROL
- ⊗ = WIRE NUT
- ⊚ = NYLON CRIMP SPLICE AT PANEL
- ⊙ = MARKED TERMINAL
- = FIELD WIRING
- - - = FACTORY WIRING
- · - · - = FIELD MTD. DEVICE

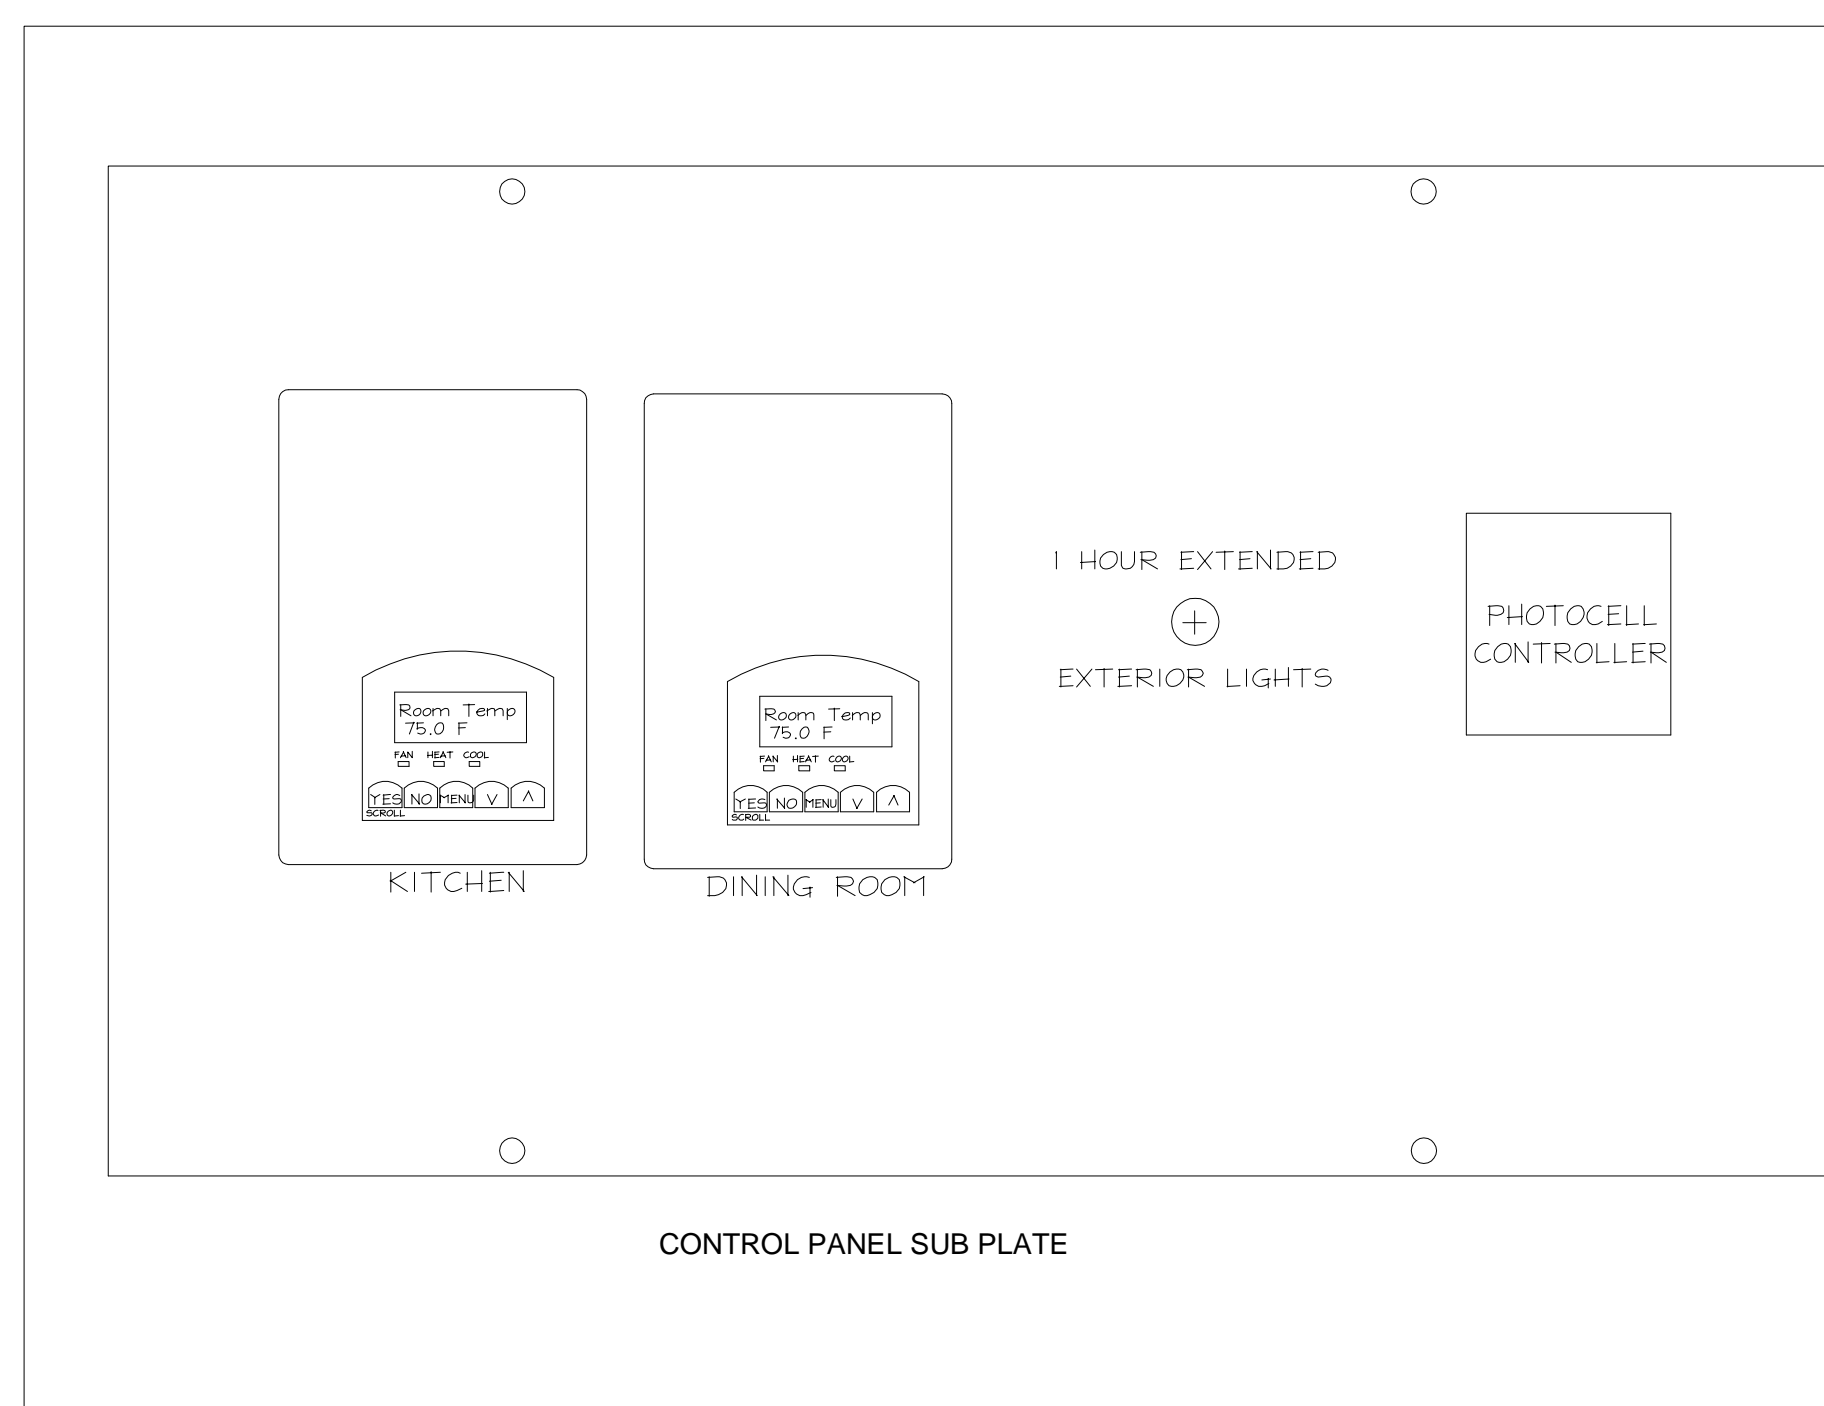

REVISIONS:

DATE ISSUED: 07-02-2008

The construction documentation contained on this sheet was not prepared by WD Partners, Inc. and is included within this set FOR REFERENCE ONLY for informational purposes pertaining to this project. WD Partners, Inc. did not review the construction documentation on this sheet for omissions, accuracy or completeness and by including this sheet within this set, WD Partners Inc. does not represent that such construction documentation on this sheet is accurate, complete and that information has not been omitted, or that it complies with applicable codes, restrictions and local requirements.

**Tim Hortons**  
1408 CONGRESS STREET  
PORTLAND, ME 04102

**TEMPERATURE & LIGHTING CONTROL SCHEMATICS AND PANEL DIAGRAMS**

FOR REFERENCE ONLY

SAI # 08138  
DRAWING NUMBER: M4

DRAWN BY: KRO CHECKED BY: JTP