


Portland International
Jetport

1001 Westbrook Street
Portland, Maine 04102


2020 K Street, Northwest
Suite 200
Washington DC 20006
Telephone 202.721.5200
Facsimile 202.872.8587

Gensler

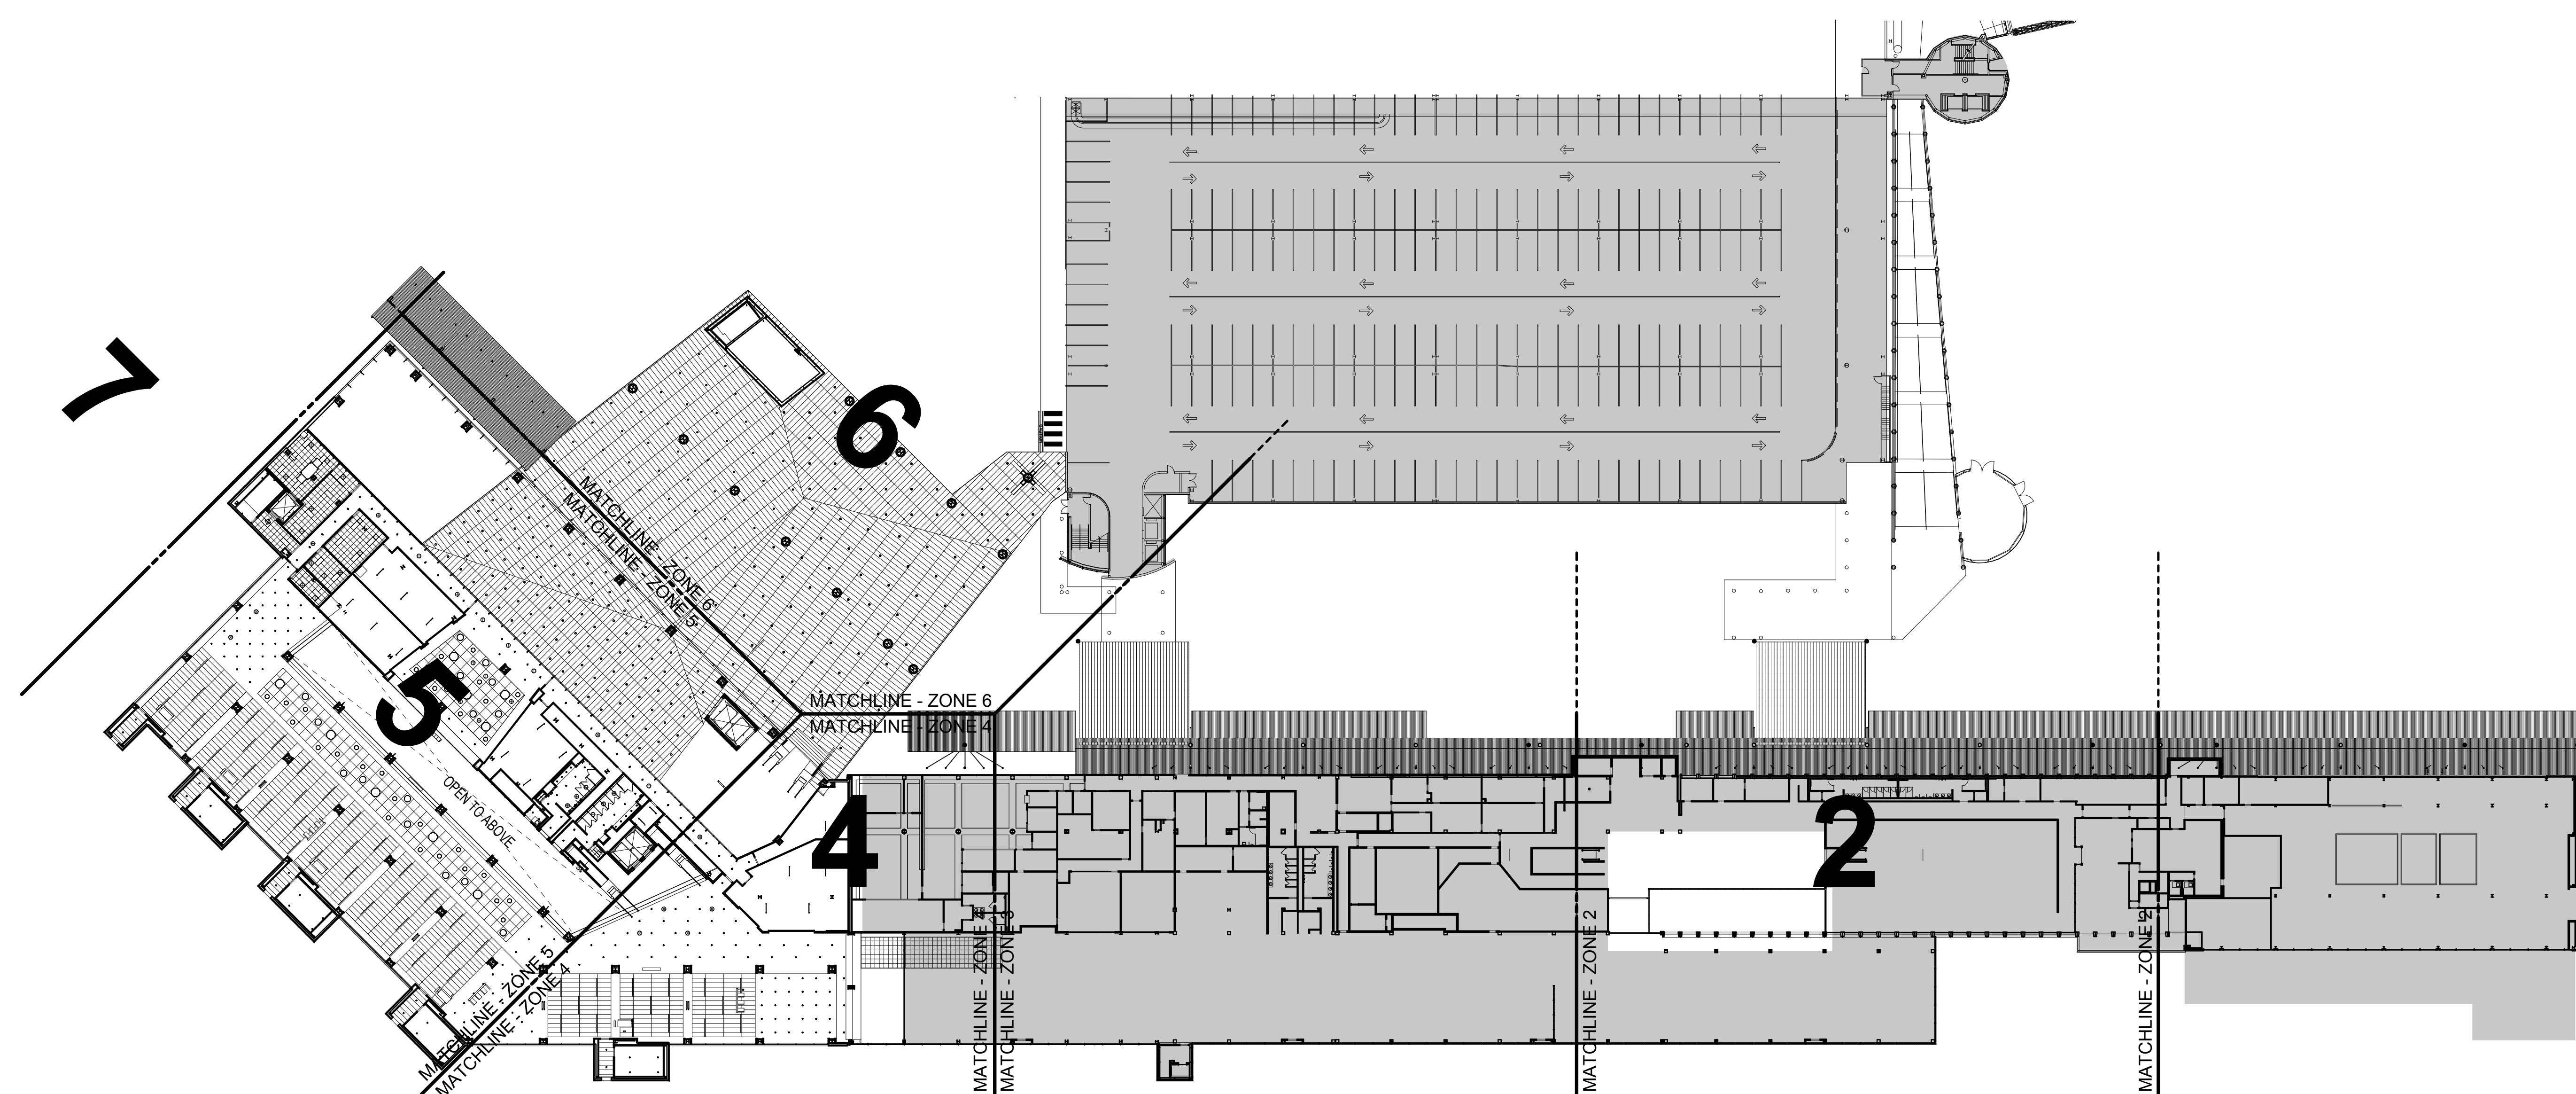

Issue	Date & Issue Description	By	Check
01	07/11/08		
02	09/22/08		
03	12/03/08		
04	01/23/09		
05	10/26/09		

Seal/Signature

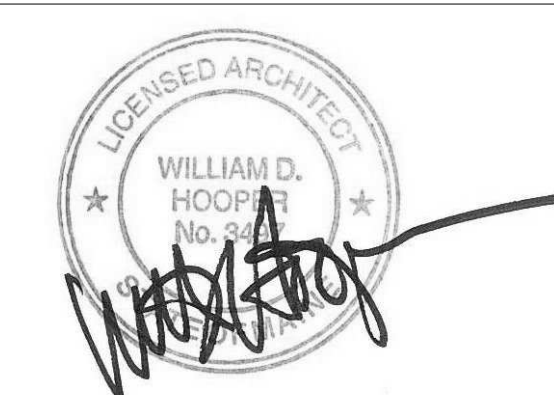


Project Name
PWM Terminal Enhancement

Project Number
09.6395.000

Description
REFLECTED CEILING PLAN - LEVEL 3 - ZONING DIAGRAM

 Scale
1" = 40'-0"



A04.03.00

© 2009 Gensler