

ELECTRICAL POWER PLAN - LEVEL 1 - ZONE 5

SCALE: 1/8" = 1'-0"


SHEET NOTES

- 01 JUNCTION BOX FOR CONNECTION TO DRINKING FOUNTAIN.
- 02 PROVIDE PULL BOX FOR CONNECTION TO ELECTRICAL PANEL (PPB) INDICATED. PPB SHALL BE PROVIDED BY BAGGAGE HANDLING CONSULTANTS. CONTRACTOR RUN CONDUCTORS THROUGH PULL BOX AND LEAVE 20' OF EXTRA CABLE COILED NEATLY. TERMINATION OF CONDUCTORS SHEET SHALL BE DONE BY OTHERS. SEE SHEET E1A01 FOR CONDUIT AND WIRE SIZE.
- 03 RESETPAGE FOR CONNECTION TO SUMP PUMP MANUFACTURER CONNECTION WITH PUMP MANUFACTURER.
- 04 PROVIDE LIBERTY MENTY MODEL OR EQUAL. PROVIDE WITH MAINTENANCE BYPASS CABINET & 10 MINUTES AT FULL LOAD RUN TIME.
- 05 SEE ONE-LINE DIAGRAM ON SHEET E1A01 FOR CONDUIT AND CONDUCTOR SIZES ASSOCIATED WITH THIS EQUIPMENT.

GENERAL NOTES

- A SEE SHEET E02.00 FOR LEGEND AND GENERAL NOTES.
- B CONTRACTOR SHALL REFER TO FIRE ALARM, SECURITY, IT, AND PUBLIC ADDRESS SYSTEMS DRAWINGS FOR CONDUITS & WIRING REQUIREMENTS.

KEY PLAN

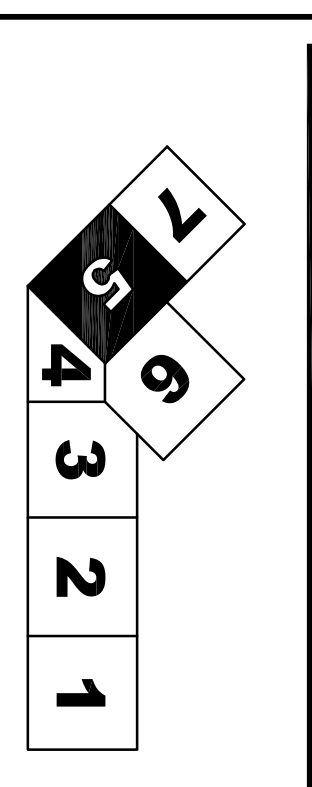

Portland International Jetport
 1001 Westbrook Street
 Portland, Maine 04102

Gensler
 2001 K Street, NW
 Suite 200
 Washington, DC 20006
 Telephone: 202.221.5200
 Fax: 202.221.5205

oast ASSOCIATES, INC.
 3600 Greenway Plaza, Suite 1000, Houston, TX 77046
 Engineers - Architects - Surveyors - Construction Managers

Issue	Date & Issue Description	By	Checked
01	07/11/08 10% DC DESIGN	LAM	BHG
02	09/22/08 DESIGN DEVELOPMENT	LAM	BHG
03	12/03/08 75% CONSTRUCTION DOCUMENTS	LAM	BHG
04	01/23/09 90% CONSTRUCTION DOCUMENTS	LAM	BHG
05	ISSUED FOR PERMIT	LAM	BHG

Project Name: PIMA Terminal Enhancement
 Project Number: E02.01.05
 Drawing Number: E02.01.05
 Designer: [Signature]
 Checker: [Signature]
 Title Block: ELECTRICAL POWER PLAN - LEVEL 1 - ZONE 5
 Scale: 1/8" = 1'-0"
 Ref. North