

SHEET NOTES

- 01 POWERS FOR ITS DEVICES SHALL BE COORDINATED AT A LATER DATE.
- 02 ROLL DOWN SWITCHES COORDINATE EXACT CONNECTION POINT WITH VENDOR.
- 03 PROVIDE GFCI TYPE RECEPTACLE IN THE SPACE. COORDINATE LOCATION AND INSTALLATION WITH THE ESCALATOR CONTRACTOR.
- 04 CONNECT DISCONNECT SWITCH TO JUNCTION BOX/TERMINAL BOX PROVIDED BY THE ESCALATOR CONTRACTOR IN THE UPPER LEVEL MACHINE SPACE. COORDINATE LOCATION AND INSTALLATION WITH ESCALATOR CONTRACTOR.
- 05 POWER FOR PTZ CAMERA. COORDINATE EXACT LOCATION WITH SECURITY CONTRACTOR.


Portland International
Jetport

1001 Westbrook Street
Portland, Maine 04102

2025 N Street, NW
Suite 200
Washington, DC 20006
Telephone 202.721.5200
Facsimile 202.721.5297

Gensler


oast ASSOCIATES, INC.
3400 Greenway Drive, Suite 400, Columbia, MD 21046
1501 17th Street, NW, Suite 200, Washington, DC 20036
Engineers • Architects • Planners • Construction Managers

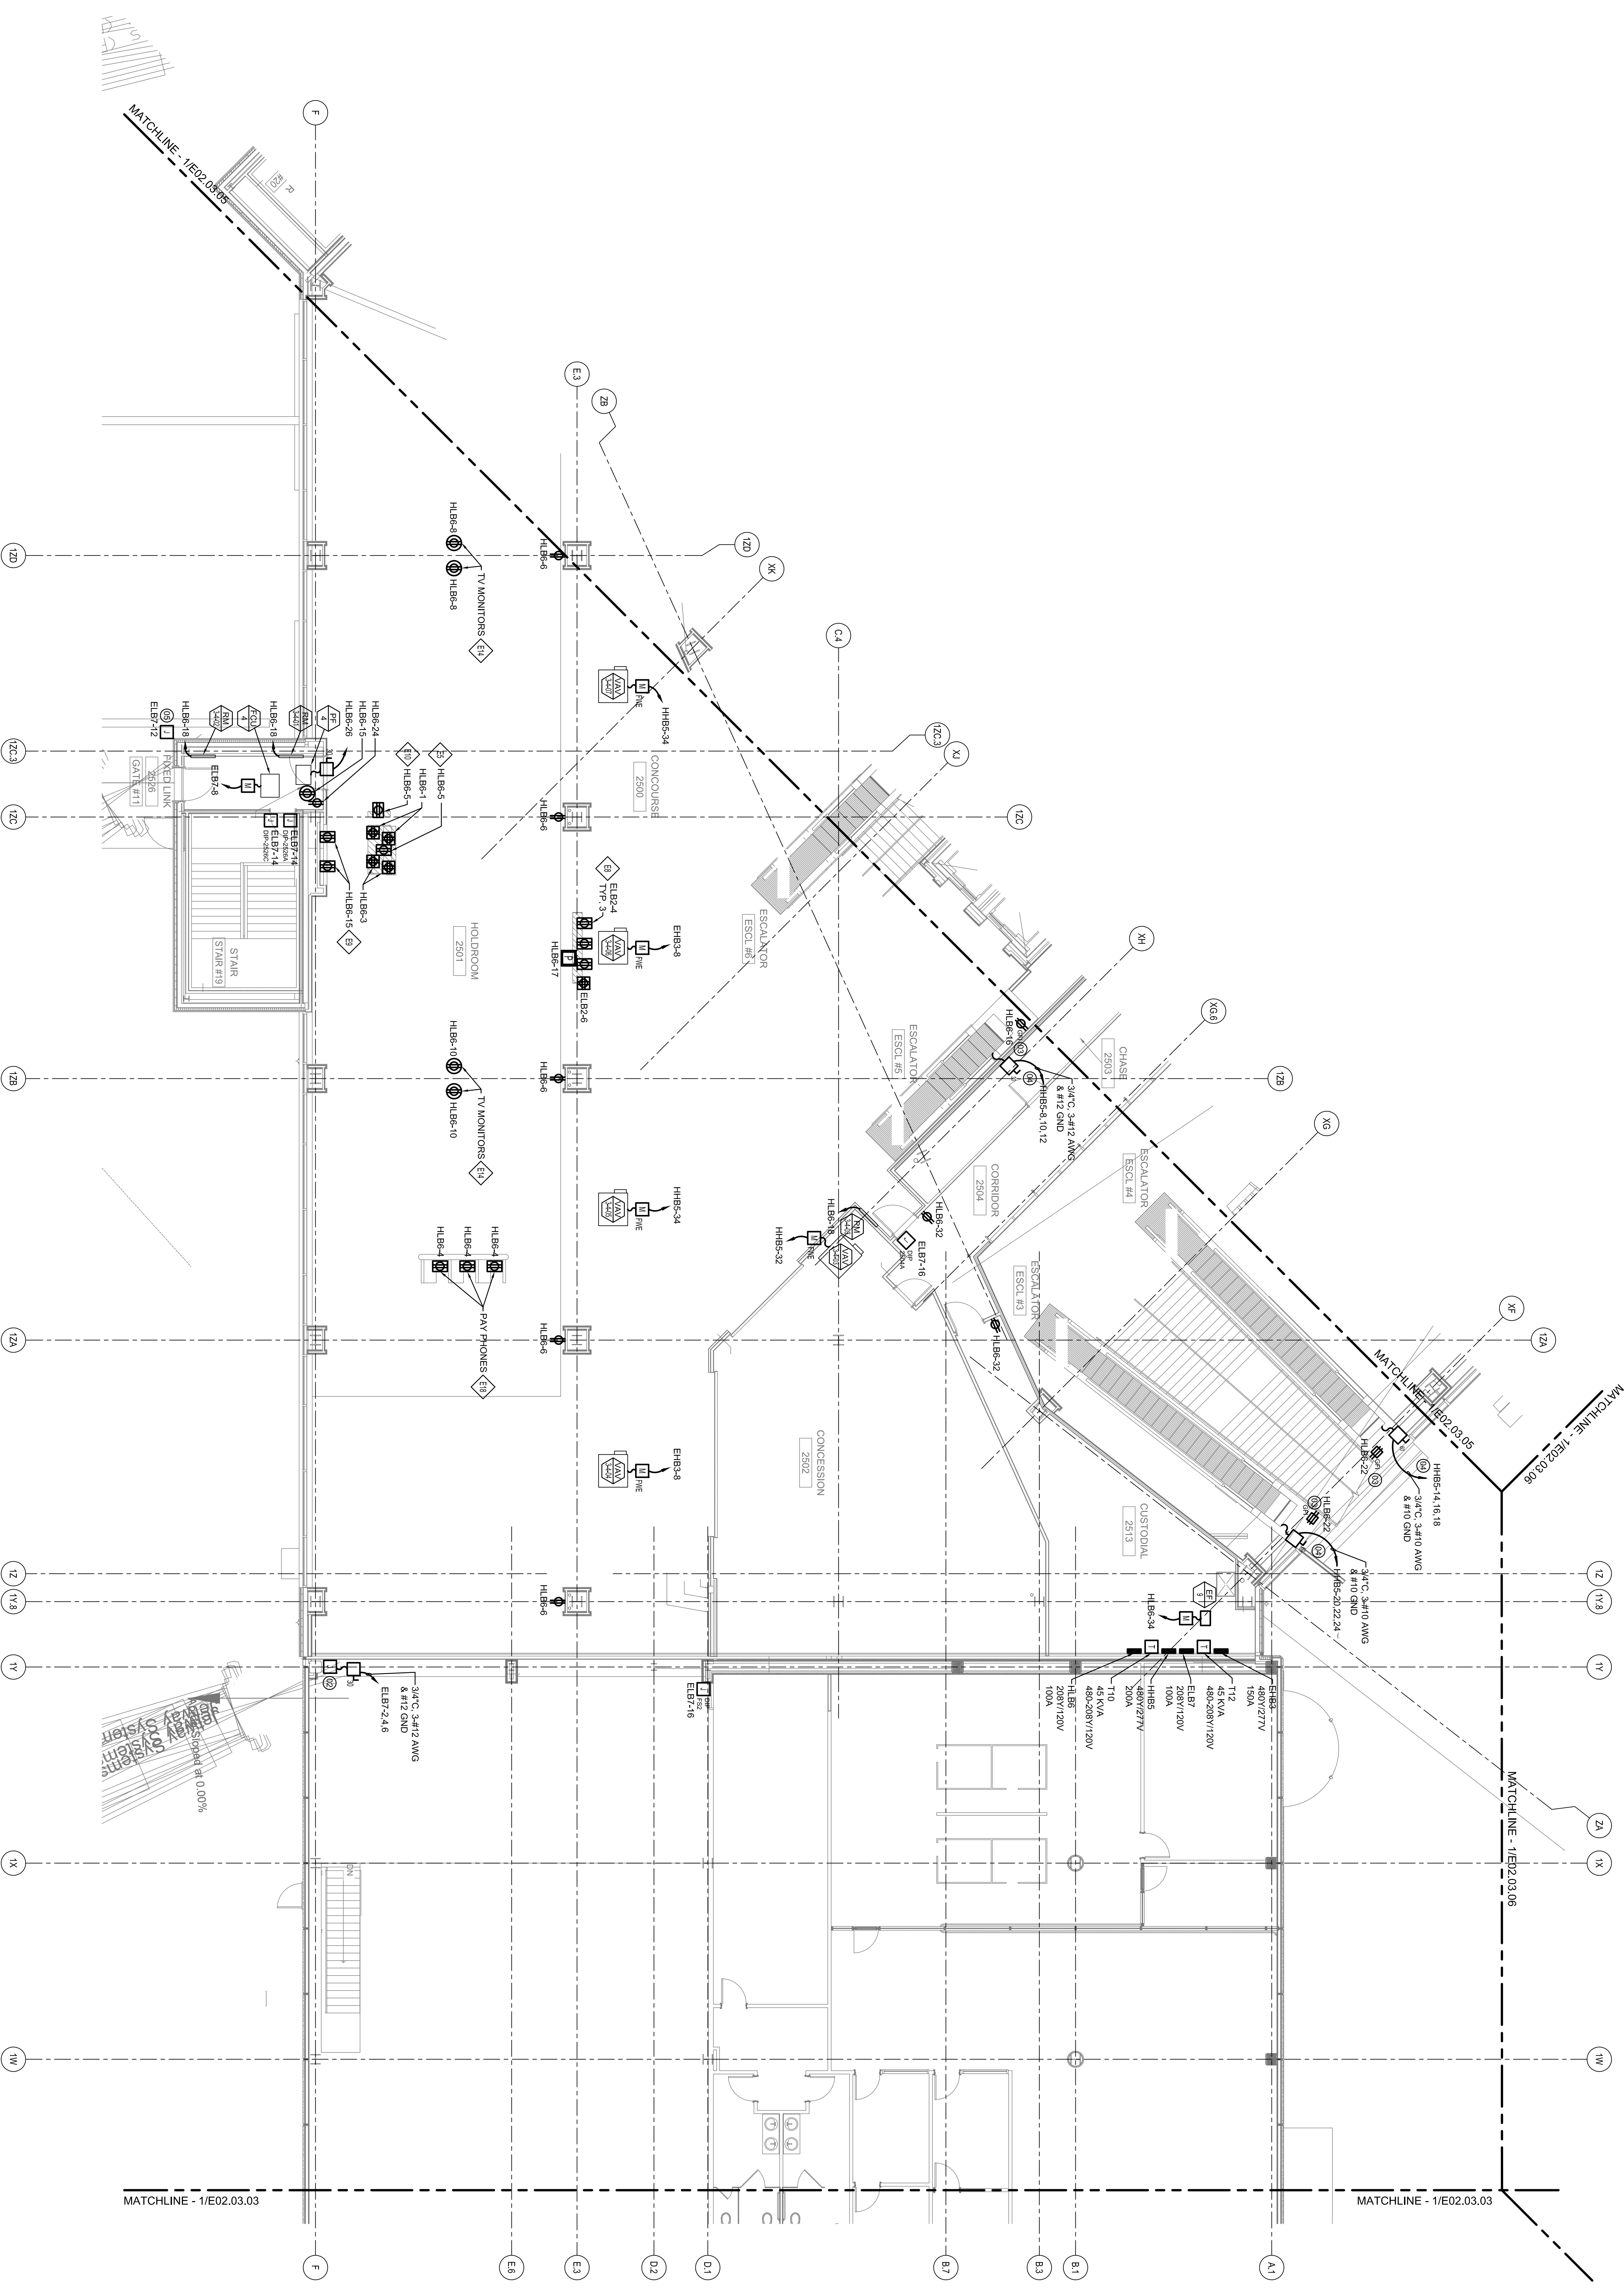

GENERAL NOTES

- A SEE SHEET E02.03.00 FOR LEGEND AND GENERAL NOTES.
- B CONTRACTOR SHALL REFER TO FIRE ALARM, SECURITY, IT, AND PUBLIC ADDRESS SYSTEMS DRAWINGS FOR CONDUITS & WIRING REQUIREMENTS.

KEY PLAN

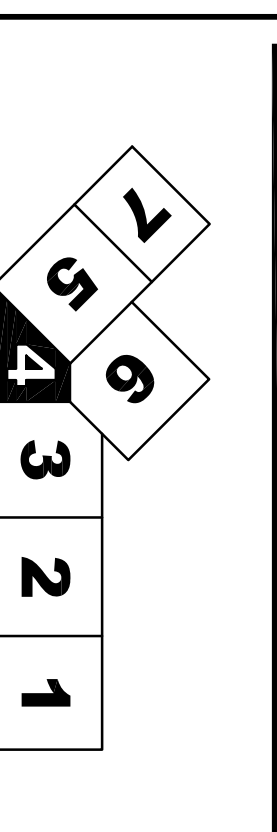

Issue	Date & Issue Description	By	Checked
01	07/11/2018	LAM	BHG
02	09/22/2018	LAM	BHG
03	12/20/2018	LAM	BHG
04	01/23/2019	LAM	BHG
05	ISSUED FOR PERMIT	LAM	BHG

Project Name: PIM Terminal Enhancement
 Project Number: E02.03.04
 Designer: Gensler
 Date: 01/23/2019
 Description: ELECTRICAL POWER PLAN - LEVEL 3 - ZONE 4
 Scale: 1/8" = 1'-0"

E02.03.04

ELECTRICAL POWER PLAN - LEVEL 3 - ZONE 4
SCALE: 1/8" = 1'-0"