

**SHEET NOTES**  
01 JUNCTION BOX FOR CONNECTION TO DRINKING FOUNTAIN.

Portland International  
Jetport  
1001 Westbrook Street  
Portland, Maine 04102

**Gensler**  
2021 K Street, NW  
Suite 200  
Washington, DC 20006  
Telephone 202.771.5200  
Facsimile 202.772.5297

**oast ASSOCIATES, INC.**  
3455 Greenway Drive, Suite 100, Portland, ME 04106  
Tel: 207.731.1100 Fax: 207.731.7434  
engineers • architects • surveyors • construction managers



Issue	Date & Issue Description	By	Check
01	07/11/03	LAM	BHG
02	09/22/03	LAM	BHG
03	12/03/03	LAM	BHG
04	01/23/09	LAM	BHG
05	ISSUED FOR PERMIT	LAM	BHG

Author: \_\_\_\_\_  
Designer: \_\_\_\_\_  
Checker: \_\_\_\_\_  
Title: \_\_\_\_\_

Project Name: PML Terminal Expansion/1  
Label Number: E02.04.05  
Drawing Title: ELECTRICAL POWER PLAN - LEVEL 4 - ZONE 5  
Description: ELECTRICAL POWER PLAN - LEVEL 4 - ZONE 5  
Scale: 1/8" = 1'-0"  
Date: E02.04.05

Scale: 1/8" = 1'-0"

**KEY PLAN**

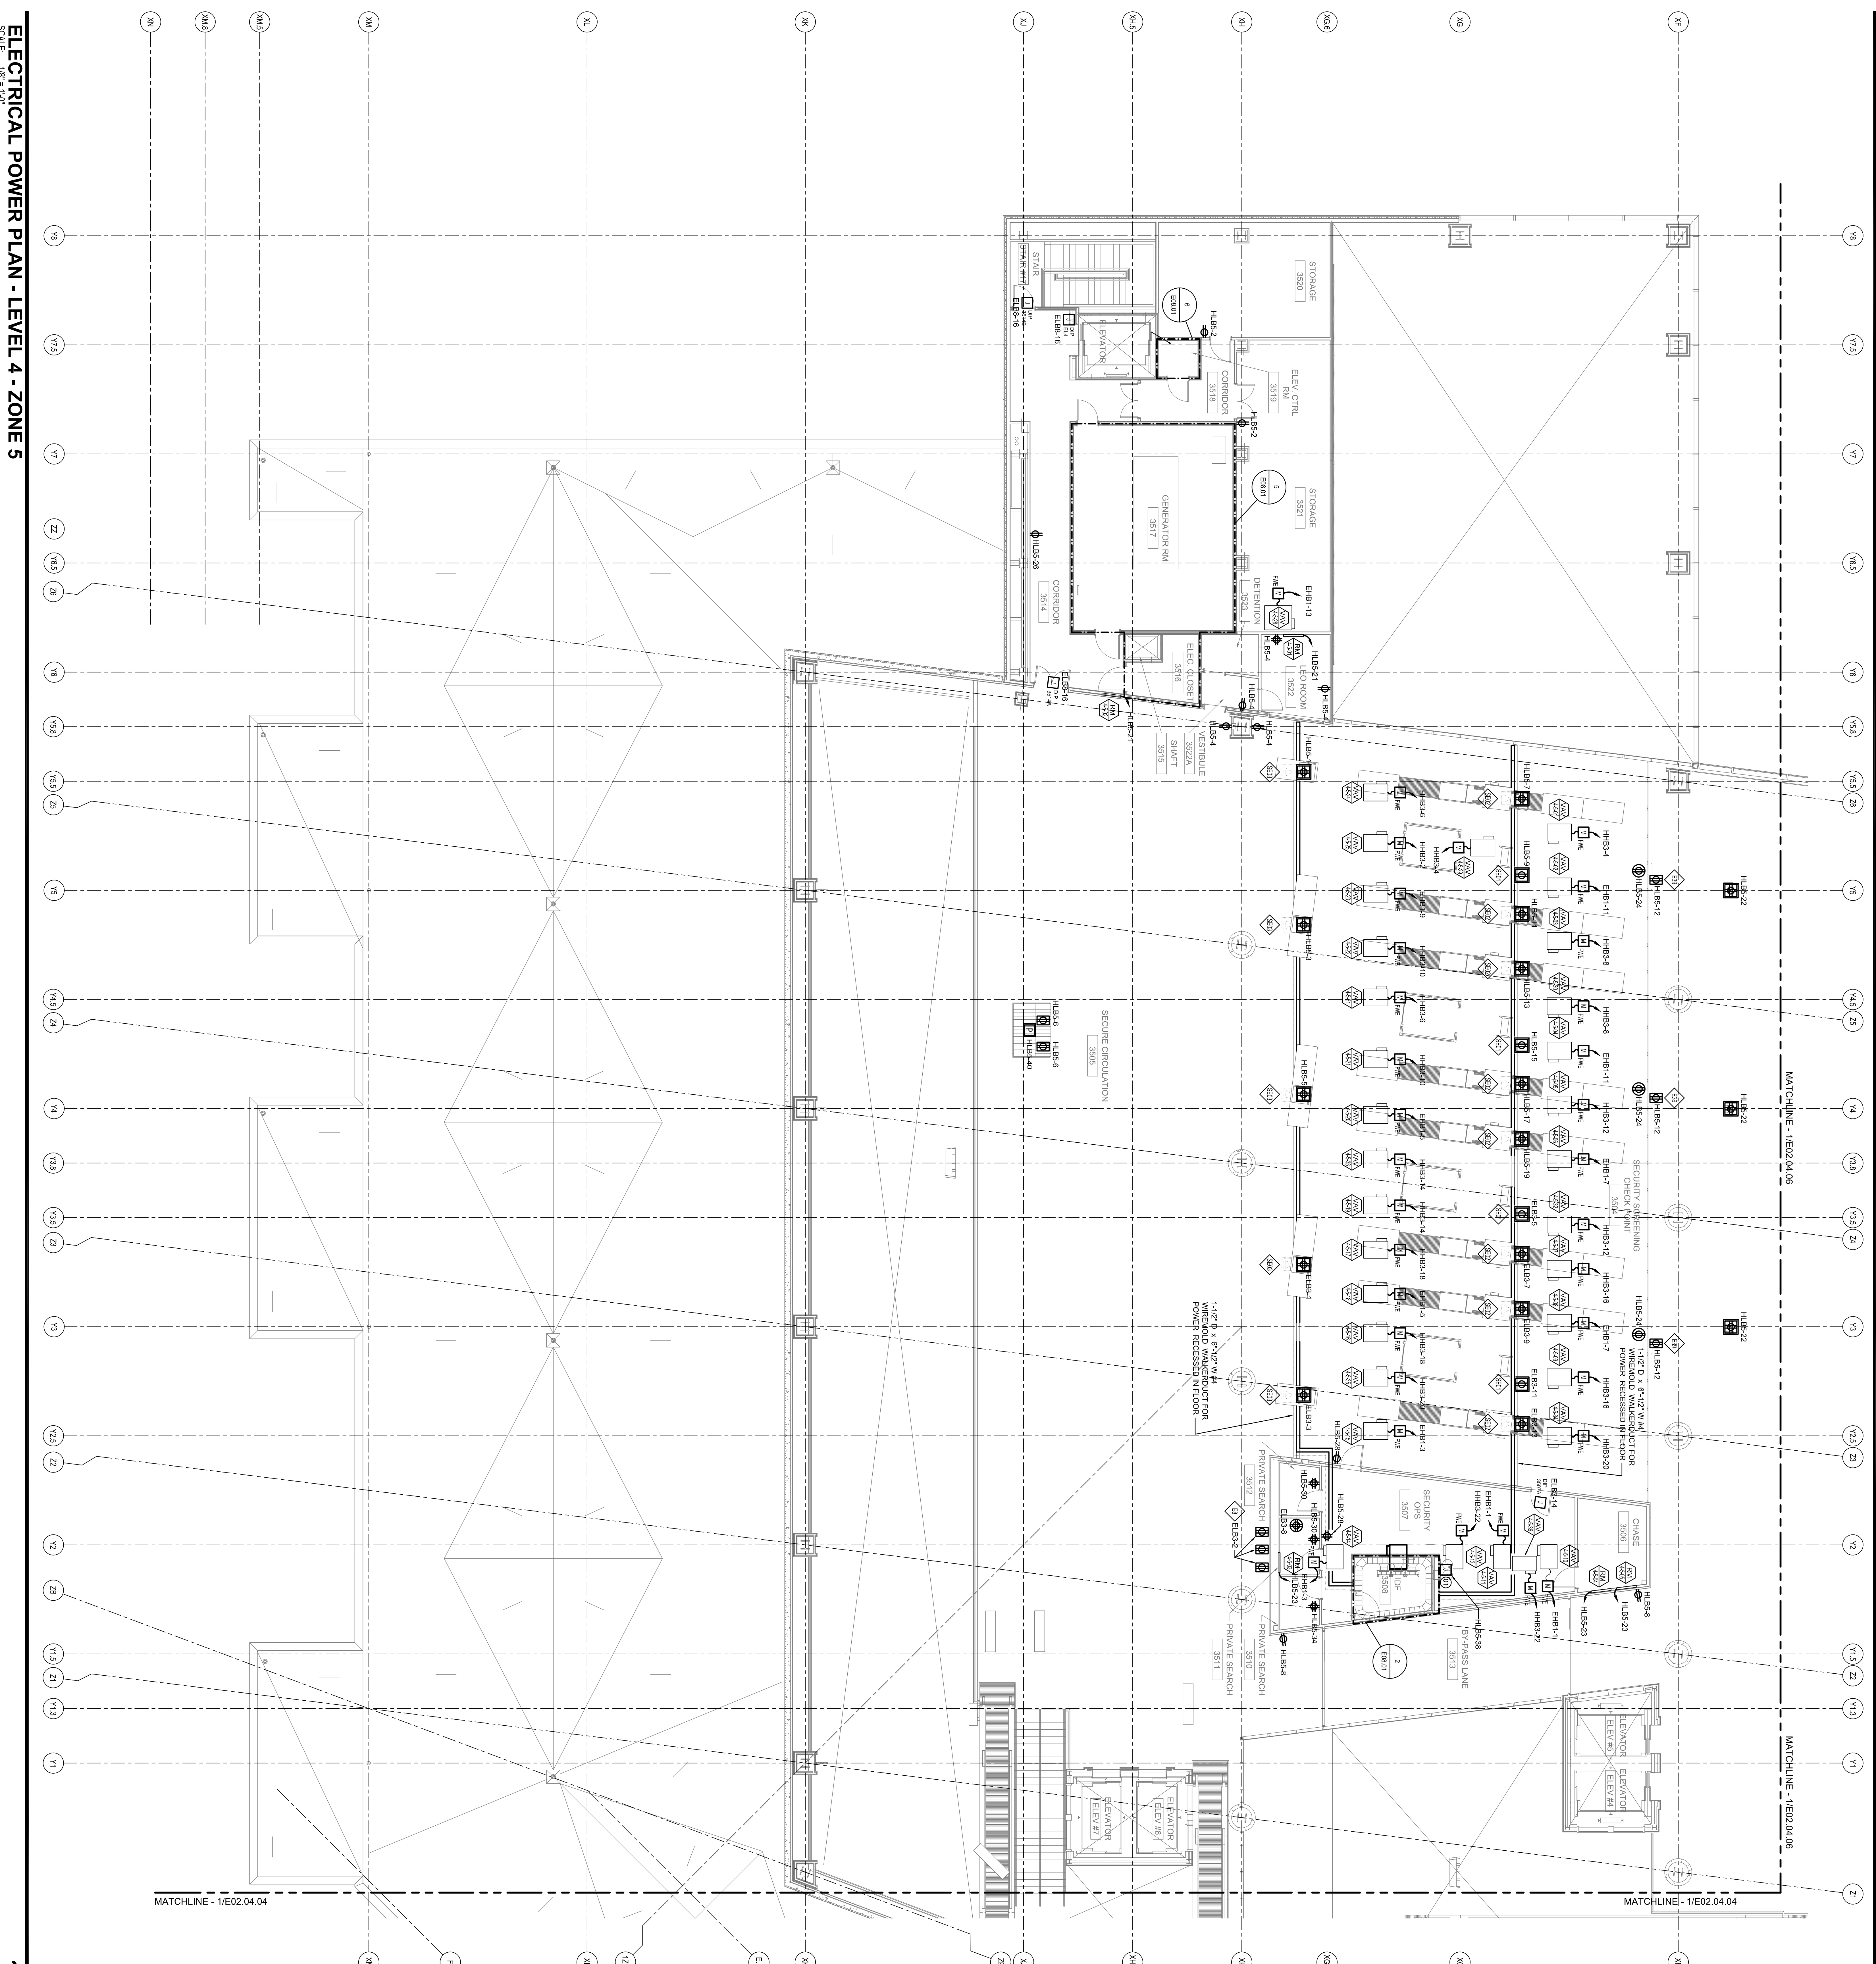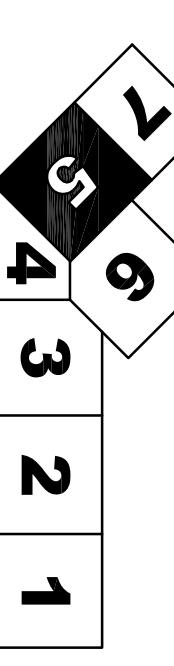

**ELECTRICAL POWER PLAN - LEVEL 4 - ZONE 5**  
SCALE: 1/8" = 1'-0"