


SHEET NOTES

Portland International
Jetport
1001 Westbrook Street
Portland, Maine 04102

Gensler
2024 N Street, NW
Suite 200
Washington, DC 20006
Telephone 202.221.5200
Facsimile 202.221.5207

oast ASSOCIATES, INC.
3405 Georgetown Road, Suite 100, Portland, ME 04103
Telephone 207.751.1100 Fax 207.751.1104
engineers • architects • interior designers • construction managers

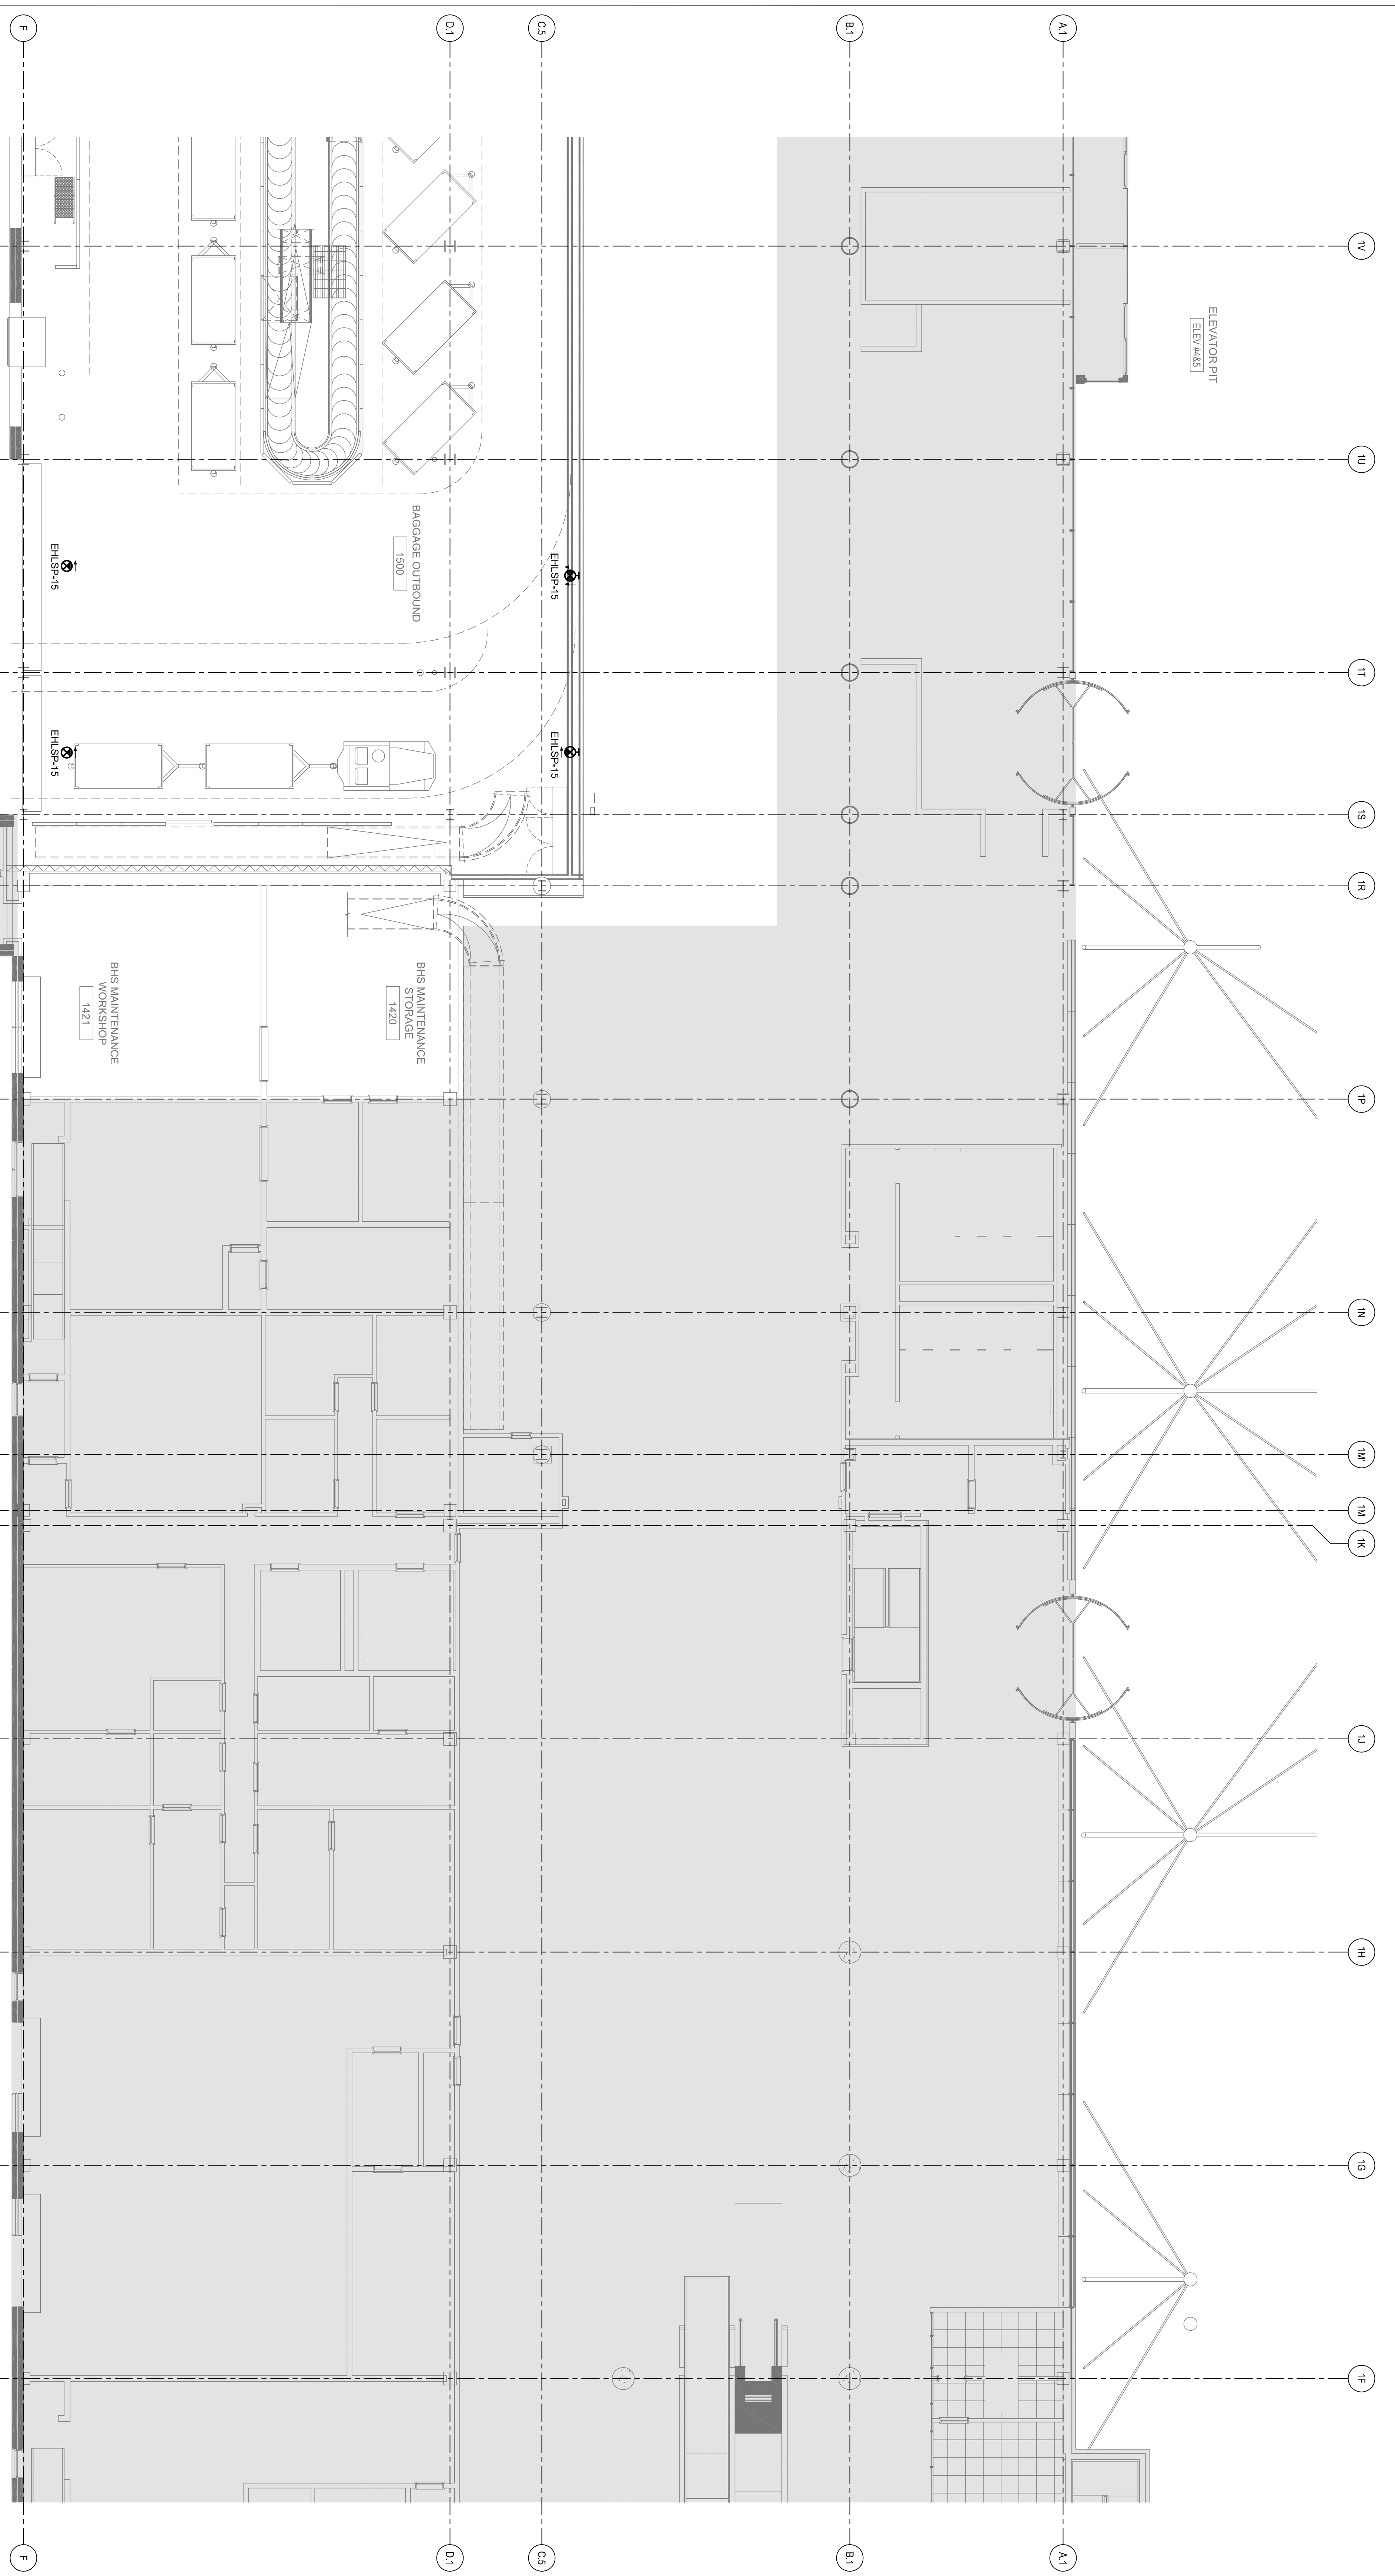


GENERAL NOTES

A SEE SHEET E00.00 FOR LEGEND AND GENERAL NOTES.

△	Issue	Date & Issue Description	By	Checked
01	12/20/00	ISSUED FOR PERMIT	LAM	BHG
02	01/23/01	50% CONSTRUCTION DOCUMENTS	LAM	BHG
03	10/26/05	ISSUED FOR PERMIT	LAM	BHG

KEY PLAN

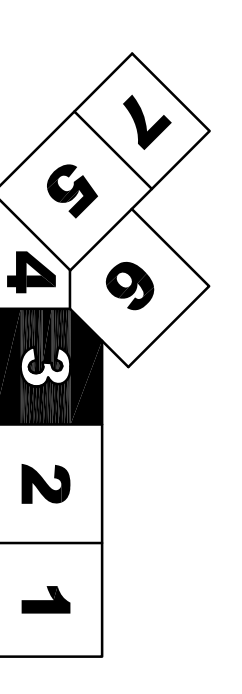

ELECTRICAL LIGHTING PLAN - LEVEL 1 - ZONE 3

SCALE: 1/8" = 1'-0"

Project Name: PMA Terminal Enhancement
 Project Number: E04.01.03
 Designer: T.3337013@Gensler.com
 Date: 10/26/05
 Description: ELECTRICAL LIGHTING PLAN - LEVEL 1 - ZONE 3
 Scale: 1/8" = 1'-0"
 Ref: North

E04.01.03

©2006 Gensler