

**SHEET NOTES**

**Portland International Jetport**  
 1001 Westbrook Street  
 Portland, Maine 04102

**Gensler**  
 2020 K Street, NW  
 Suite 200  
 Washington, DC 20006  
 Telephone 202.221.5200  
 Fax 202.221.5200

**oast ASSOCIATES, INC.**  
 360 Commonwealth Blvd., Suite 200  
 Portland, ME 04102  
 Engineers - Architects - Surveyors - Construction Managers


**GENERAL NOTES**

A SET SHEET E04.02.00 FOR LEGEND AND GENERAL NOTES.


Issue	Date & Issue Description	By	Checked
01	09/22/05	LAM	BHG
02	12/03/05	LAM	BHG
03	01/23/06	LAM	BHG
04	10/26/09	LAM	BHG

ISSUED FOR PERMIT

**KEY PLAN**

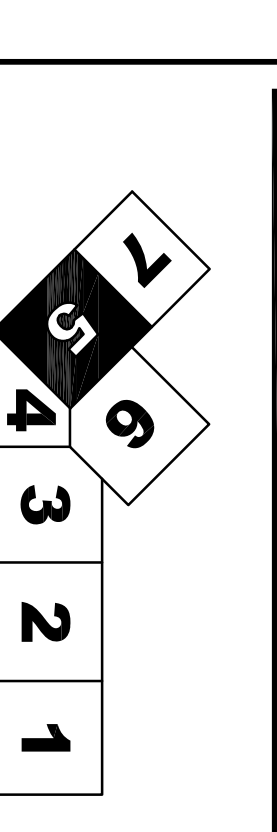

**E04.02.05**  
 SCALE: 1/8" = 1'-0"

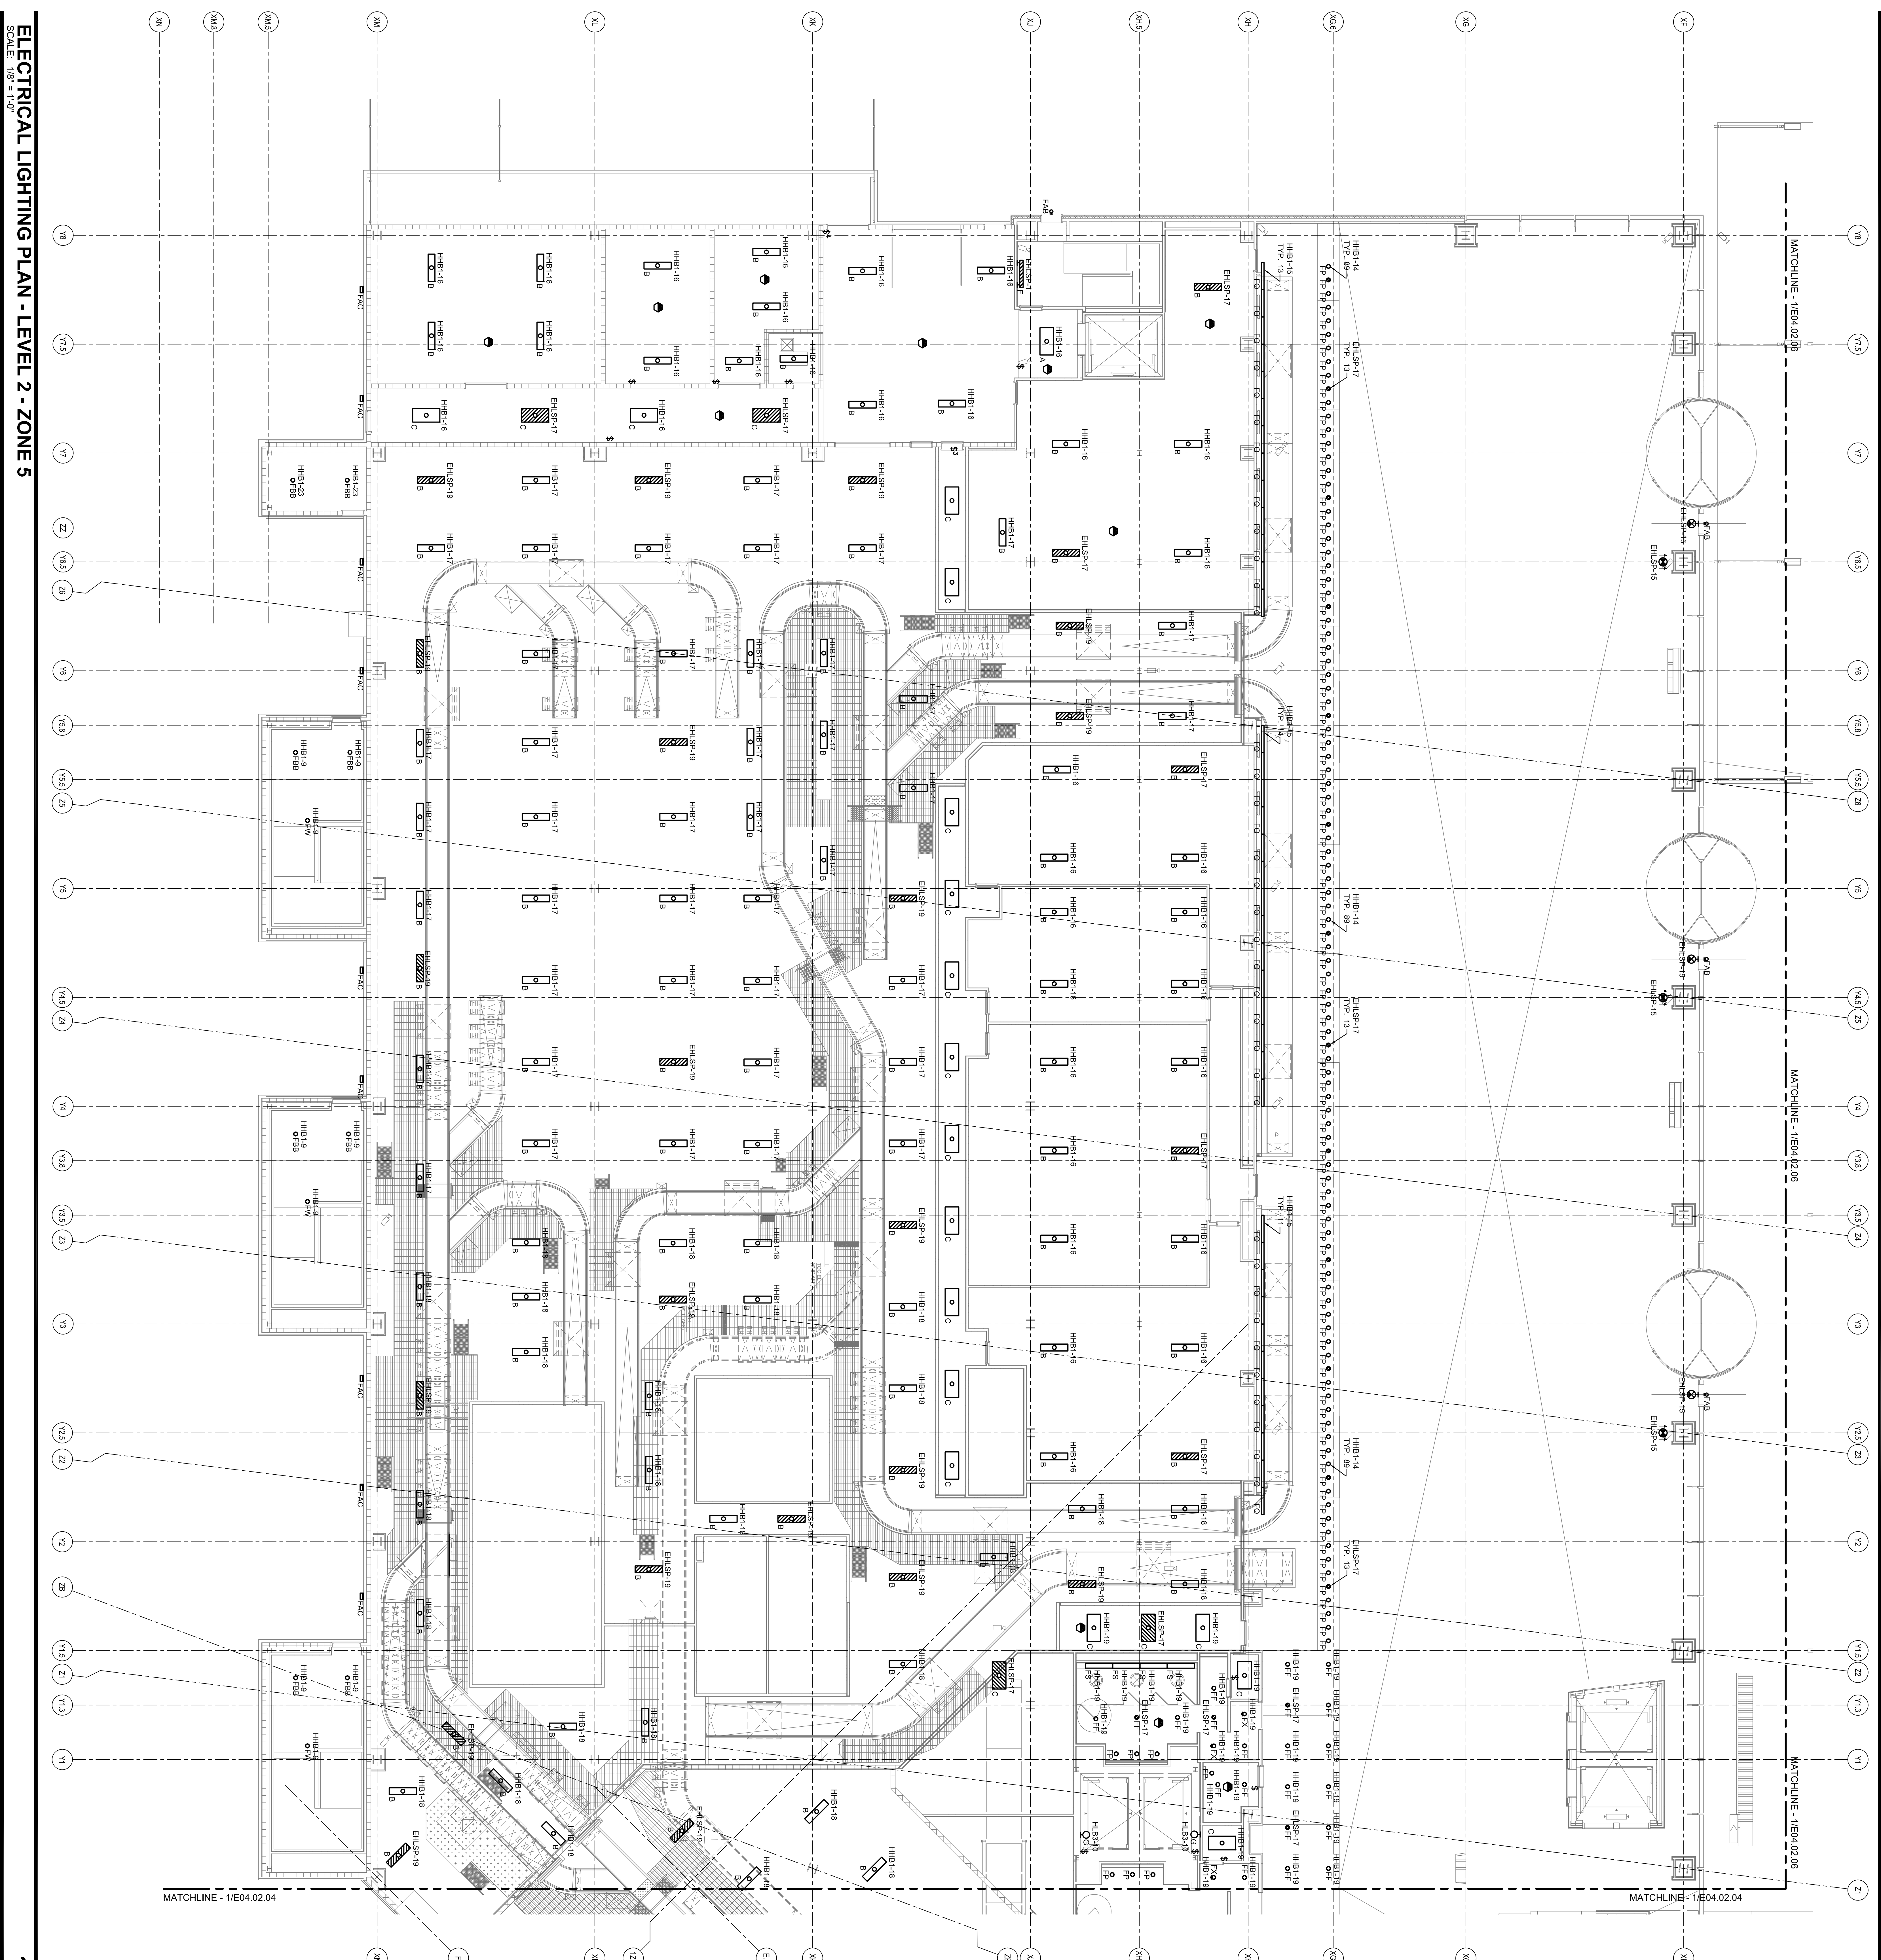

**ELECTRICAL LIGHTING PLAN - LEVEL 2 - ZONE 5**  
 SCALE: 1/8" = 1'-0"