

SHEET NOTES

- 01 PROVIDE TWO ROWS OF FIXTURES ONE ABOVE MIRROR AND ONE BELOW. SEE ARCHITECTURAL PLANS DETAILS.
- 02 PROVIDE COMPENSATION LIGHT WITH SWITCH IN THE ESCALATOR UPPER LEVEL MACHINE SPACE. COORDINATE LOCATION AND INSTALLATION WITH THE ESCALATOR CONTRACTOR.

Portland International Jetport
 1001 Westbrook Street
 Portland, Maine 04102

Gensler
 2001 K Street, NW
 Washington, DC 20006
 Telephone: 202.221.5200
 Facsimile: 202.672.5297

oast ASSOCIATES, INC.
 365 Commercial Street, Suite 400, Portland, ME 04101
 Engineers • Architects • Surveyors • Construction Managers

GENERAL NOTES


- A SET SHEET E04.03.00 FOR LEGEND AND GENERAL NOTES.

Issue	Date & Issue Description	By	Check
01	08/22/05	LAM	BHG
02	12/03/05	LAM	BHG
03	01/23/06	LAM	BHG
04	10/26/09	LAM	BHG

Legend Number	Description
01	2500/2500
02	2500/2500
03	2500/2500
04	2500/2500


Legend Number	Description
01	2500/2500
02	2500/2500
03	2500/2500
100	2500/2500

KEY PLAN

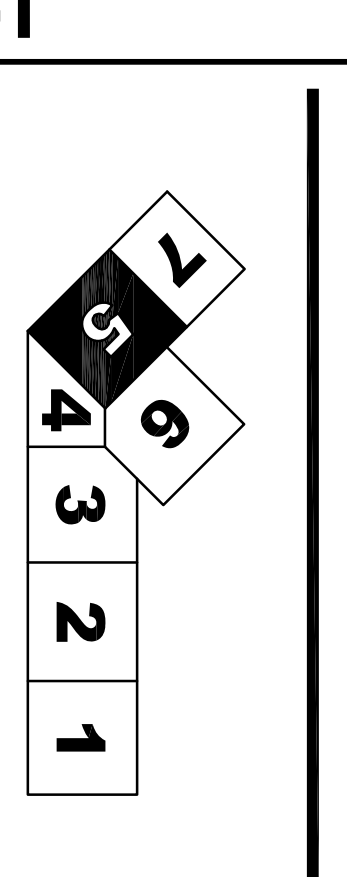

E04.03.05

SCALE: 1/8" = 1'-0"

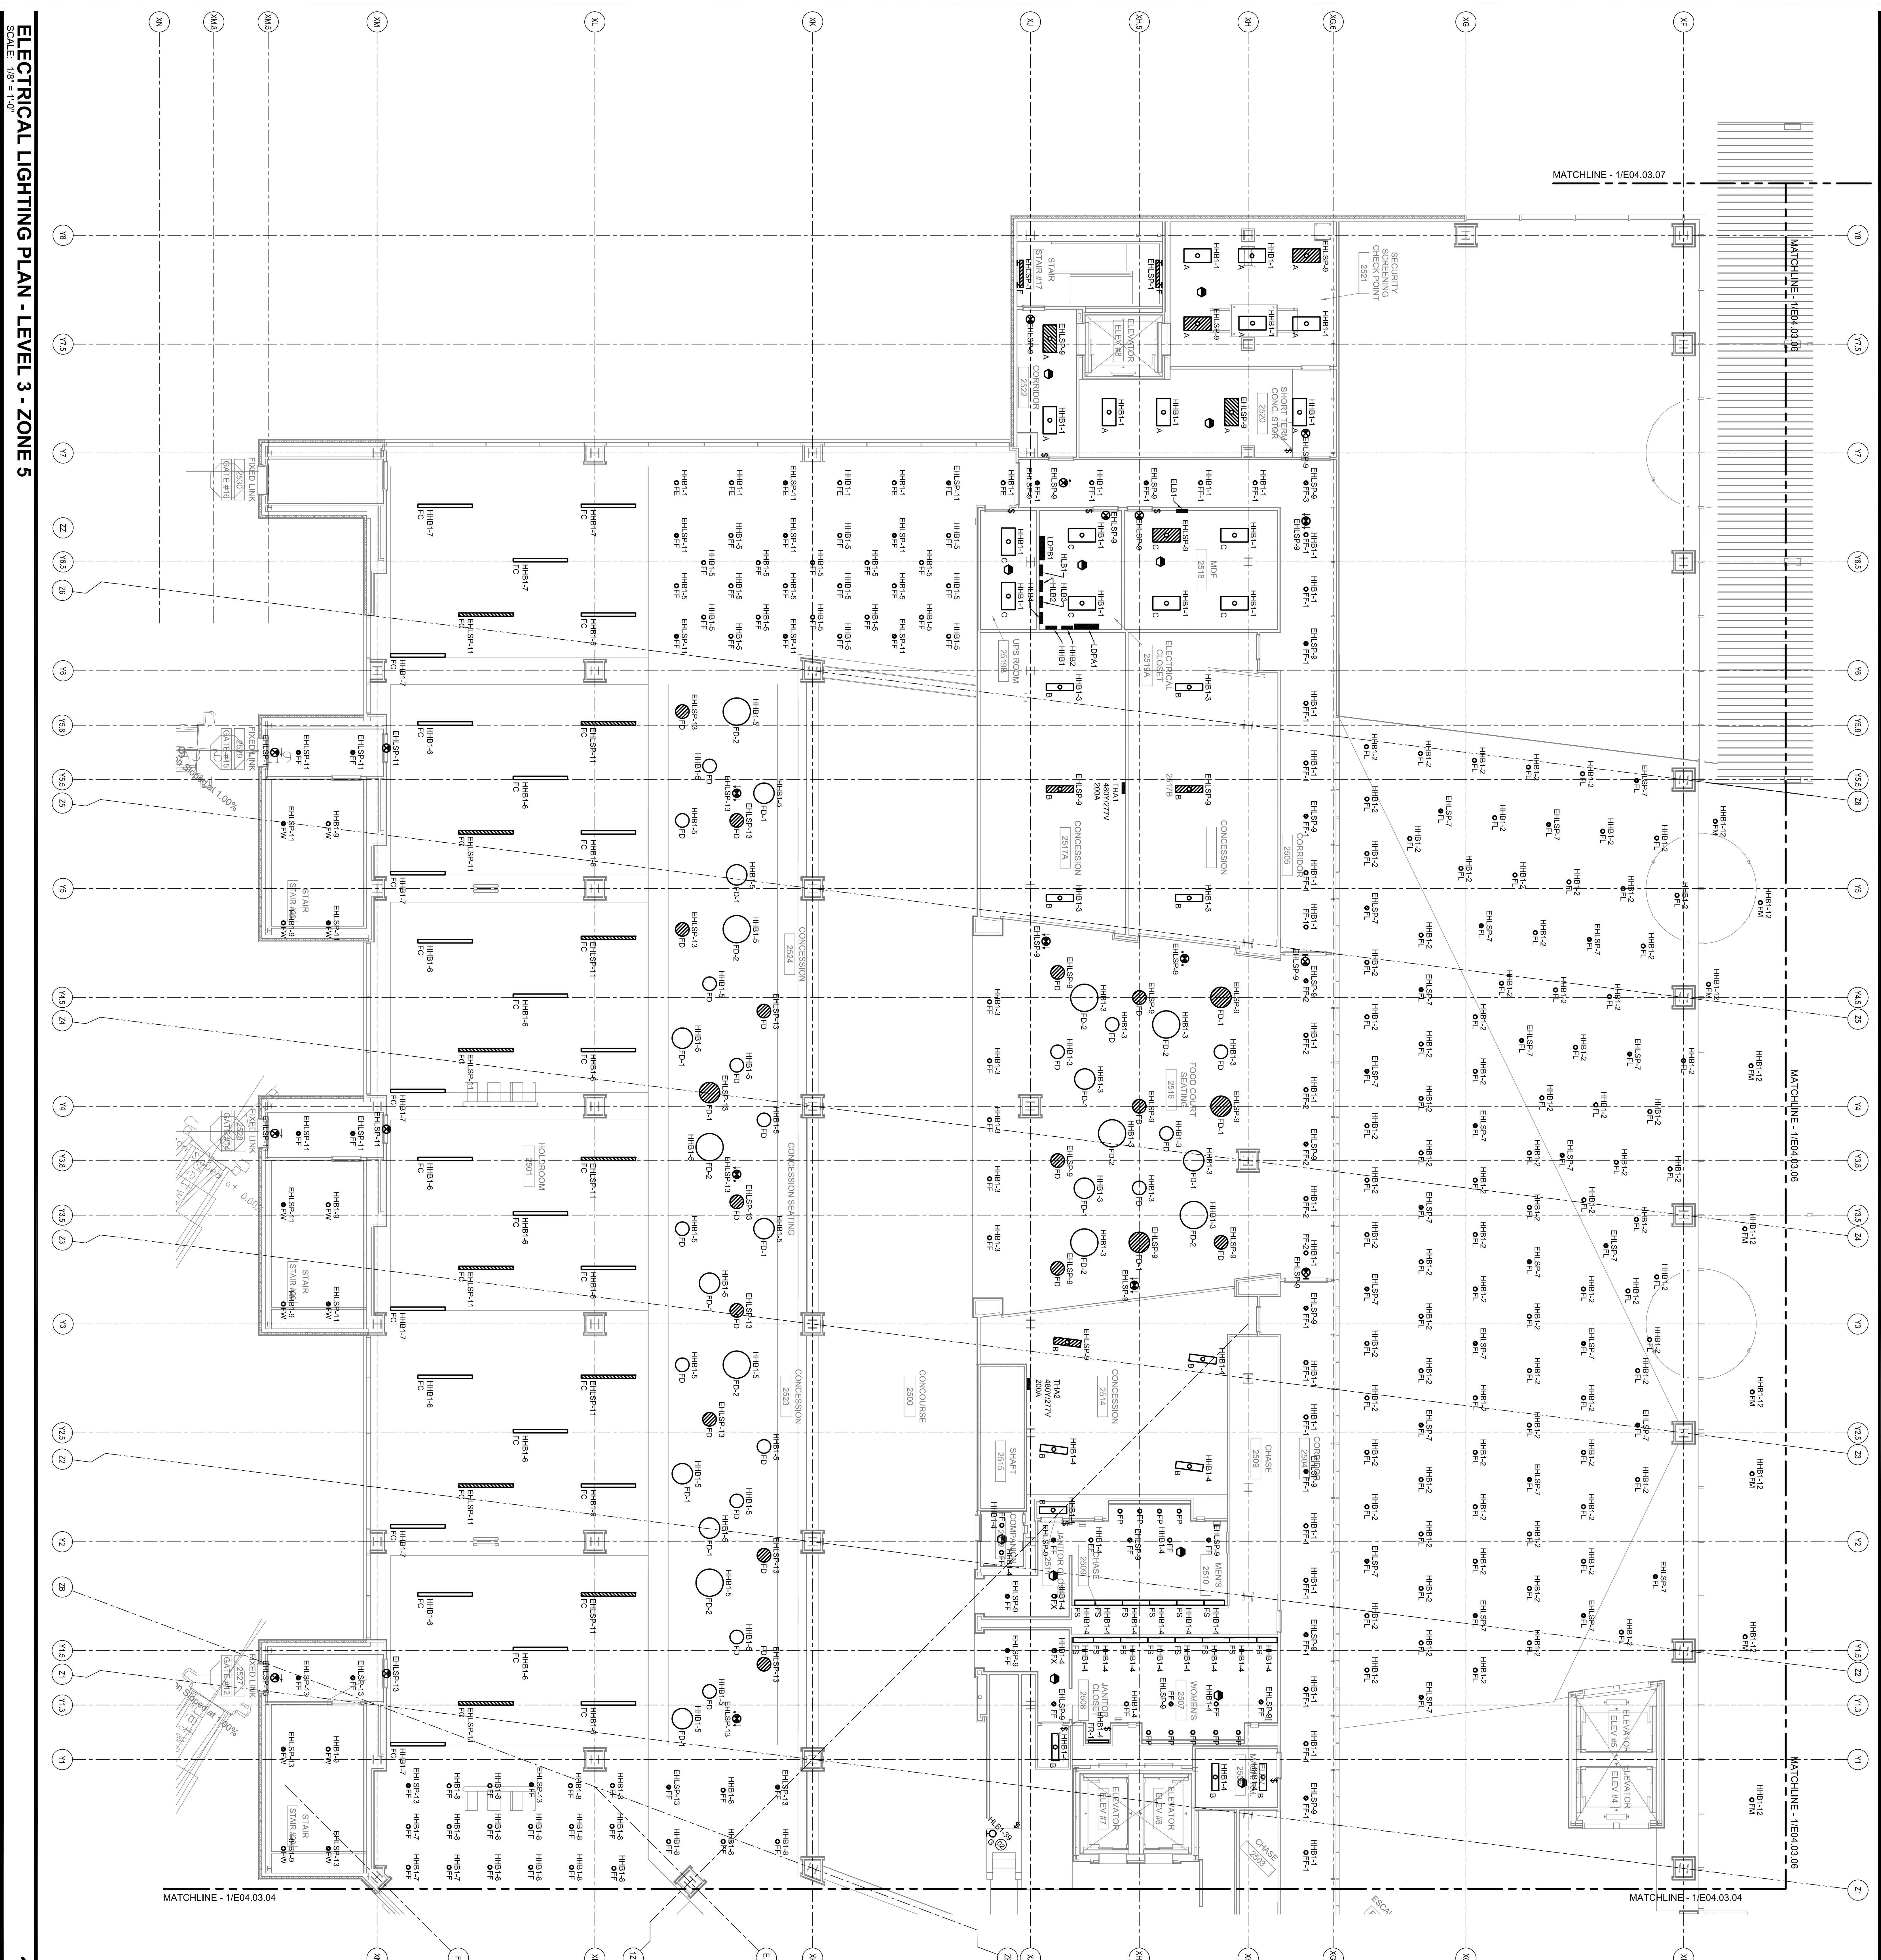

ELECTRICAL LIGHTING PLAN - LEVEL 3 - ZONE 5

SCALE: 1/8" = 1'-0"