


SHEET NOTES

Portland International Jetport
 1001 Westbrook Street
 Portland, Maine 04102

Gensler
 2001 N Street, NW
 Suite 200
 Washington, DC 20006
 Telephone 202.221.5200
 Facsimile 202.973.5297

oast ASSOCIATES, INC.
 360 Commonwealth Blvd., Suite 100, Portland, ME 04103
 Telephone 207.761.1100
 Fax 207.761.1104
 engineers • architects • interior designers • construction managers

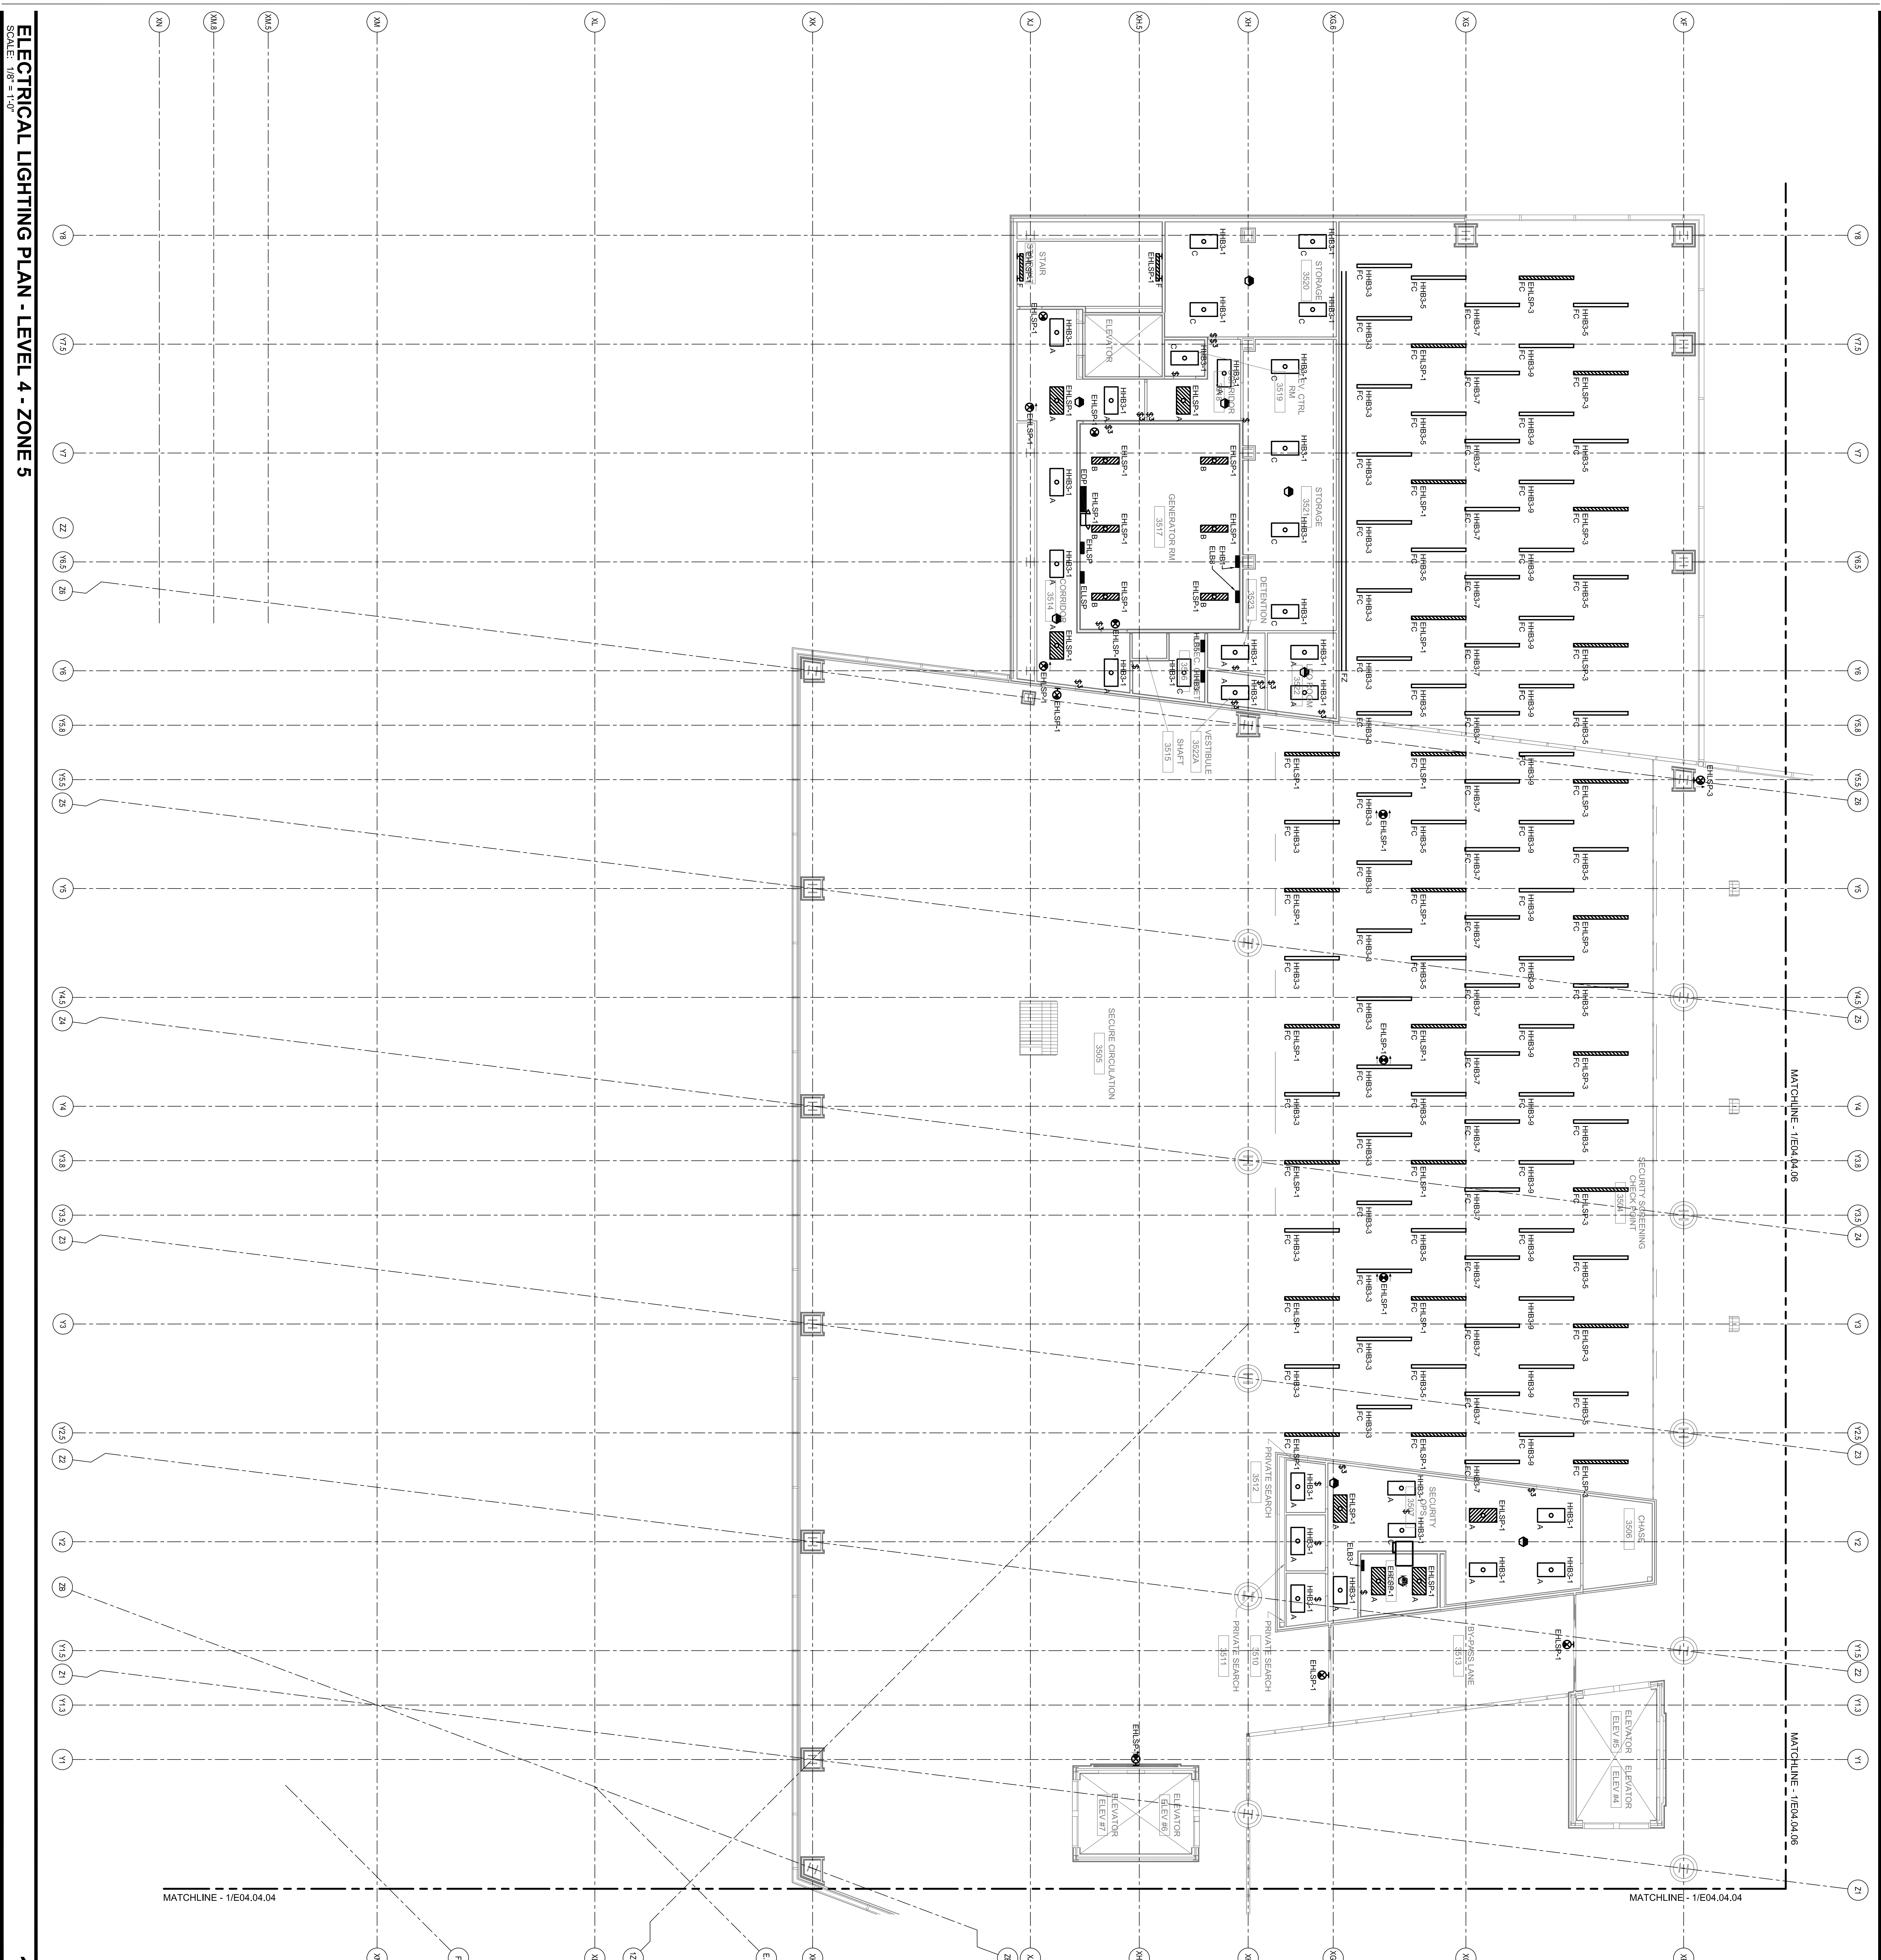


ELECTRICAL LIGHTING PLAN - LEVEL 4 - ZONE 5
 SCALE: 1/8" = 1'-0"

GENERAL NOTES

A SEE SHEET E00.00 FOR LEGEND AND GENERAL NOTES.

KEY PLAN

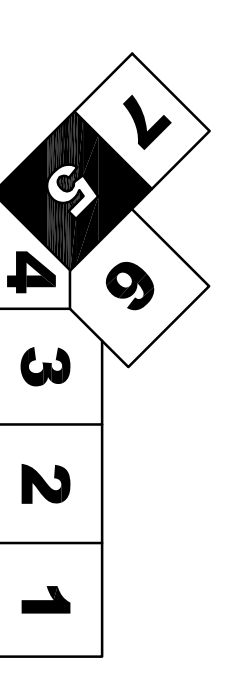

Revision	Date & Issue Description	By	Check
01	09/22/03 PRELIMINARY	LAM	BHG
02	12/03/03 REVISION	LAM	BHG
03	01/23/04 75% CONSTRUCTION DOCUMENTS	LAM	BHG
04	10/26/04 90% CONSTRUCTION DOCUMENTS	LAM	BHG
	ISSUED FOR PERMIT	LAM	BHG

Project Name	PMI Terminal Expansion
Project Number	E00.00
Client	Portland International Jetport
Designer	Gensler
Architect	Gensler
Engineer	Oast Associates, Inc.
Interior Designer	Oast Associates, Inc.
Construction Manager	Oast Associates, Inc.
Scale	1/8" = 1'-0"

©2004 Gensler

E04.04.05

