


SHEET NOTES

01 APPROXIMATE LOCATION OF PHOTO SENSOR SEE DETAIL 1/E12.02.

Portland International Jetport
 1001 Westbrook Street
 Portland, Maine 04102

Gensler
 2025 K Street, NW
 Suite 200
 Washington, DC 20006
 Telephone 202.221.5200
 Facsimile 202.221.5299


oast ASSOCIATES, INC.
 345 Commonwealth Blvd., Suite 100
 Portland, ME 04103
 Engineers - Architects - Surveyors - Construction Managers

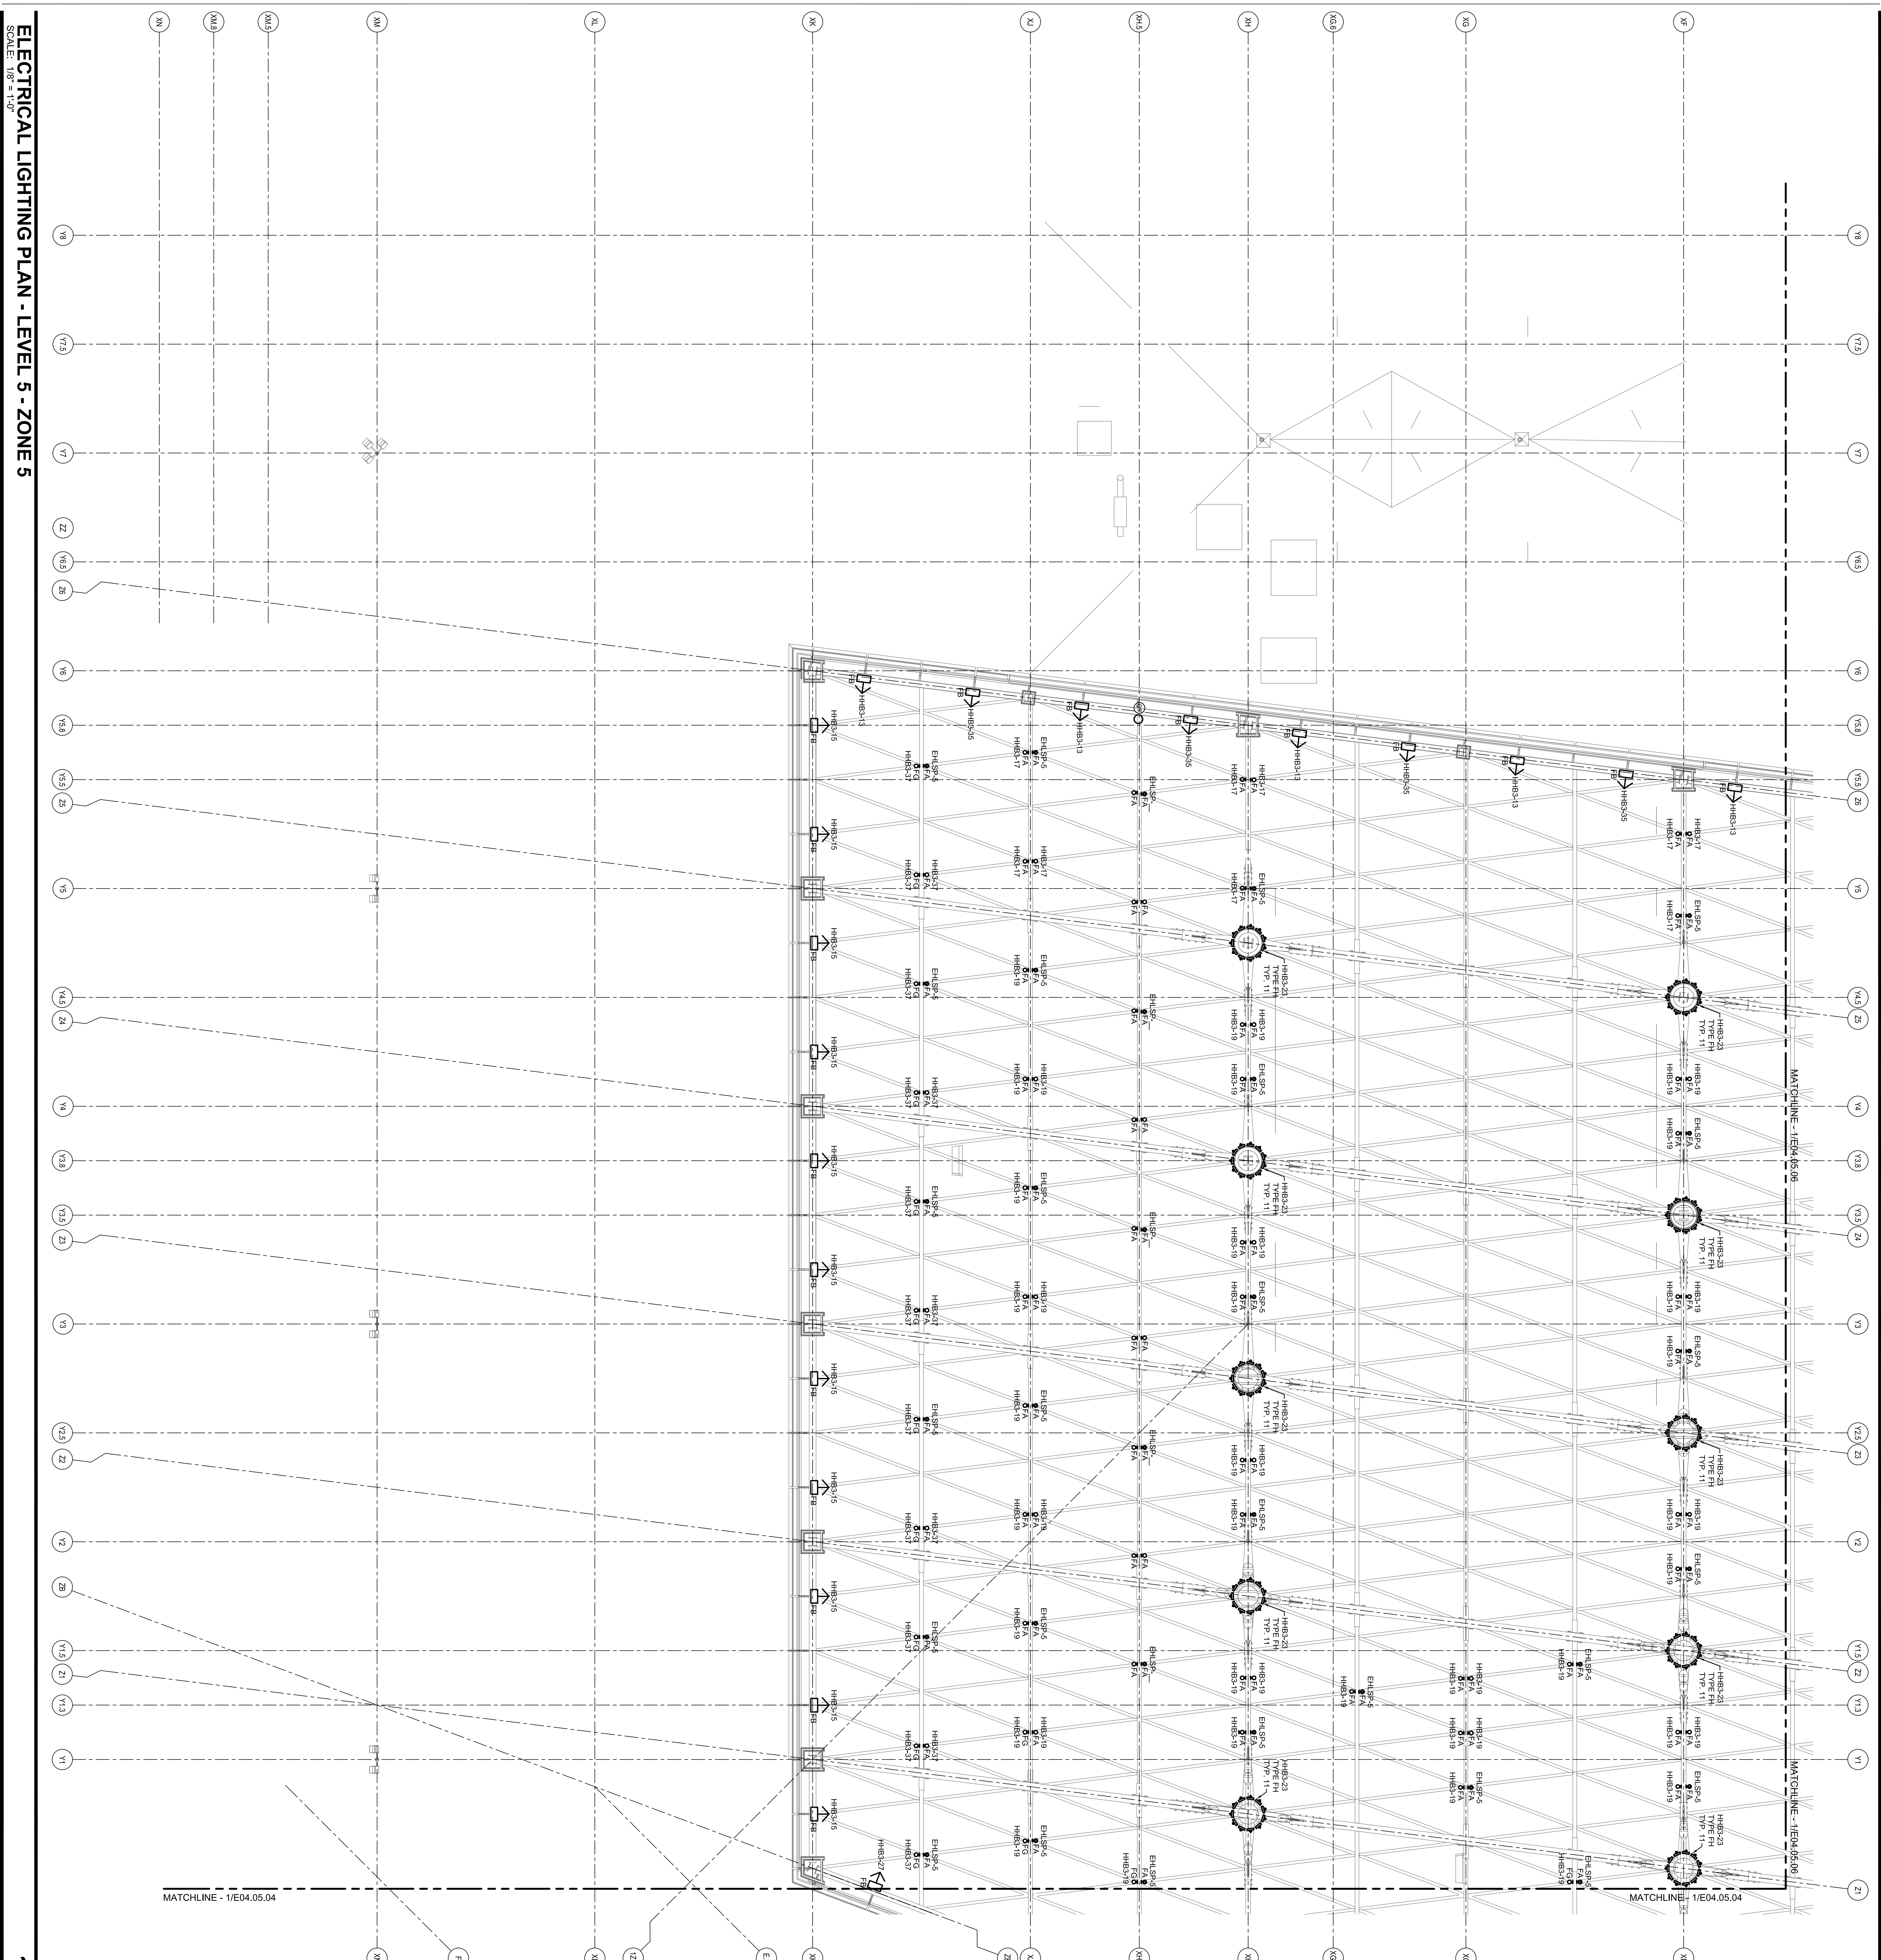

GENERAL NOTES

A SEE SHEET E04.00 FOR LEGEND AND GENERAL NOTES.

KEY PLAN

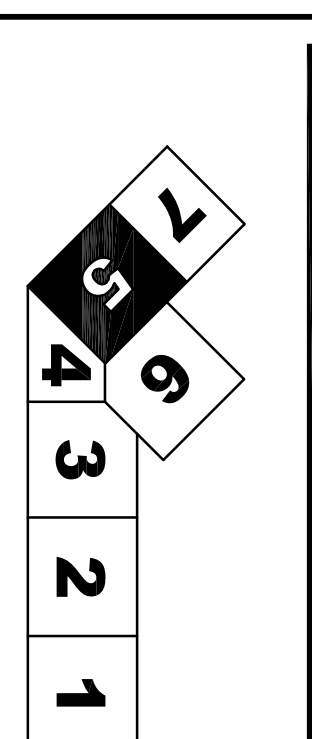

Issue	Date & Issue Description	By	Check
01	09/22/08	LAM	BHG
02	12/03/08	LAM	BHG
03	01/23/09	LAM	BHG
04	10/26/09	LAM	BHG
ISSUED FOR PERMIT			

Project Name	PMI Terminal Expansion
Project Number	10000000
Client Name	TERRACON CONSULTING
Description	ELECTRICAL LIGHTING PLAN - LEVEL 5 - ZONE 5
Scale	1/8" = 1'-0"

ELECTRICAL LIGHTING PLAN - LEVEL 5 - ZONE 5
 SCALE: 1/8" = 1'-0"