

**SHEET NOTES**

01 UNIT HEATERS- COORDINATE SPRINKLER TEMPERATURE RATINGS PER NFPA 13.


**Portland International Jetport**

1001 Westbrook Street  
Portland, Maine 04102

**Gensler**  
2020 K Street, NW  
Suite 200  
Washington, DC 20006  
Telephone 202.721.5200  
Facsimile 202.872.8587

**oest ASSOCIATES, INC.**  
345 Gophers Road South Portland, ME 04106 P (207) 761-1770 F (207) 774-1242 www.oest.com  
engineers • architects • surveyors • construction managers


**FIRE RISK MANAGEMENT, INC.**  
1 First Street  
South Portland, ME 04106 P (207) 442-7268  
www.fire-risk.com

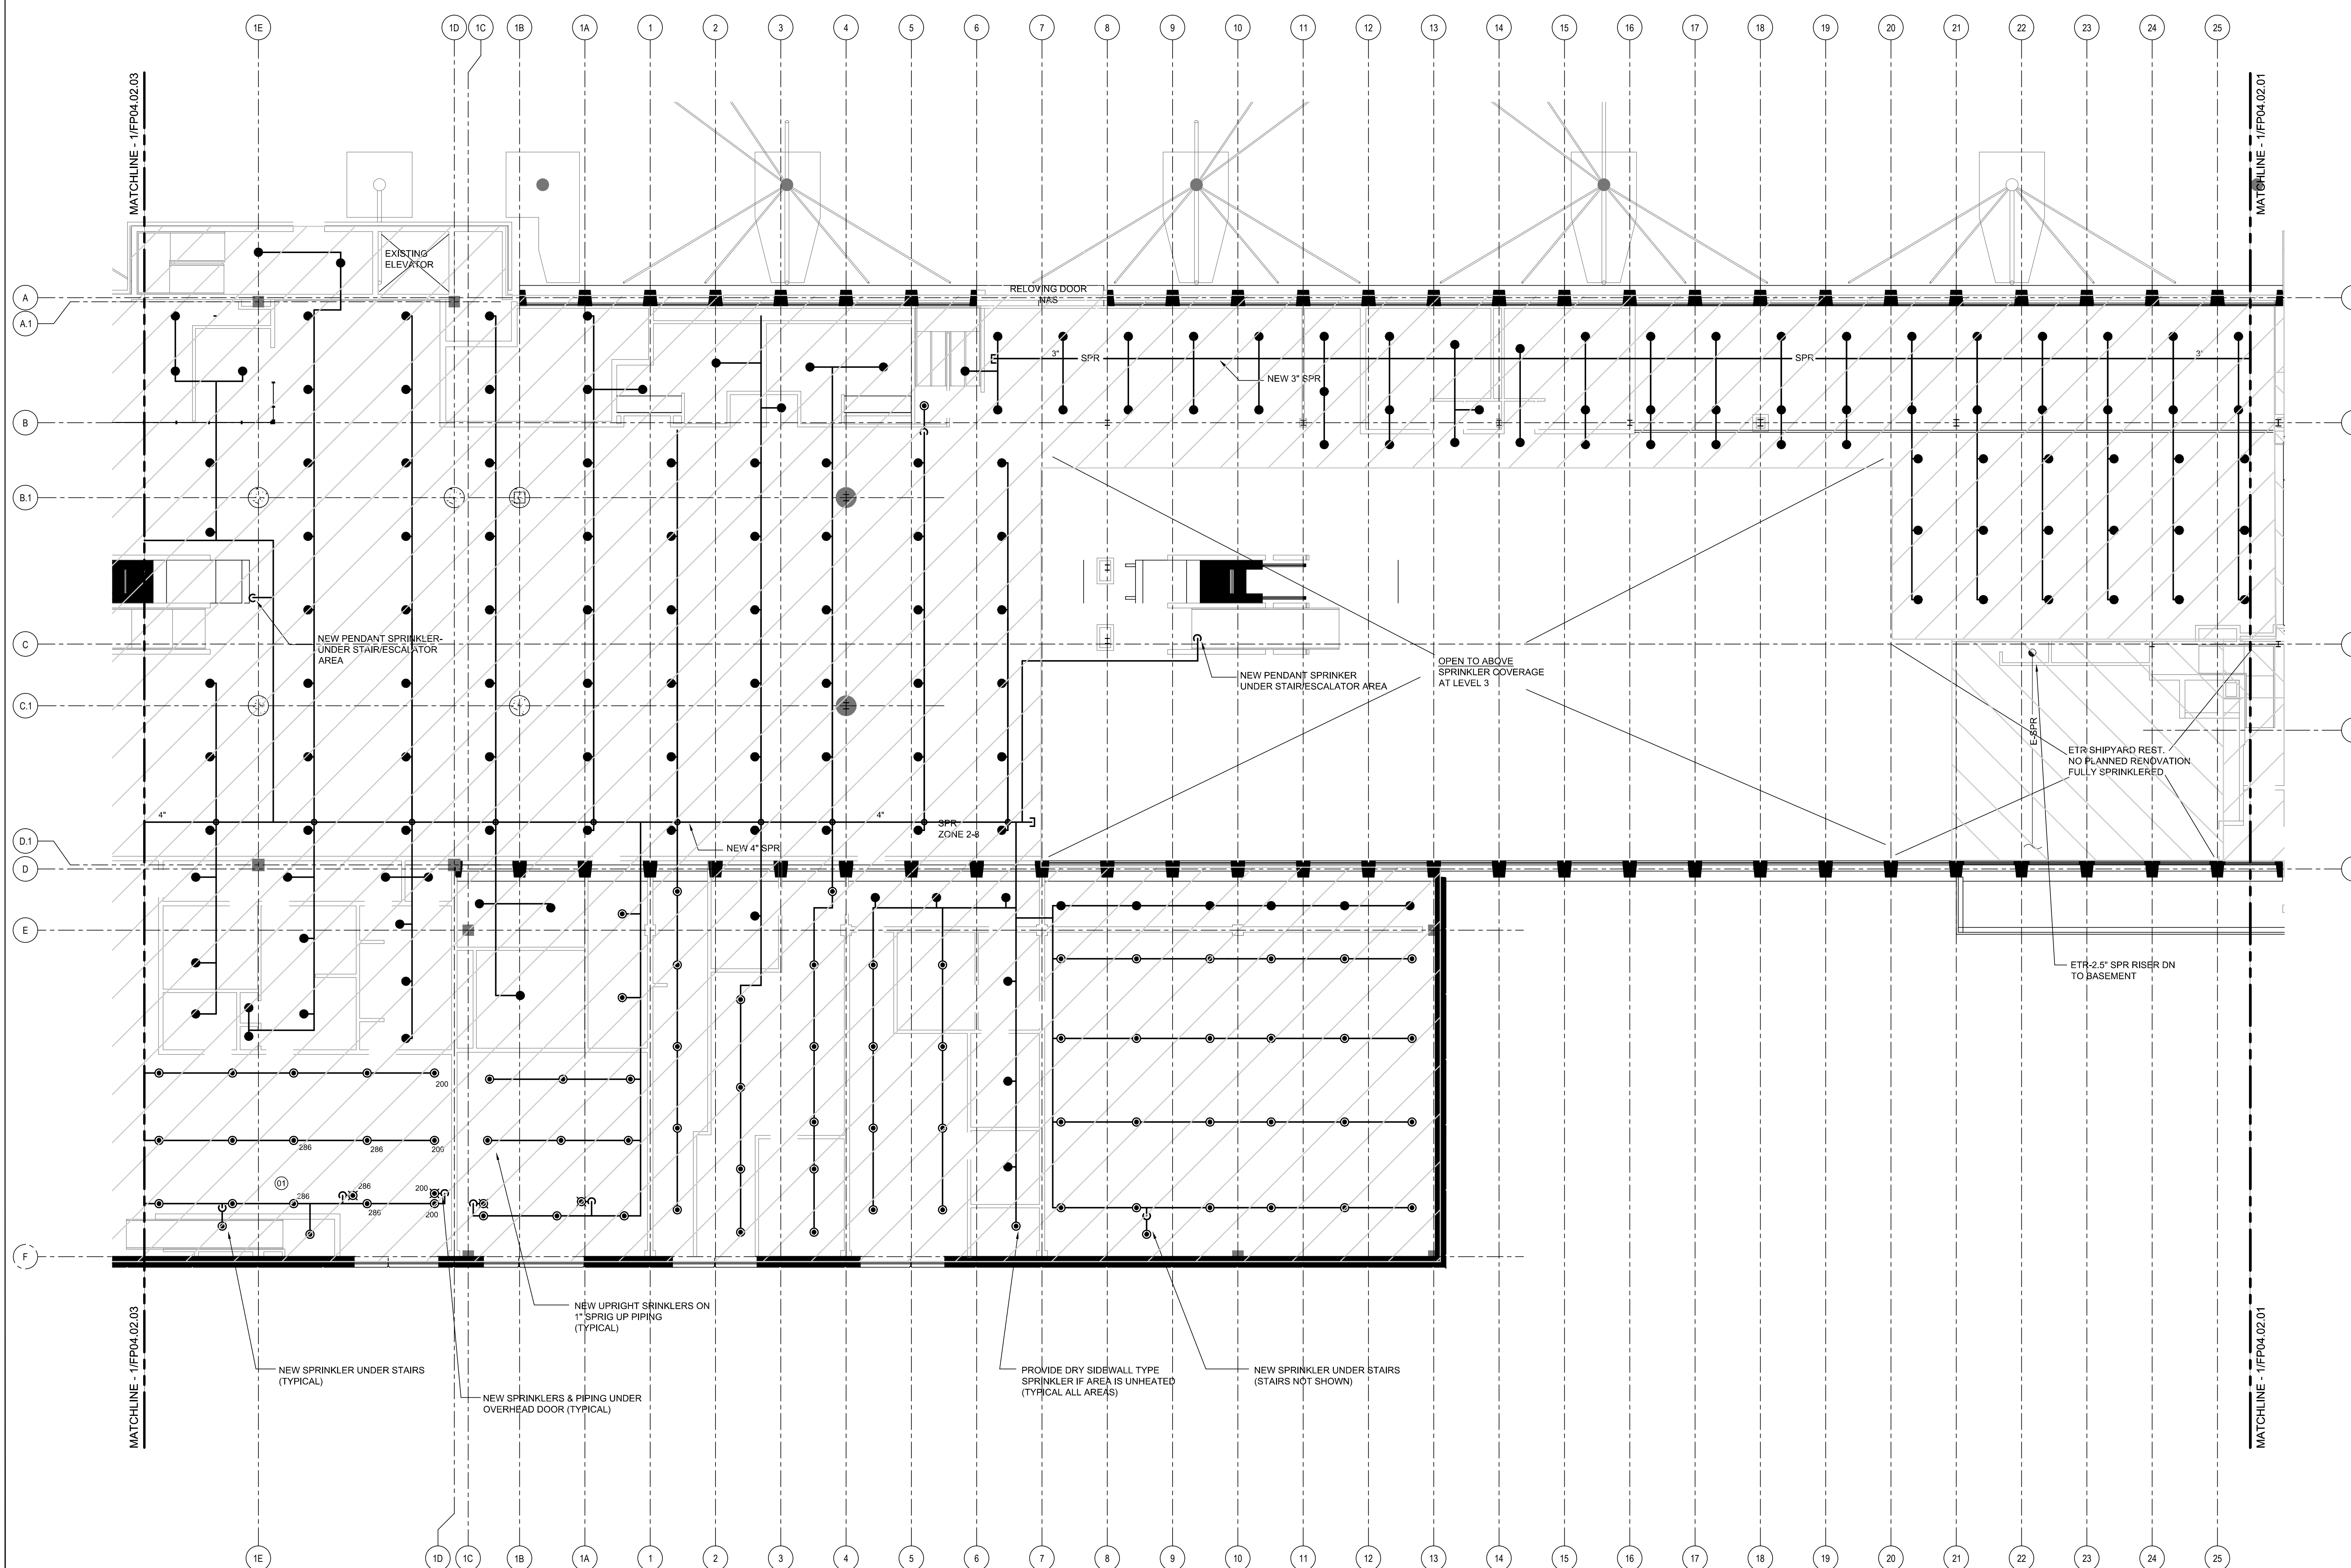

**GENERAL NOTES**

A SEE SHEET FP00.01 FOR LEGEND, SCHEDULES & GENERAL NOTES.

Issue	Date & Issue Description	By	Check
01	07/11/08	PWZ	RHB
02	09/22/08	SKD	WMC
03	12/03/08	SKD	WMC
04	01/23/09	MHY	JLD
05	10/26/09	JLD	SKD

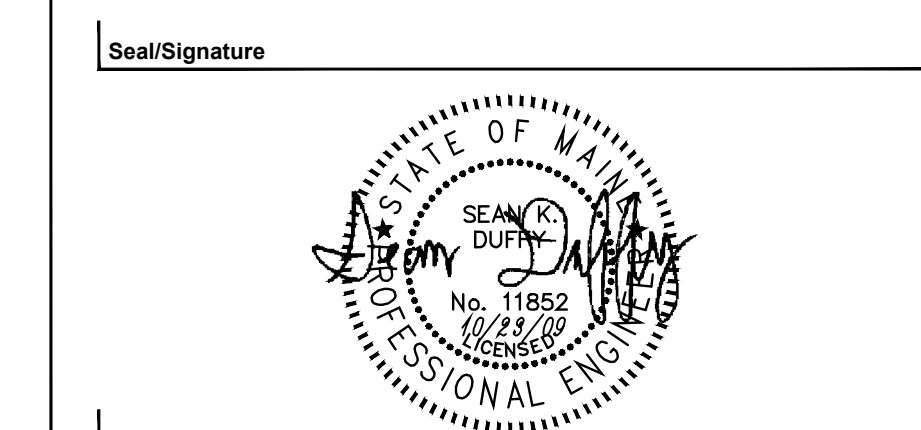

Project Name  
PJM Terminal Expansion

Project Number  
08.0395.000

CAD File Name  
FP04.02.02.dwg


Description  
FIRE PROTECTION PLAN - LEVEL 2 - ZONE 2

Scale  
1/8" = 1'-0"

**FP04.02.02**

©2009 Gensler

**KEY PLAN**

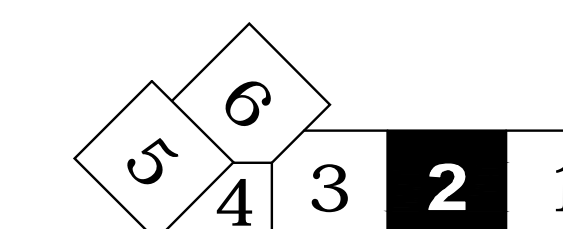

**FIRE PROTECTION PLAN - LEVEL 2 - ZONE 2**  
SCALE: 1/8"=1'-0"