


SHEET NOTES

Portland International
Jetport
1001 Westbrook Street
Portland, Maine 04102

Gensler
2020 K Street, NW
Suite 200
Washington, DC 20006
Telephone 202.721.5200
Facsimile 202.872.8587

oest ASSOCIATES, INC.
345 Gophers Road, South Portland, ME 04106 P: (207) 761-1770 F: (207) 774-1242 www.oest.com
engineers • architects • surveyors • construction managers

FIRE RISK MANAGEMENT, INC.
1 First Street
South Portland, ME 04106 P: (207) 442-7200
www.fire-risk.com

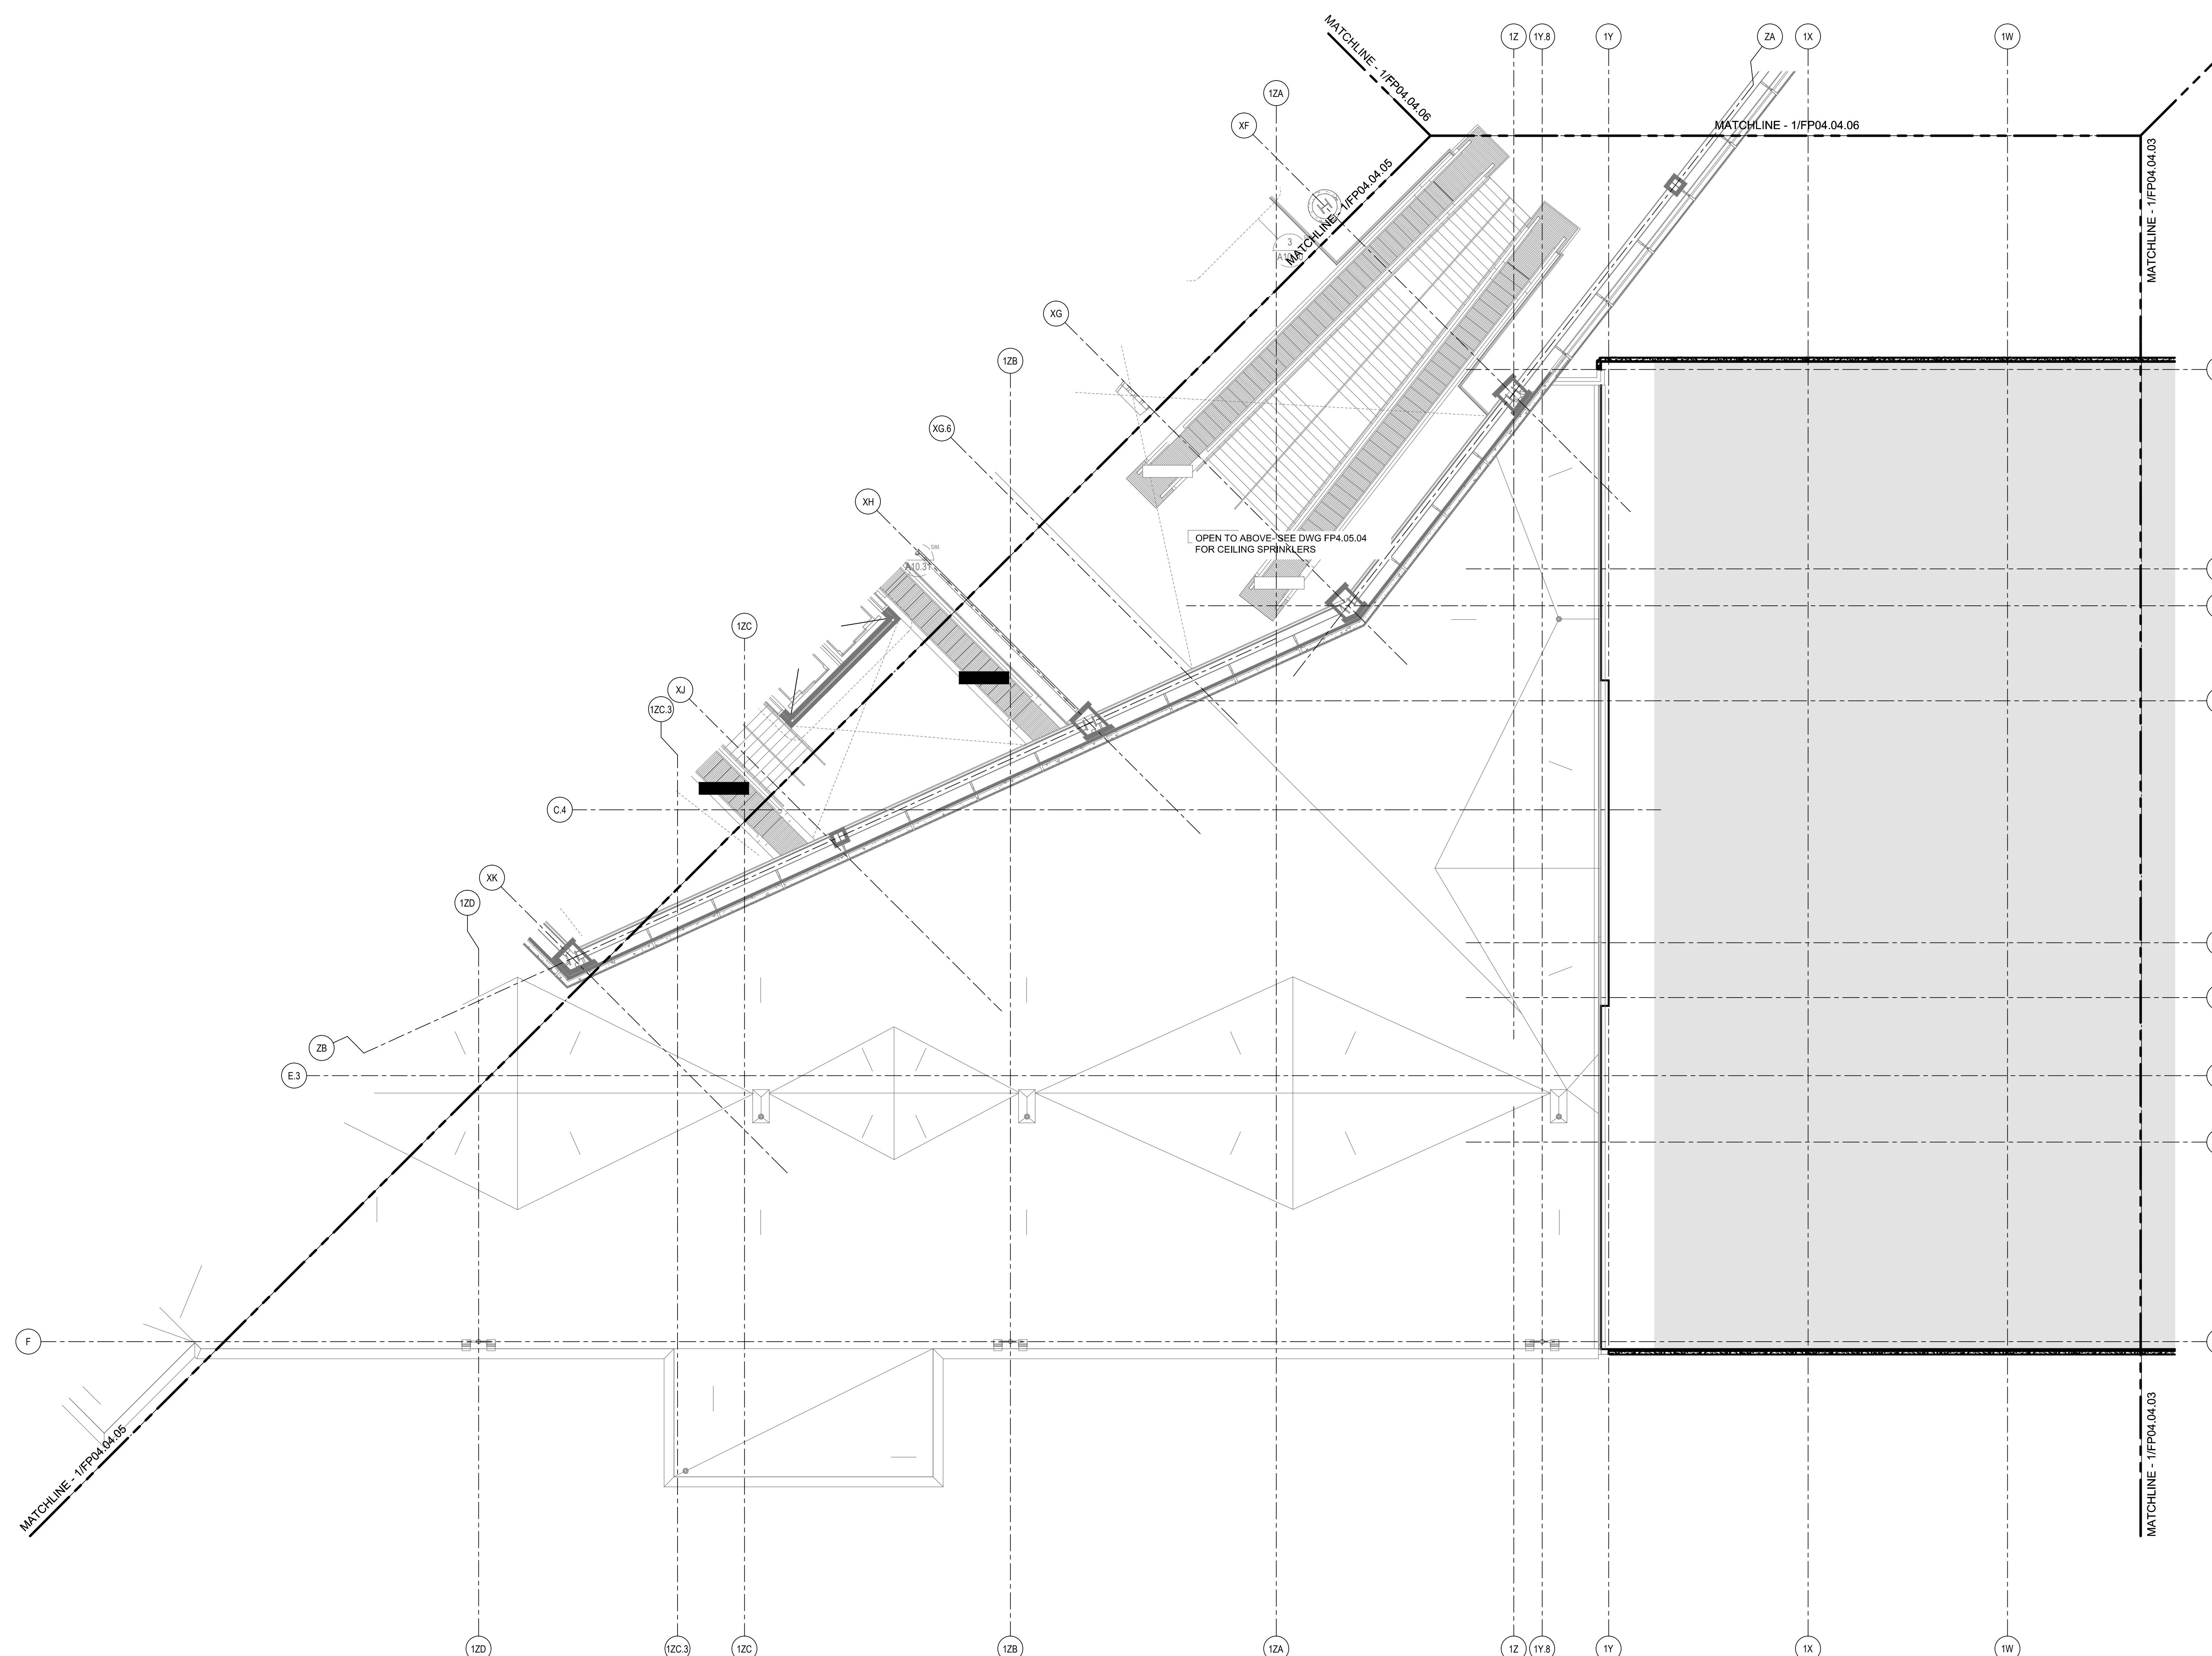


GENERAL NOTES

A SEE SHEET FP00.01 FOR LEGEND, SCHEDULES & GENERAL NOTES.

Issue	Date & Issue Description	By	Check
01	07/11/08	PWZ	RHB
02	09/22/08	SKD	WMC
03	12/03/08	SKD	WMC
04	01/23/09	MHY	JLD
05	10/26/09	JLD	SKD

Seal/Signature

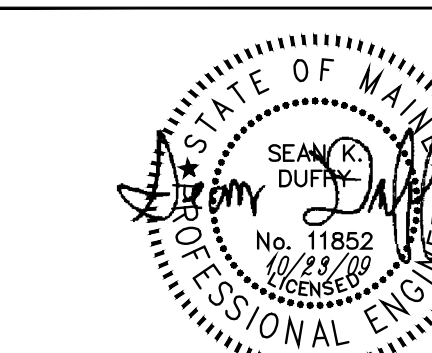


Project Name
PJM Terminal Expansion

Project Number
08.0395.000

CAD File Name
FP04.04.04.dwg

Description
FIRE PROTECTION PLAN - LEVEL 4 - ZONE 4

KEY PLAN

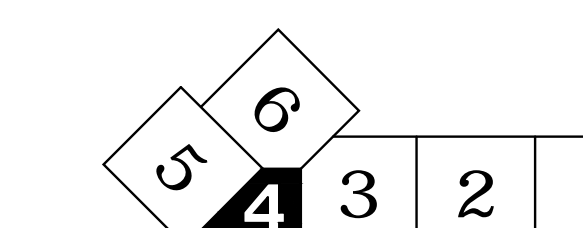

Scale
1/8" = 1'-0"



FP04.04.04

©2009 Gensler

FIRE PROTECTION PLAN - LEVEL 4 - ZONE 4

SCALE: 1/8"=1'-0"