


SHEET NOTES

**Portland International
Jetport**
1001 Westbrook Street
Portland, Maine 04102

Gensler
2020 K Street, NW
Suite 200
Washington, DC 20006
Telephone 202.721.5200
Facsimile 202.872.8587

oest ASSOCIATES, INC.
363 Goshen Road, South Portland, ME 04106 P: (207) 741-1770 F: (207) 774-2461 www.oest.com
engineers • architects • surveyors • construction managers

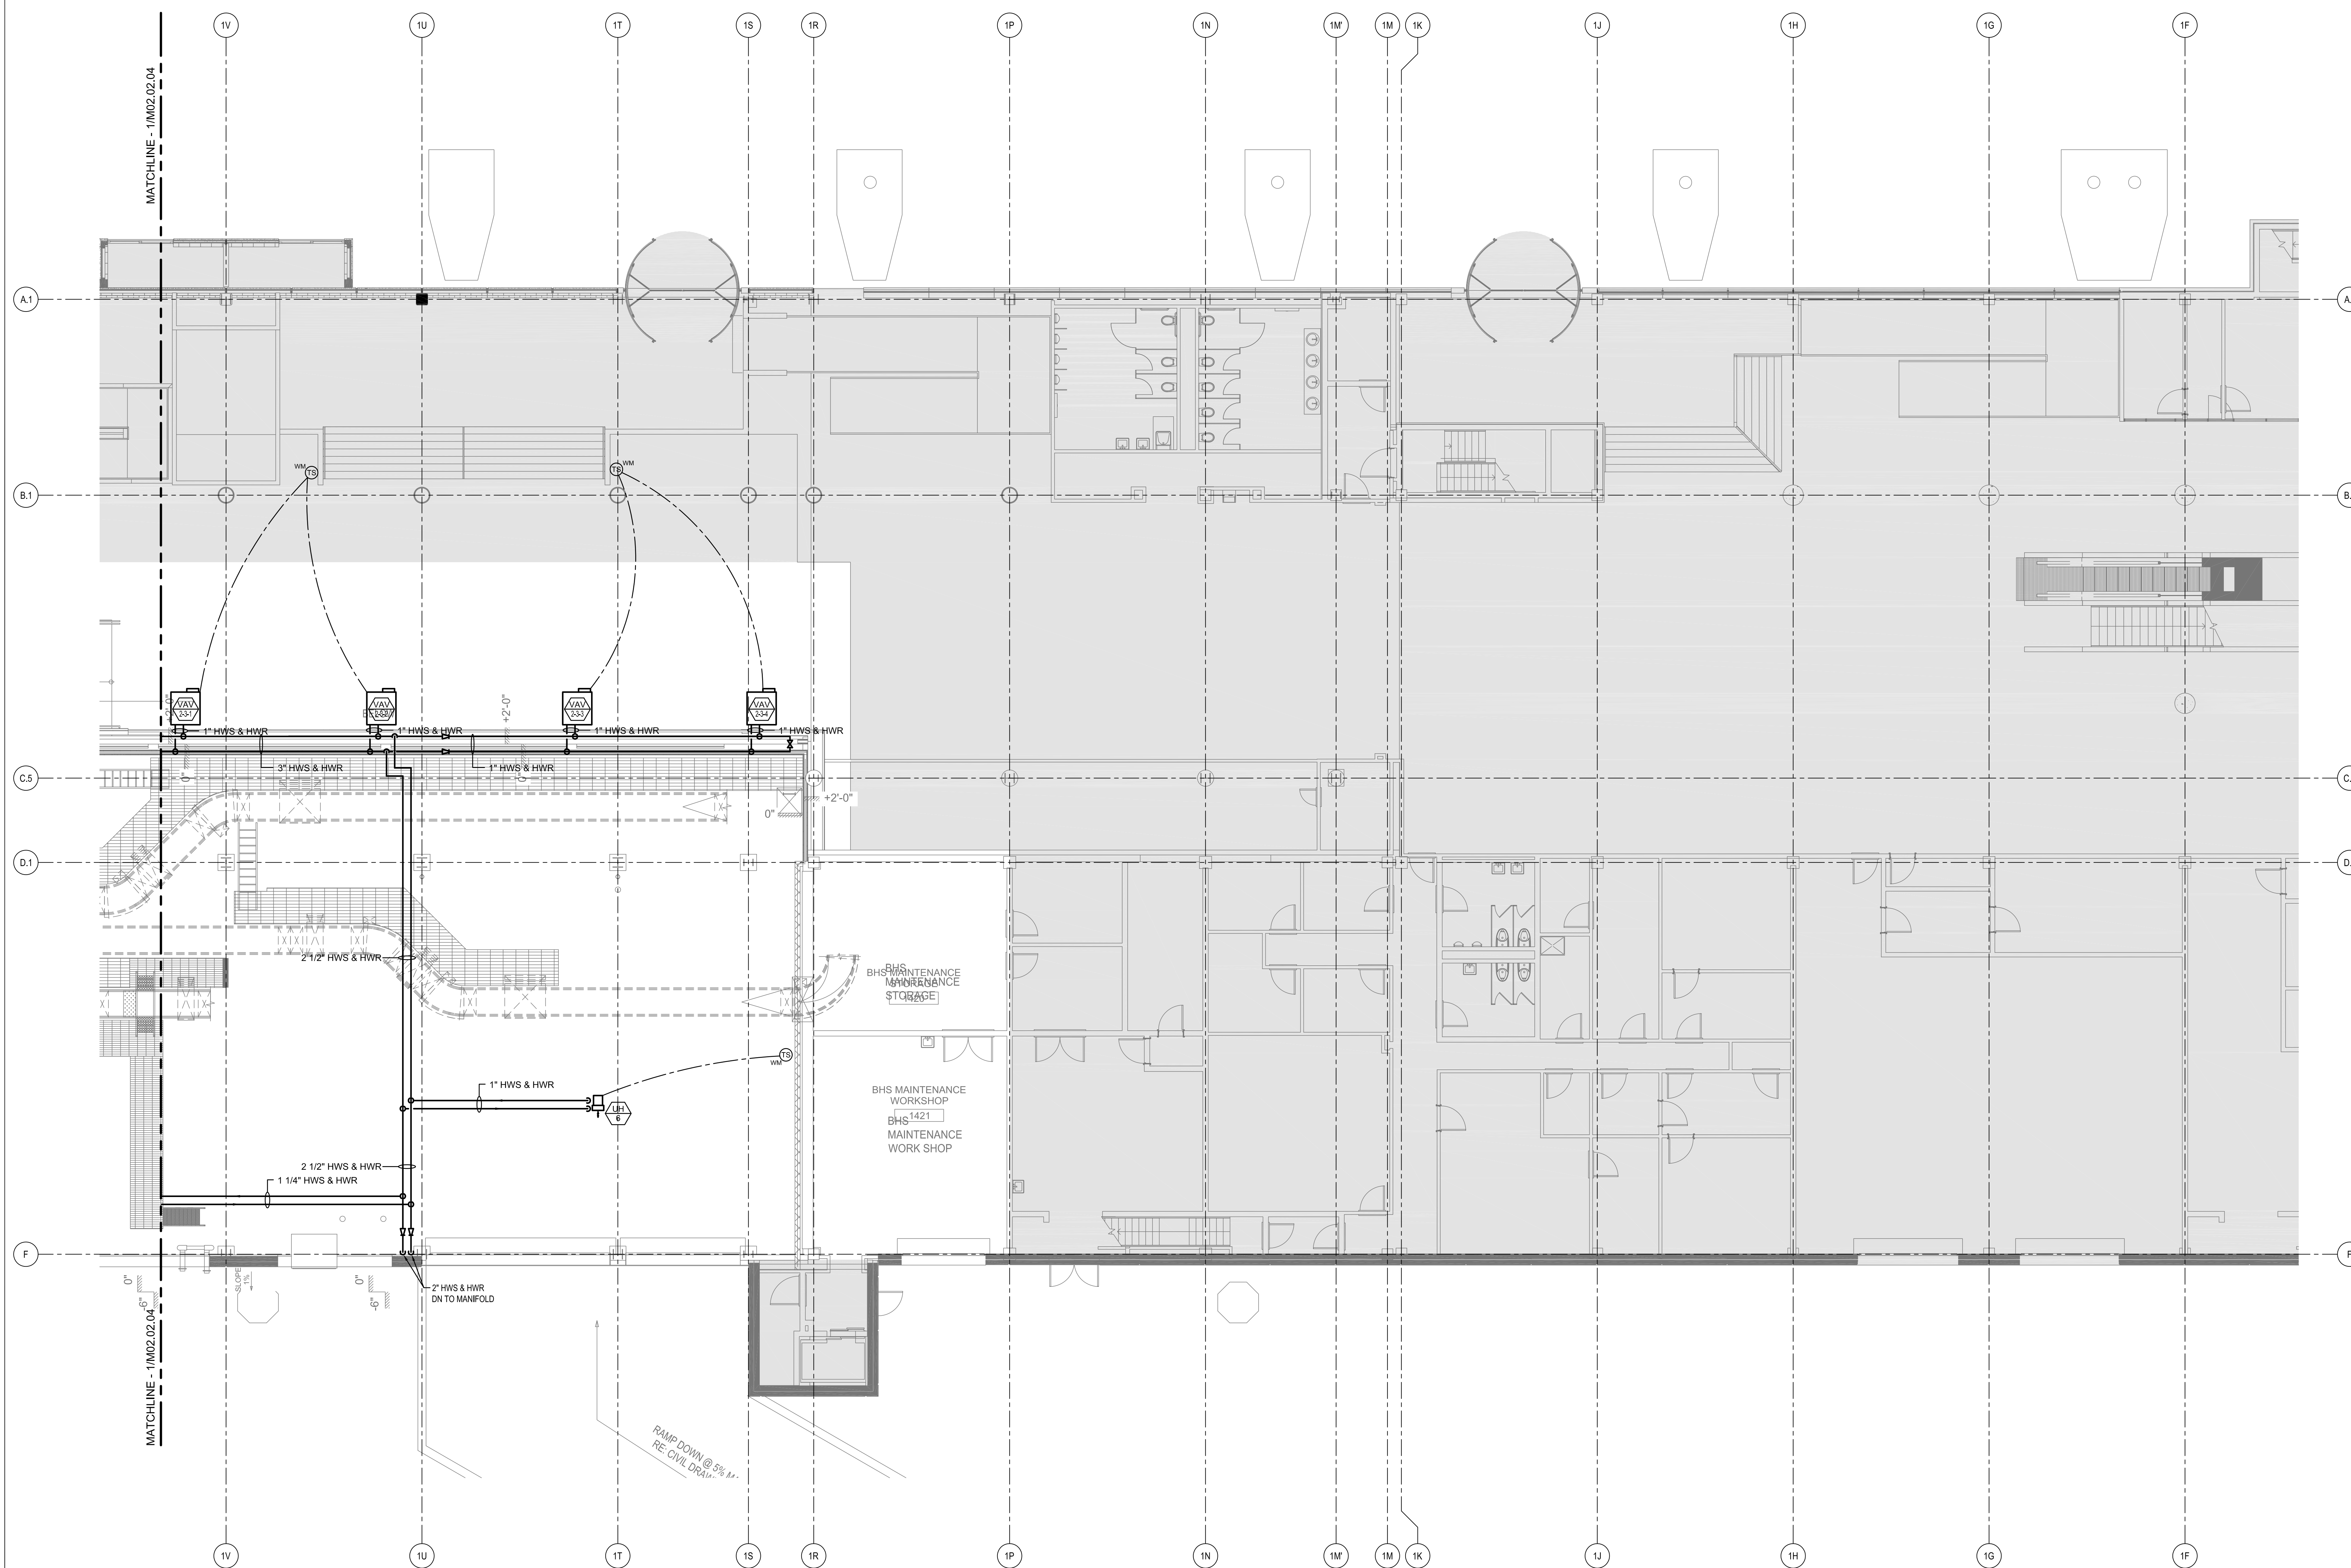

GENERAL NOTES

- A SEE SHEET M00.00 FOR LEGEND AND GENERAL NOTES.
- B MAINTAIN 18" MIN CLEARANCE FROM RADIANT TUBING TO FLOOR DRAINS, COLUMN WRAPS, PLUMBING FIXTURES, EQUIPMENT SUPPORTS, AND PIPING AT FLOORS.
- C RUN ALL PIPING HIGH AS POSSIBLE WITHIN BEAM POCKET TO AVOID BAGGAGE HANDLING EQUIPMENT.

Issue	Date & Issue Description	By	Check
01	12/03/08 75% DESIGN DEVELOPMENT	PWZ	RHB
02	01/23/09 95% CONSTRUCTION DOCUMENTS	PWZ	RHB
02	10/26/09 ISSUED FOR PERMIT	PWZ	RHB

Seed/Signature


Project Name: PWM Terminal Enhancement (Date: 10/26/09)

Project Number: 09-6395-000

CAD File Name: T:\5330\101\Sheets\M02.02.03.dwg

Description: MECHANICAL PIPING PLAN - LEVEL 2 - ZONE 3

KEY PLAN

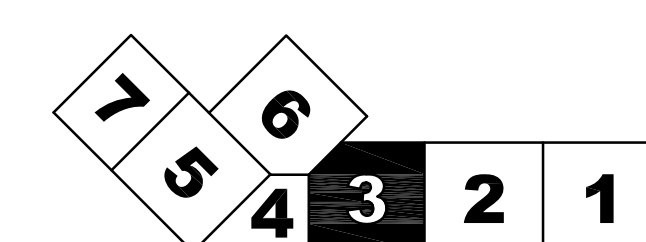

Scale: 1/8" = 1'-0"

Ref. North

M02.02.03

©2009 Gensler