




DETAIL - BYPASS CHEMICAL FEEDER 13
SCALE: NOT TO SCALE

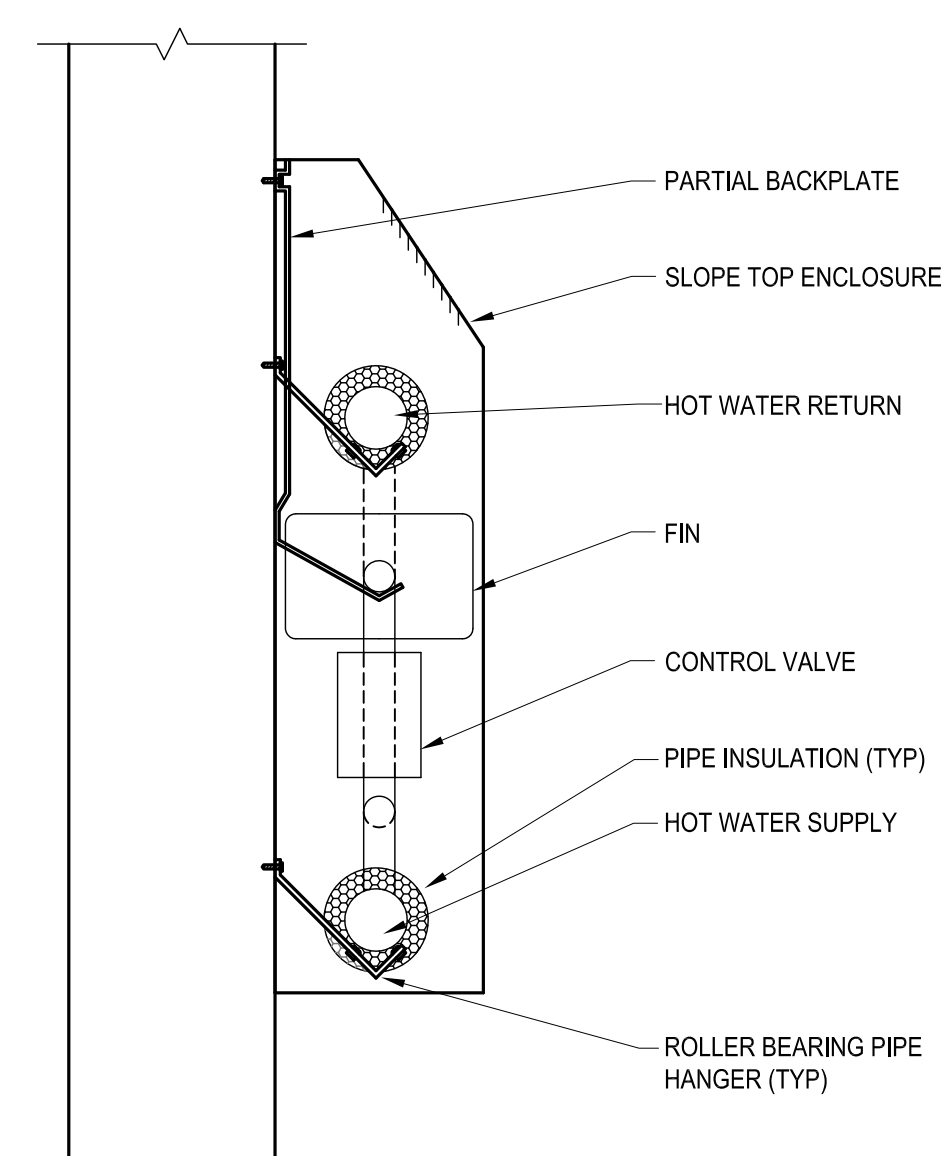


DETAIL - HOT WATER FIN TUBE SECTION 9
SCALE: NOT TO SCALE

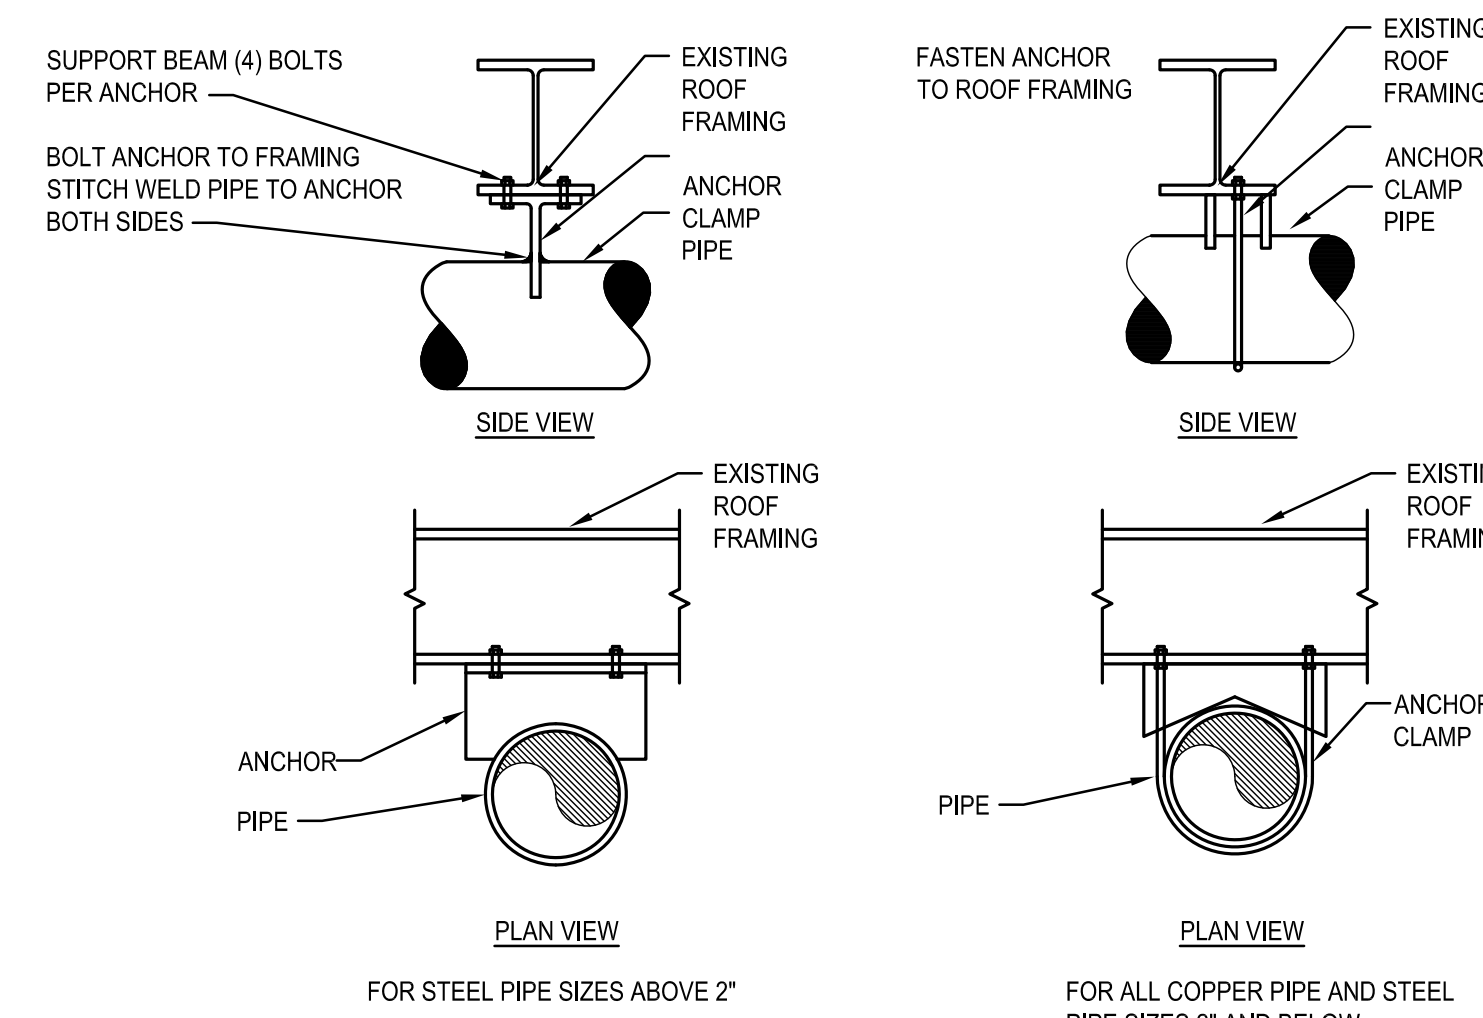


DETAIL - PIPE ANCHOR 5
SCALE: NOT TO SCALE

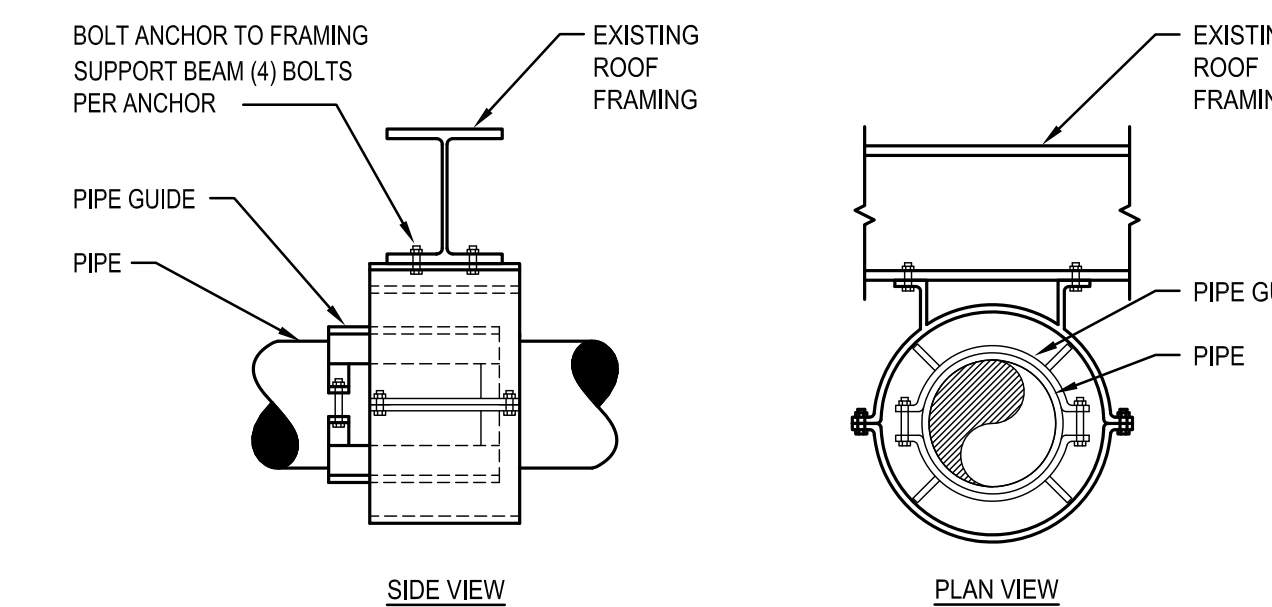


DETAIL - PIPE SPIDER GUIDE DETAIL 1
SCALE: NOT TO SCALE

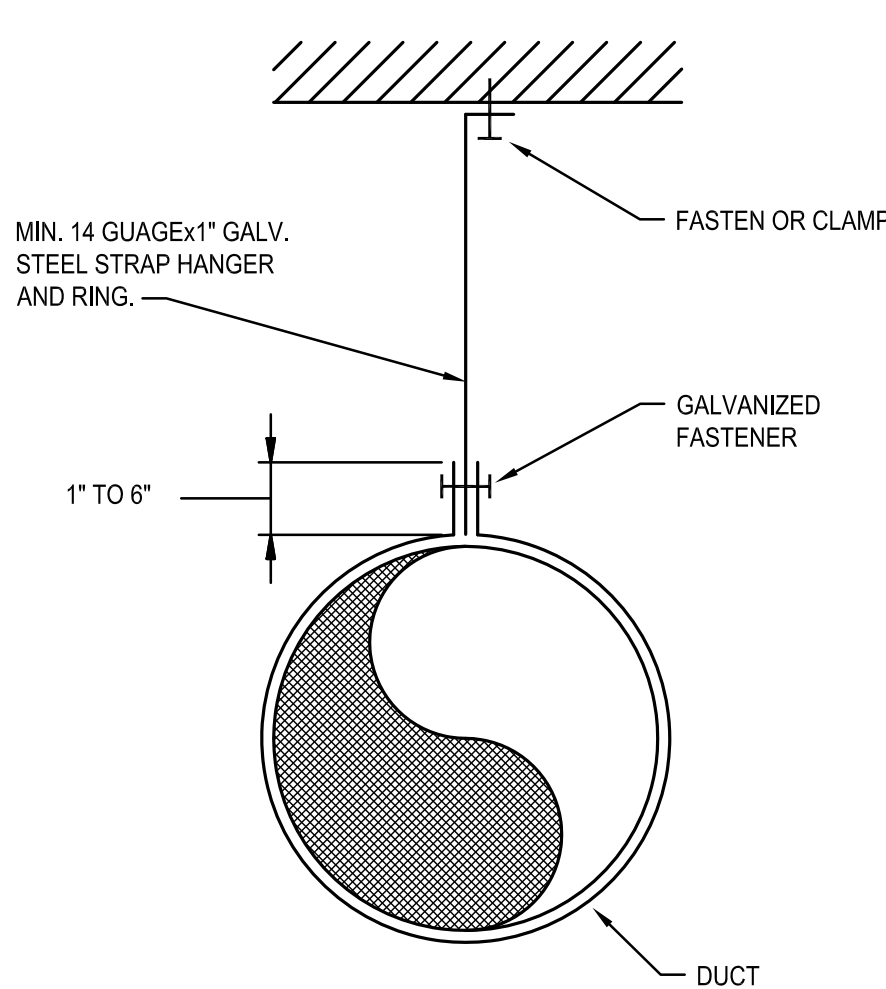


DETAIL - ROUND DUCT HANGER 14
SCALE: NOT TO SCALE

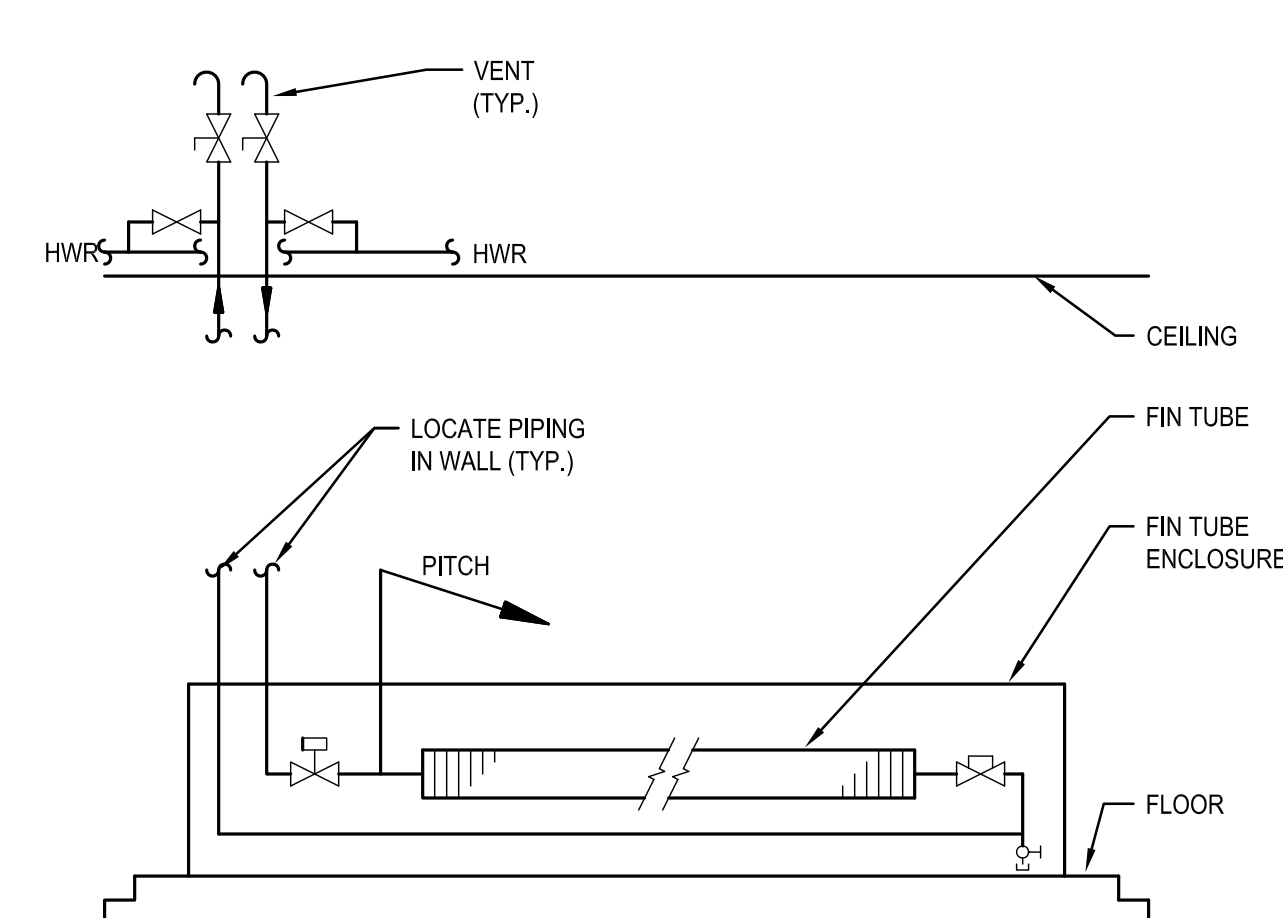


DETAIL - HOT WATER FTR PIPING 10
SCALE: NOT TO SCALE

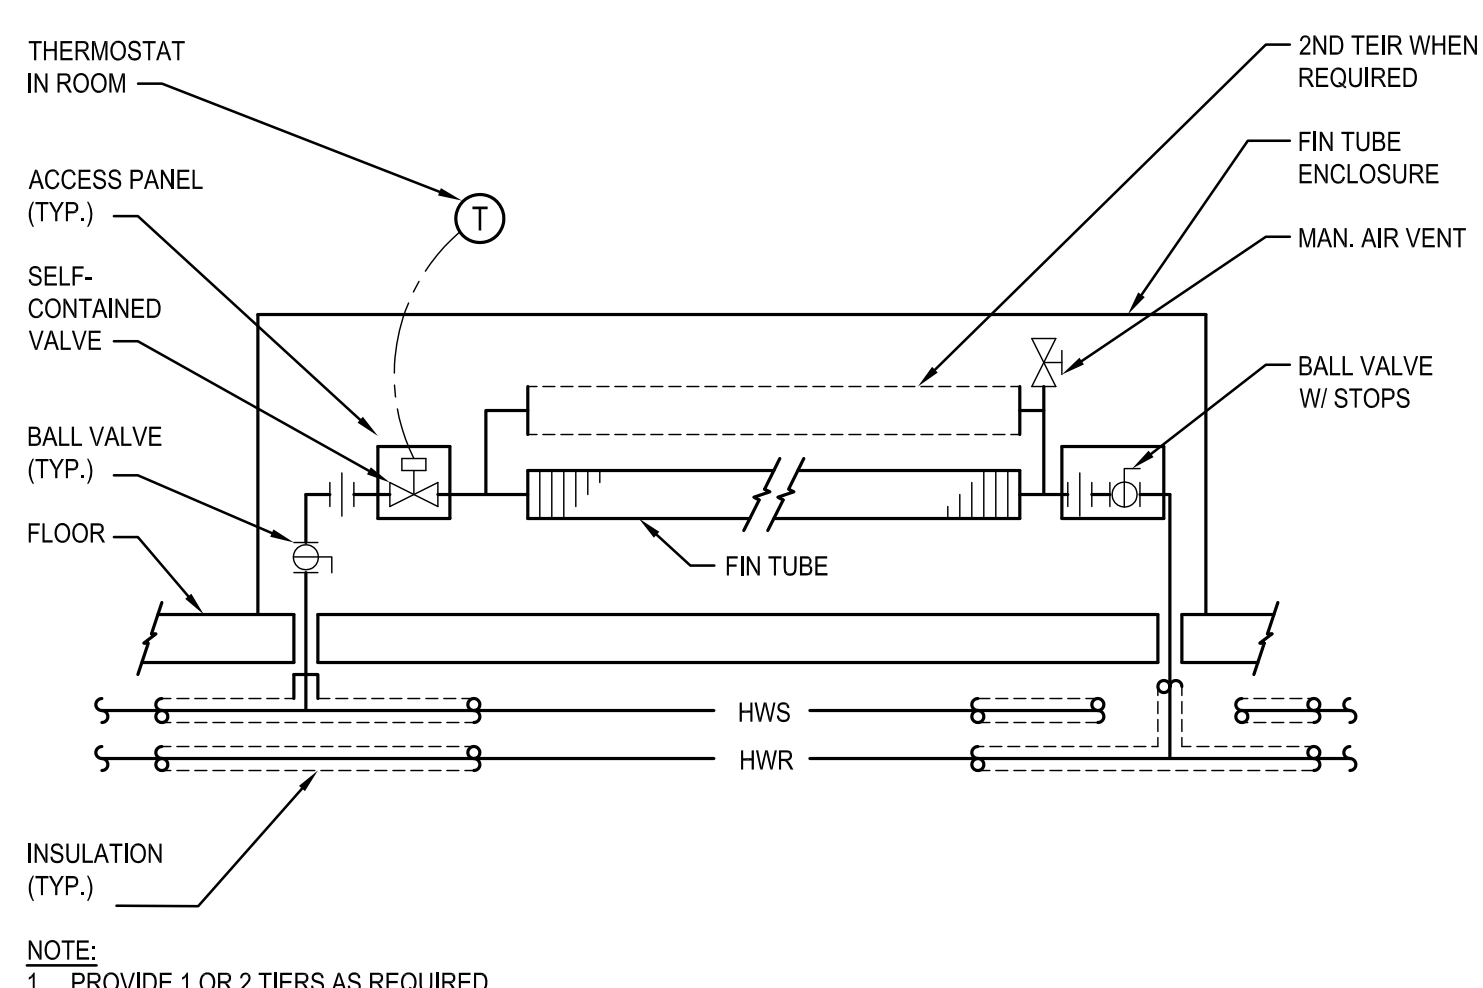


DETAIL - HOT WATER FTR PIPING 6
SCALE: NOT TO SCALE

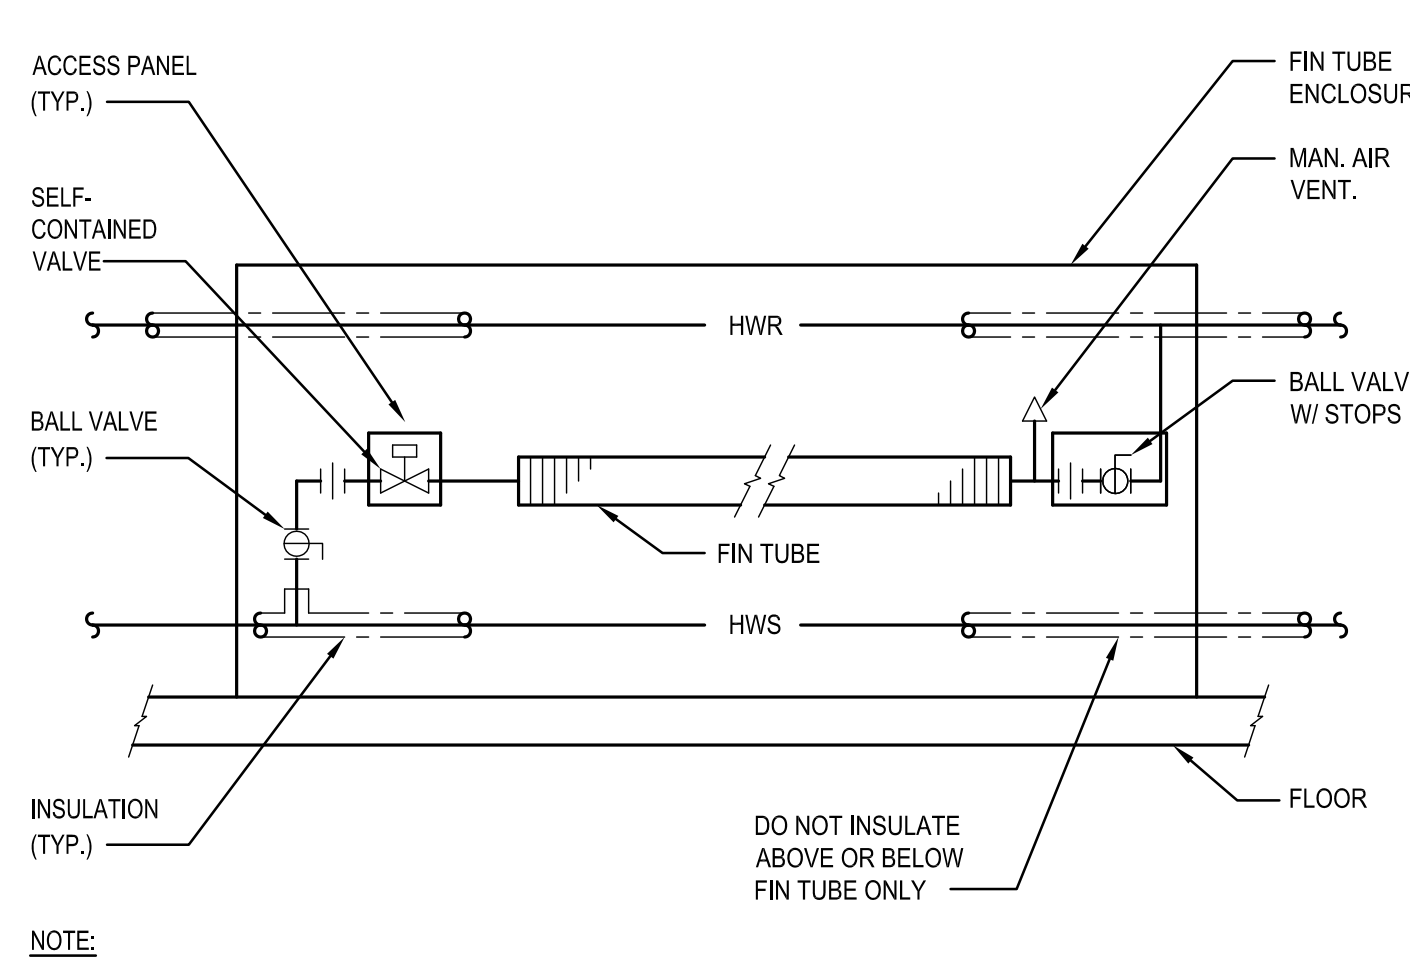


DETAIL - HOT WATER FTR PIPING 2
SCALE: NOT TO SCALE

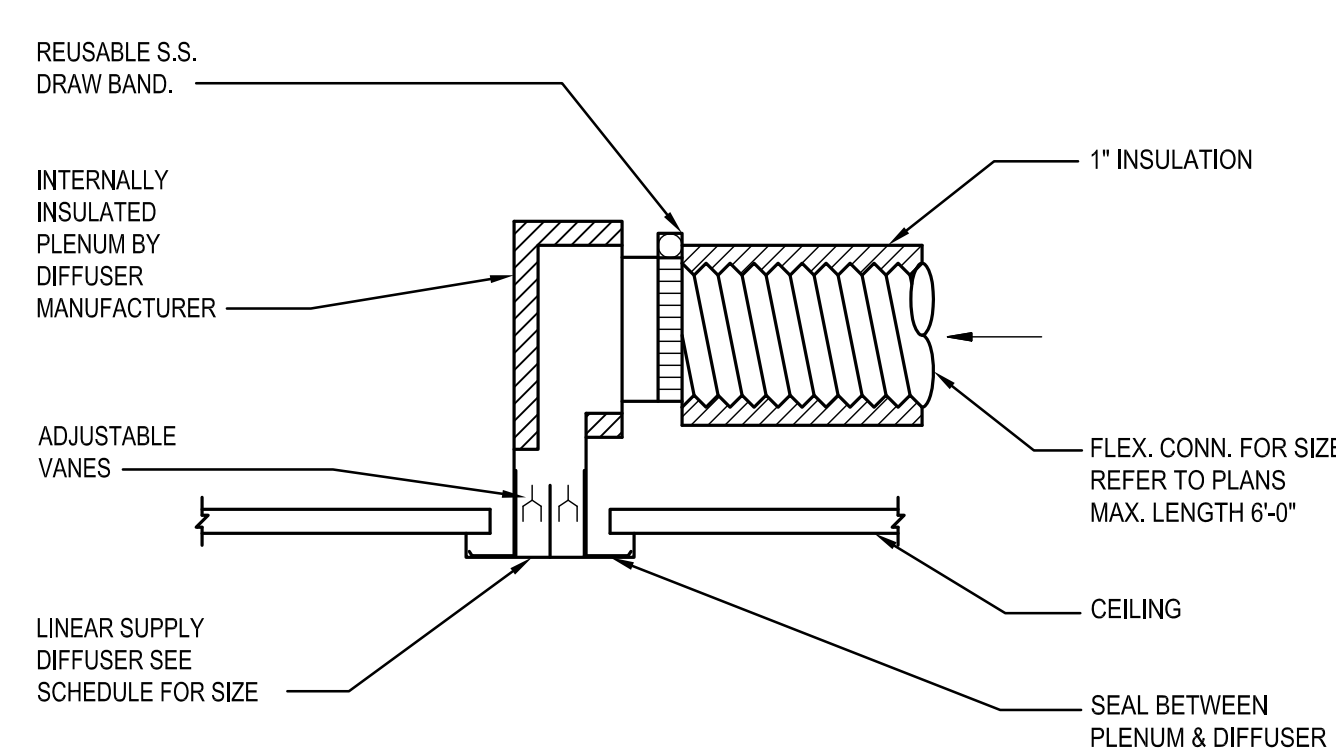


DETAIL - LINEAR DIFFUSER PLENUM 15
SCALE: NOT TO SCALE

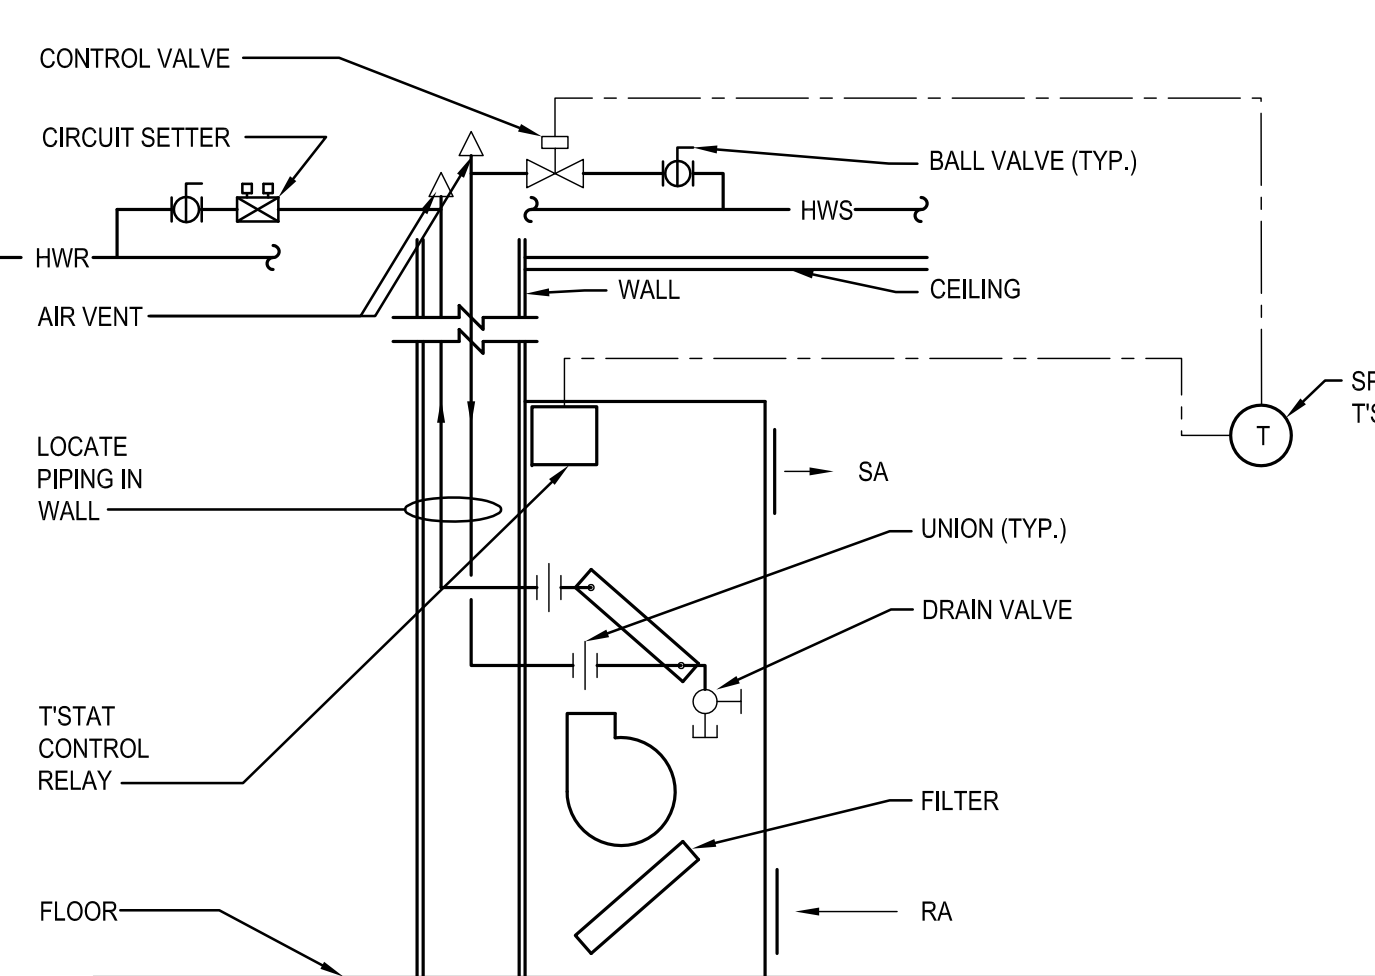


DETAIL - WALL CABINET UNIT HEATER 11
SCALE: NOT TO SCALE

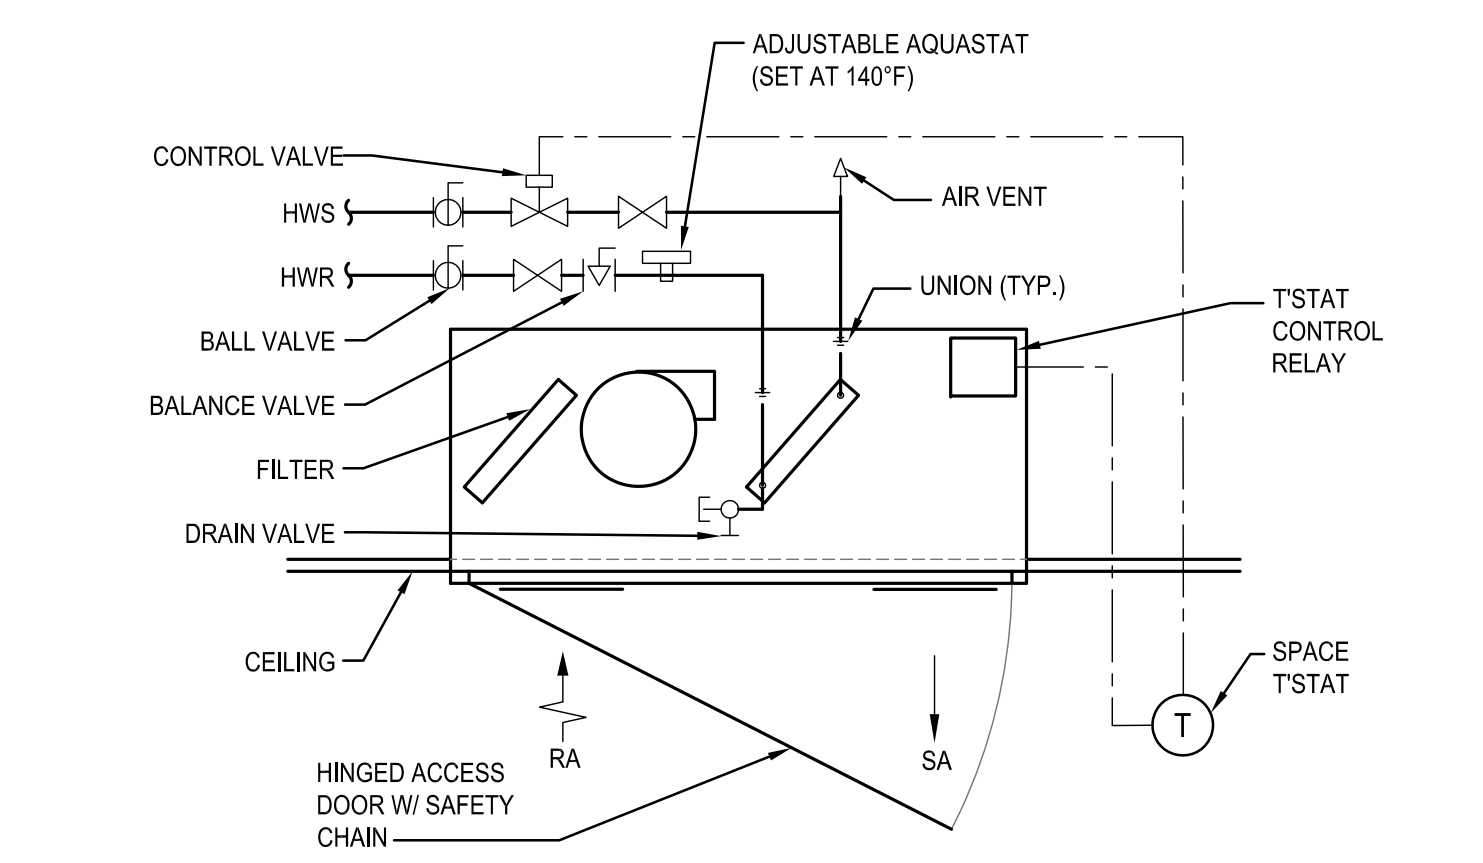


DETAIL - CEILING RECESSED CABINET UNIT HEATER 7
SCALE: NOT TO SCALE

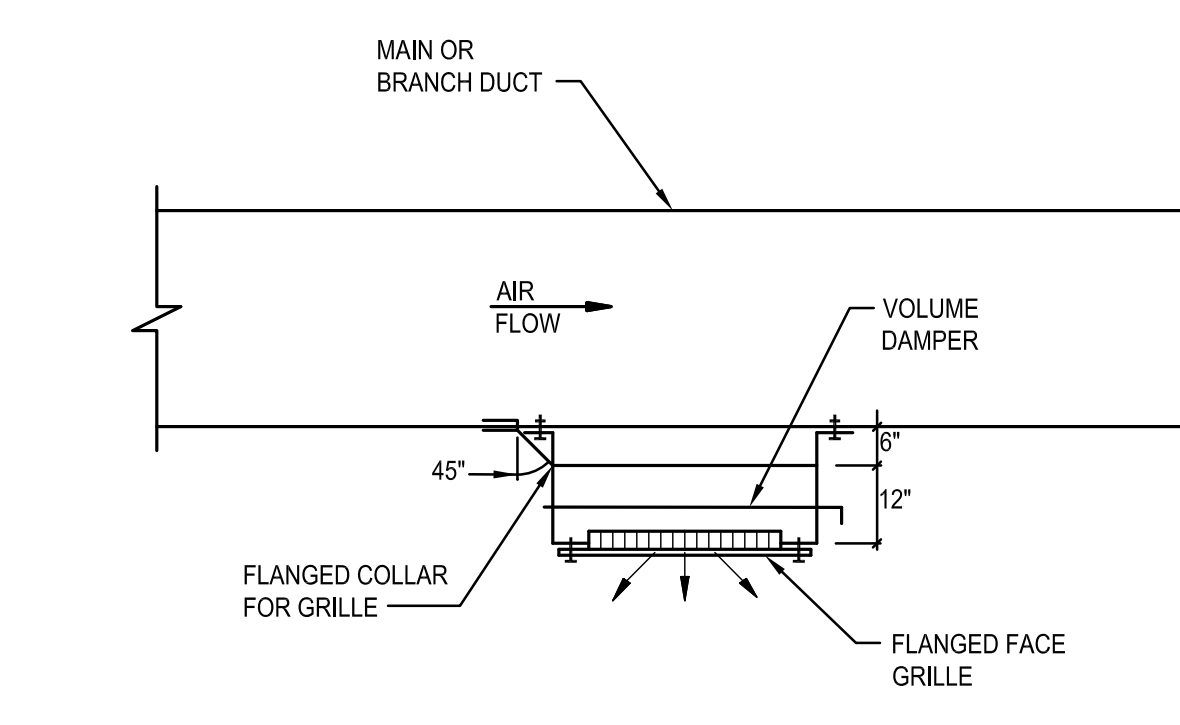


DETAIL - DUCT SUPPLY GRILLE TAKE OFF 3
SCALE: NOT TO SCALE

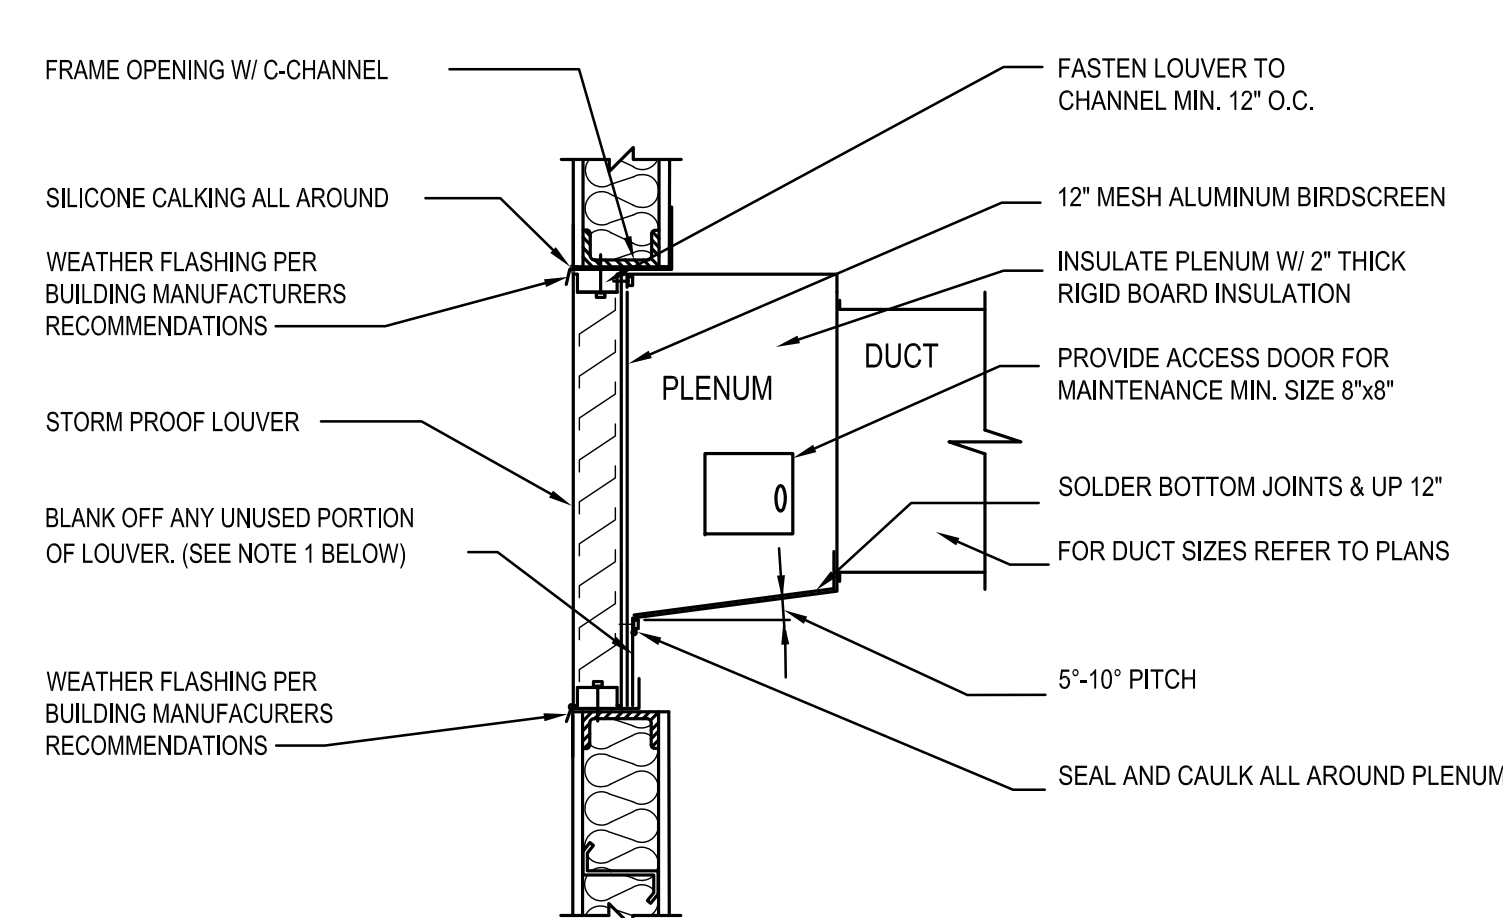


DETAIL - LOUVER CONNECTION 16
SCALE: NOT TO SCALE

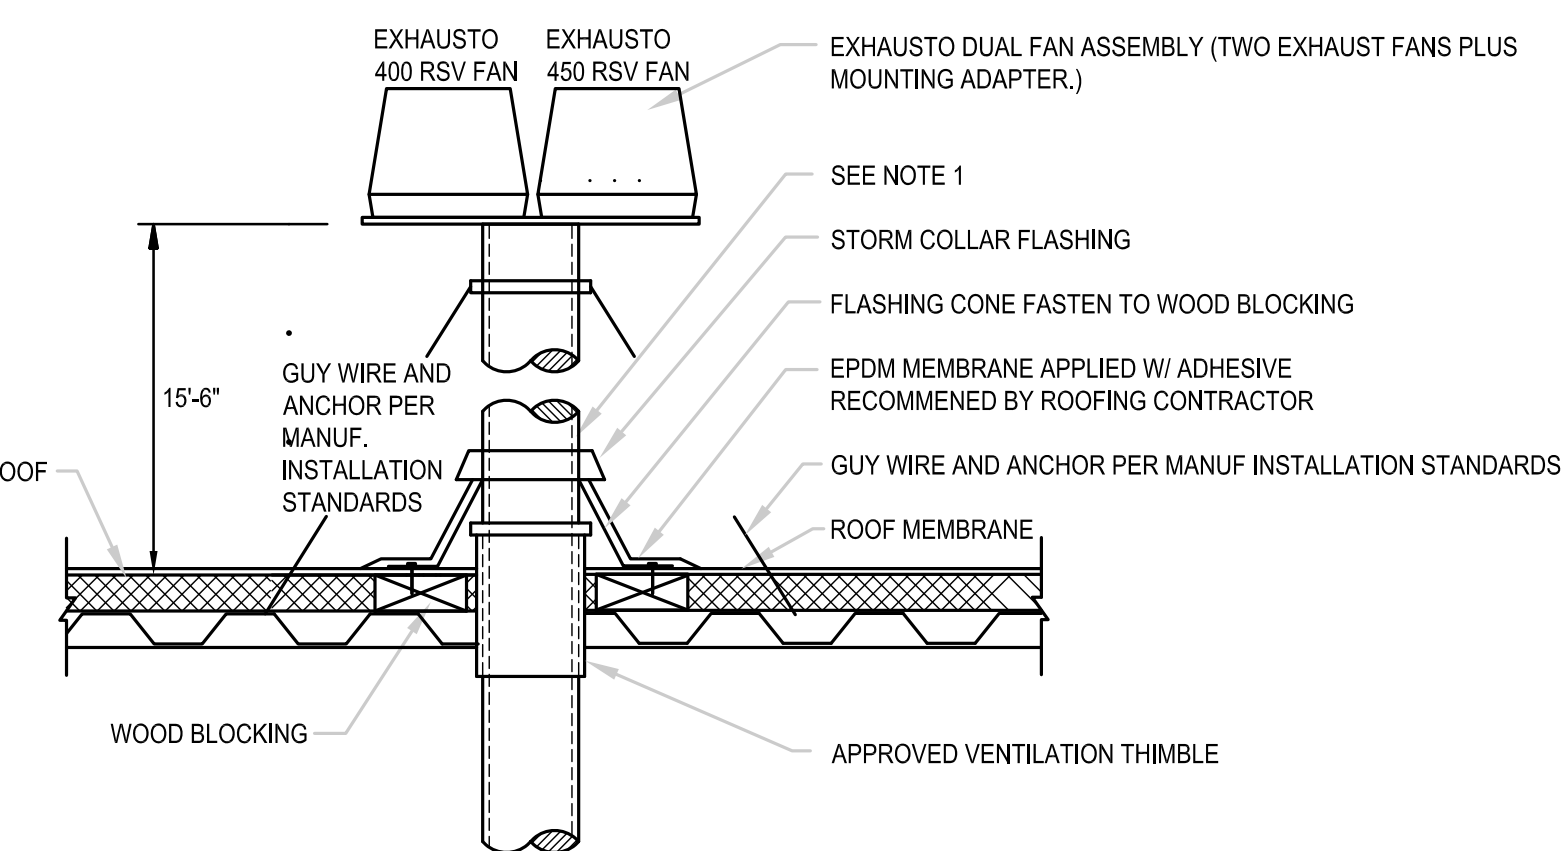

DETAIL - POSITIVE PRESSURE FLUE 12
SCALE: NOT TO SCALE

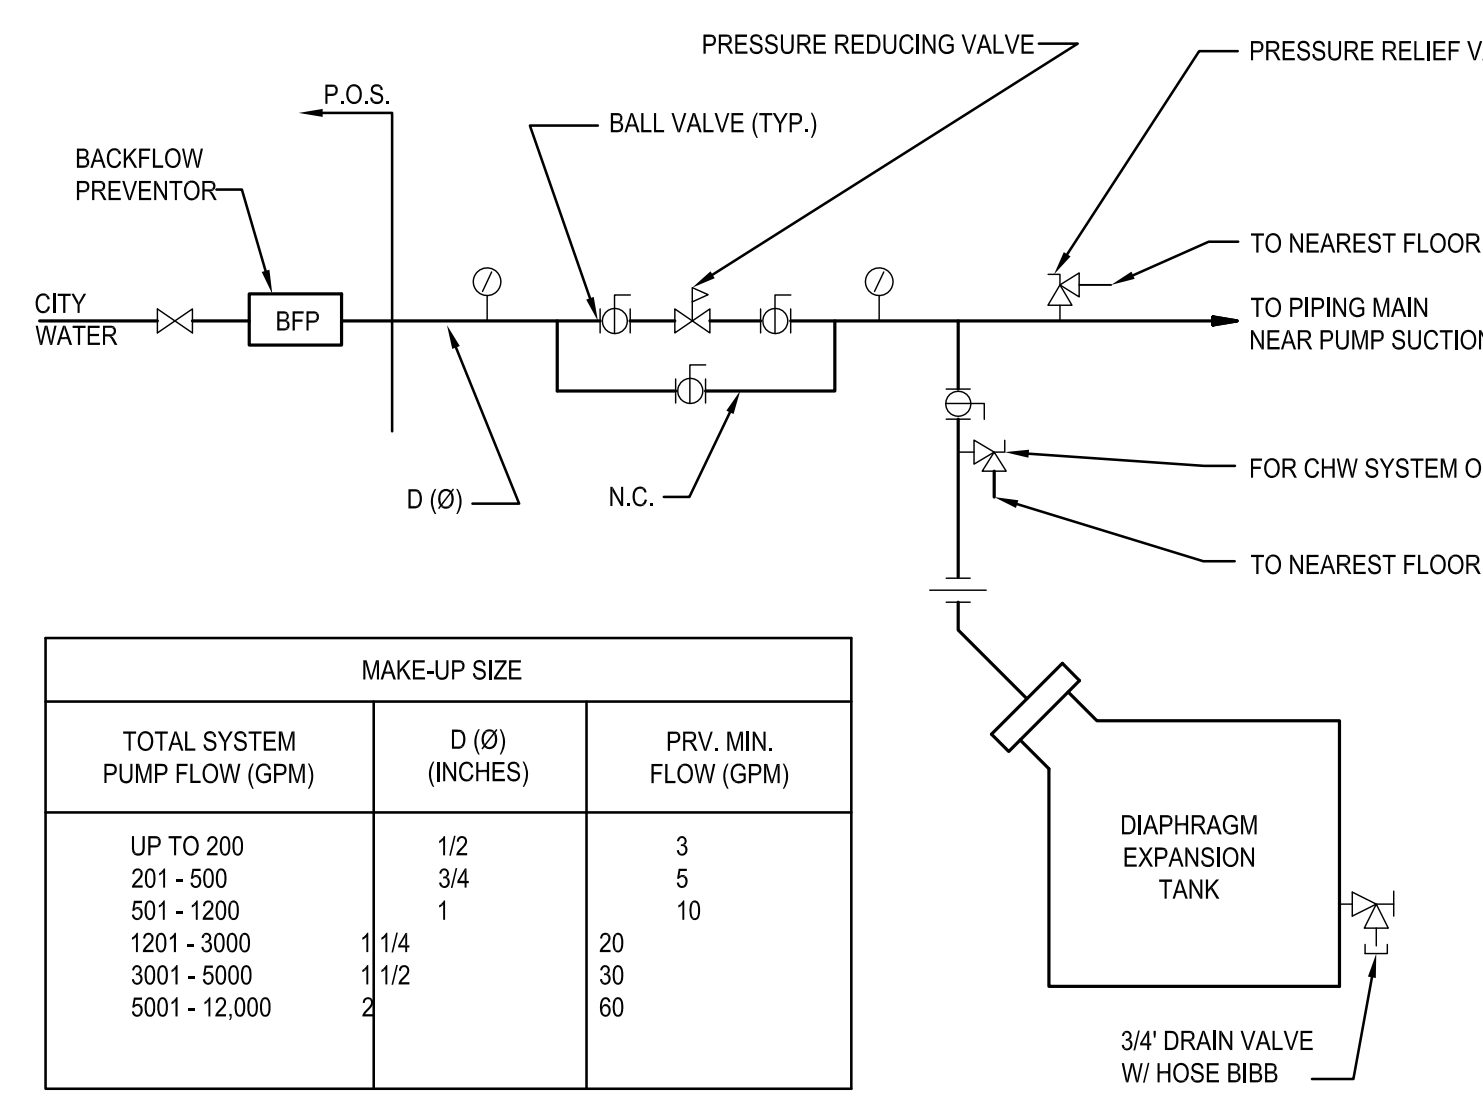

DETAIL - MAKE-UP WATER & DIAPHRAGM EXPANSION TANK 8
SCALE: NOT TO SCALE

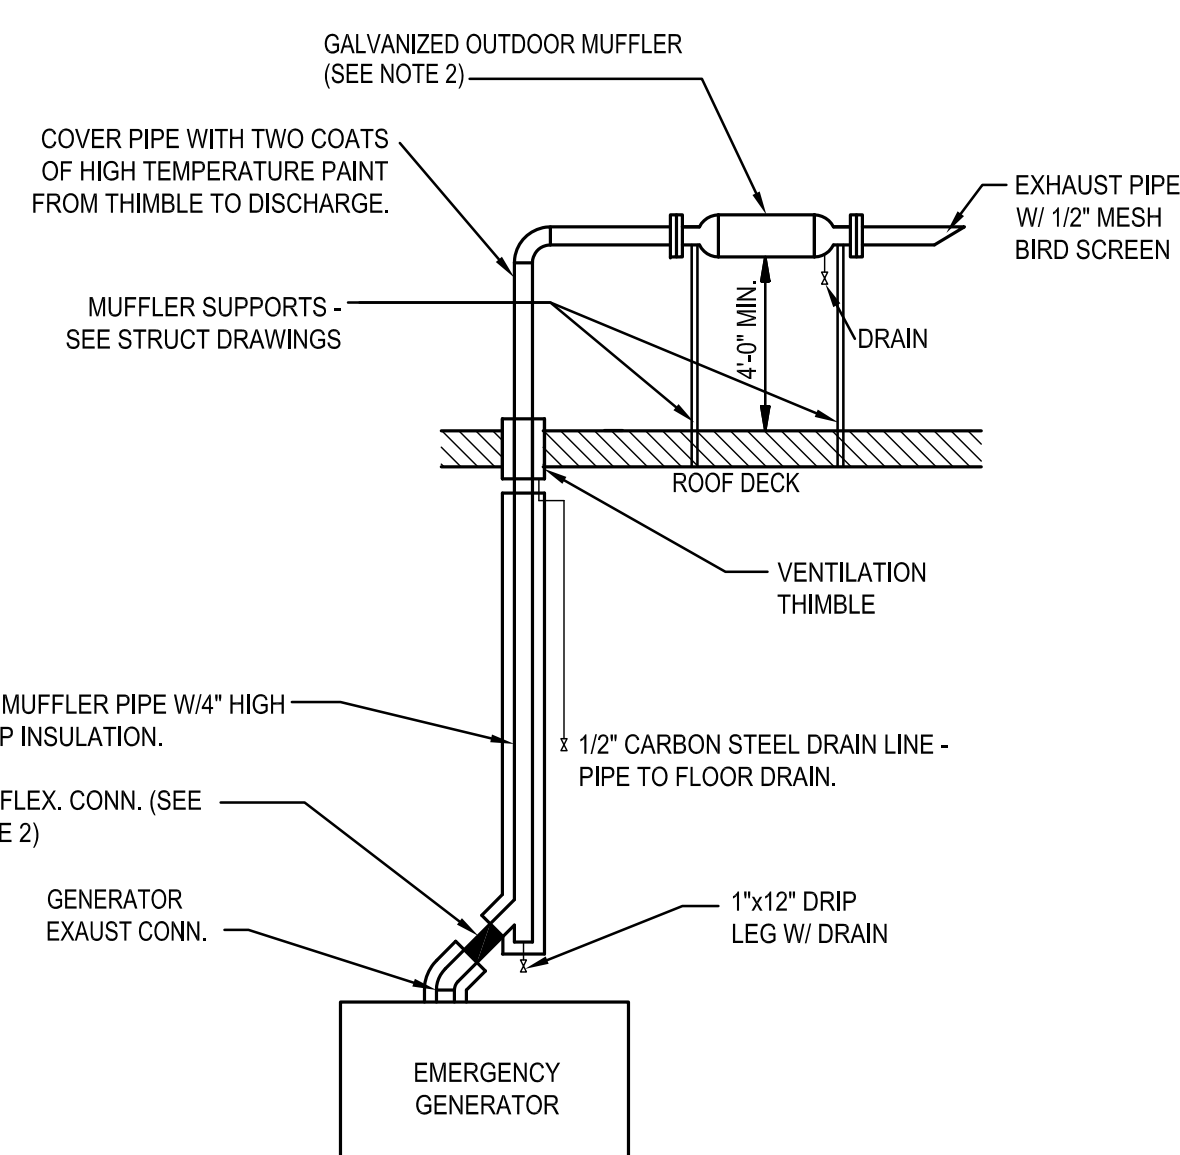

DETAIL - GENERATOR EXHAUST PIPE 4
SCALE: NOT TO SCALE


GENERAL NOTES

A SEE SHEET M00.00 FOR LEGEND AND GENERAL NOTES.

Issue	Date & Issue Description	By	Check
01	12/03/08	PWZ	RHB
02	01/23/09	PWZ	RHB
02	10/26/09	PWZ	RHB

ISSUED FOR PERMIT

Project Name	Project Number
PWM Terminal Enhancement	09-0395-000

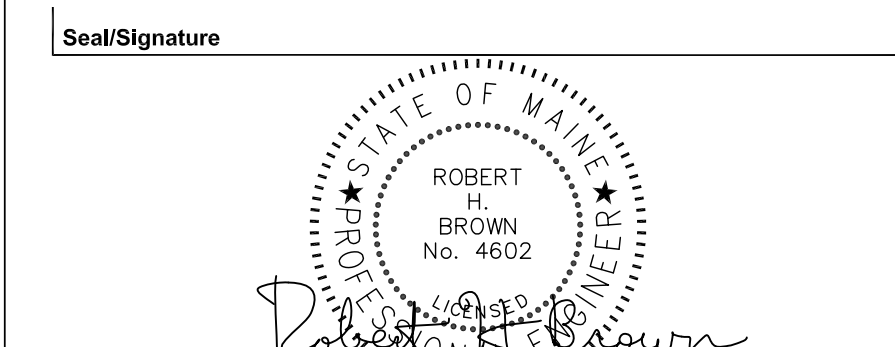

CAD File Name: T:\5330101\Sheets\M12.12.dwg
Description: MECHANICAL DETAILS

Scale: NOT TO SCALE