

SHEET NOTES

01 PRC PASSES THROUGH 24" BEAM AT CENTERLINE OF WEB.


Portland International Jetport

1001 Westbrook Street
Portland, Maine 04102

Gensler

2020 K Street, NW
Suite 200
Washington, DC 20006
Telephone 202.721.5200
Facsimile 202.872.8587

oest ASSOCIATES, INC.
363 Goshen Road, South Portland, ME 04106 P: (207) 741-1770 F: (207) 774-2466 www.oest.com
engineers • architects • surveyors • construction managers

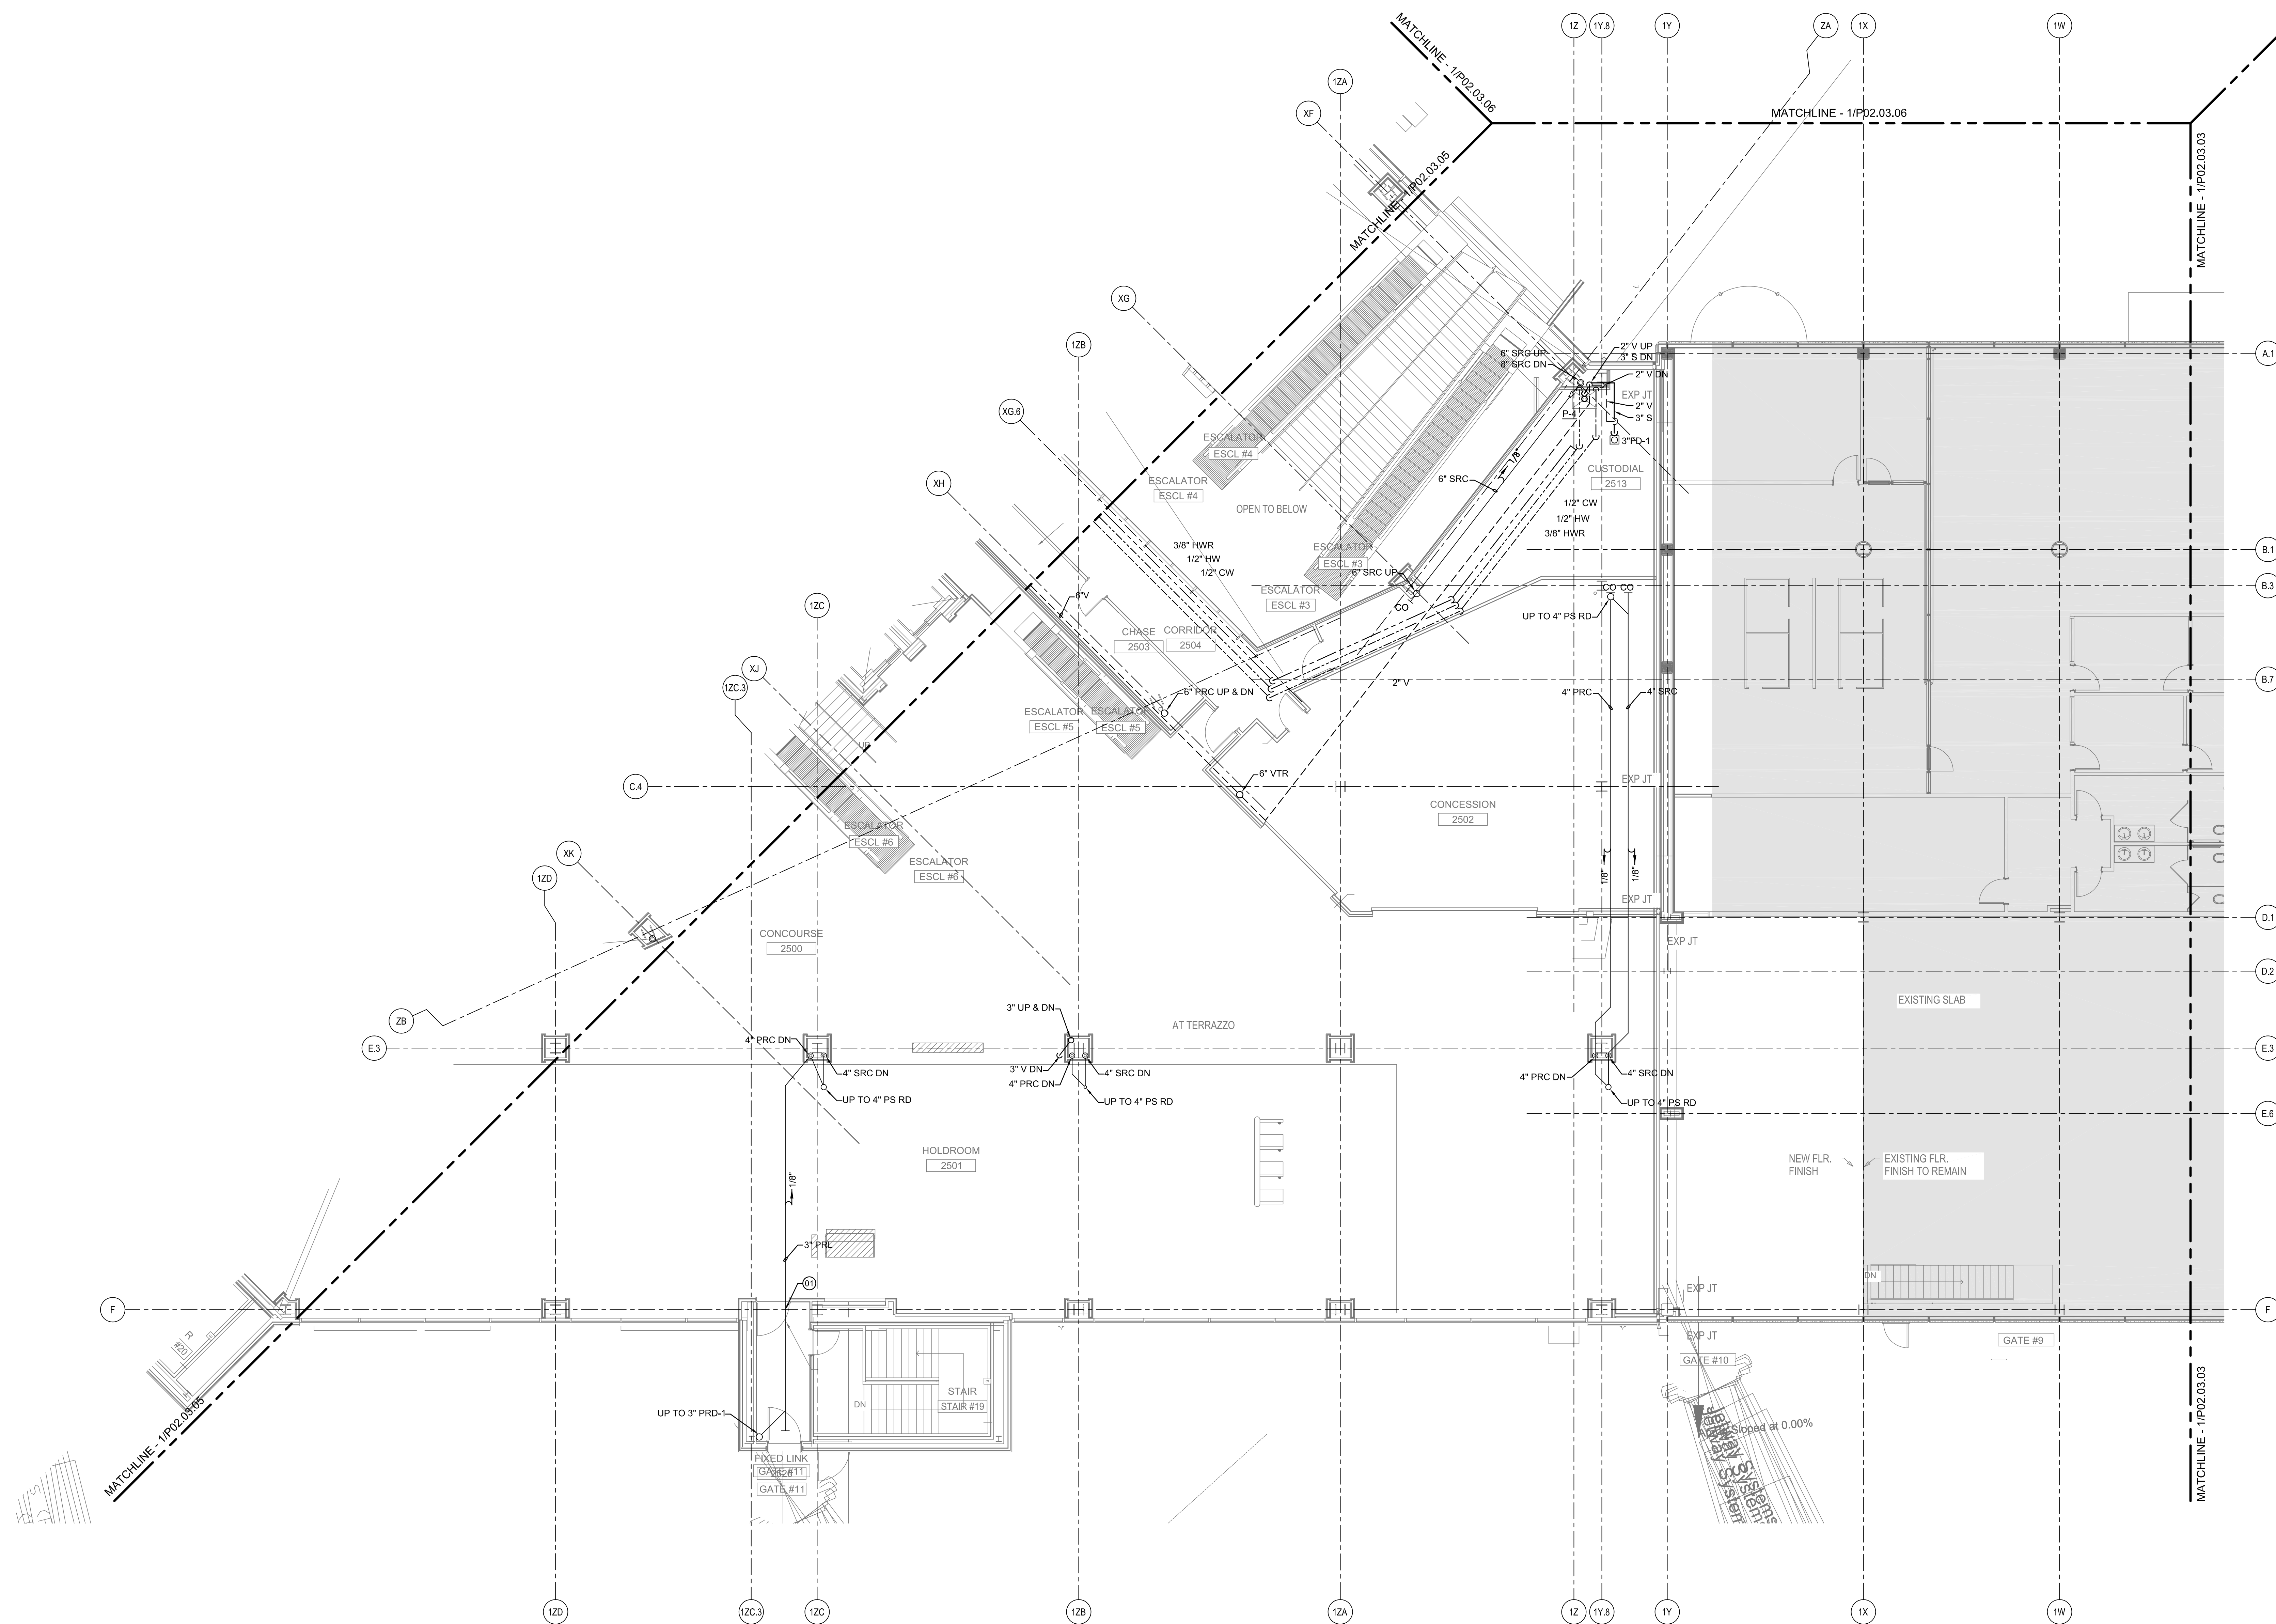


GENERAL NOTES

A SEE SHEET P00.00 FOR LEGEND AND GENERAL NOTES.

Issue	Date	Issue Description	By	Check
01	07/11/08	SCHEMATIC DESIGN	PWZ	JS
02	09/22/08	DESIGN DEVELOPMENT	PWZ	JS
03	12/03/08	75% CONSTRUCTION DOCUMENTS	KLM	JS
04	01/23/09	95% CONSTRUCTION DOCUMENTS	CM	JS
05	10/26/09	ISSUED FOR PERMIT	PWZ	JS

KEY PLAN

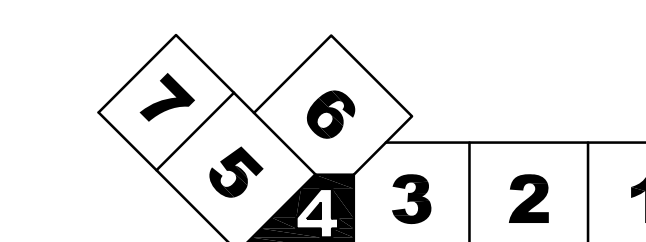

Seed/Signature

Project Name
PJM Terminal Enhancement

Project Number
09-6395-000

CAD File Name
T:\5330\101\Sheet\P02.03.04.dwg

Description
PLUMBING PLAN - LEVEL 3 - ZONE 4

Scale
1/8" = 1'-0"



P02.03.04

©2009 Gensler