


SHEET NOTES

Portland International
Jetport
1001 Westbrook Street
Portland, Maine 04102

Gensler
2020 K Street, NW
Suite 200
Washington, DC 20006
Telephone 202.721.5200
Facsimile 202.872.8587

oest ASSOCIATES, INC.
340 Gophers Road South Portland, ME 04106 P (207) 761-7777 F (207) 774-1244 www.oest.com
engineers • architects • surveyors • construction managers

FIRE RISK MANAGEMENT, INC.
1 First Street
Rush, ME 04958
(207) 442-7268
www.fire-risk.com

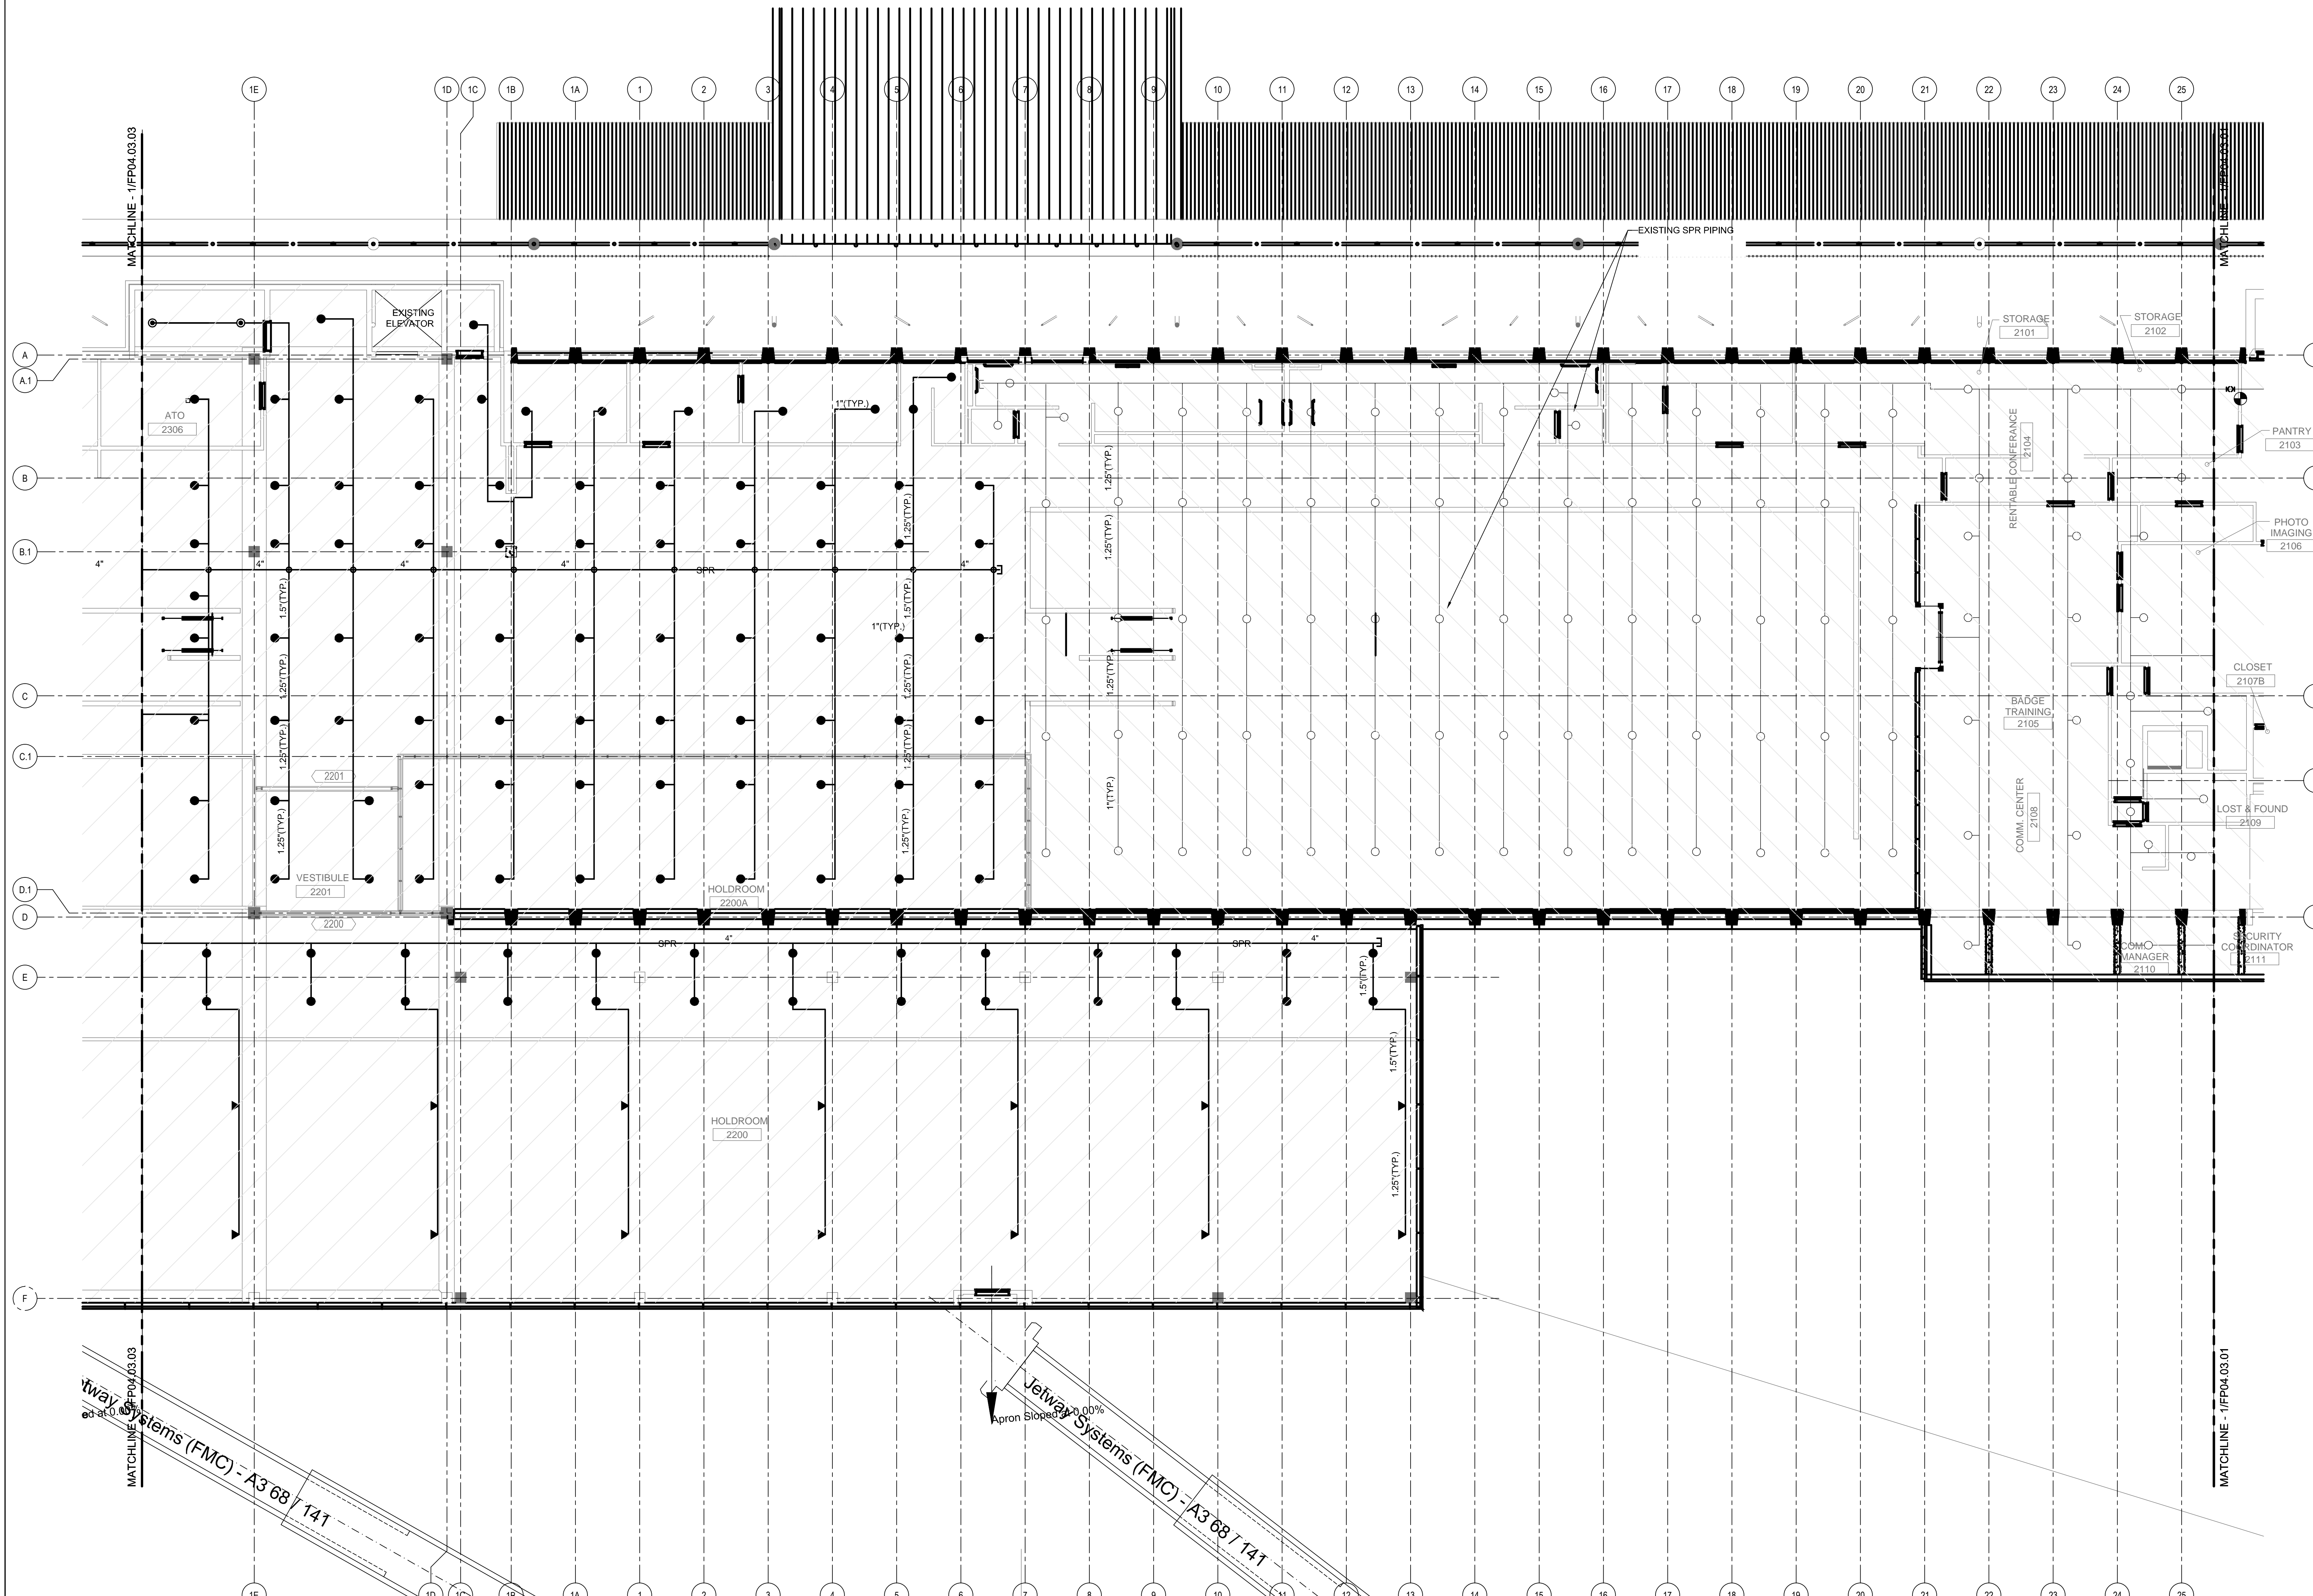


GENERAL NOTES

A SEE SHEET F00.01 FOR LEGEND, SCHEDULES & GENERAL NOTES.

Issue	Date & Issue Description	By	Check
01	09/22/08	SKD	WMC
02	12/03/08	SKD	WMC
03	01/23/09	MHY	JLD
04	10/26/09	JLD	SKD

ISSUED FOR PERMIT

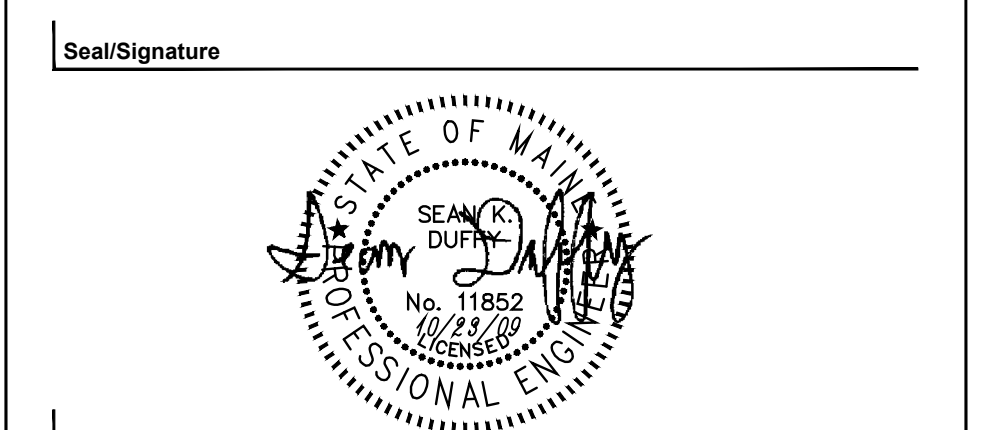

Project Name
PJM Terminal Expansion

Project Number
08.0395.000

CAD File Name
FP04.03.02.dwg

Description
FIRE PROTECTION PLAN - LEVEL 3 - ZONE 2


Scale
1/8" = 1'-0"

Ref. North

FP04.03.02

©2009 Gensler

KEY PLAN

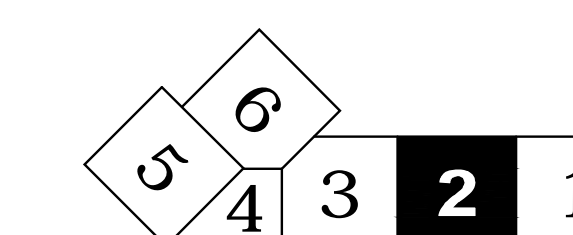

FIRE PROTECTION PLAN - LEVEL 3 - ZONE 2

SCALE: 1/8"=1'-0"