


**Portland International
Jetport**

1001 Westbrook Street
Portland, Maine 04102

2020 K Street, Northwest
Suite 200
Washington DC 20006
Telephone 202.721.5200
Facsimile 202.872.8587

Gensler

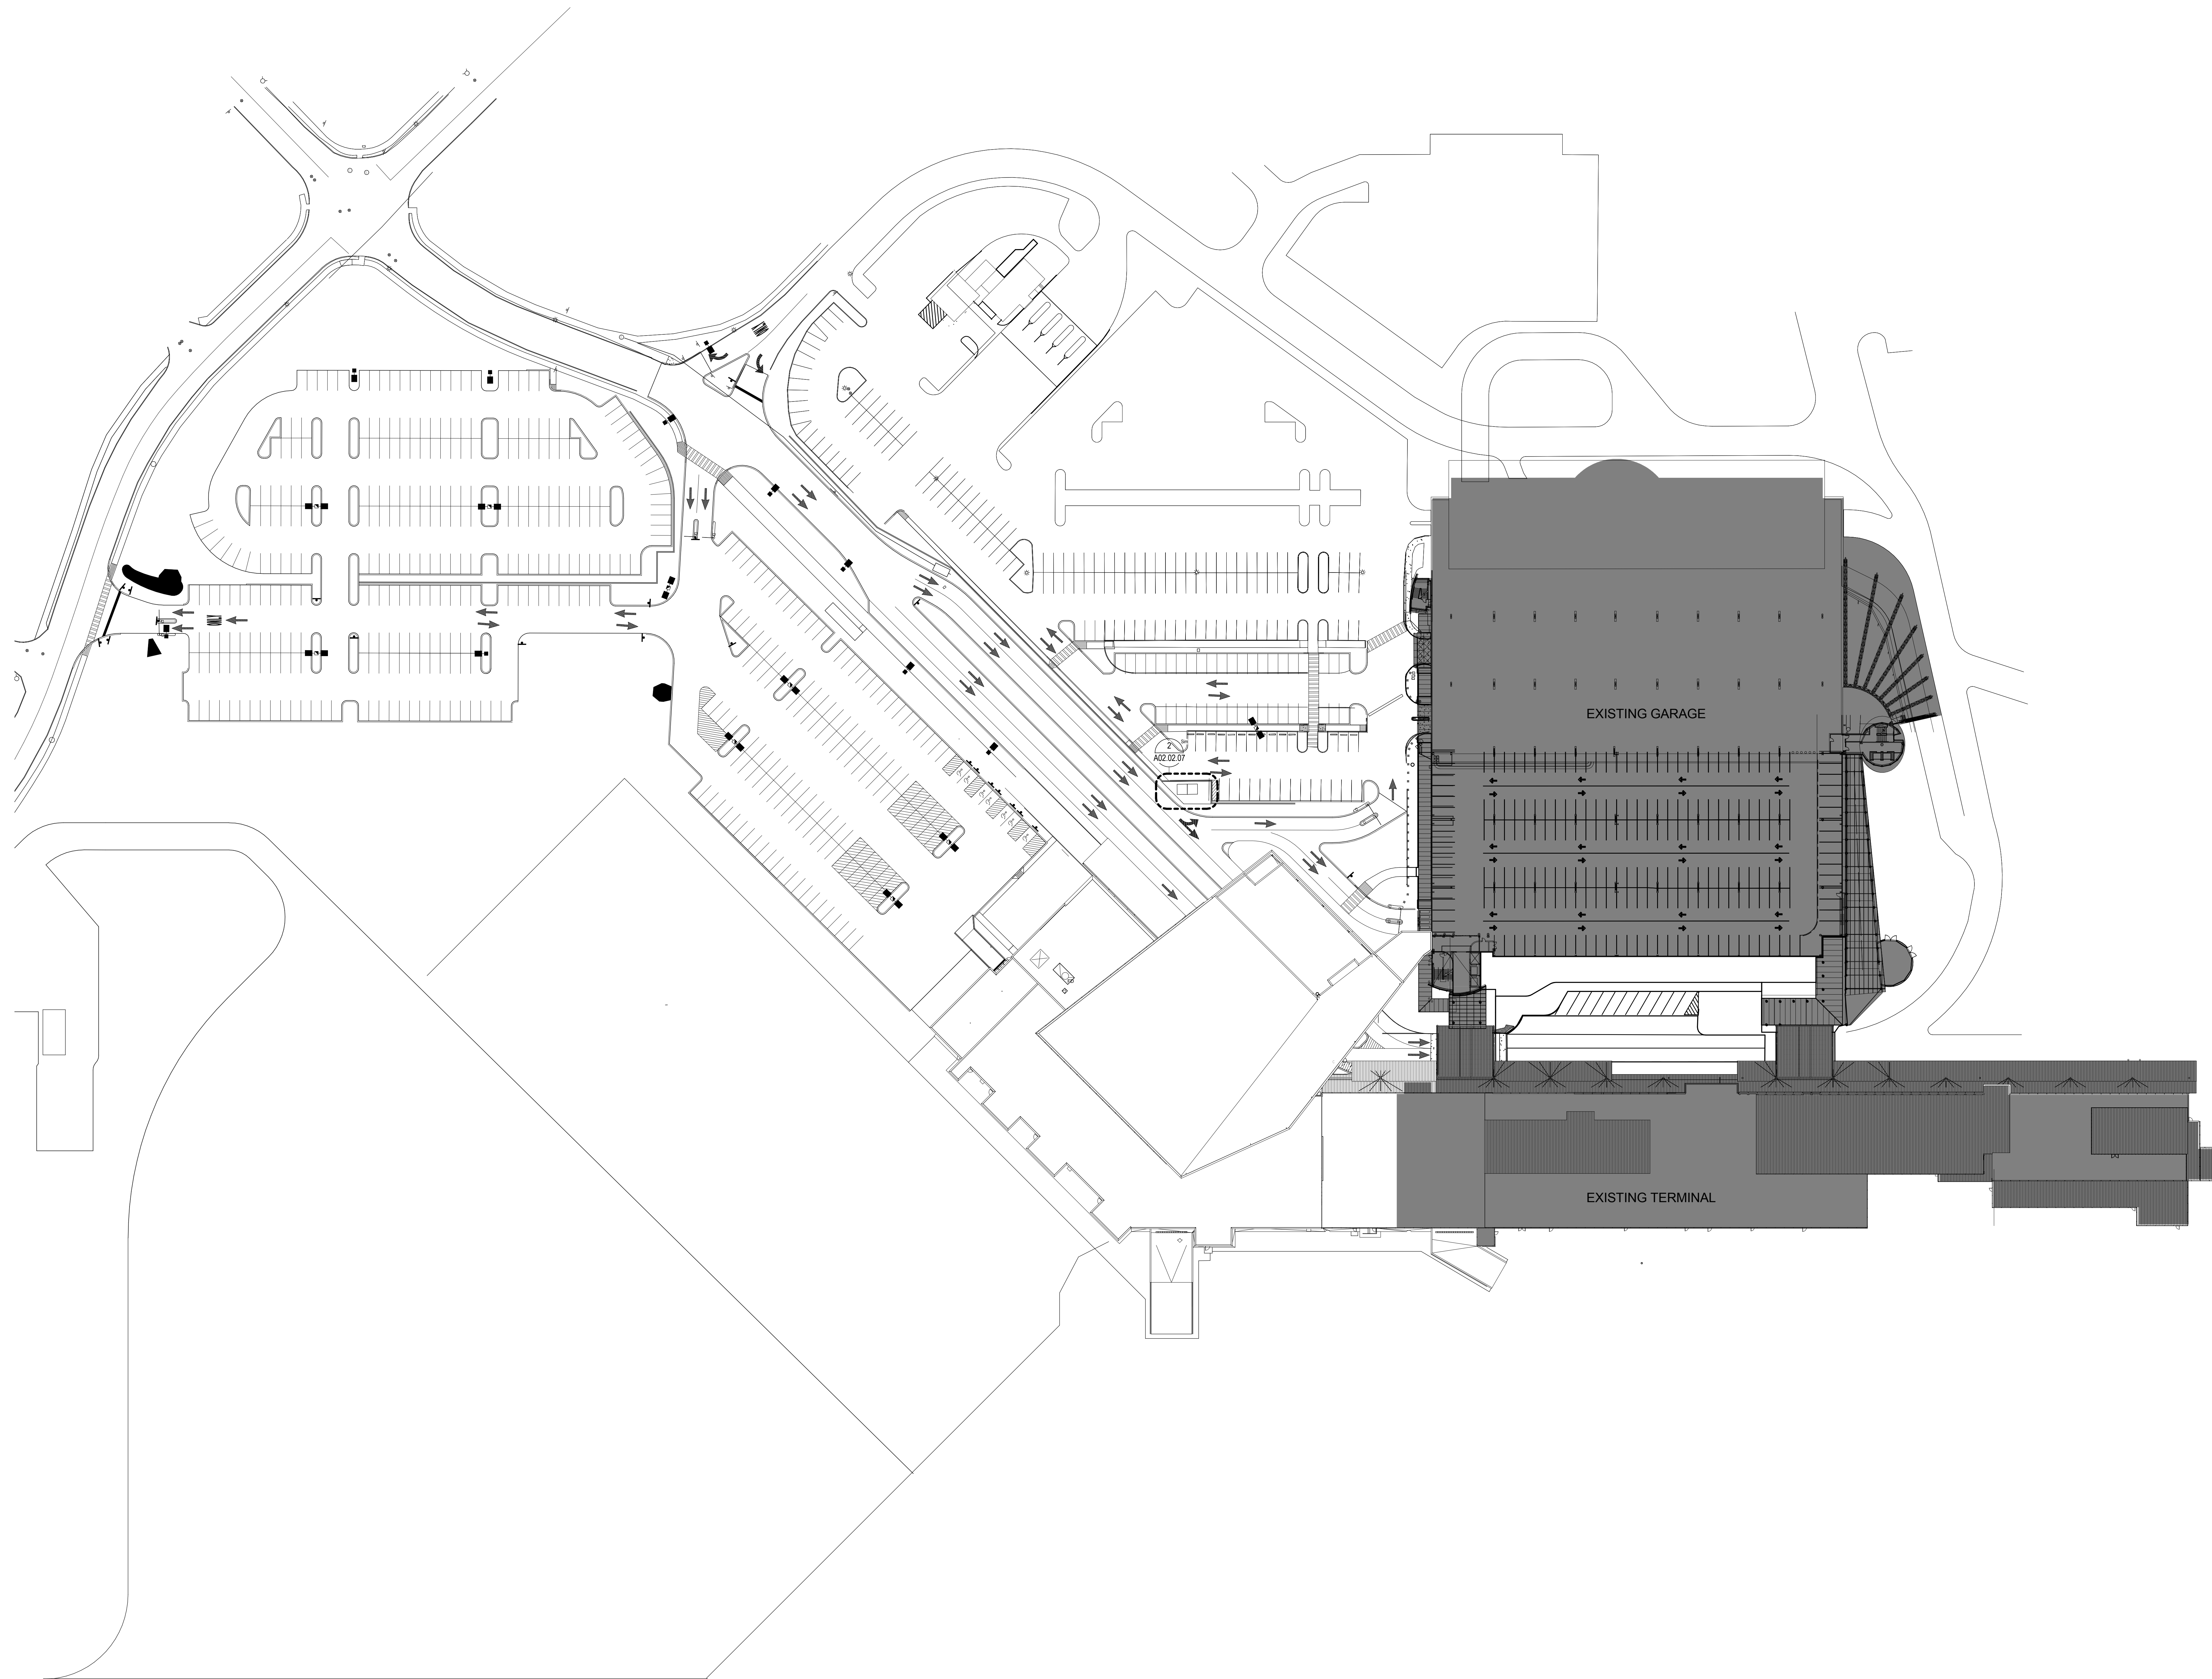

Issue	Date & Issue Description	By	Check
01	07/11/08		
02	09/22/08		
03	12/03/08		
04	01/23/09		
05	10/26/09		

Seal/Signature



Project Name
PWM Terminal Enhancement

Project Number
09-6395-000

Description
ARCHITECTURAL SITE PLAN

Scale
1" = 50'-0"



A00.50

© 2009 Gensler