


Portland International  
Jetport

1001 Westbrook Street  
Portland, Maine 04102


2020 K Street, Northwest  
Suite 200  
Washington DC 20006  
Telephone 202.721.5200  
Facsimile 202.872.8587

**Gensler**

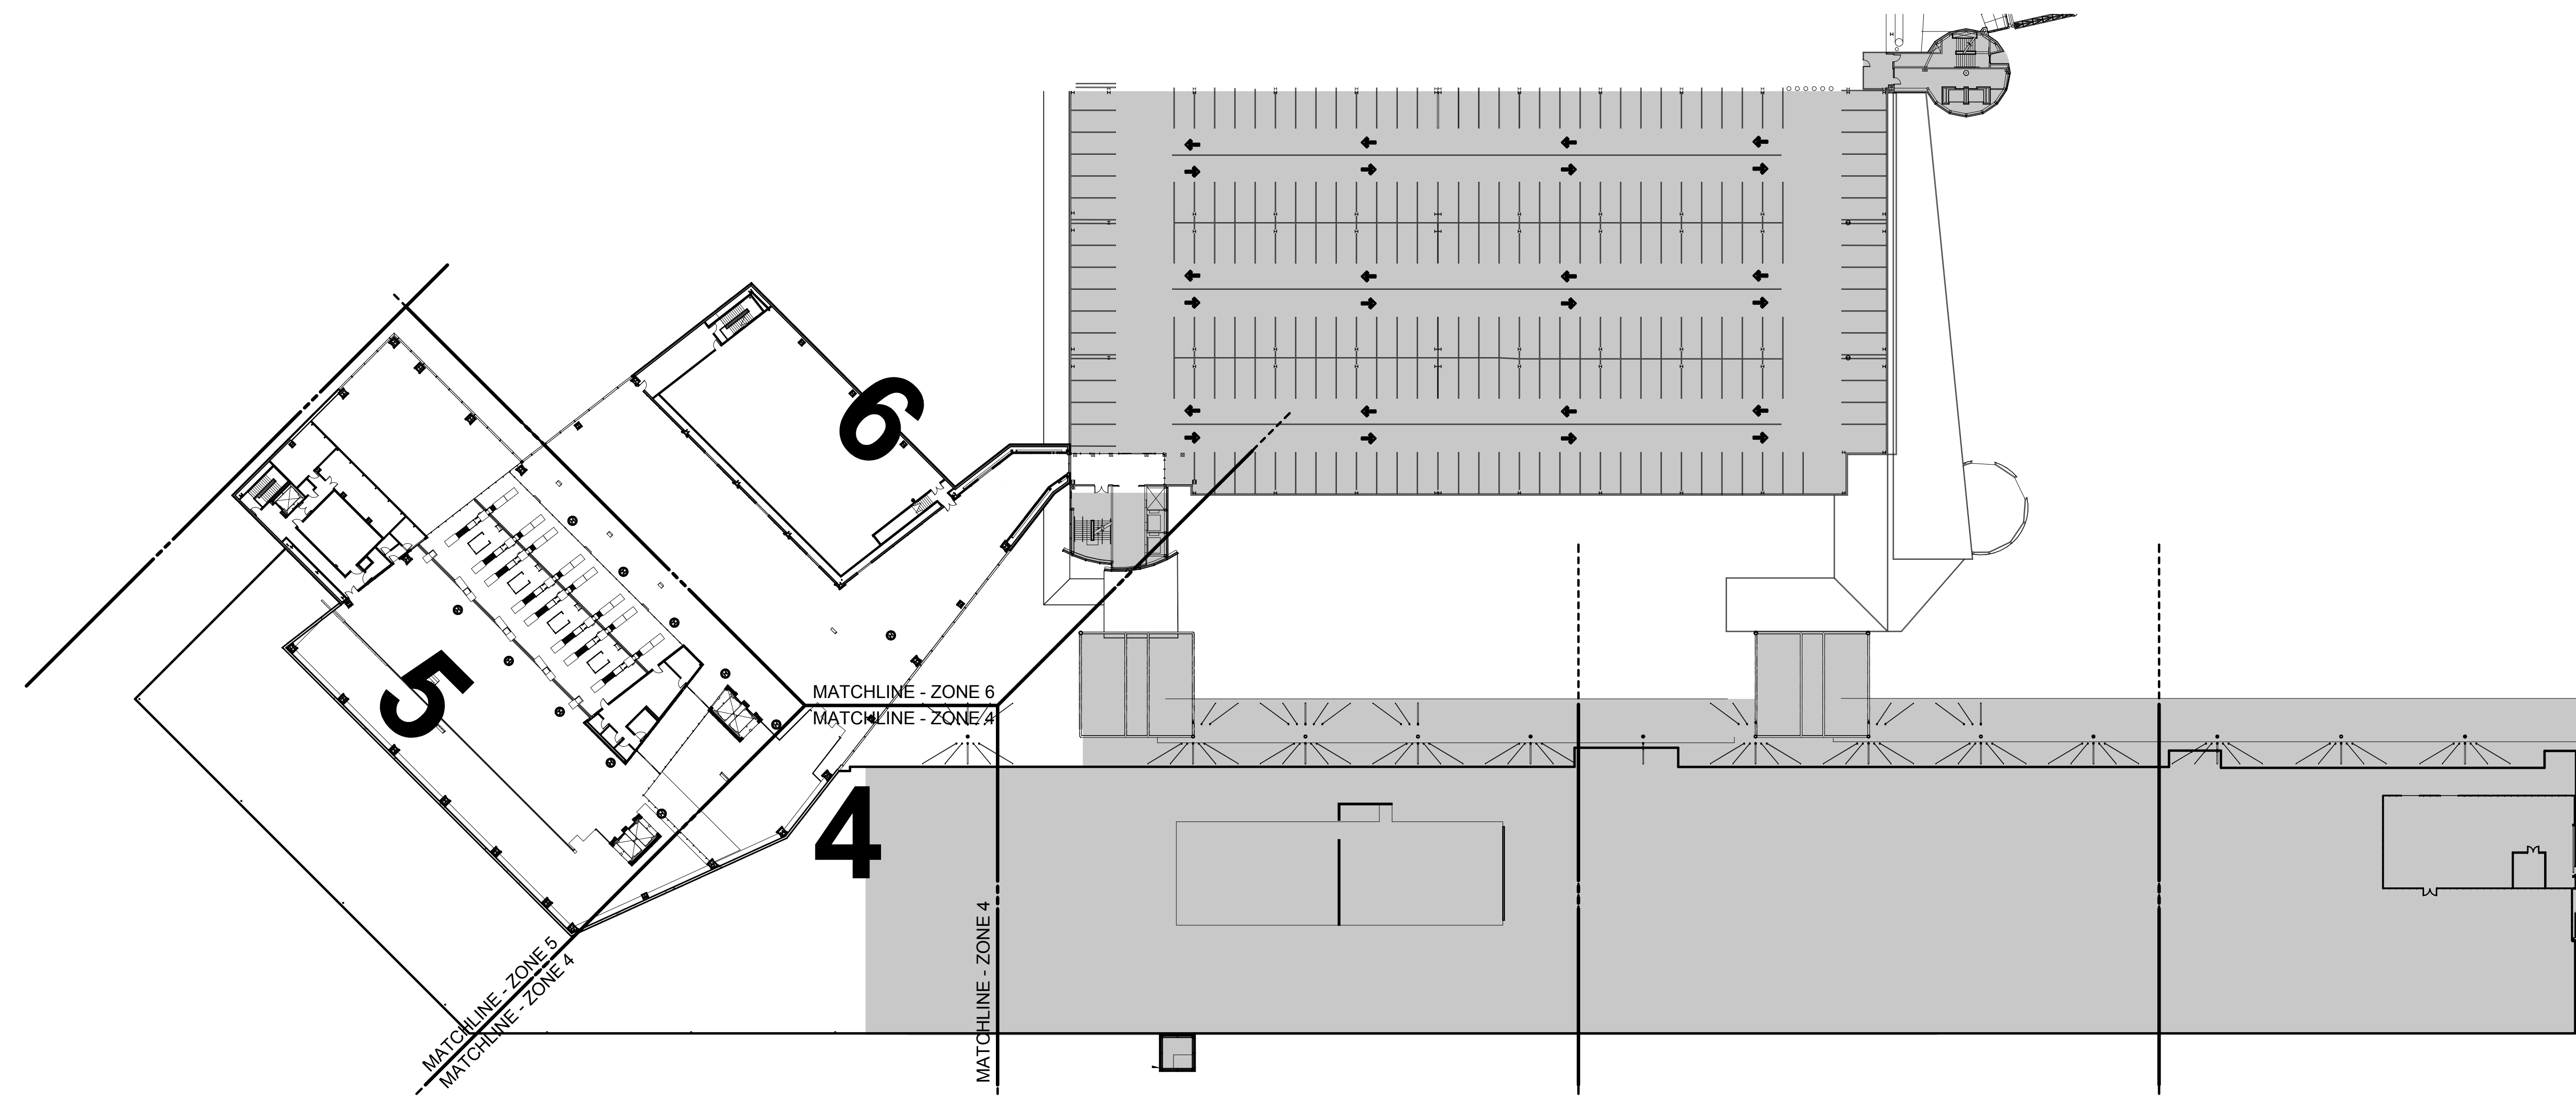

Issue	Date & Issue Description	By	Check
01	08/22/08		
02	12/03/08		
03	01/23/09		
04	10/28/09		

Seal/Signature

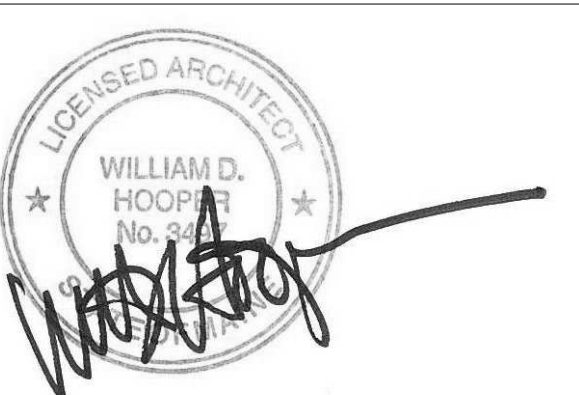


Project Name  
PWM Terminal Enhancement

Project Number  
09.6395.000

Description  
POWER & COMMUNICATION PLAN - LEVEL 4 - ZONING DIAGRAM

Scale  
1" = 40'-0"

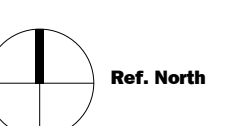

**A03.04.00**

© 2009 Gensler