


Portland International  
Jetport


1001 Westbrook Street  
Portland, Maine 04102

**Gensler**  
2020 K Street, Northwest  
Suite 200  
Washington, DC 20006  
Telephone 202.721.5200  
Facsimile 202.872.8587

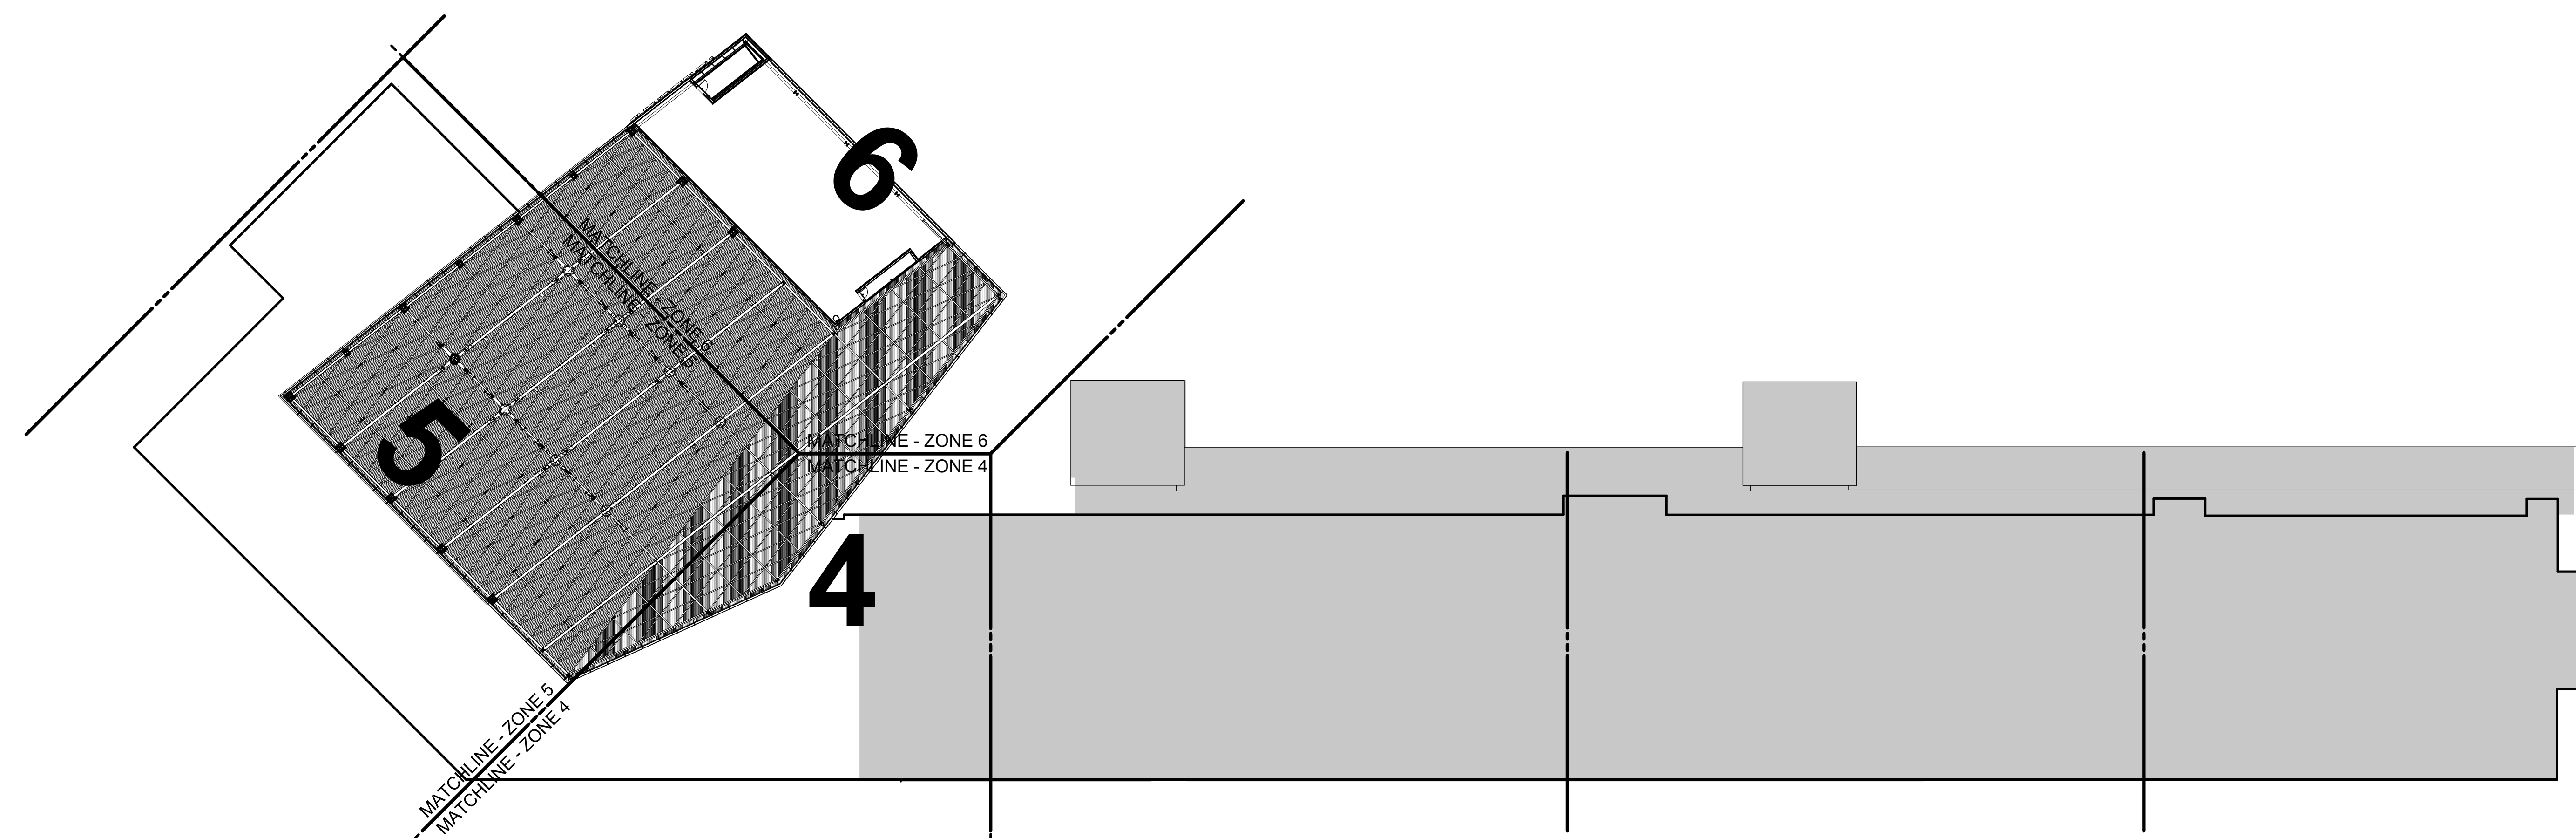

Issue	Date & Issue Description	By	Check
01	07/11/08		
02	09/22/08		
03	12/03/08		
04	01/23/09		
05	10/26/09		

Seal/Signature

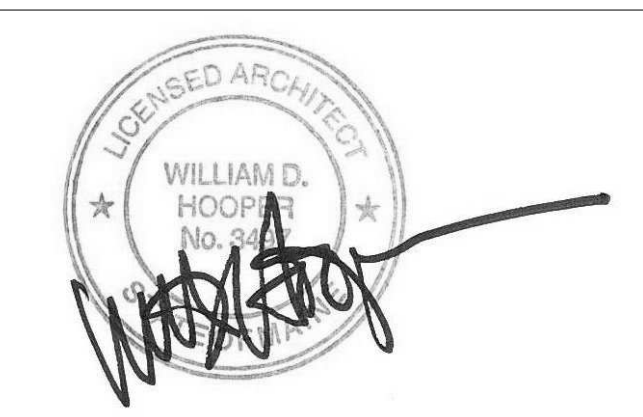


Project Name  
PWM Terminal Enhancement

Project Number  
09.6395.000

Description  
REFLECTED CEILING PLAN - LEVEL 5 - ZONING DIAGRAM

Scale  
1" = 40'-0"

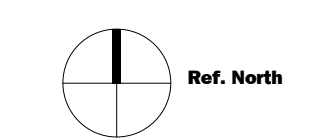

**A04.05.00**

© 2009 Gensler