

SHEET NOTES

- 01 HEAT TRACE
- 02 PROVIDE 120V CIRCUIT FOR CONTROL VOLTAGE TO TRASH COMPACTORS.

Portland International


Jetport

1001 Westbrook Street
Portland, Maine 04102

Gensler

2001 N Street, NW
Suite 200
Washington, DC 20006
Telephone 202.221.5200
Facsimile 202.972.5297


oast ASSOCIATES, INC.
3400 Cornerstone, Suite 1000, Irving, TX 75039
engineers • architects • planners • construction managers

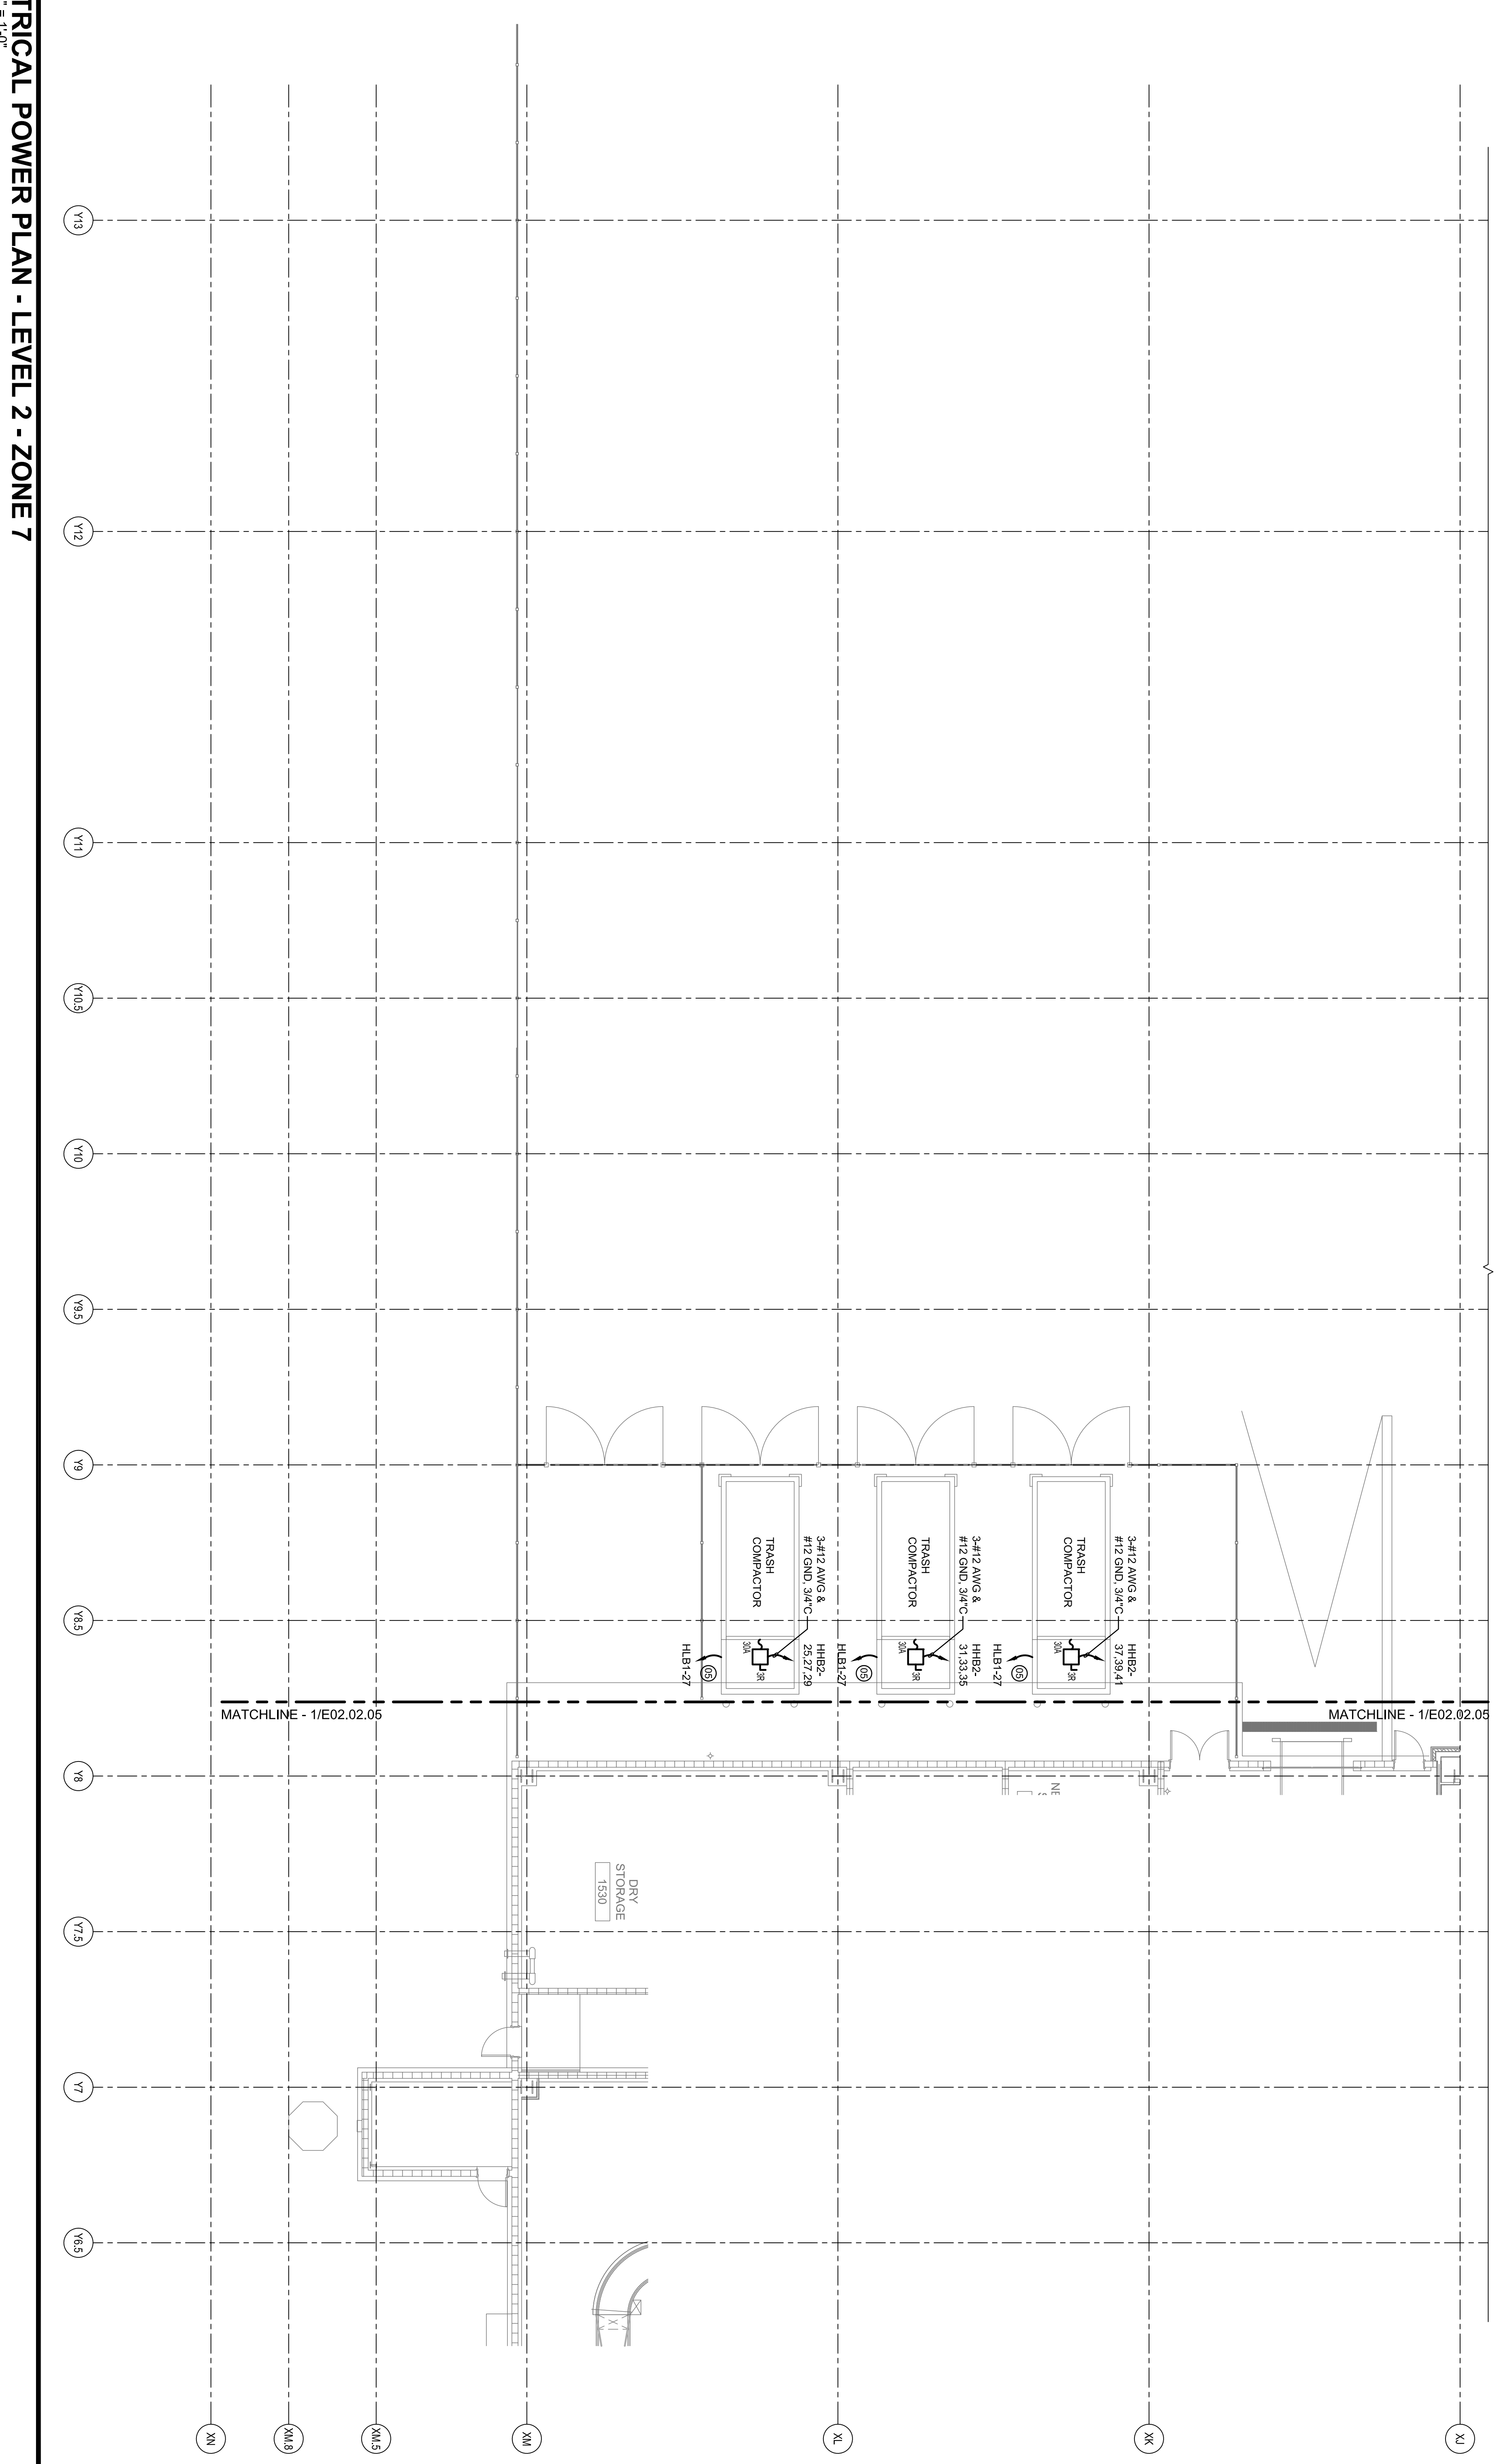

GENERAL NOTES

- A SEE SHEET E00.00 FOR LEGEND AND GENERAL NOTES.
- B CONTRACTOR SHALL REFER TO FIRE ALARM, SECURITY, IT, AND PUBLIC ADDRESS SYSTEMS DRAWINGS FOR CONDUITS & WIRING REQUIREMENTS.

KEY PLAN

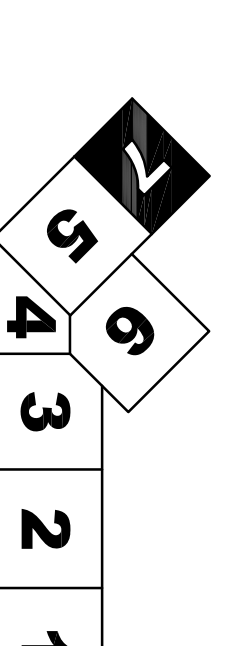

Issue	Date & Issue Description	By	Checked
01	12/20/07 50% CONSTRUCTION DOCUMENTS	LAM	BHG
02	01/23/08 50% CONSTRUCTION DOCUMENTS	LAM	BHG
03	10/26/09 ISSUED FOR PERMIT	LAM	BHG

Project Name: PML Terminal Enhancement
 Project Number: E02.02.07
 Date: 10/26/09
 Description: ELECTRICAL POWER PLAN - LEVEL 2 - ZONE 7
 Scale: 1/8" = 1'-0"
 Ref: North