

SHEET NOTES

**Portland International
Jetport**
1001 Westbrook Street
Portland, Maine 04102

Gensler
2020 K Street, NW
Suite 200
Washington, DC 20006
Telephone 202.221.5200
Facsimile 202.221.5207

oast ASSOCIATES, INC.
3400 Greenleaf Road, Suite 100, Portland, ME 04106
Engineers - Architects - Surveyors - Construction Managers

GENERAL NOTES

A SEE SHEET E00.00 FOR LEGEND AND GENERAL NOTES.

Issue	Date & Issue Description	By	Checked
01	01/23/09 CONSTRUCTION DOCUMENTS	LAM	BHG
02	10/26/09 ISSUED FOR PERMIT	LAM	BHG

Subcontractor


Project Name
PWI Terminal Enhancement

Legend Number
E02.RP.05
Callout Number
T-0330701-SHEET-E02.RP.05.dwg
Description
ELECTRICAL POWER PLAN - ROOF - ZONE 5

Scale
1/8" = 1'-0"

E02.RP.05

©2009 Gensler

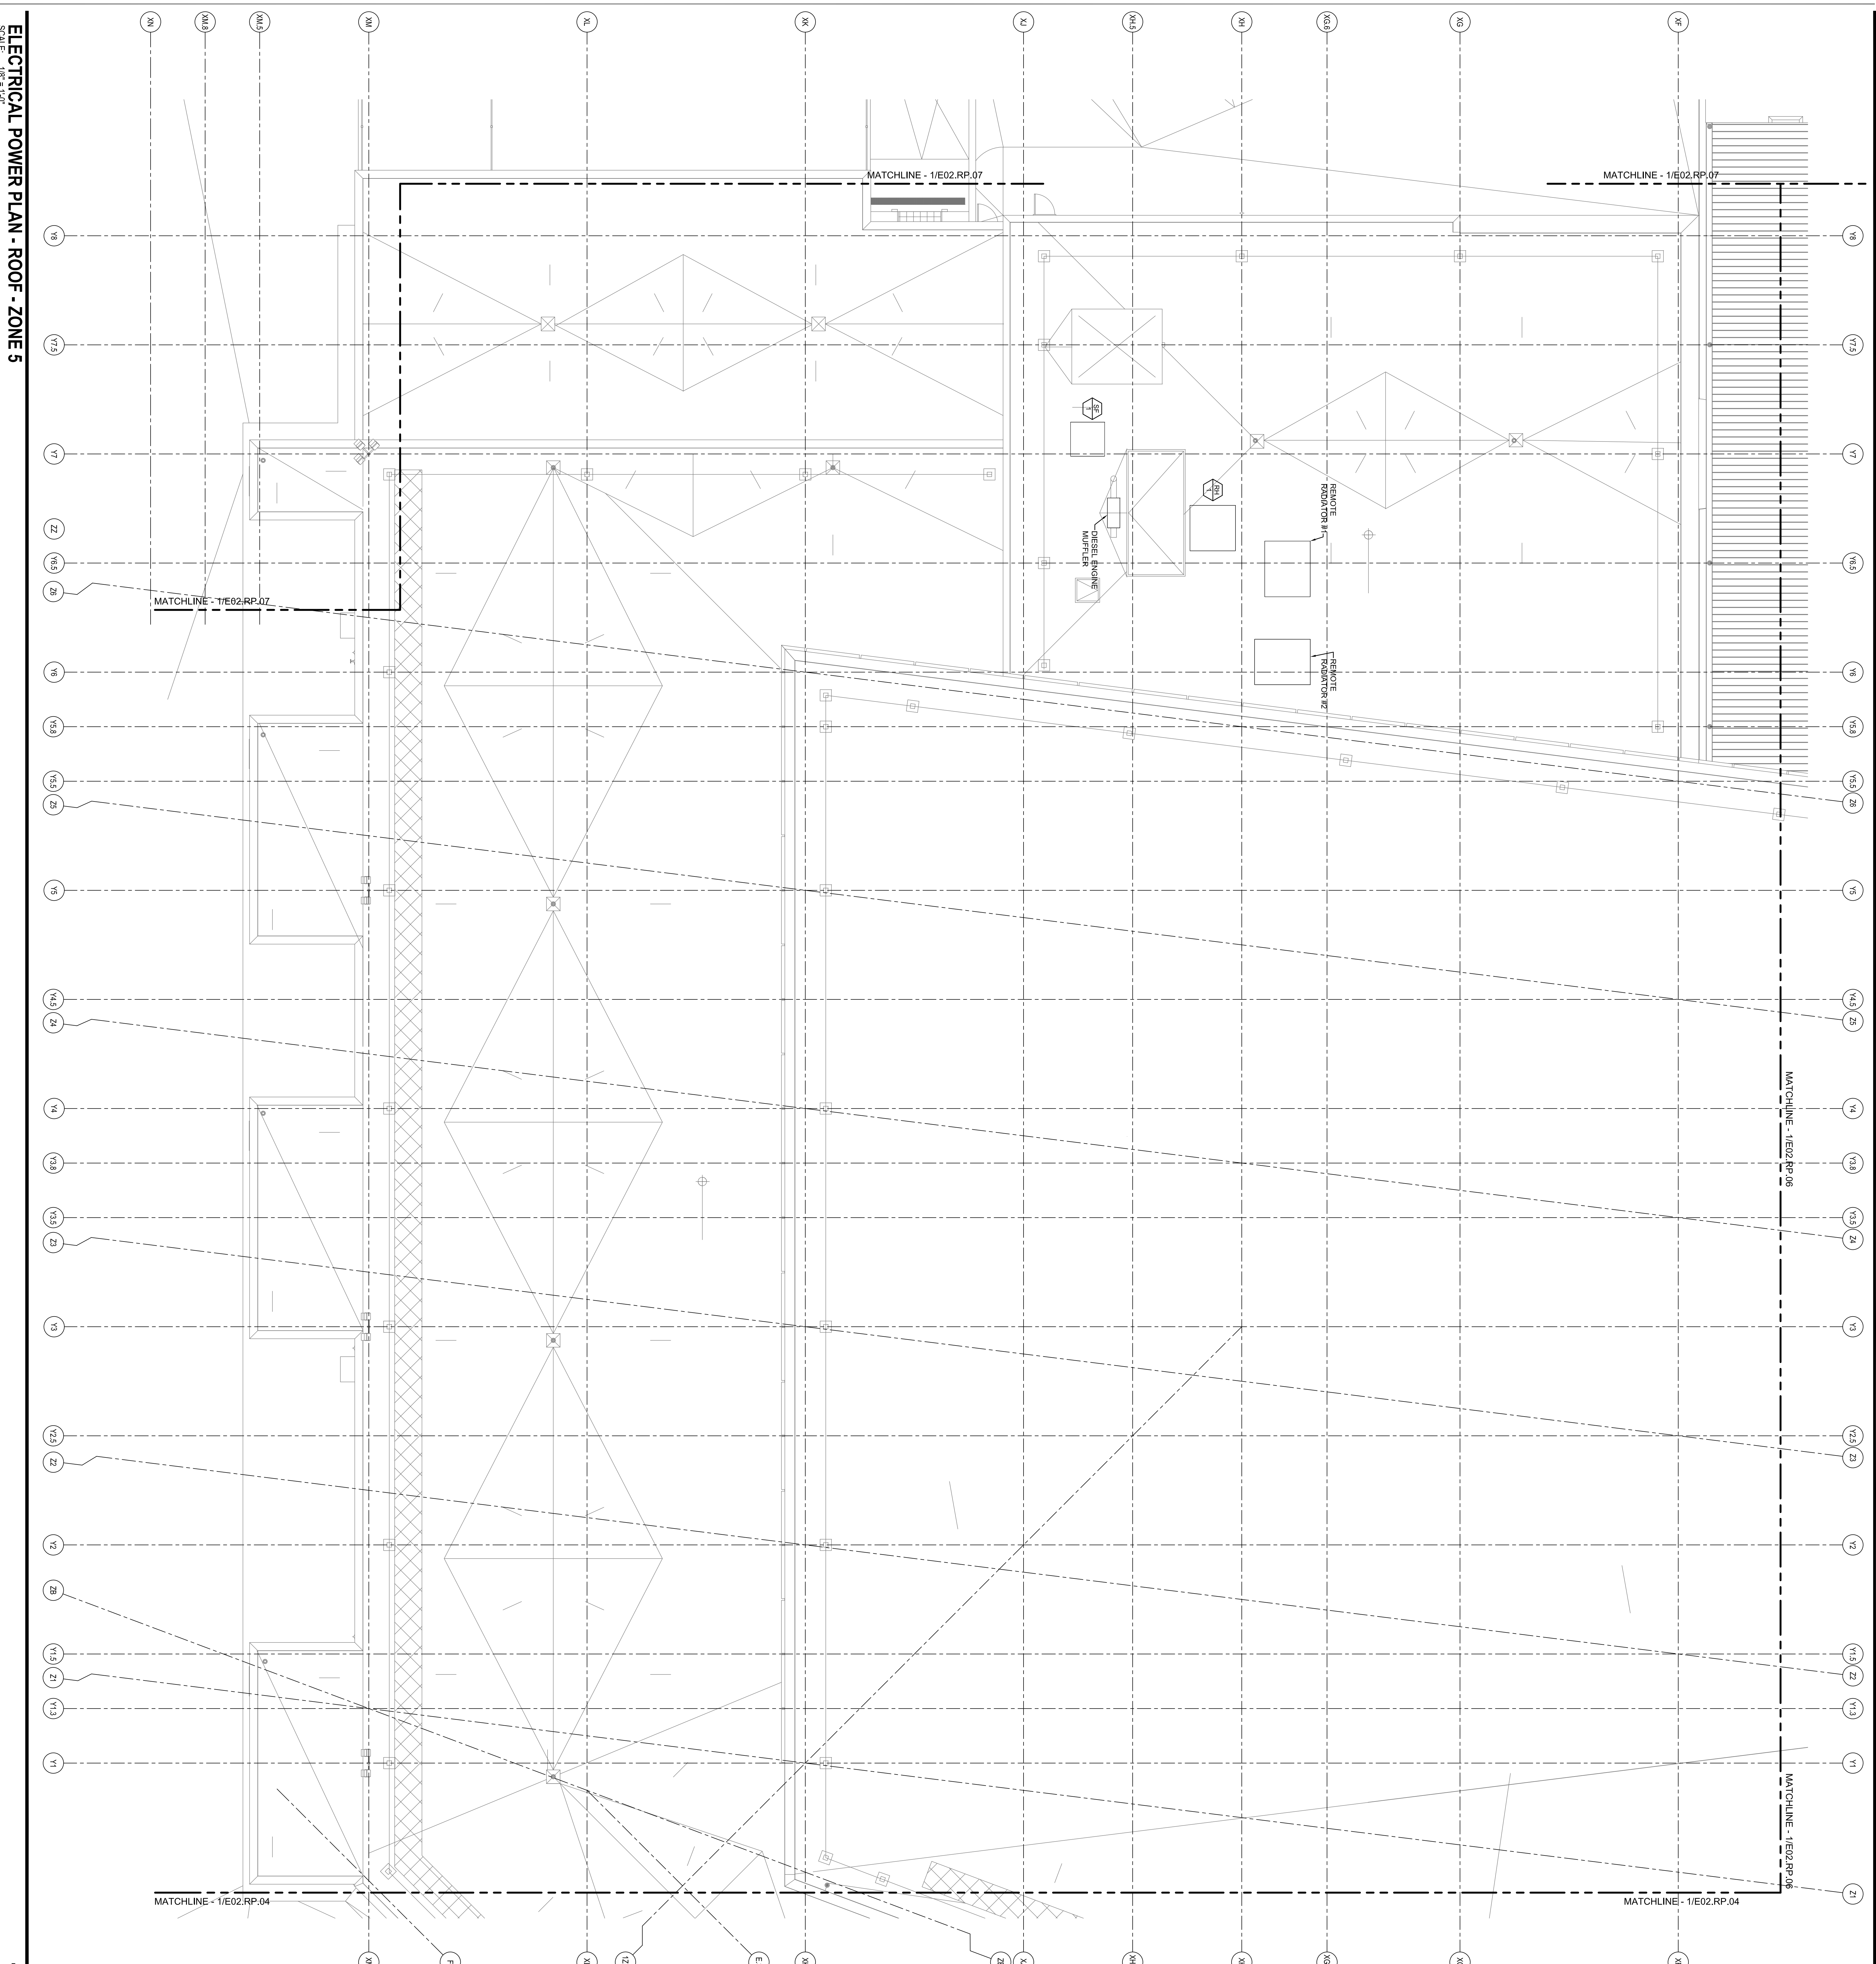

ELECTRICAL POWER PLAN - ROOF - ZONE 5

SCALE: 1/8" = 1'-0"