


SHEET NOTES

01 PROVIDE CONJUGENICE LIGHT FIXTURE WITH SWITCH IN THE ESCALATOR LOWER LEVEL MACHINE SPACE. COORDINATE LOCATION AND INSTALLATION WITH THE ESCALATOR CONTRACTOR.

Portland International Jetport
1001 Westbrook Street
Portland, Maine 04102

Gensler
2024 N Street, NW
Suite 200
Washington, DC 20006
Telephone 202.221.5200
Facsimile 202.272.5297

oast ASSOCIATES, INC.
3400 Greenway, Suite 1000, Portland, ME 04103
Tel: 207.761.1100 Fax: 207.774.1100
engineers • architects • interior architects • construction managers

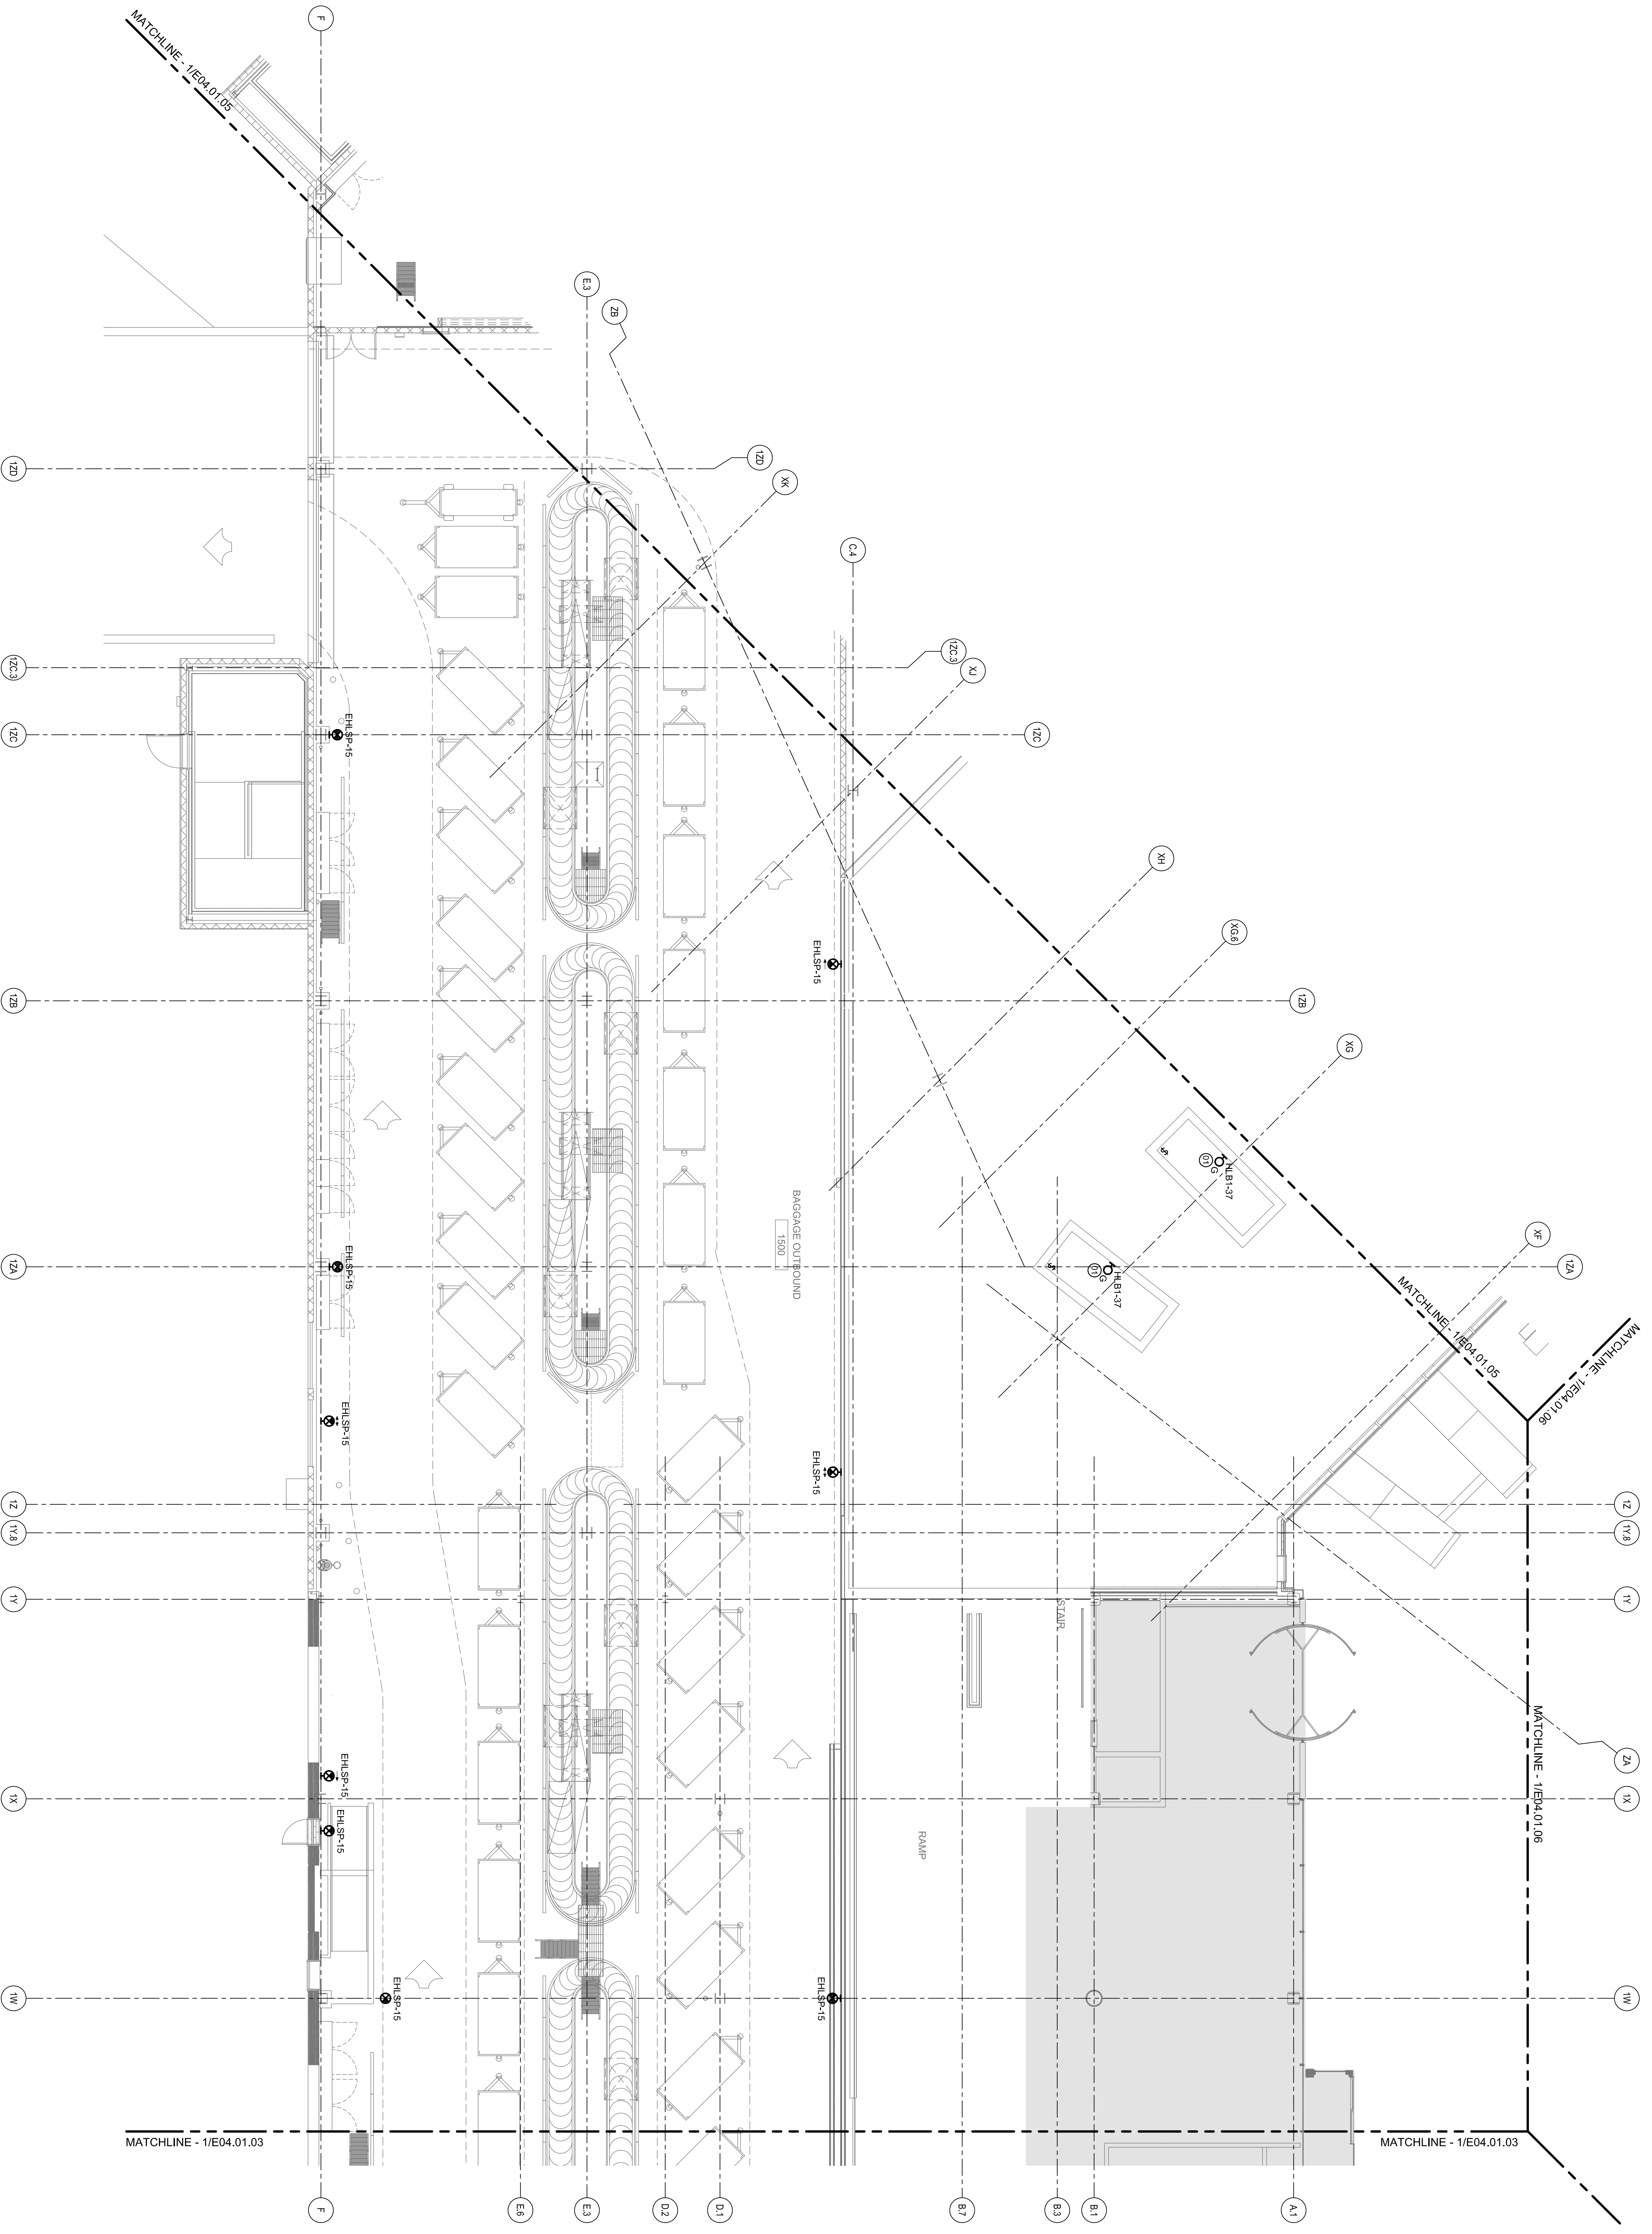


GENERAL NOTES

A SEE SHEET E00.00 FOR LEGEND AND GENERAL NOTES.

Revision	Date & Issue Description	By	Check
01	12/20/00	LAM	BHG
02	01/23/01	LAM	BHG
03	10/26/09	LAM	BHG

ISSUED FOR PERMIT

KEY PLAN

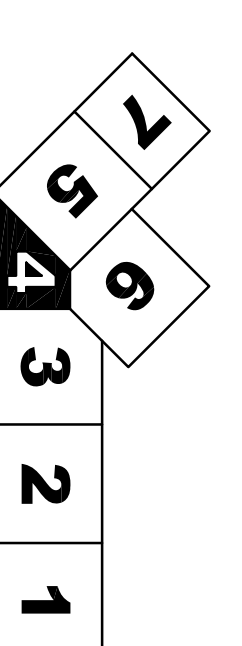

ELECTRICAL LIGHTING PLAN - LEVEL 1 - ZONE 4

SCALE: 1/8" = 1'-0"

E04.01.04
1/8" = 1'-0"
Ref. North

©2009 Gensler